


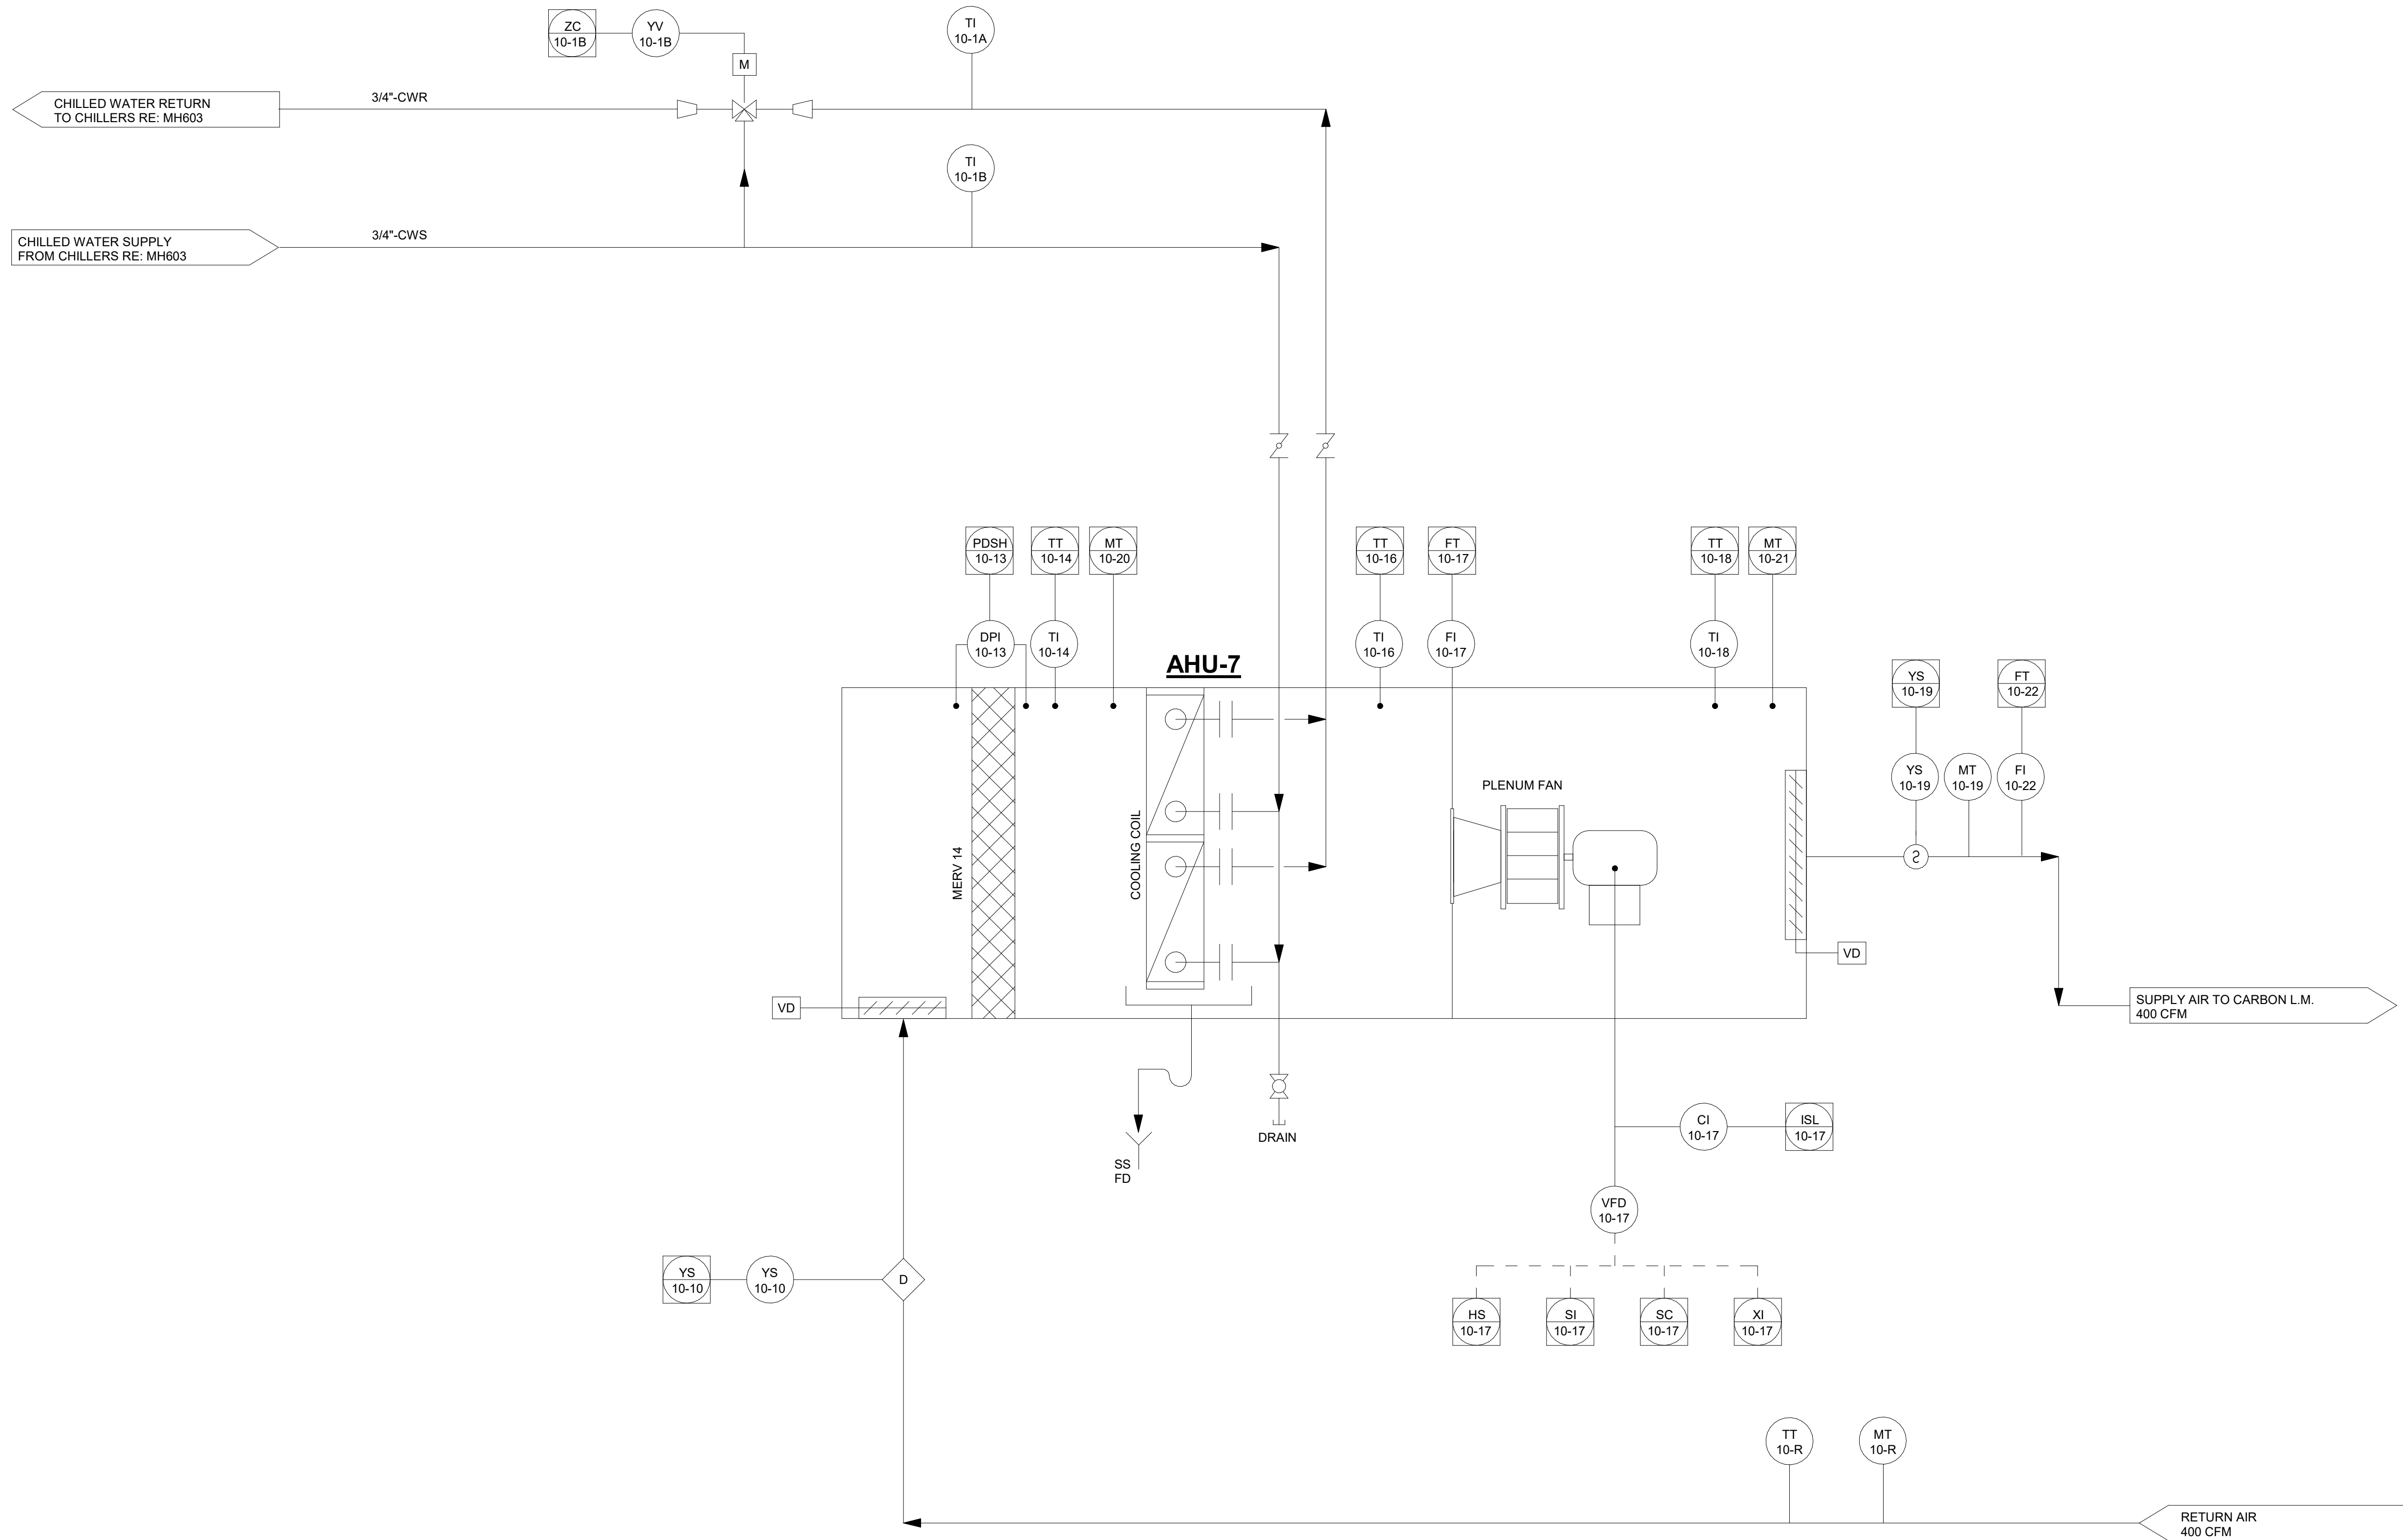

A1 AHU-7 P&ID
SCALE: NTS


GENERAL SHEET NOTES

PROGRAMMING AND ALL
CONTROL DEVICES PROVIDED
BY L&H AIRCO AND INSTALLED
AT EQUIPMENT FACTORY.

SHEET KEYNOTES

LEGEND

GRAPHIC SCALE(S)

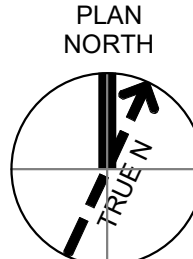

DESIGN	DATE	DR	CHK	ASM	APVD	BY	APVD	SUG
0	09/18/2024					JWG		
100% ISSUED FOR CONSTRUCTION - EXPANSION								

GMLRS
Camden OSD
Calhoun County, Arkansas
Aerojet Rocketdyne

MECHANICAL
AHU-7 P&ID

SHEET NO
MH617

SCALE	12" = 1'-0"
DATE	09/18/2024
PROJ	D3754502
DWG	CMDN_OSD_GMLRS_MH617

REUSE OF DOCUMENTS: THIS DOCUMENT AND THE DESIGNS AND DESIGN INFORMATION CONTAINED HEREIN ARE THE PROPERTY OF PROFESSIONAL ENGINEER STEVE J. GOODELL. NO PART OF THIS DOCUMENT OR ITS CONTENTS MAY BE REPRODUCED OR TRANSMITTED IN ANY FORM OR BY ANY MEANS, ELECTRONIC OR MECHANICAL, WITHOUT THE WRITTEN PERMISSION OF THE ENGINEER.

© Jacobs Solutions 2023. ALL RIGHTS RESERVED.