


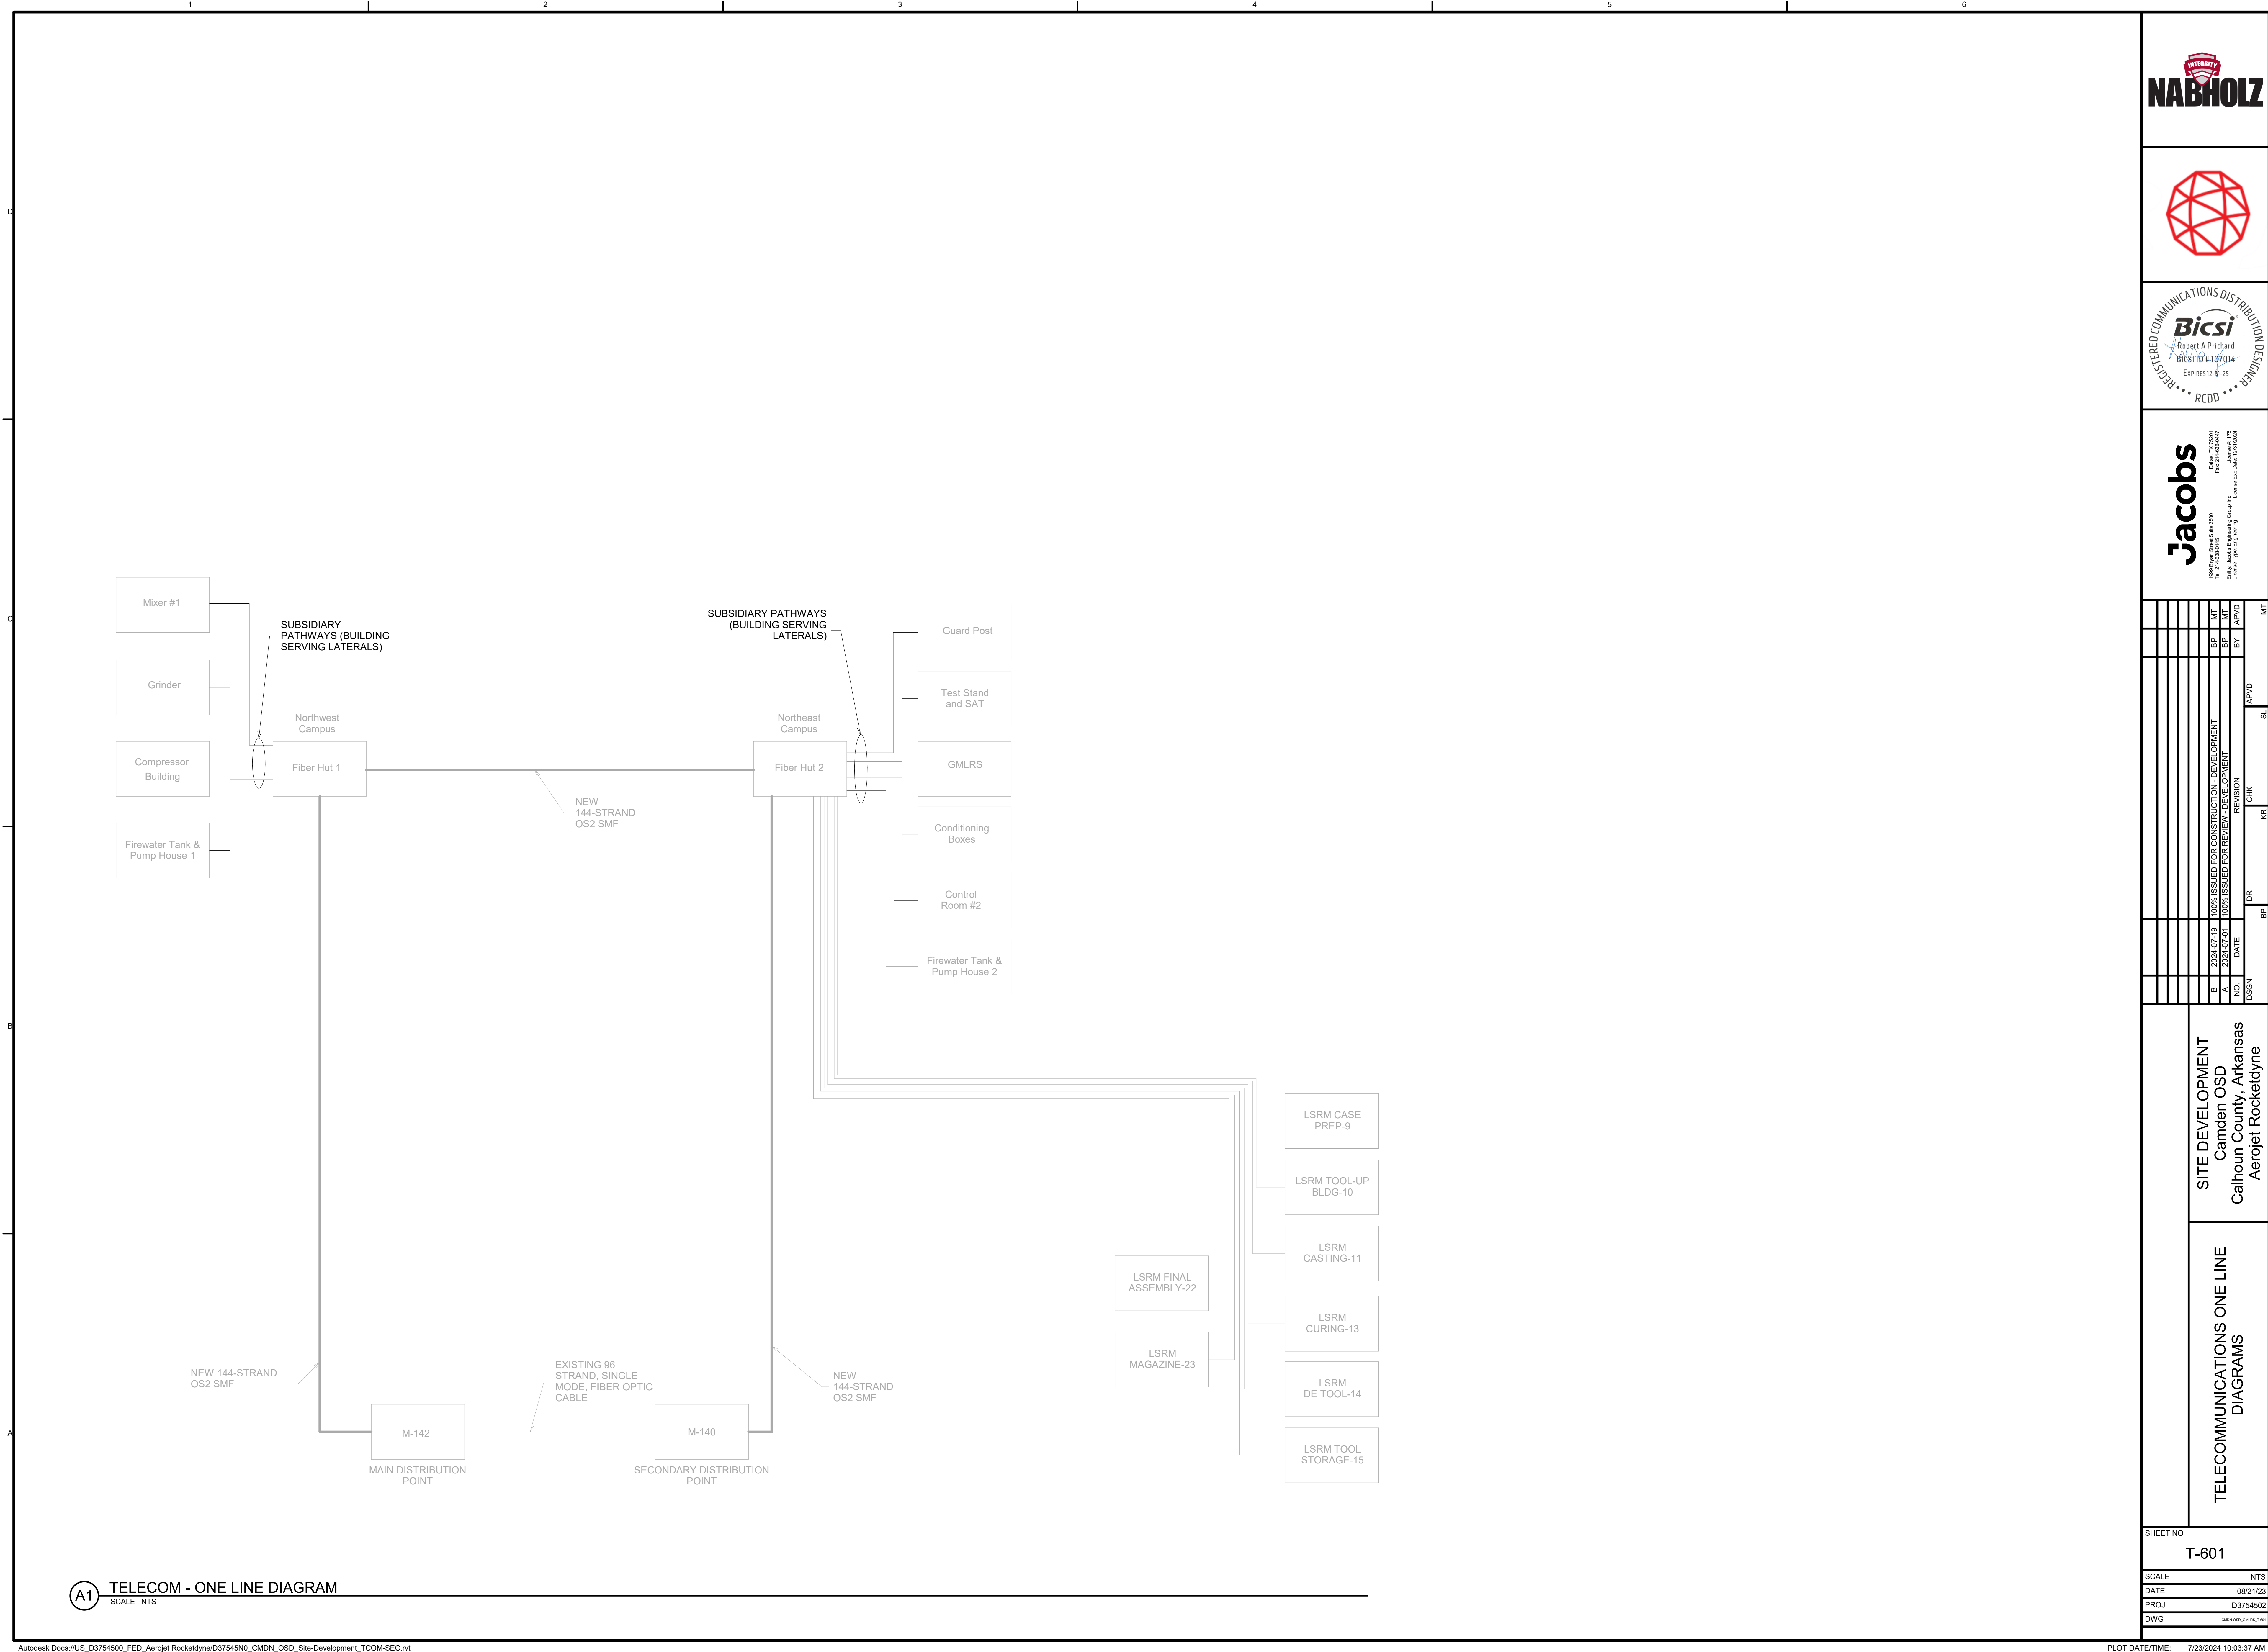

A1 TELECOM - ONE LINE DIAGRAM

SCALE NTS



Jacobs

1995 Bayview Drive, Suite 3000
Dallas, TX 75224
Phone: 214.746.2000
Fax: 214.746.2001
Email: Jacobs Engineering Group Inc.
License Type: Engineering License No. 123123456
License Exp. Date: 12/31/2024

NO.	DATE	DR	CHK	REVISION	BY	MT
B	2024/07/19			100% ISSUED FOR CONSTRUCTION - DEVELOPMENT	BP	MT
A	2024/07/20			100% ISSUED FOR REVIEW - DEVELOPMENT	BP	MT
DESIGN						

SITE DEVELOPMENT
Camden OSD
Calhoun County, Arkansas
Aerojet Rocketdyne

TELECOMMUNICATIONS ONE LINE
DIAGRAMS

SHEET NO	T-601
SCALE	NTS
DATE	08/21/23
PROJ	D3754502
DWG	COMM-ONE LINE-1-001