


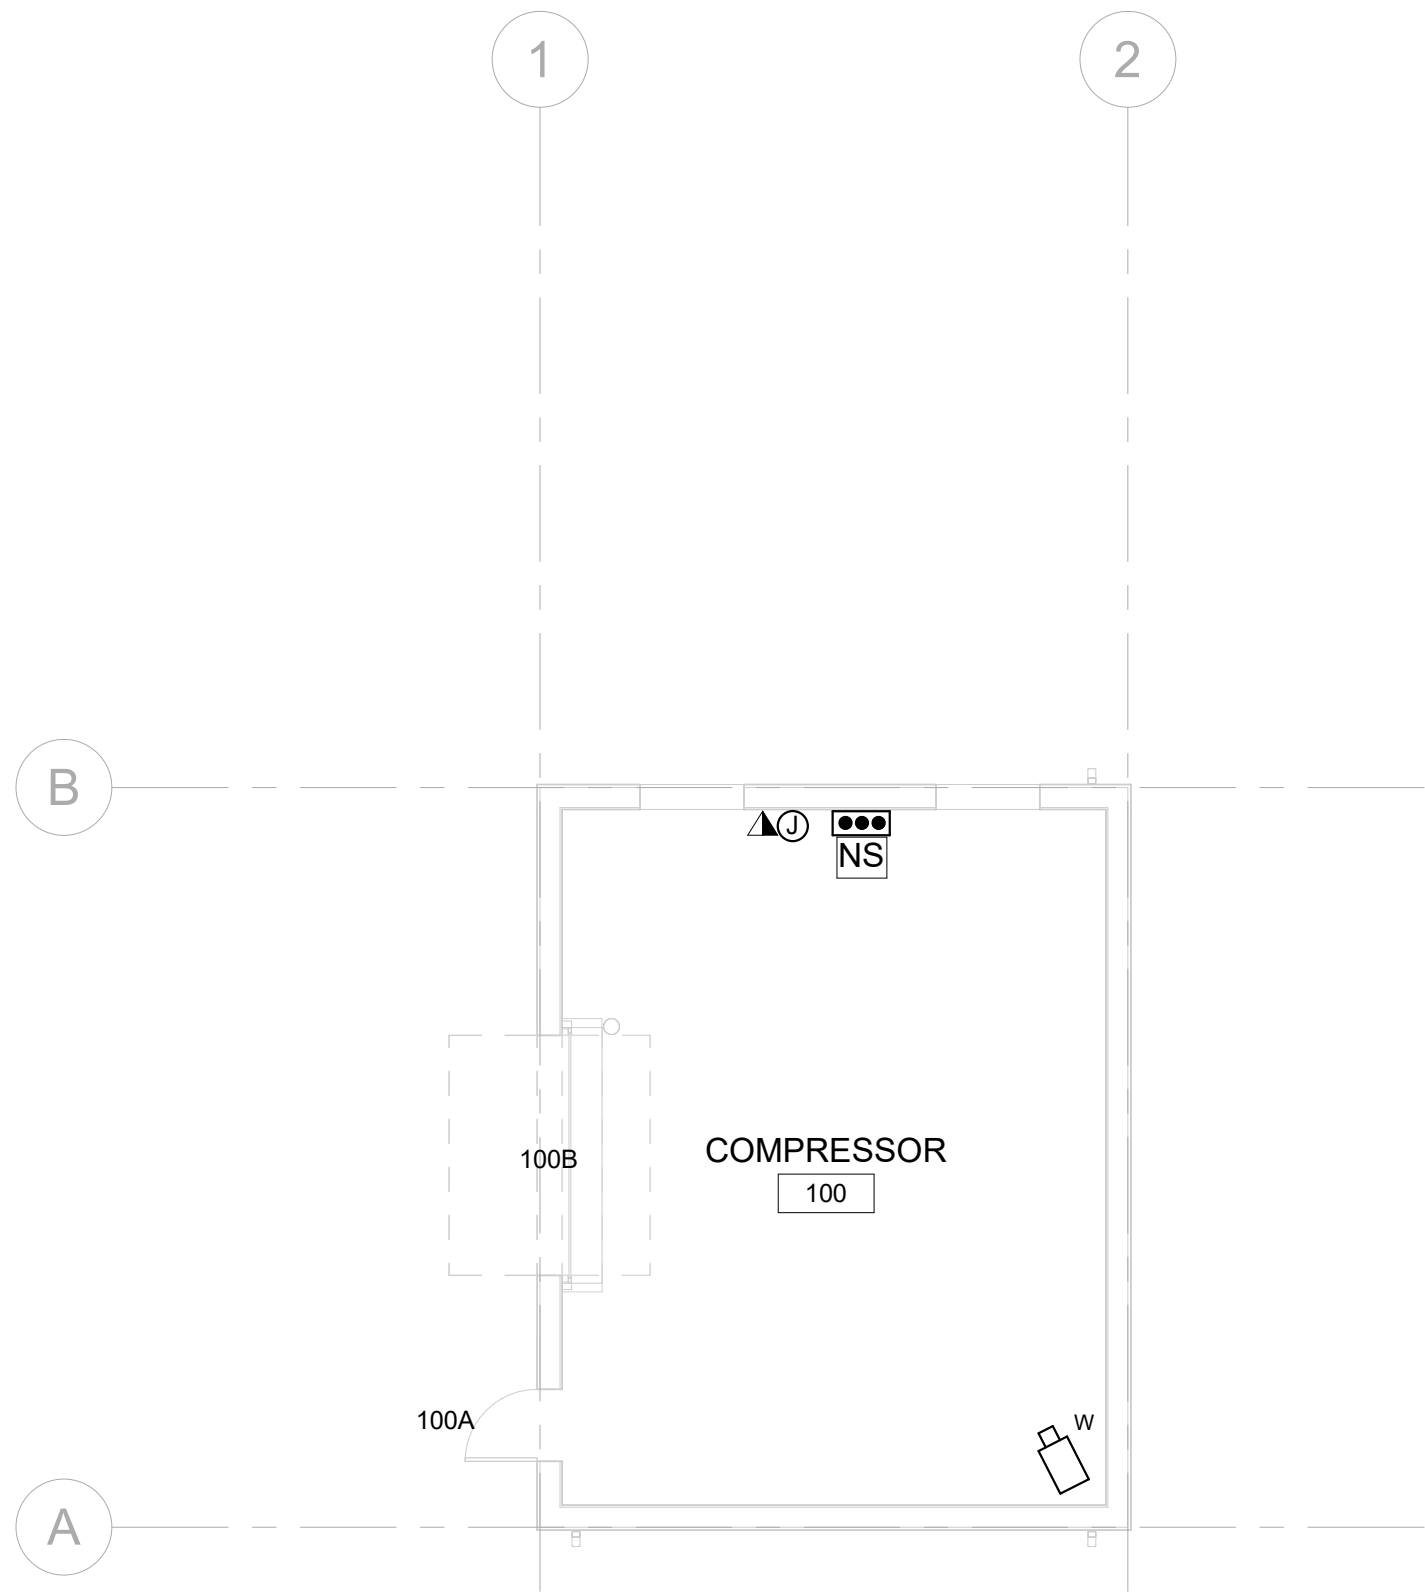

A1 GROUND FLOOR ELECTRONIC SECURITY SYSTEM PLAN
SCALE 1/8" = 1'-0"

SHEET NO		TY-101	
SCALE		1/8" = 1'-0"	
DATE		09/18/2024	
PROJ		D3754502	
DWG		CMEN-OSD_Compressor-Building_TY-101	
JACOBS		SECURITY SYSTEM DEVICE LAYOUT FLOOR PLAN	
Compressor-Building Camden OSD Calhoun County, Arkansas Aerojet Rocketdyne		B	
09/18/2024		BOARD CERTIFIED MICHAEL GROSENFELD INTERNATIONAL 10.1.19 SECURITY PROFESSIONAL	
JACOBS		1999 Bryan Street Suite 3000 Dallas, TX 75201 Tel: 214-638-0145 Fax: 214-638-0447 Entity: Jacobs Engineering Group Inc. License Type: Engineering Exp. Date: 12/31/2024	
DSGN		LTV	
NO.		DATE	
0		09/18/2024	
100% ISSUED FOR CONSTRUCTION - EXPANSION		REVISION	
BY		CHK	
BP		ND	
MT		APVD	
APVD		MAH	
TM		TM	

REUSE OF DOCUMENTS FOR OTHER PROJECTS WITHOUT THE WRITTEN AUTHORIZATION OF JACOBS IS NOT TO BE USED, IN WHOLE OR IN PART, FOR ANY OTHER PROJECT WITHOUT THE WRITTEN AUTHORIZATION OF JACOBS.

© Jacobs Solutions 2022. ALL RIGHTS RESERVED.