



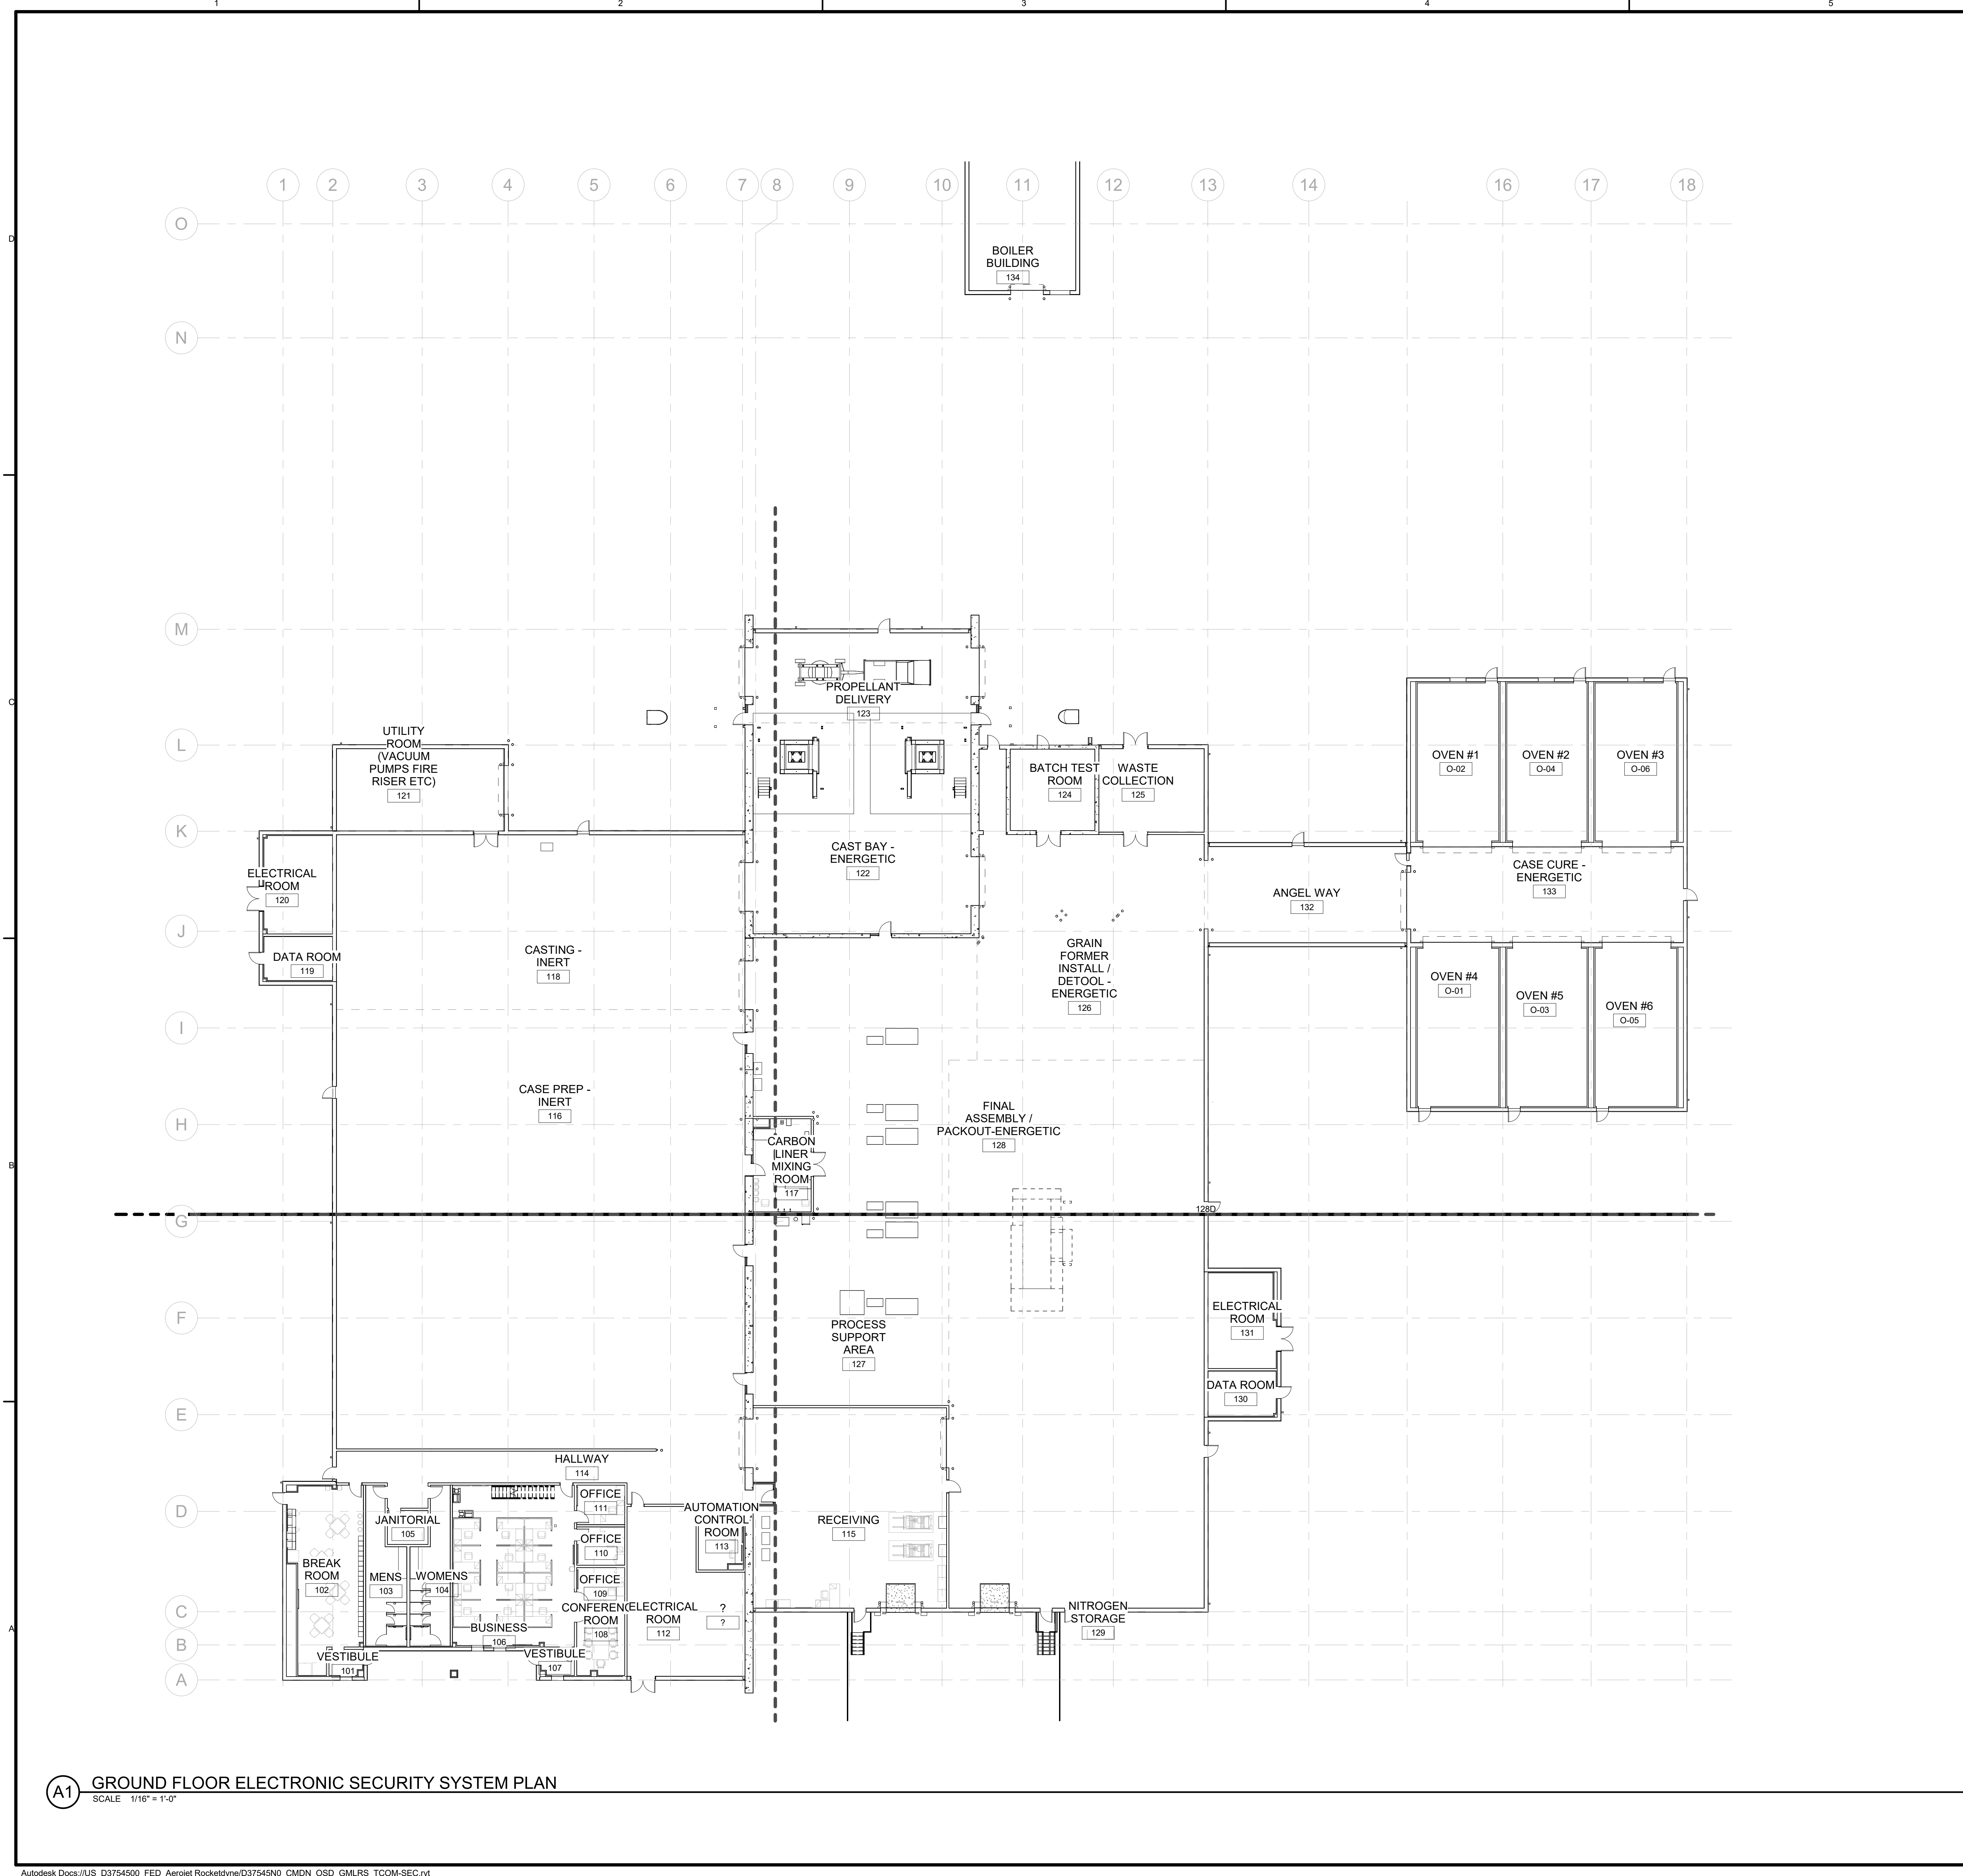


A1 GROUND FLOOR ELECTRONIC SECURITY SYSTEM PLAN
SCALE 1/16" = 1'-0"

KEY PLAN

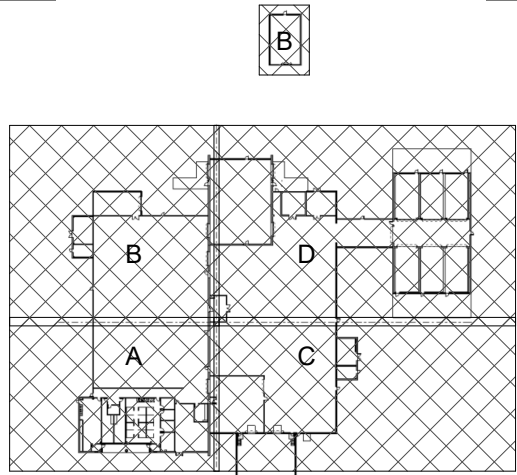

GRAPHIC SCALE(S)



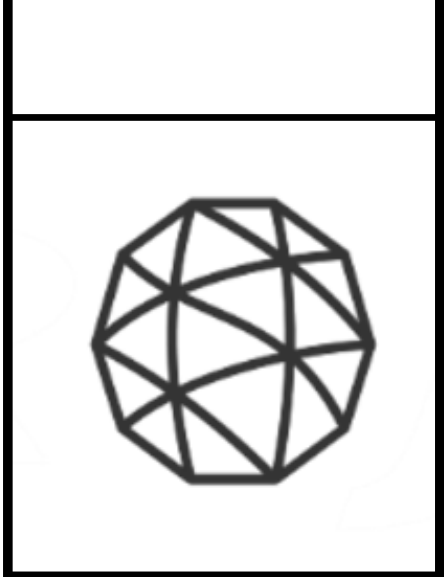

09/18/2024
ASIS
INTERNATIONAL
10.1.19
SECURITY PROFESSIONAL



Jacobs
1998 Bryan Street Suite 300
Houston, TX 77002
Phone: 713.465.1000
Fax: 713.465.1001
Email: info@jacobs.com
License Type: Engineering License Exp. Date: 12/31/2024

NO.	DATE	REVISION	BY	CHK	DR	LTV	MAIL	APVD	MT	TM
0	09/18/2024	100% ISSUED FOR CONSTRUCTION - EXPANSION	BP	MT						

GMLRS
Camden OSD
Calhoun County, Arkansas
Aerojet Rocketdyne

ELECTRONIC SECURITY SYSTEM
FLOOR PLAN

SHEET NO.
TY101

SCALE 1/16" = 1'-0"

DATE 09/18/2024

PROJ D3754502

DWG 0000-000, 000, 000, 000, 000, 000

9/18/2024 2:40:34 PM

Autodesk Docs://US_D3754500_FED_Aerojet Rocketdyne/D3754500_CMDN_OSD_GMLRS_TCOM-SEC.rvt

© Jacobs Solutions 2023. ALL RIGHTS RESERVED.
THIS DOCUMENT AND THE IDEAS AND DESIGNS INCORPORATED HEREIN, AS AN INSTRUMENT OF PROFESSIONAL SERVICE, IS THE PROPERTY OF JACOBS AND IS NOT TO BE USED, IN WHOLE OR IN PART, FOR ANY OTHER PROJECT WITHOUT THE WRITTEN AUTHORIZATION OF JACOBS.