


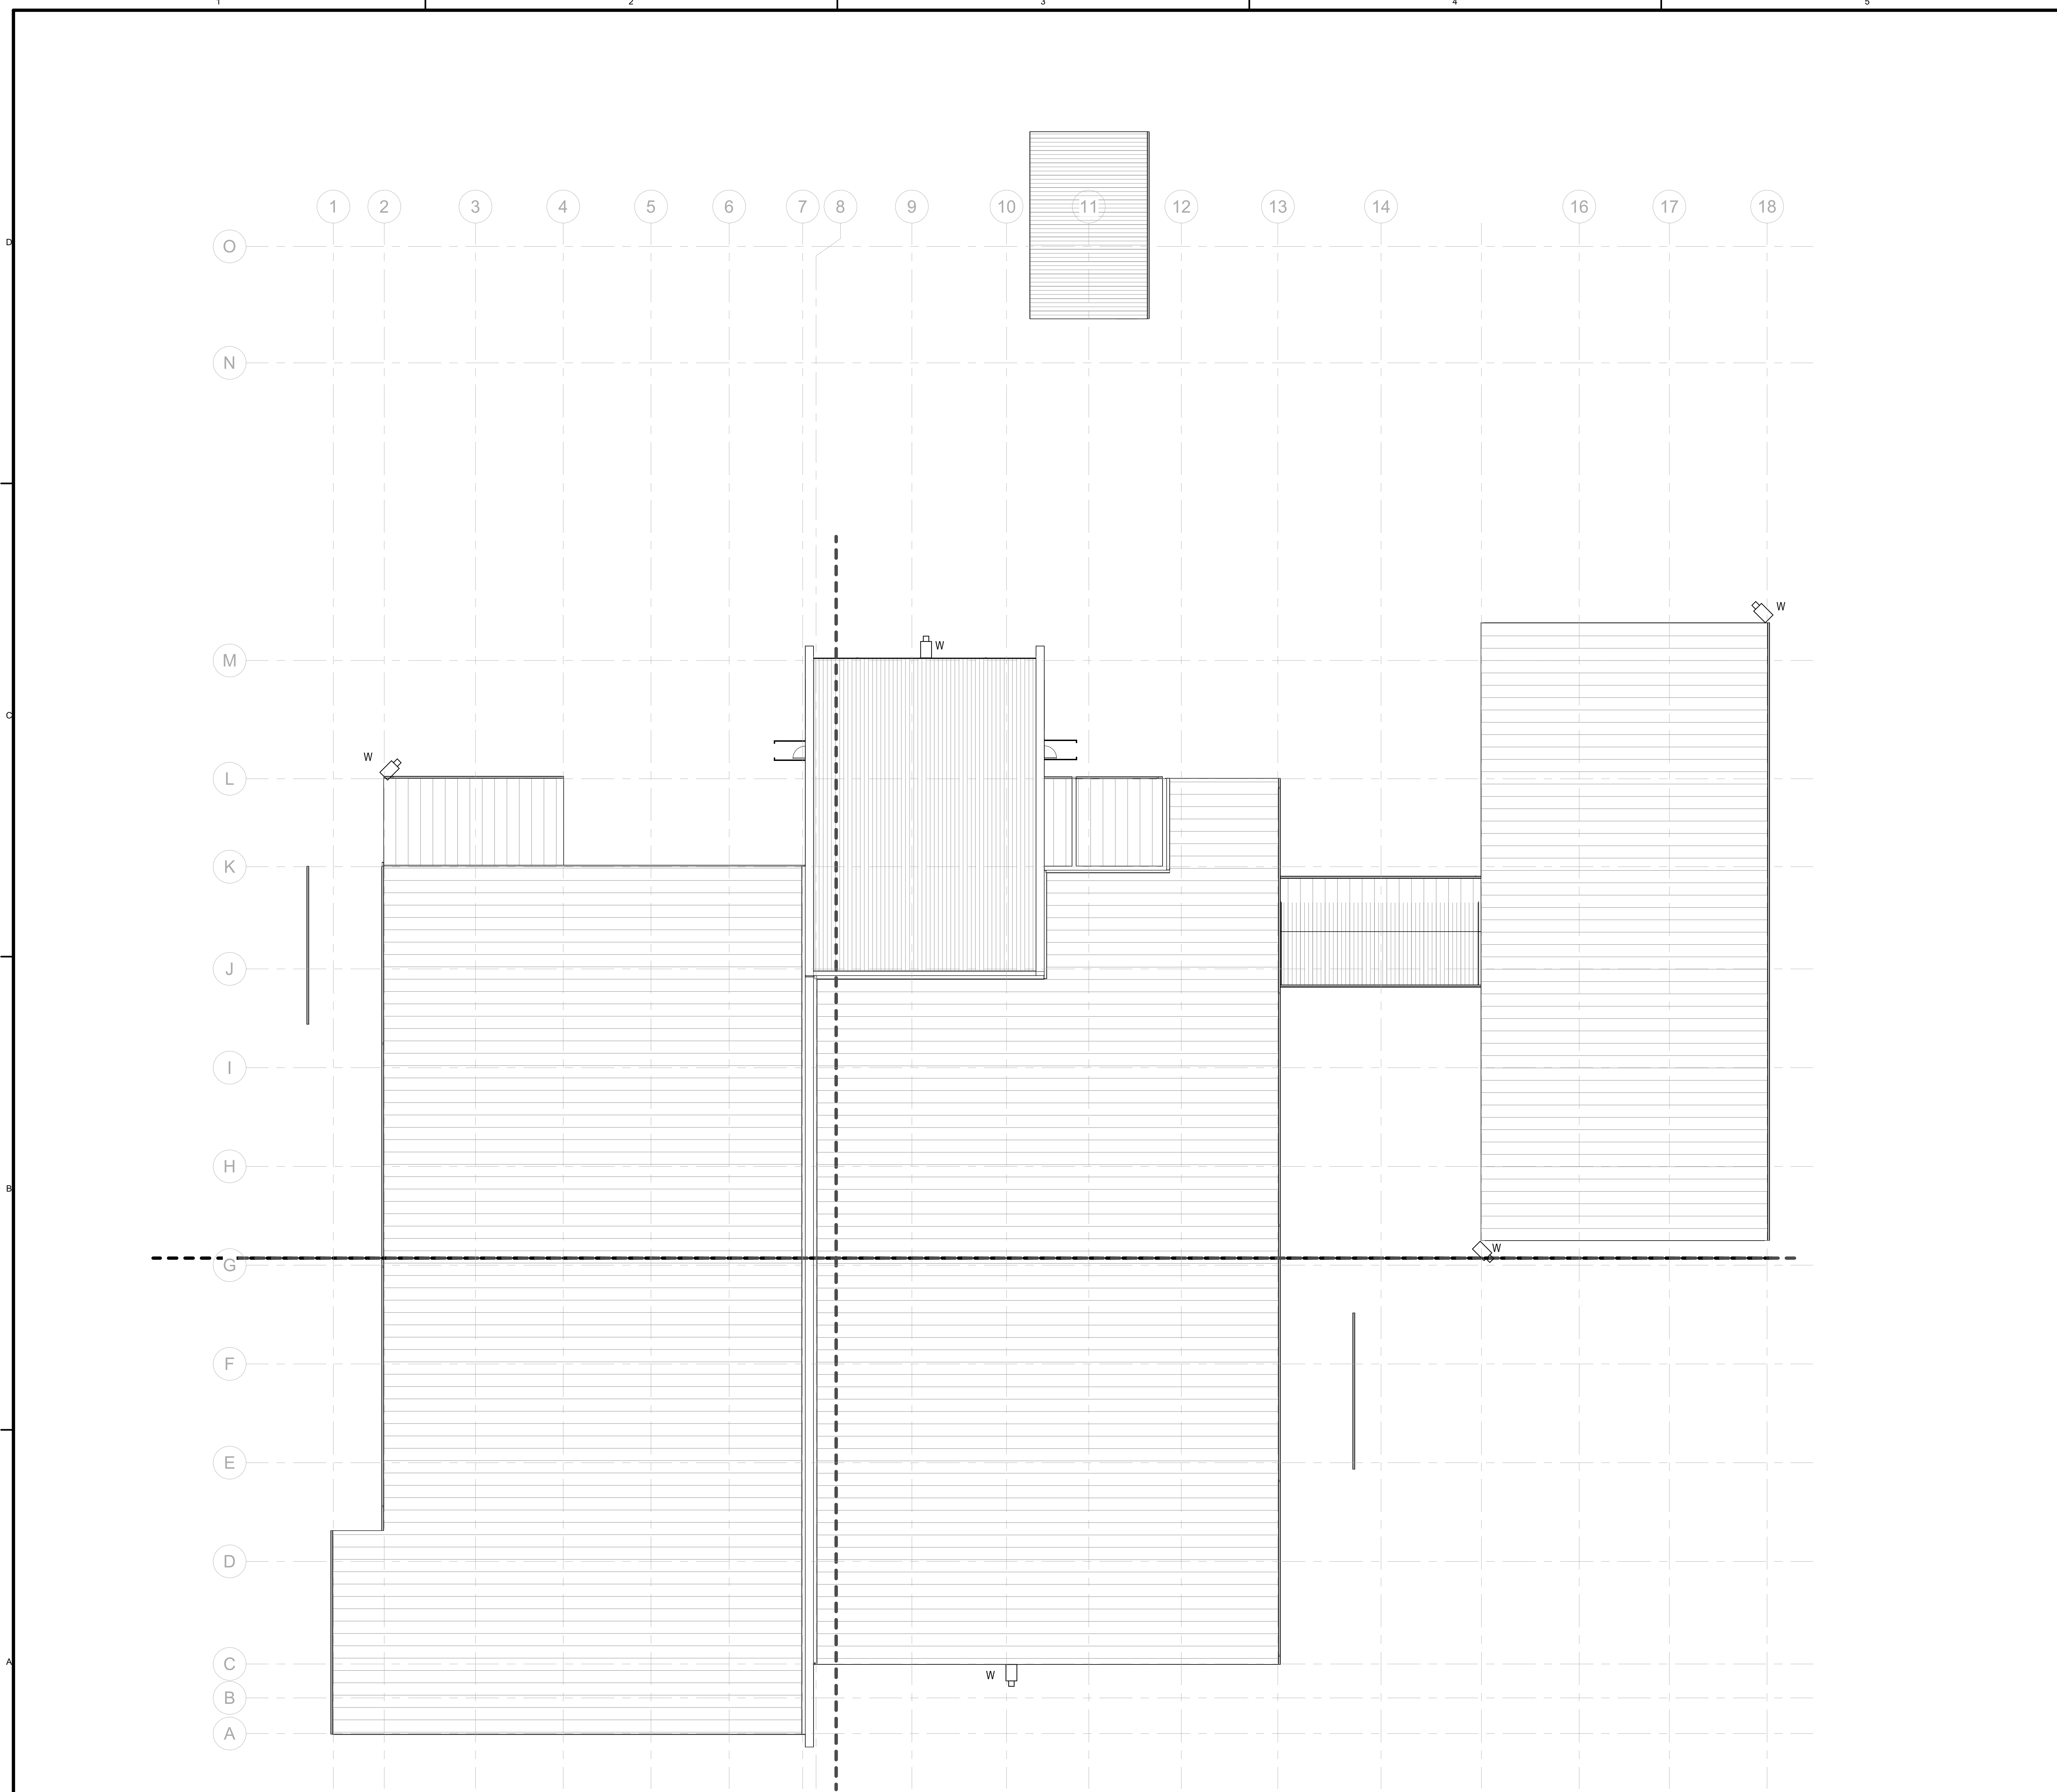


(A1) ROOF ELECTRONIC SECURITY SYSTEM PLAN
SCALE 1/16" = 1'-0"

GENERAL SHEET NOTES

1. REFER TO TY001 FOR GENERAL NOTES, SYMBOLS, AND ABBREVIATIONS.

KEY PLAN

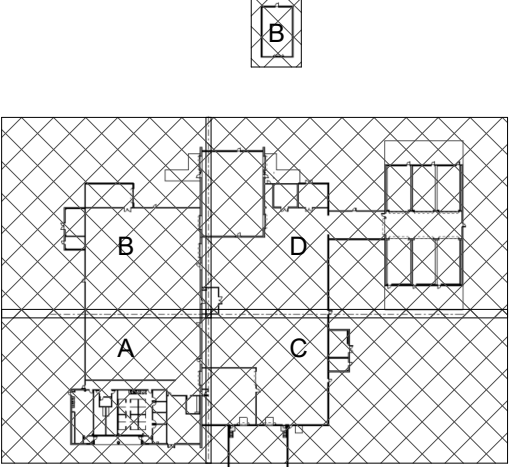

GRAPHIC SCALE(S)



SHEET NO		TY103
SCALE	1/16" = 1'-0"	
DATE	09/18/2024	
PROJ	D3754502	
DWG	000A-000, 000B, TY103	

NO	DATE	DR	CHK	APVD	BY	MT
0	09/18/2024				BP	MT
100% ISSUED FOR CONSTRUCTION - EXPANSION						
DESIGN	LTV	DR	ND	CHK	APVD	BY

GMLRS
Camden OSD
Calhoun County, Arkansas
Aerojet Rocketdyne

ELECTRONIC SECURITY SYSTEM
ROOF PLAN



© Jacobs Solutions 2023. ALL RIGHTS RESERVED.
THIS DOCUMENT, AND THE IDEAS AND DESIGNS INCORPORATED HEREIN, AS AN INSTRUMENT OF PROFESSIONAL SERVICE, IS THE PROPERTY OF JACOBS AND IS NOT TO BE USED, IN WHOLE OR IN PART, FOR ANY OTHER PROJECT WITHOUT THE WRITTEN AUTHORIZATION OF JACOBS.