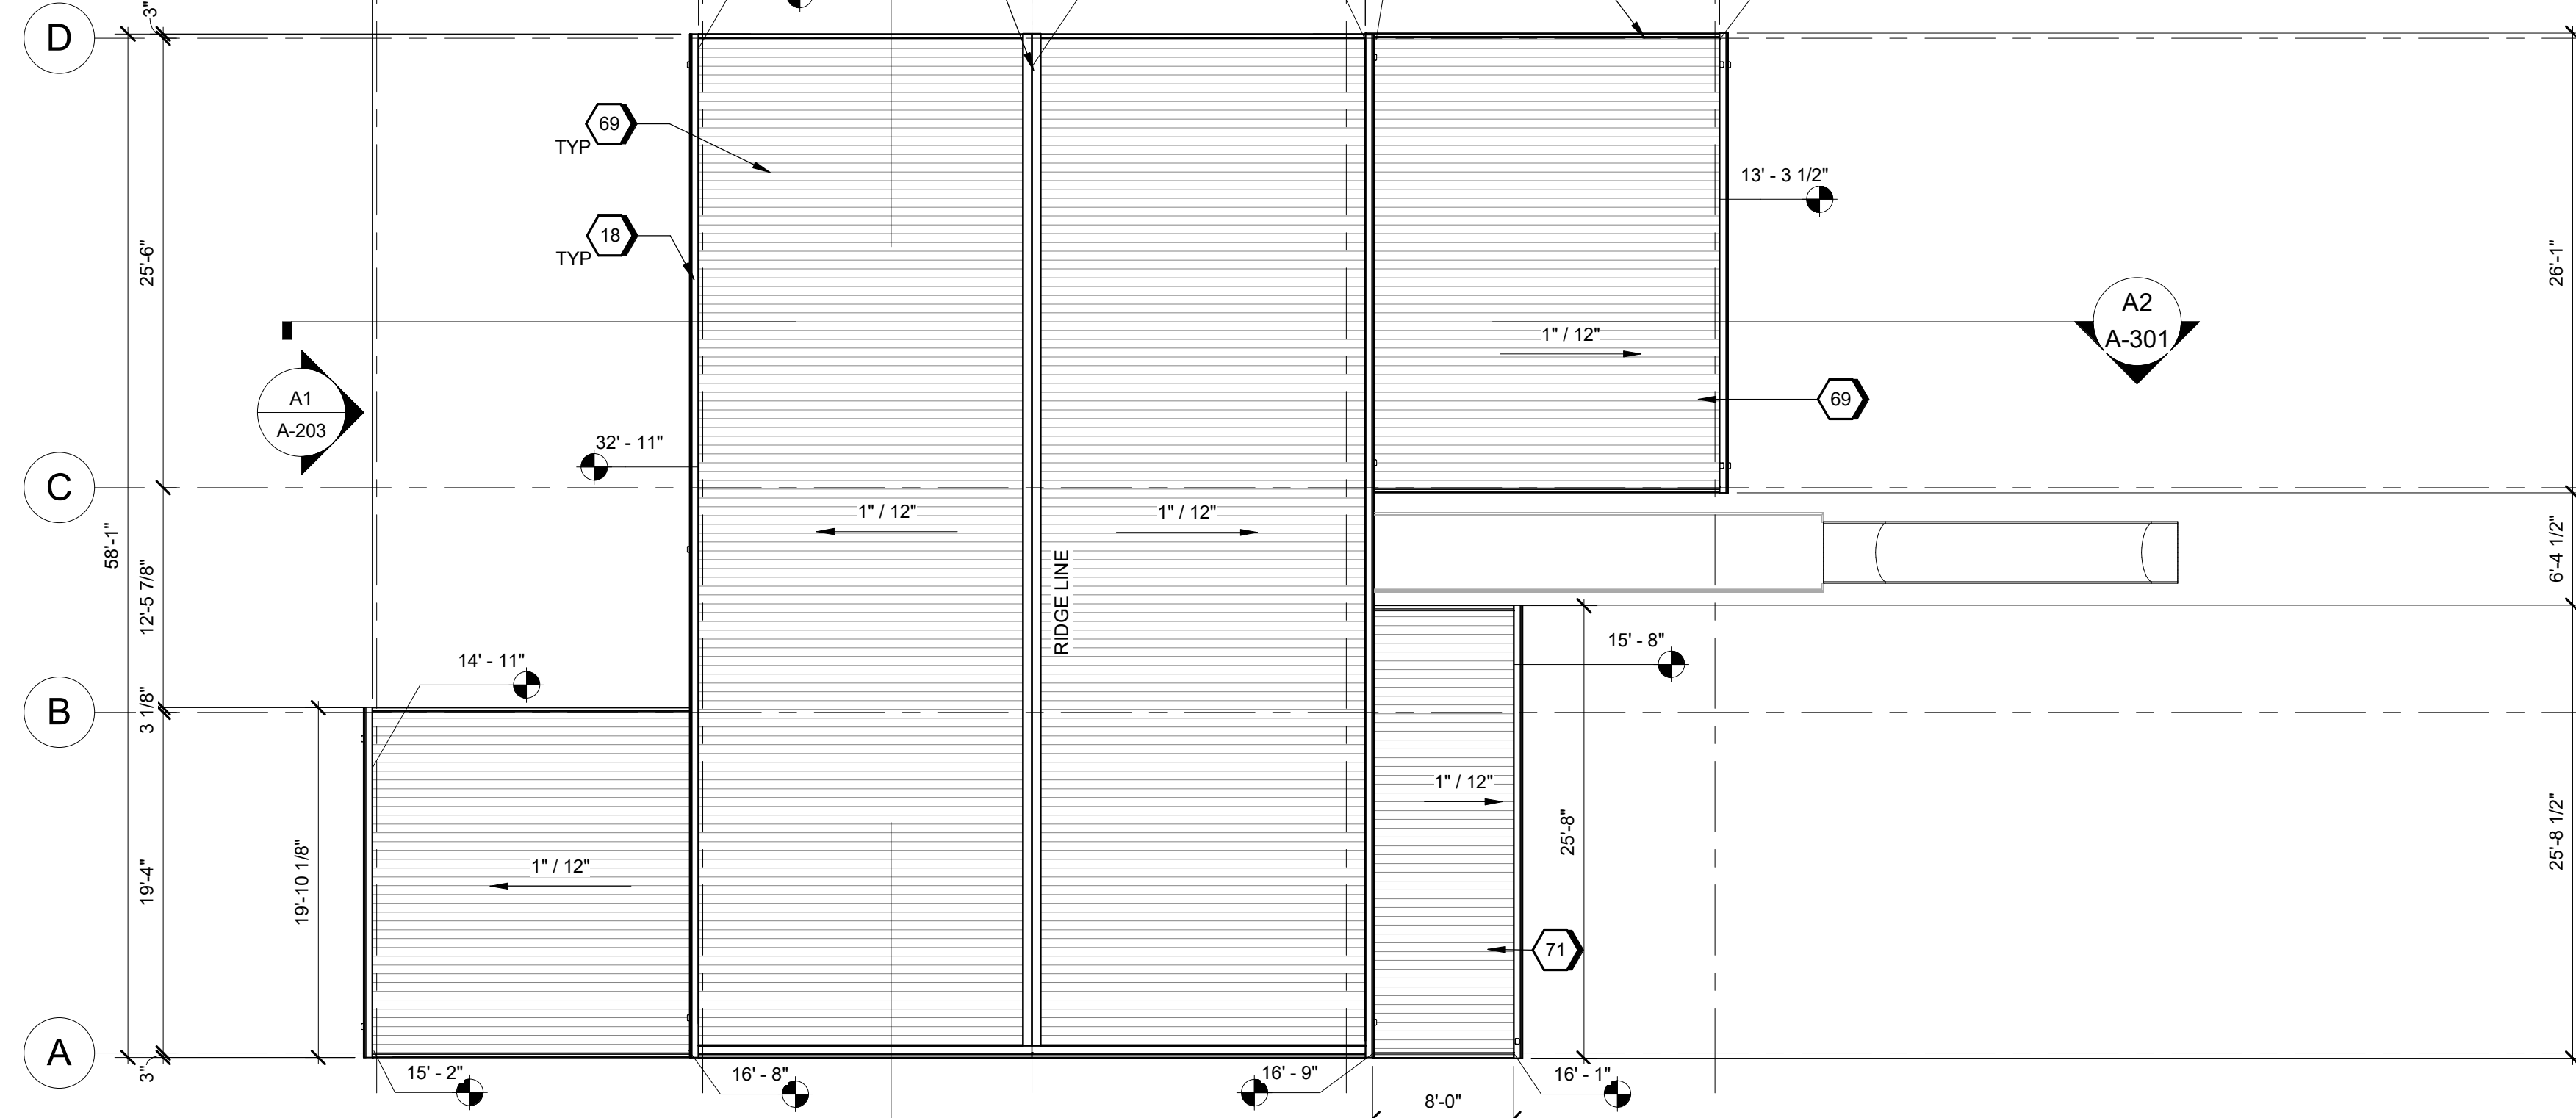


PLOT DATE/TIME: 9/18/2024 9:31:01 AM

GENERAL SHEET NOTES

A. REFER TO ELECTRICAL FOR LIGHTNING PROTECTION.

SHEET KEYNOTES

18 CONT. METAL GUTTER 5" DEEP X 6" WIDE. COLOR TO MATCH THE BUILDING
26 PEMB: RIDGE CAP
27 PEMB: RAKE TRIM AND FASCIA
69 RP-3 - REFER TO CAMPUS DETAILS A-800
71 RP-2 - REFER TO CAMPUS DETAILS A-800



Grinder
Camden OSD
Calhoun County, Arkansas
Aerjet Rocketdyne

ARCHITECTURE
ROOF PLAN

SHEET NO

AE131

SCALE	As indicated
-------	--------------

DATE	09/18/2024
------	------------

DWG C:\MSOFT\CD\CH09\FIGS\Figure_9-6.dwg



		E	ND/YA	BH	TM
REUSE OF DOCUMENTS:	THIS DOCUMENT, AND THE IDEAS AND DESIGNS INCORPORATED HEREIN, AS AN INSTRUMENT OF PROFESSIONAL SERVICE, IS THE PROPERTY OF Jacobs And is NOT TO BE USED IN WHOLE OR IN PART FOR ANY OTHER PROJECT WITHOUT THE WRITTEN AUTHORIZATION OF JACOBS.				

© Jacobs Solutions 2023. ALL RIGHTS RESERVED.