


9/18/2024 11:10:45 AM FA102
Autodesk Docs/US D3754502_FED_Aerojet Rocketdyne/D3754502_CIMDL OSD_Grinder_FP.rvt

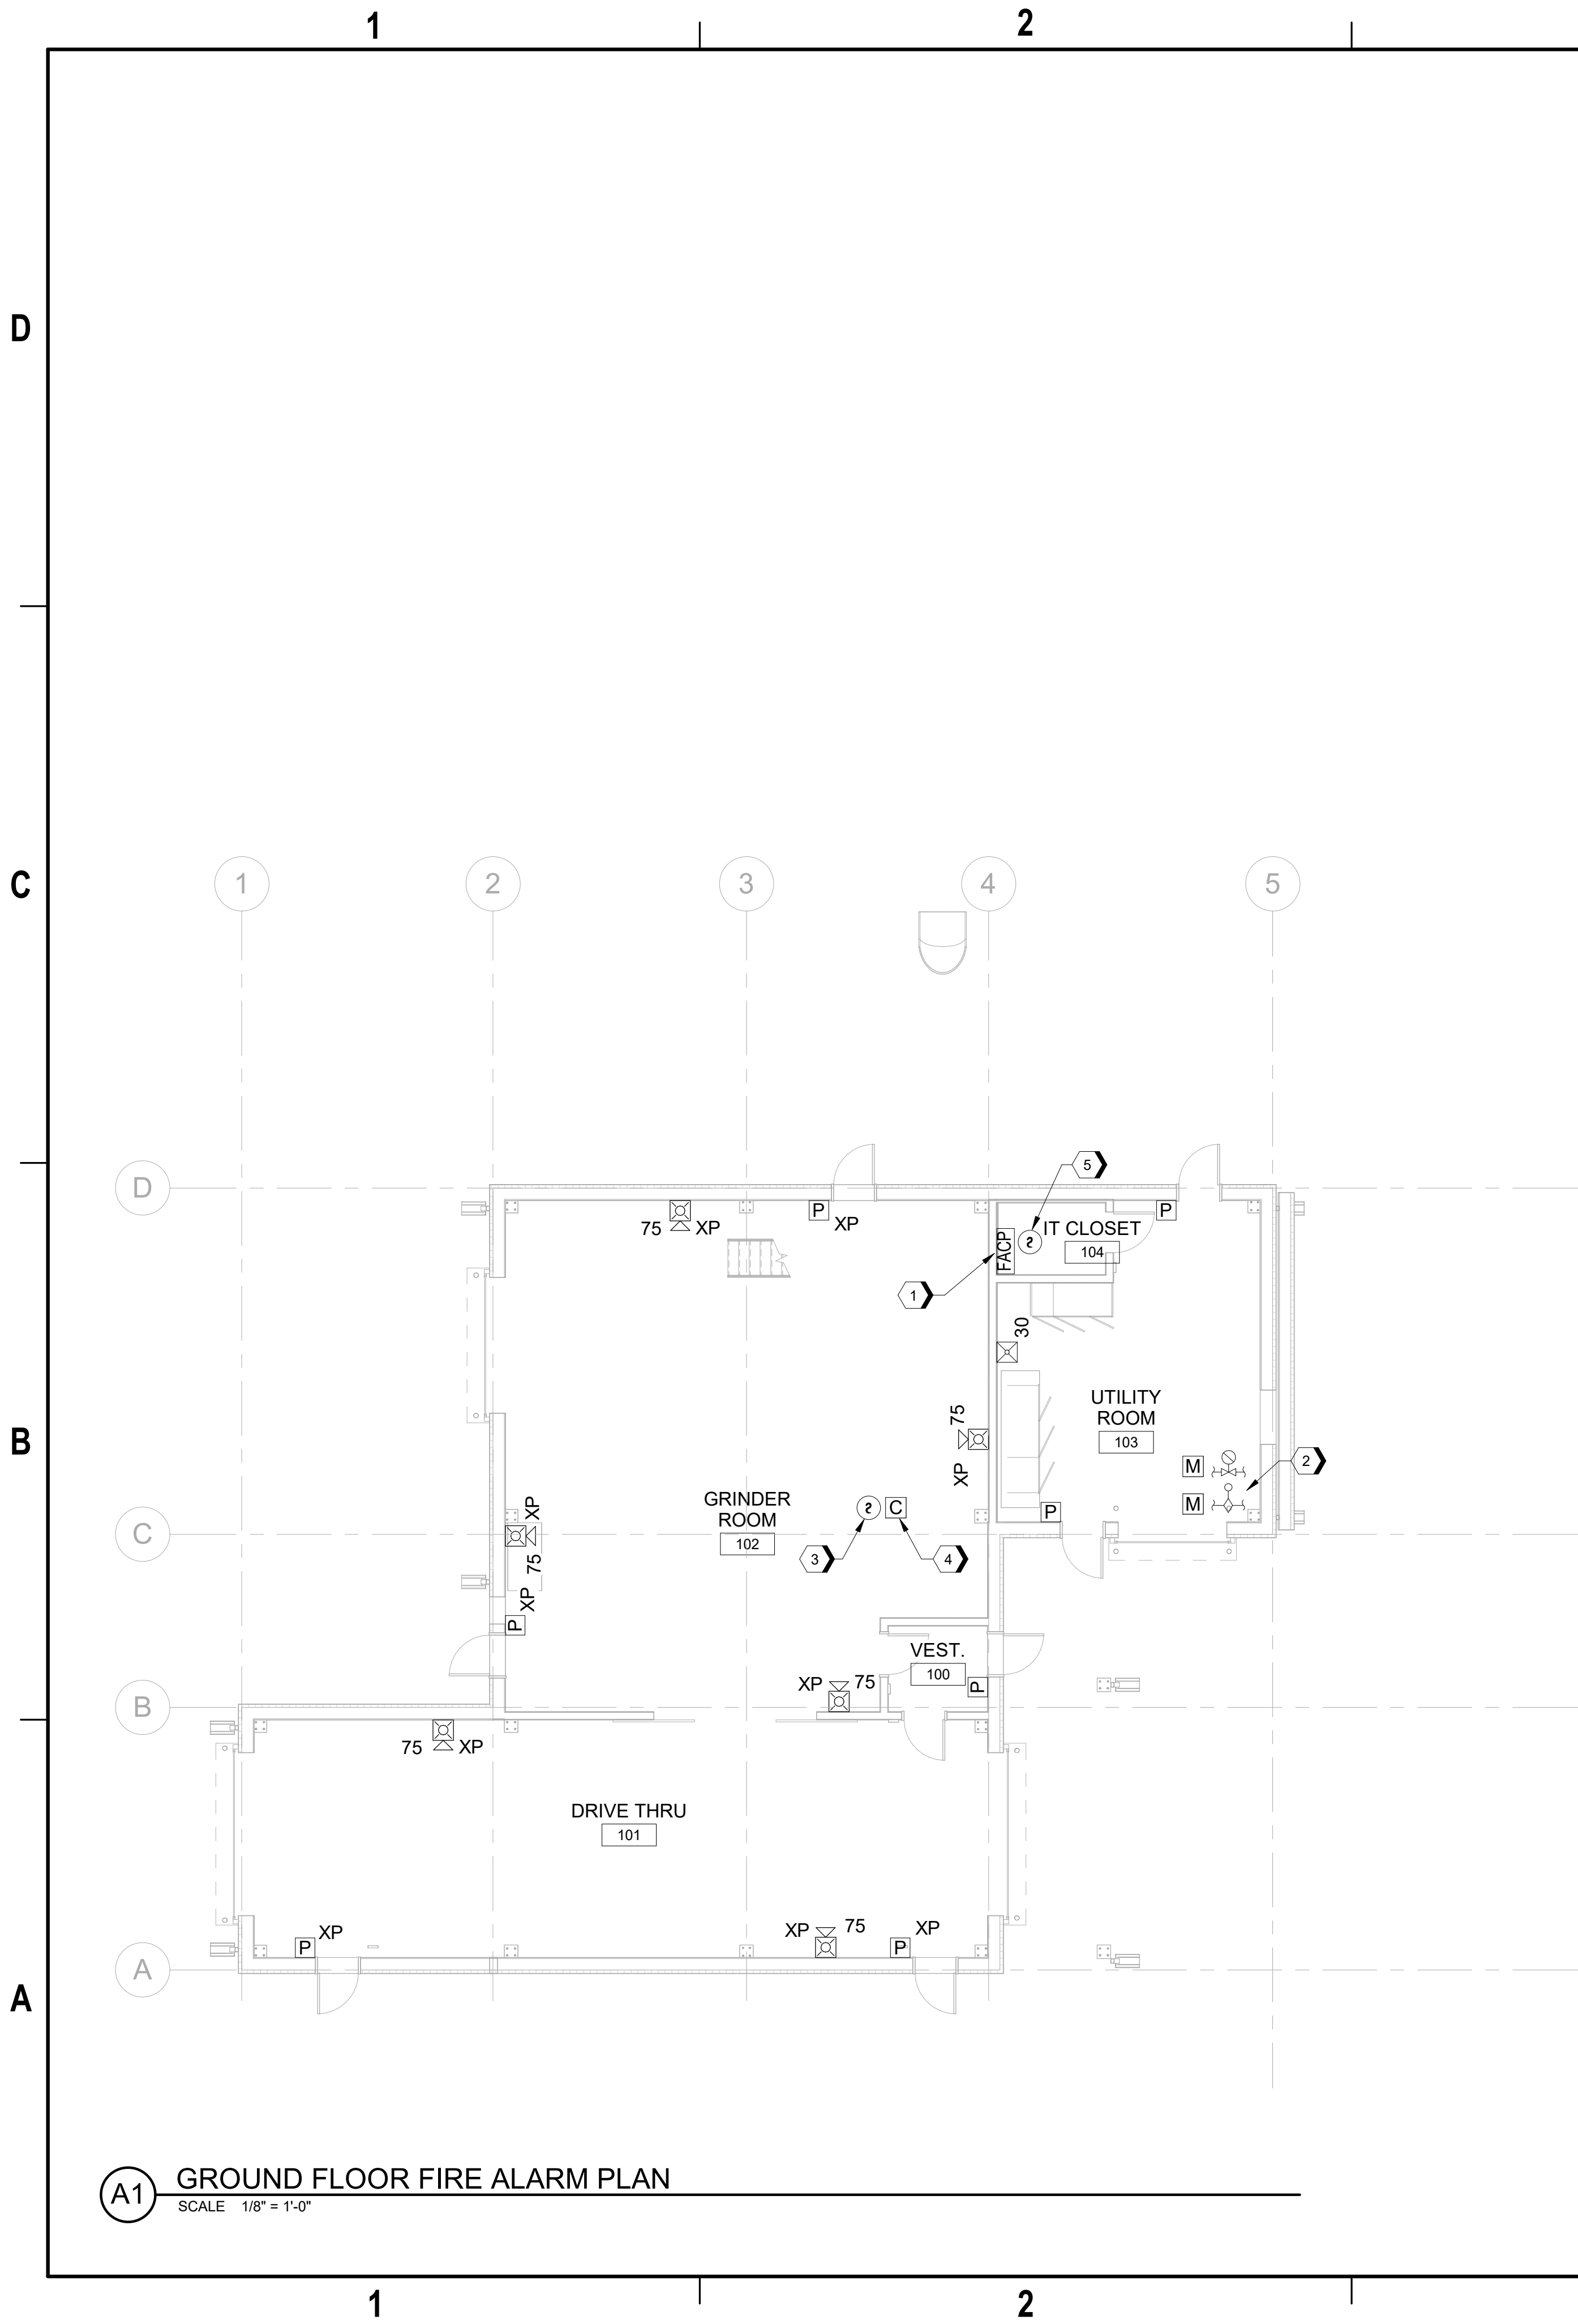


GENERAL SHEET NOTES

- REFER TO SHEET F-001 FOR GENERAL NOTES AND SYMBOLS.
- REFER TO SHEET FA801 AND FA802 FOR FIRE ALARM DETAILS.
- FIRE ALARM COMPONENTS SHALL BE RATED FOR EXPLOSIVE ENVIRONMENTS IN AREAS WHERE EXPLOSIVE MATERIALS ARE HANDLED AND A DEFLAGRATION RISK IS PRESENT.

#SHEET KEYNOTES

- FIRE ALARM CONTROL PANEL
- MONITOR RISER WATERFLOW AND TAMPER SWITCHES
- PROVIDE SMOKE DETECTION IN DUST COLLECTION SYSTEM TO BE MONITORED BY THE FIRE ALARM SYSTEM
- PROVIDE CONTROL MODULES TO CLOSE DAMPER AND SHUT DOWN DUST COLLECTION SYSTEM UPON ACTIVATION OF ASSOCIATED SMOKE DETECTOR
- PROVIDE SMOKE DETECTOR ABOVE FACP

GRAPHIC SCALE(S)

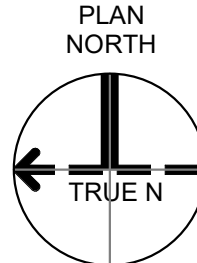

Jacobs
1889 Bryan Street Suite 3500 Dallas, TX 75201
Tel: 214-638-0145 Fax: 214-638-0447
Entity: Jacobs Engineering Group Inc.
License: Professional Engineering
Exp. Date: 12/31/2024



Jacobs **M&BIOZ**

Grinder
Camden OSD
Calhoun County, Arkansas
Aerojet Rocketdyne

**FIRE ALARM
FLOOR PLAN**

SHEET NO

FA102

SCALE 1/8" = 1'-0"
DATE 09/18/2024
PROJ D3754502
DWG CIMDL OSD_Grinder_FA102

PLOT DATE/TIME: 9/18/2024 11:10:45 AM