


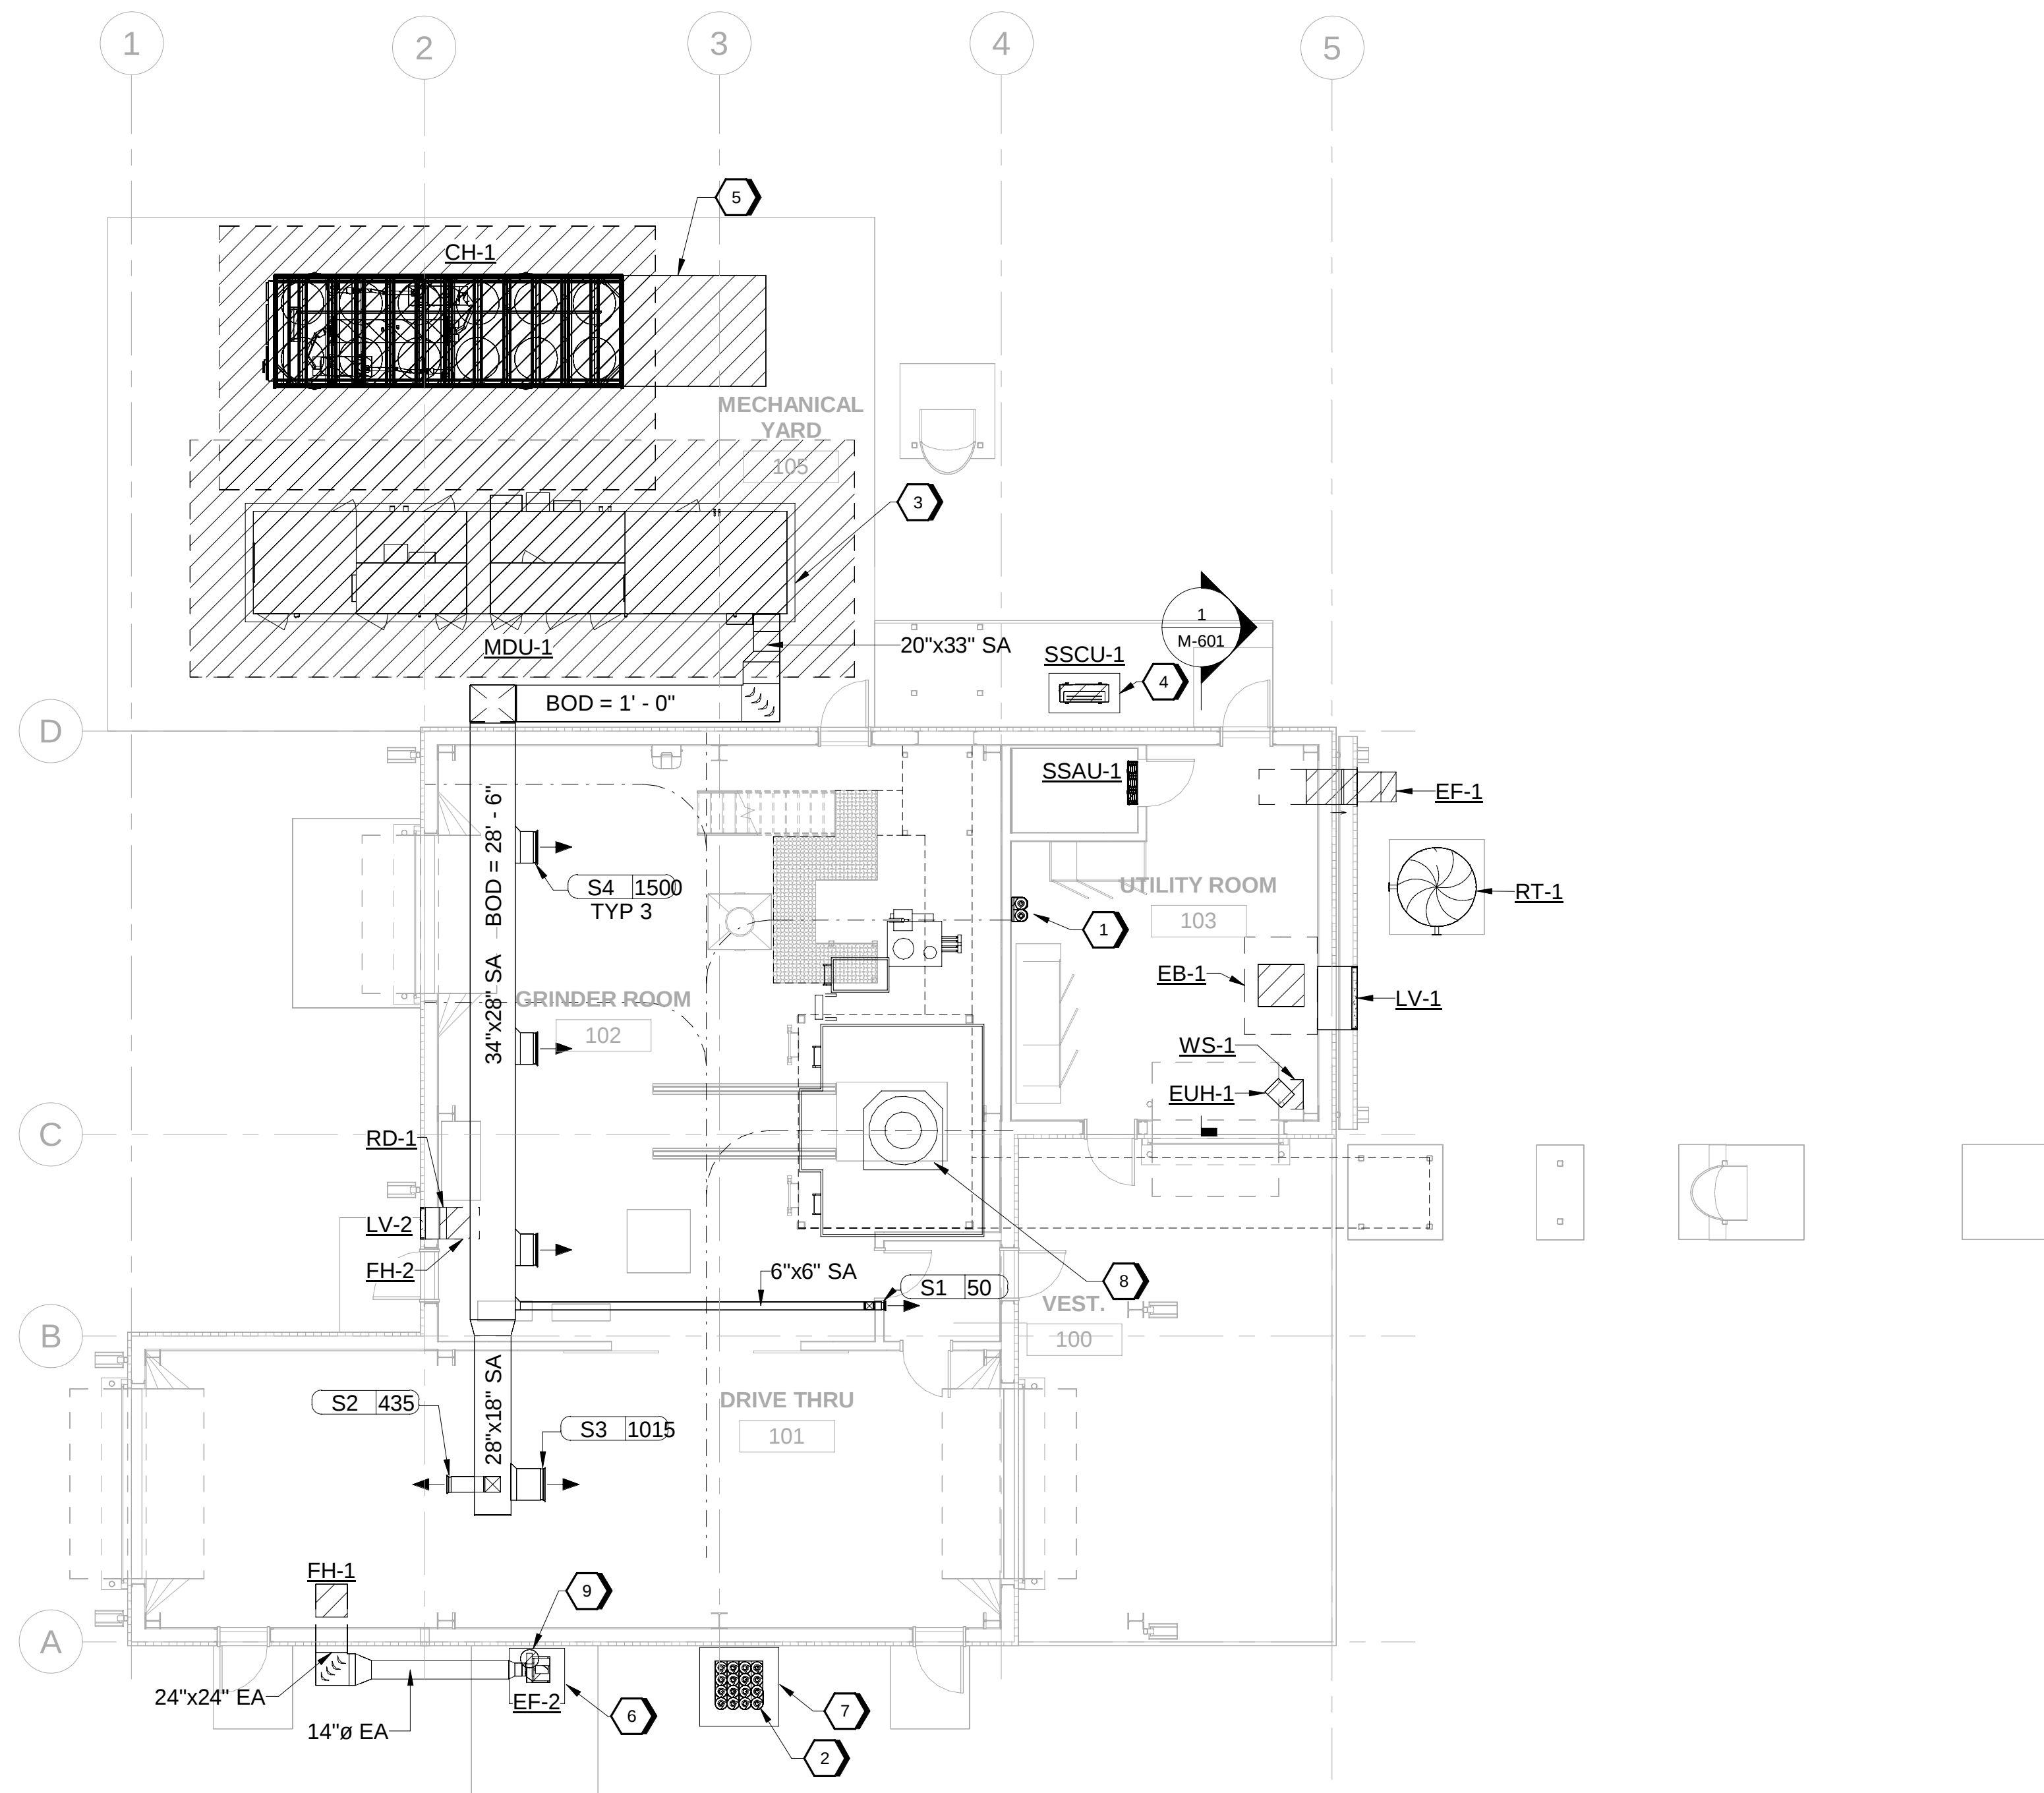

**A1 OVERALL HVAC FLOOR PLAN**  
SCALE 1/8" = 1'-0"


## GENERAL SHEET NOTES

1. ALL GRADE MOUNTED MECHANICAL AND PLUMBING EQUIPMENT IN UTILITY RM 103 SHALL HAVE A HOUSEKEEPING PAD 4" TALL EXTENDING 6" FROM EACH SIDE.

## # SHEET KEYNOTES

- |   |                                                                                                             |
|---|-------------------------------------------------------------------------------------------------------------|
| 1 | HIGH PRESSURE ARGON MANIFOLD. USE ARGON SCHEMATIC DIAGRAM ON SHEET MI-1094.                                 |
| 2 | 16-CYLINDER ARGON BOTTLE RACK                                                                               |
| 3 | PROVIDE CONCRETE PAD (6" TALL, 34"-9"W X 7'-6"L).                                                           |
| 4 | PROVIDE CONCRETE PAD (4" TALL, 4'-6"W X 2'-6"L). UNIT SHALL SIT ON 12" TALL STAND. SEE SCHEDULE MATHS-1070. |
| 5 | PUMP PACKAGE SKID. SEE CHILLER SCHEDULE FOR EQUIPMENT DETAILS.                                              |
| 6 | PROVIDE CONCRETE PAD (4" TALL, 3'-6"W X 3'-6"L).                                                            |
| 7 | PROVIDE CONCRETE PAD (4" TALL, 5'-0"W X 5'-0"L).                                                            |
| 8 | ROUTE DUST COLLECTOR VENT TO NEAR FH-2                                                                      |
| 9 | TERMINATE 14" EA DUCT ABOVE ROOF LINE                                                                       |

**Jacobs**

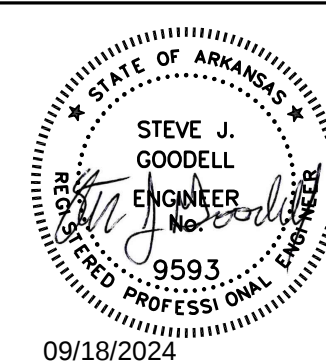


Grinder  
Camden OSD  
Calhoun County, Arkansas  
Aerojet Rocketdyne

**Jacobs**  **NABHOLZ** 

## KEY PLAN

**GRAPHIC SCALE(S)**

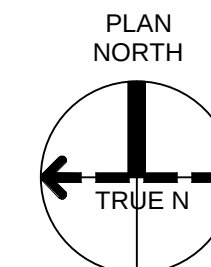

PLOT DATE/TIME: 9/17/2024 9:14:51 PM