


9/17/2024 9:15:04 PM MI-102
Autodesk Docs/US_D3754500_FED_Aerojet Rocketdyne/D3754500_CNDN_OSD_Grinder_MECH.vrt

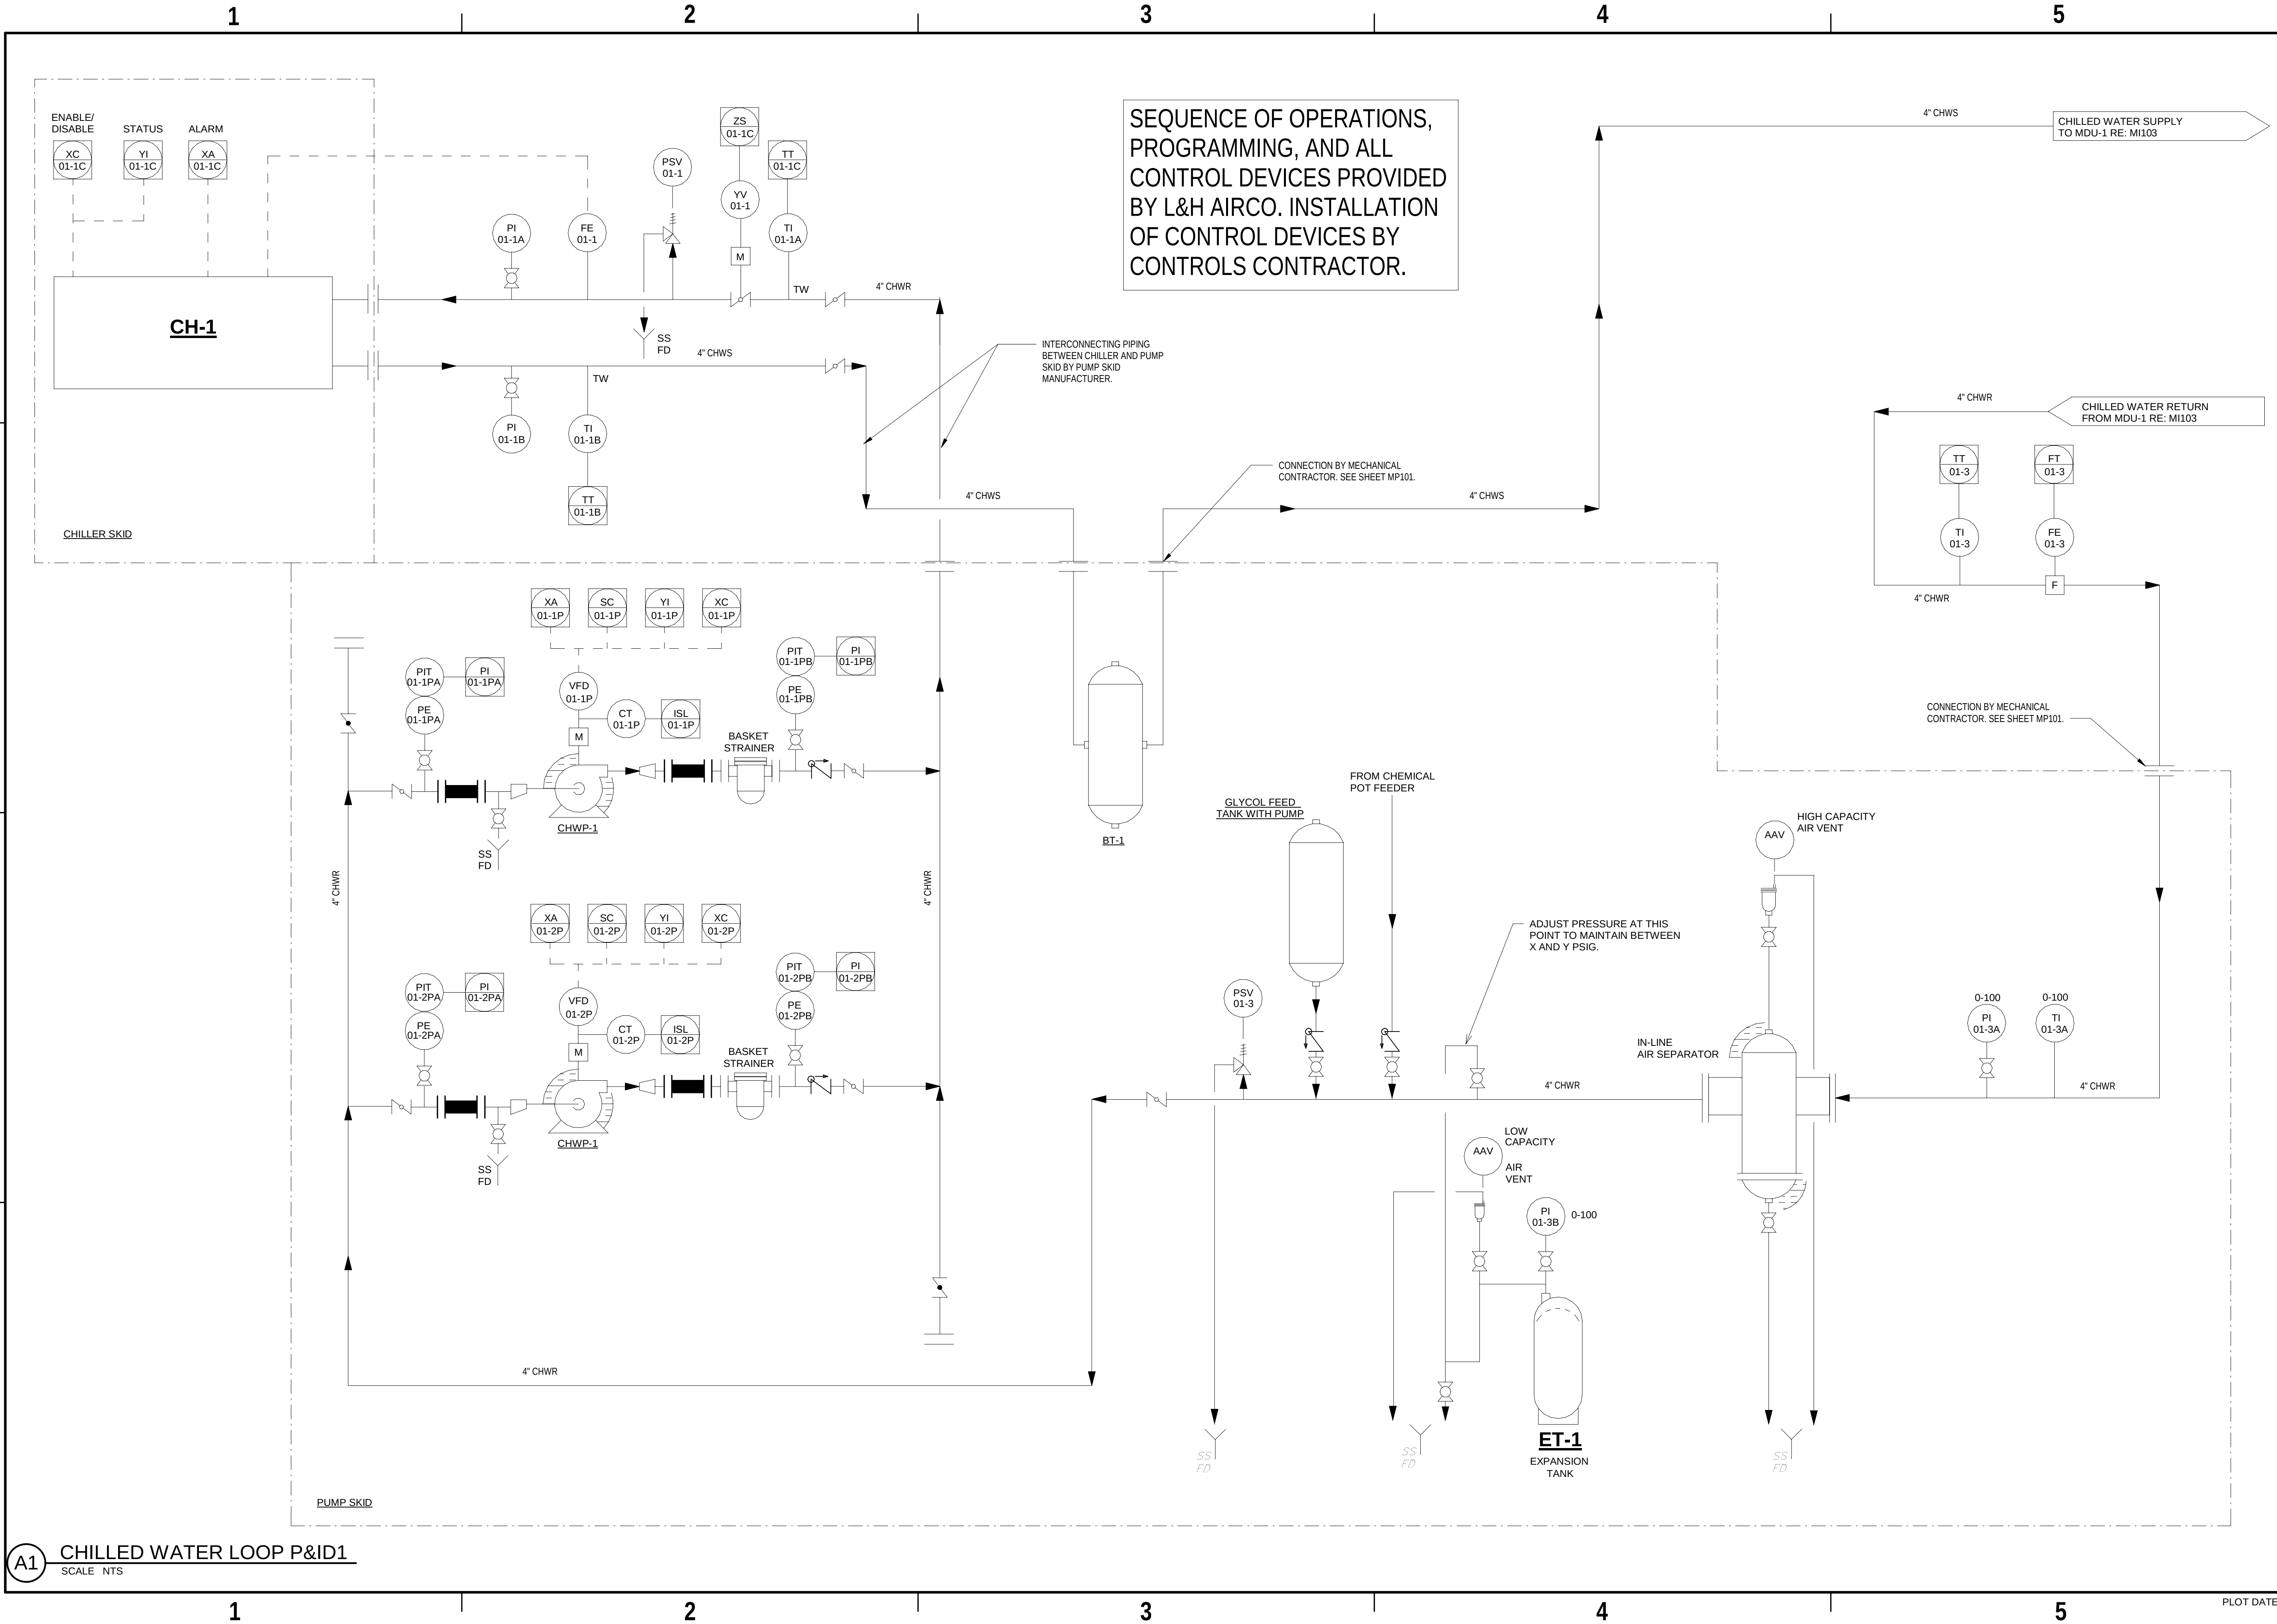

SEQUENCE OF OPERATIONS,
PROGRAMMING, AND ALL
CONTROL DEVICES PROVIDED
BY L&H AIRCO. INSTALLATION
OF CONTROL DEVICES BY
CONTROLS CONTRACTOR.

SHEET NO		MI-102	
SCALE		12" = 1'-0"	
DATE		09/18/2024	
PROJ		D3754502	
DWG		CNDN_OSD_Grinder_MI-102	

Grinder
Camden OSD
Calhoun County, Arkansas
Aerojet Rocketdyne

NO.	DATE	BY	CHK	DR	APVD	SG
0	09/18/2024	JWG				
100% ISSUED FOR CONSTRUCTION - EXPANSION						

1909 Bryan Street Suite 200 Dallas, TX 75201
Tel: 214-639-0145 Fax: 214-639-0447
Entity: Jacobs Engineering Group Inc.
License: Professional Engineering
Exp. Date: 12/31/2024

REUSE OF DOCUMENTS: THIS DOCUMENT AND ITS CONTENTS ARE THE PROPERTY OF JACOBS AND ARE NOT TO BE USED IN WHOLE OR IN PART FOR ANY OTHER PROJECT WITHOUT THE WRITTEN AUTHORIZATION OF JACOBS.

A1 CHILLED WATER LOOP P&ID1
SCALE NTS