



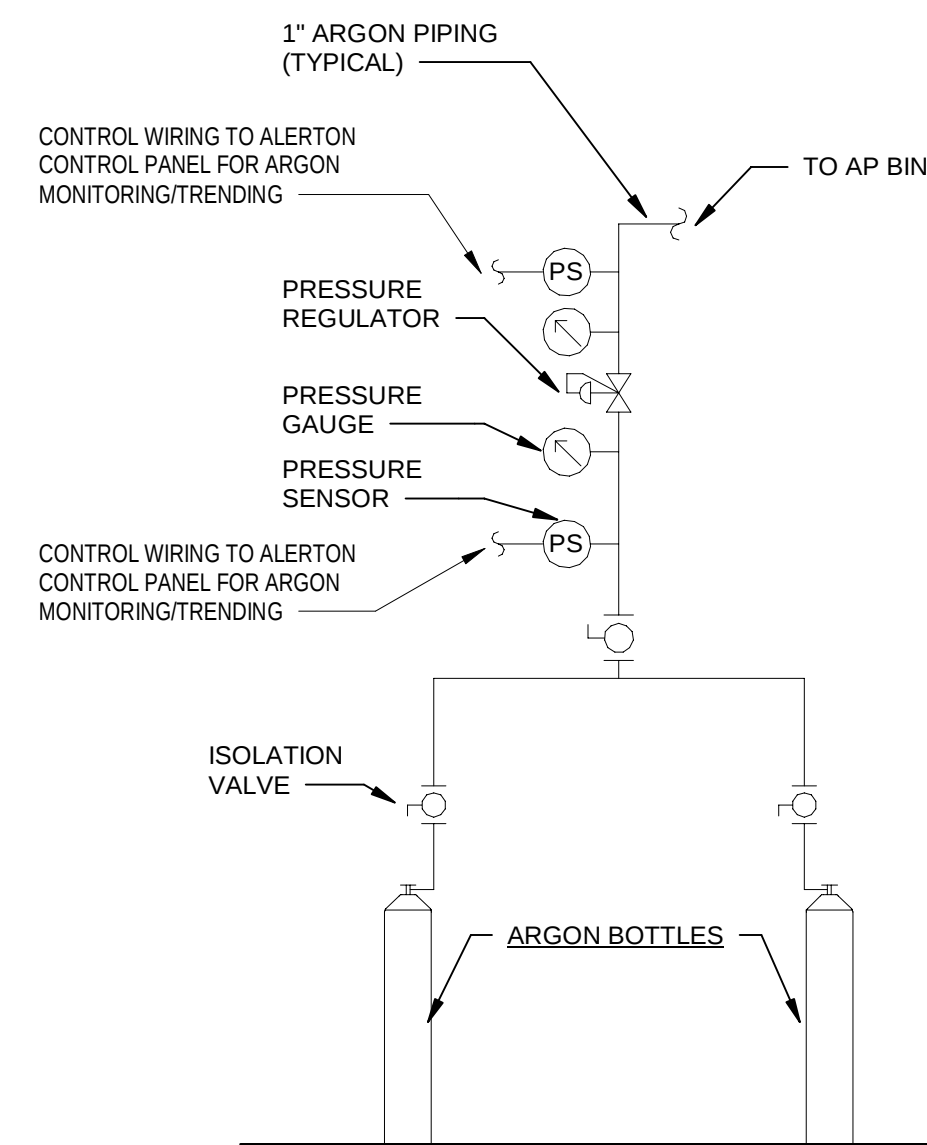

1 ARGON SCHEMATIC DIAGRAM
SCALE NTS

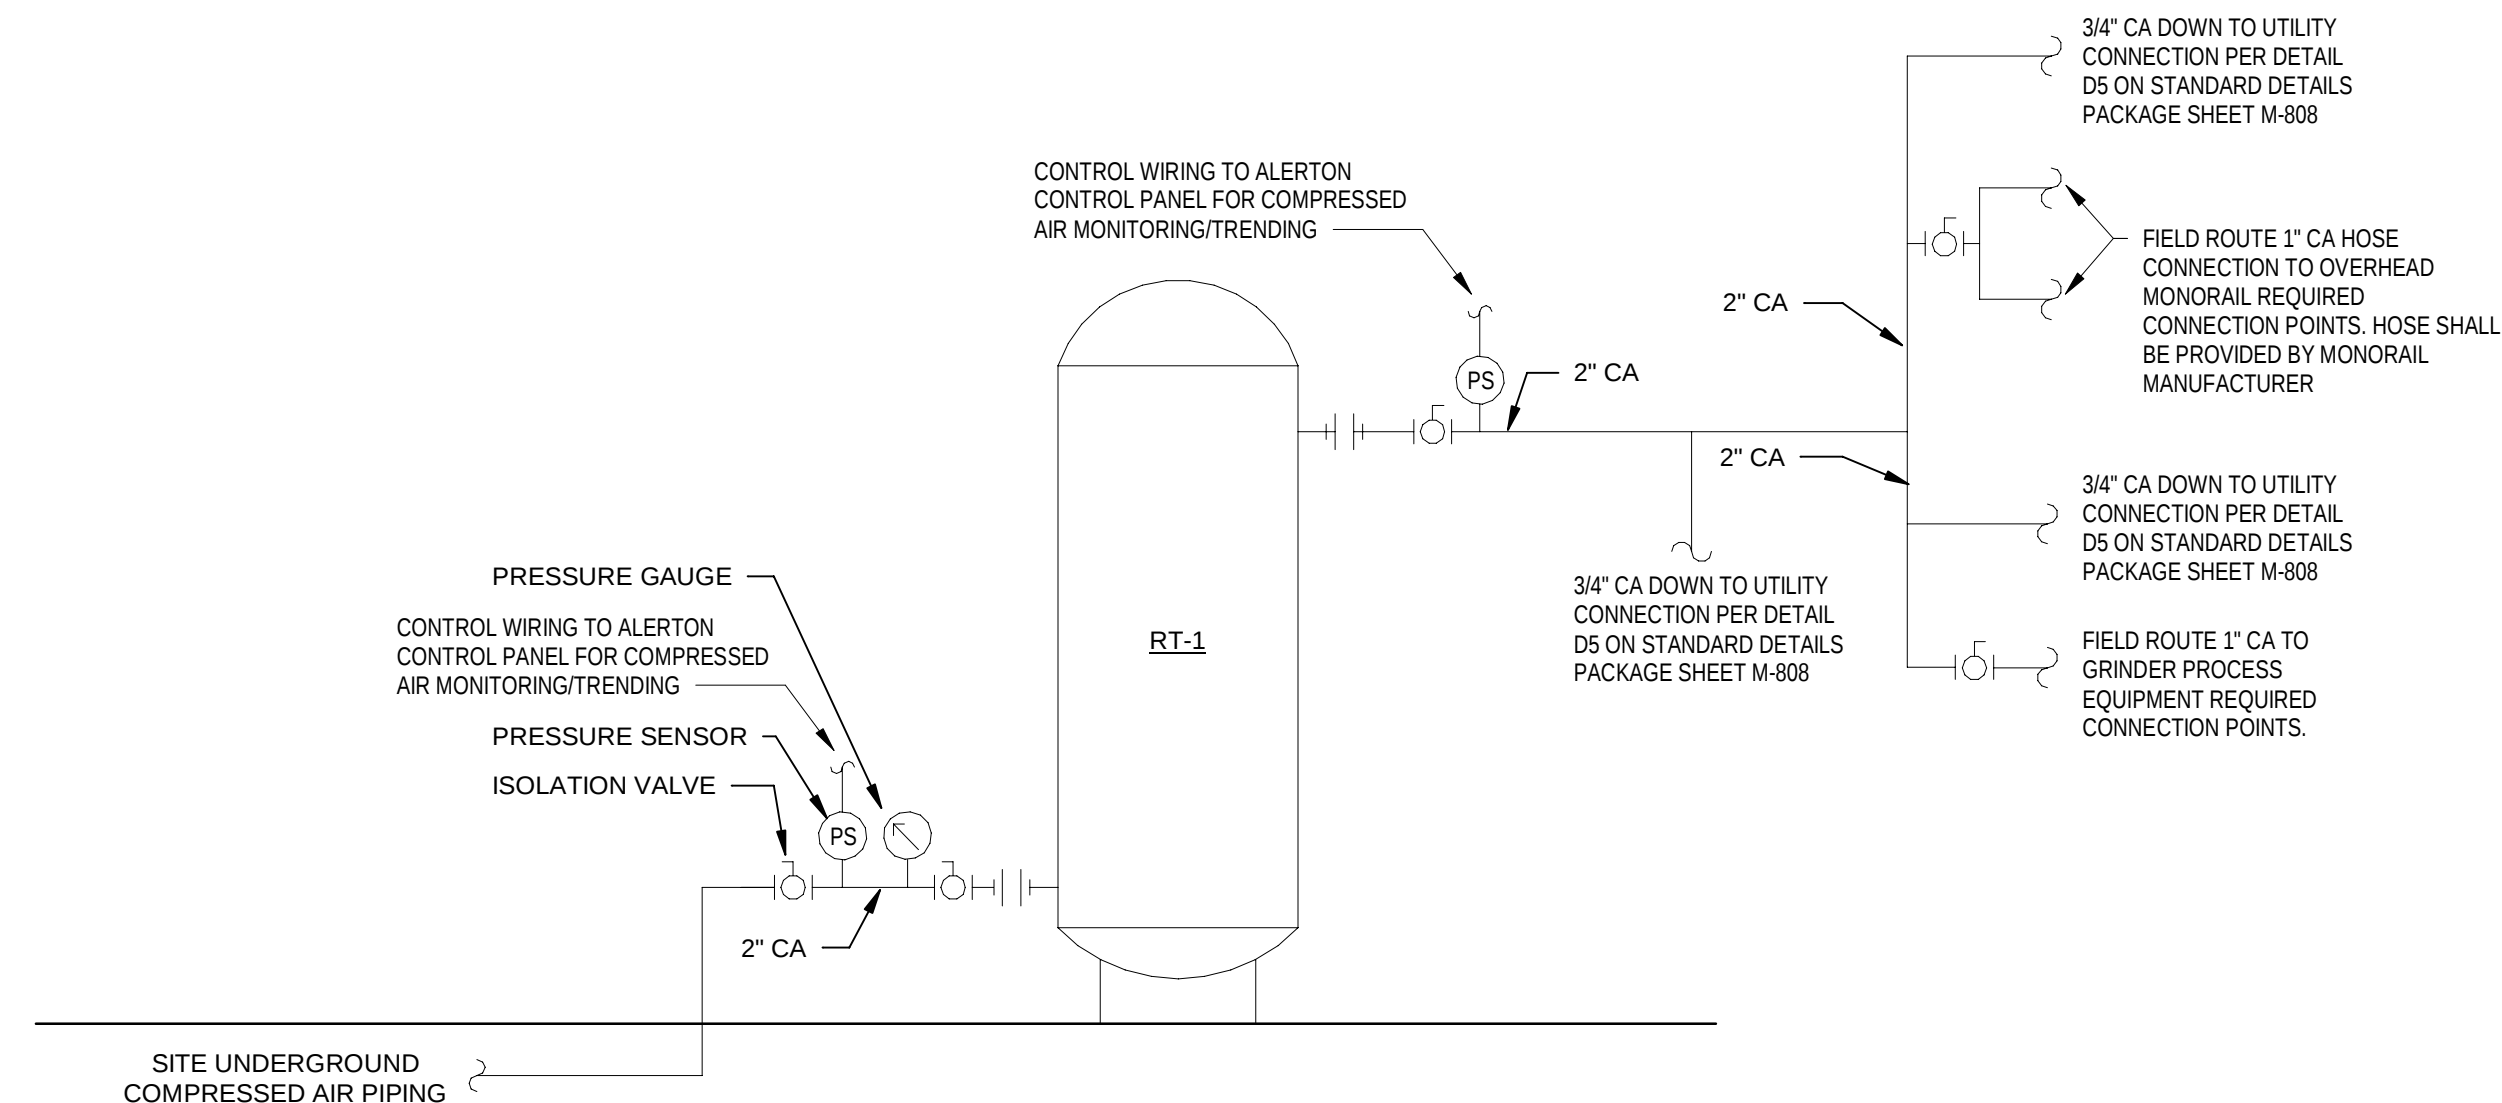

2 COMPRESSED AIR SCHEMATIC DIAGRAM
SCALE NTS

SEQUENCE OF OPERATIONS,
PROGRAMMING, AND ALL
CONTROL DEVICES PROVIDED
BY L&H AIRCO. INSTALLATION
OF CONTROL DEVICES BY
CONTROLS CONTRACTOR.

[illegible]