


9/12/2024 11:51:45 AM T-601
Autodesk Docs\\US_D3754502_FED_Aerojet Rocketdyne\\D3754502_CADD\\OSD_Grinder_T001\\SEC.rvt

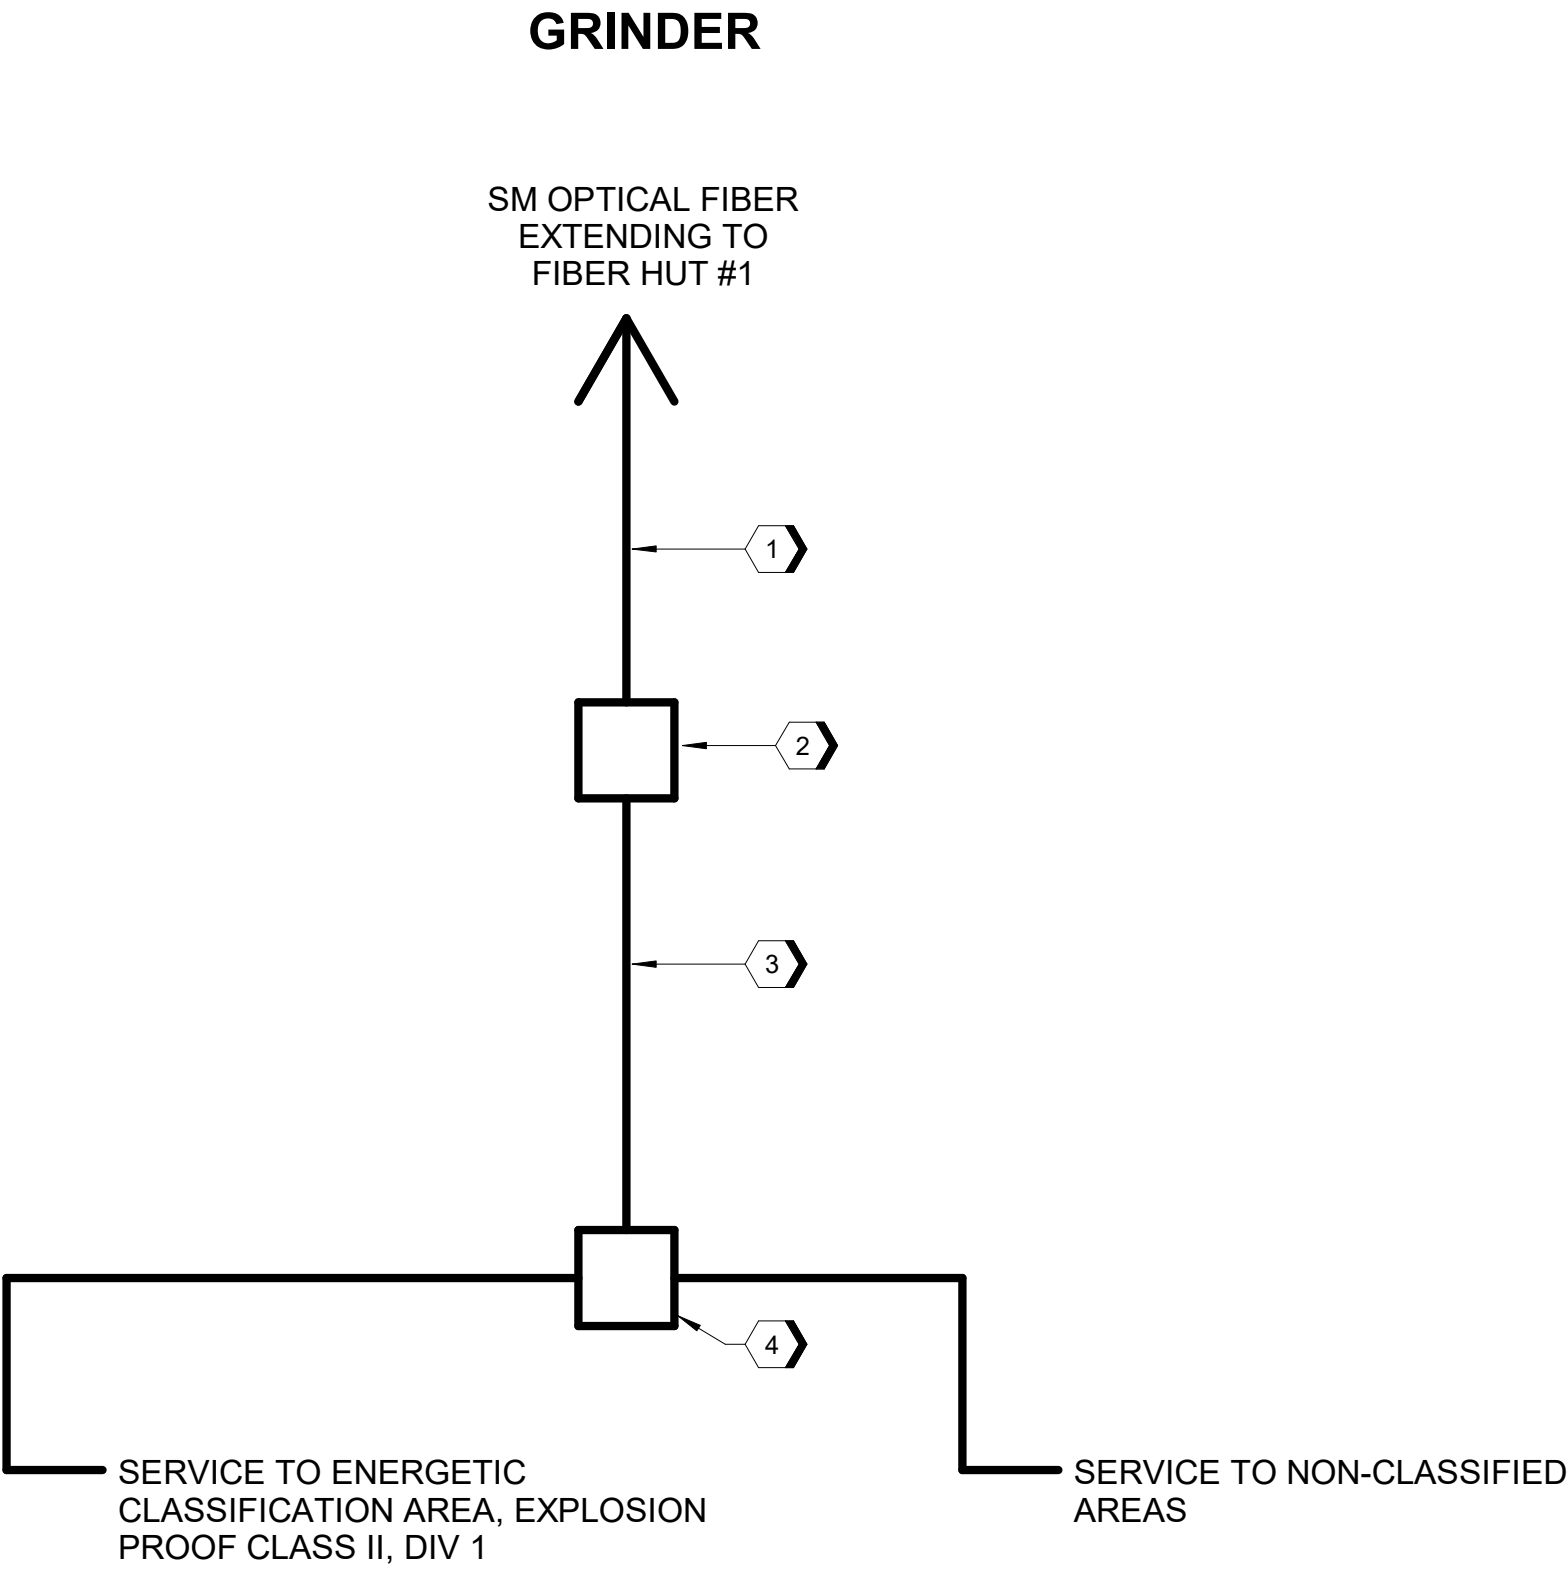


A1 TELECOM - ONE LINE DIAGRAM
SCALE NTS

#SHEET KEYNOTES

- 2 x 4" LATERAL CONDUITS EXTENDING TO FIBER HUT #1.
- 3' x 3' TELECOMMUNICATIONS HAND HOLE FOR INTERCONNECTION OF THE GRINDER TO THE CAMPUS BACKBONE NETWORK.
- 2 x 4" TELECOMMUNICATIONS BUILDING ENTRANCE CONDUITS FOR INTERCONNECTION OF THE GRINDER TO THE CAMPUS BACKBONE NETWORK.
- 24" WIDE x 30" DEEP 26 RU WALL MOUNTED TELECOMMUNICATIONS EQUIPMENT CABINET.



1889 Bryan Street Suite 3500 Dallas, TX 75201
Tel: 214-638-0145 Fax: 214-638-0447
Entity: Jacobs Engineering Group Inc.
License: Professional Engineering
License No. 107014
Exp. Date: 12/31/2024

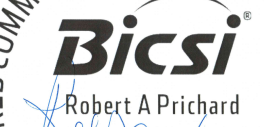

REGISTERED COMMUNICATIONS DISTRIBUTION DESIGNER
Robert A Prichard
Bicsi ID #107014
EXPIRES 12-31-25
RCCD



Grinder
Camden OSD
Calhoun County, Arkansas
Aerojet Rocketdyne



TELECOMMUNICATION
ONE-LINE DIAGRAM

SHEET NO	
T-601	
SCALE	NTS
DATE	09/18/2024
PROJ	D3754502
DWG	CADD\\OSD_Grinder_T601