


9/18/2024 9:53:27 AM AE131
Autodesk Docs\US_D3754502_FED_Aerojet Rocketdyne\B3754500_CIMDN_OSD_Mixer-Building_1_ARCH-INT.rvt

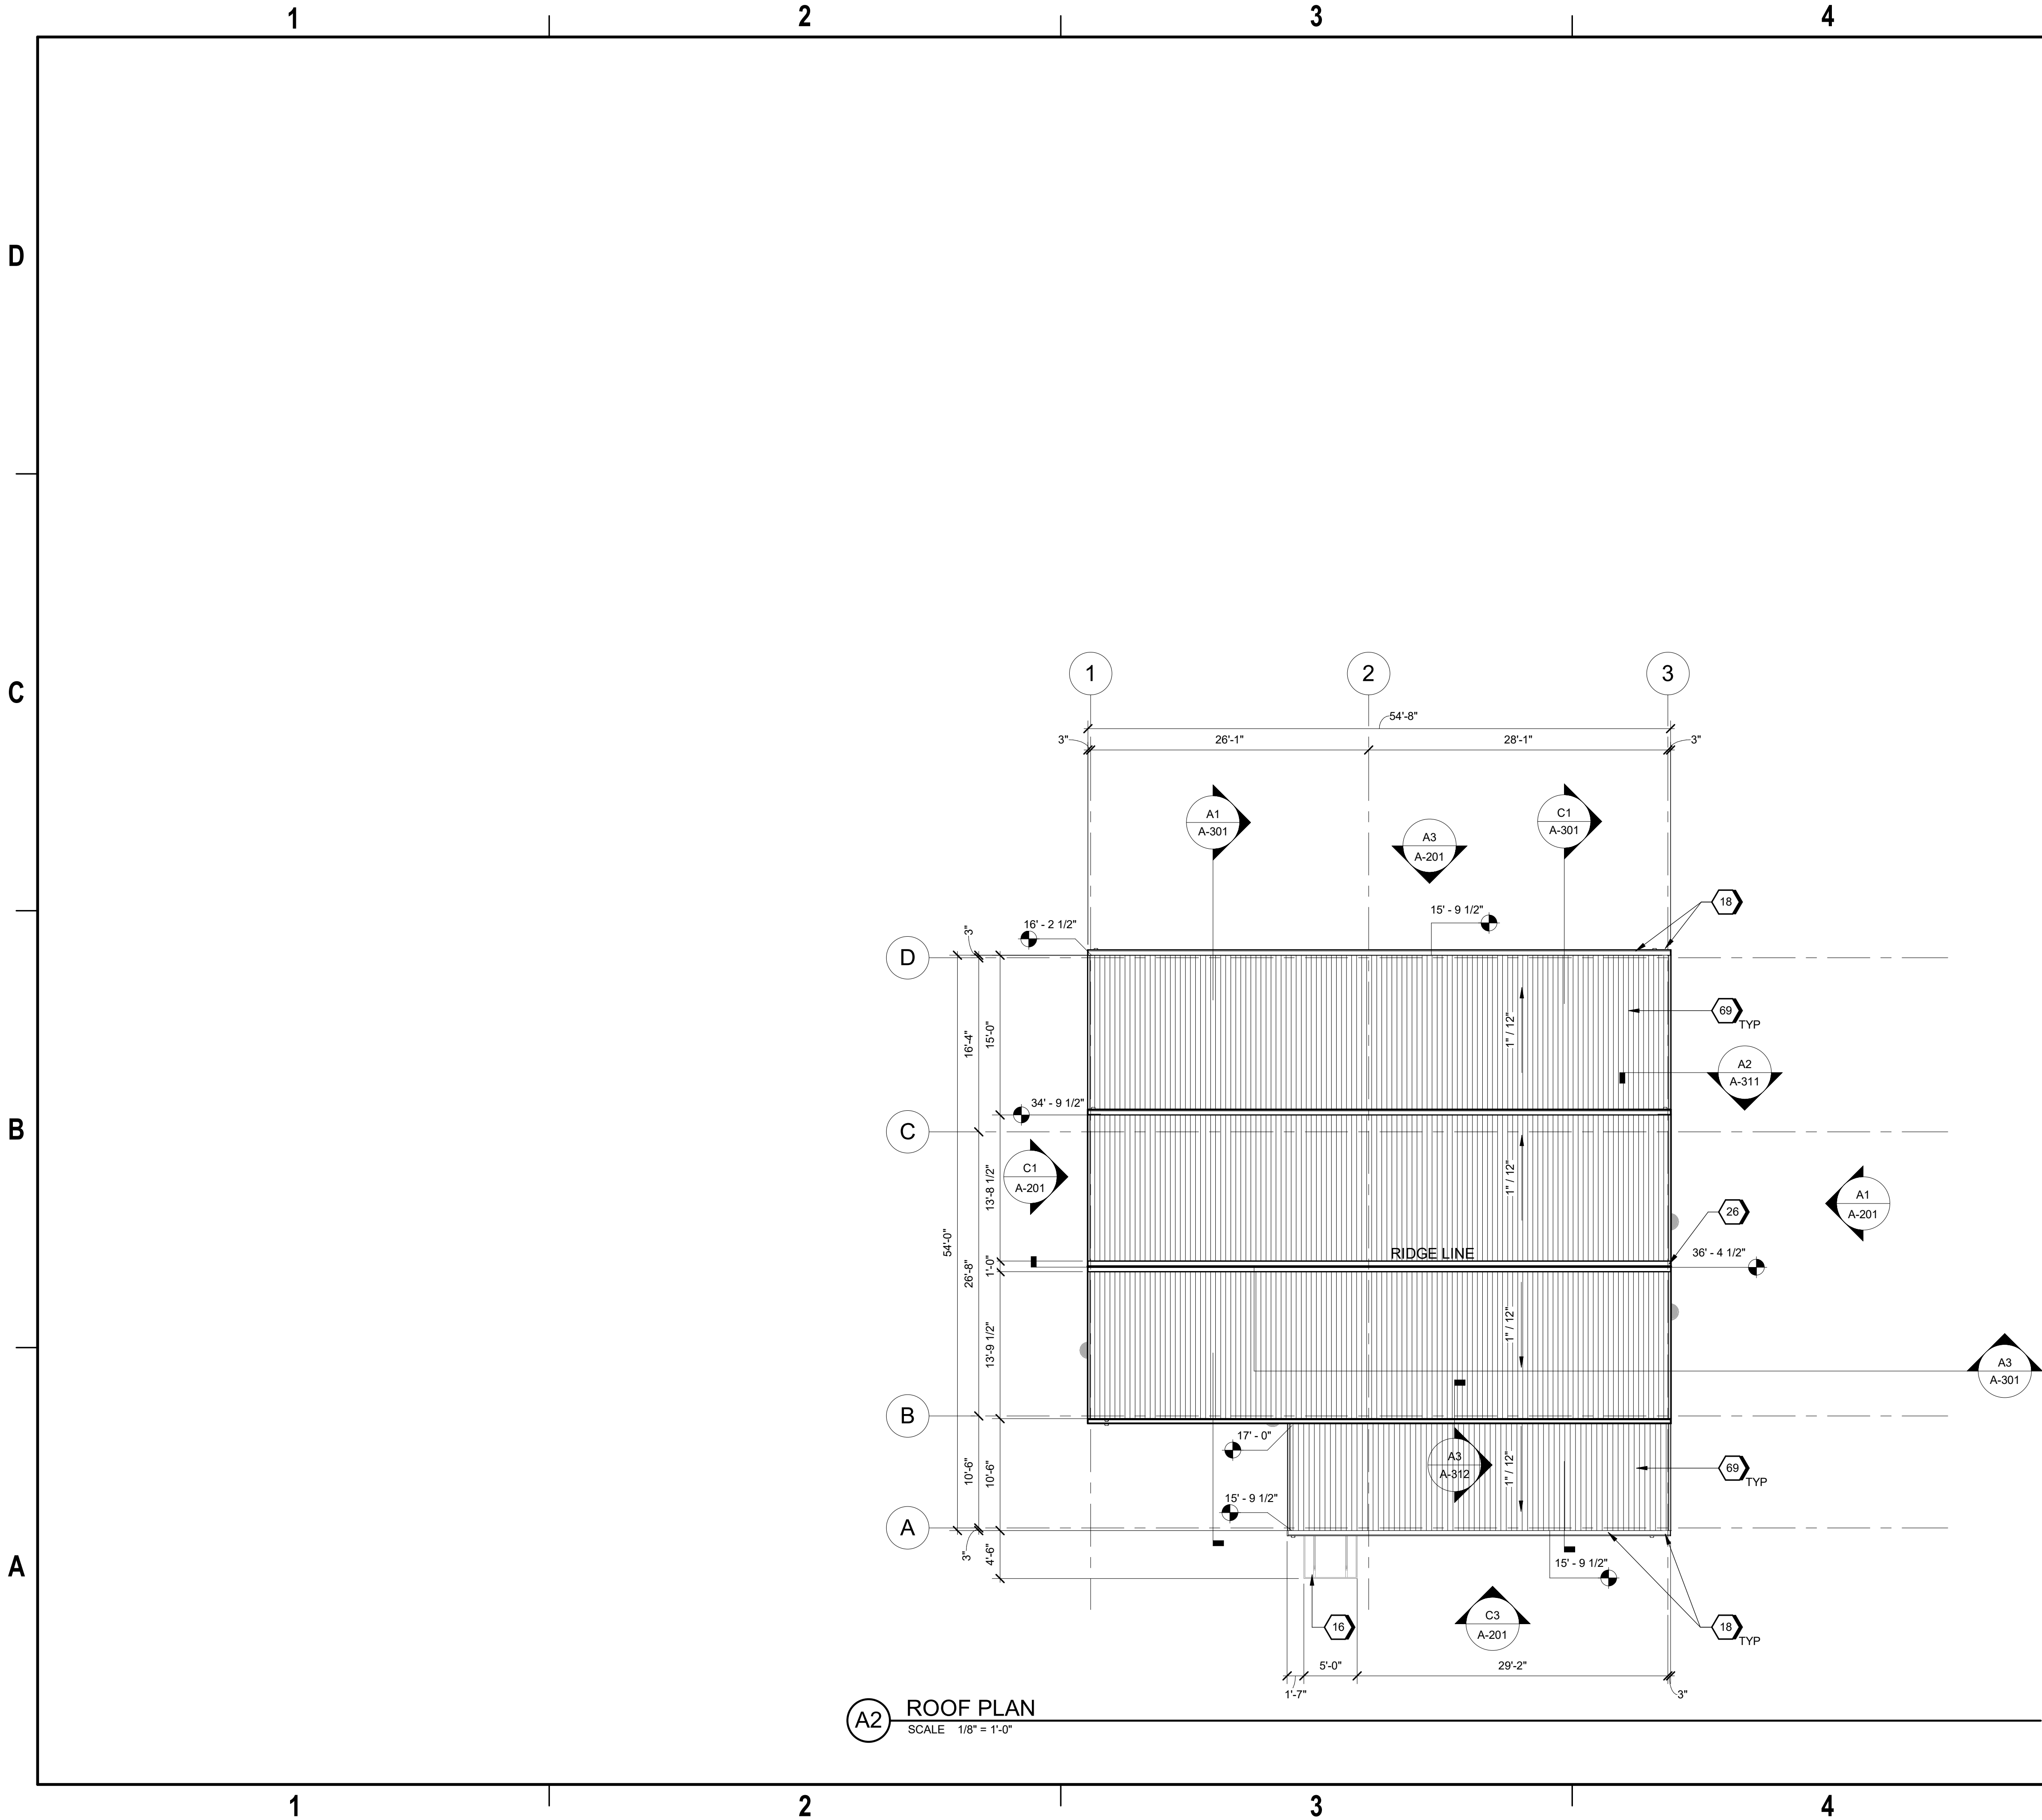


GENERAL SHEET NOTES

A. REFER TO ELECTRICAL FOR LIGHTNING PROTECTION.

#SHEET KEYNOTES

- 16 PRE-FABRICATED METAL CANOPY
18 CONT. METAL GUTTER 5" DEEP X 6" WIDE. COLOR TO MATCH THE BUILDING
26 PEMB; RIDGE CAP
69 RP-3 - REFER TO CAMPUS DETAILS A-800

GRAPHIC SCALE(S)

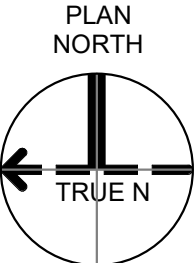

NO.	DATE	BY	APVD	TM
0	09/18/2024	IE	TM	
1		BY	APVD	
2		BY	APVD	
3		BY	APVD	
100		BY	APVD	

Jacobs
1889 Bryan Street Suite 3500 Dallas, TX 75201
Tel: 214-638-0145 Fax: 214-638-0447
Entity: Jacobs Consultants Inc.
License: Professional Engineer
Exp. Date: 01/31/2025



Mixer 1
Camden OSD
Calhoun County, Arkansas
Aerojet Rocketdyne

Jacobs **MABIOZ**
ARCHITECTURE
ROOF PLAN

SHEET NO	AE131
SCALE	As indicated
DATE	09/18/2024
PROJ	D3754502
DWG	CIMDN-OSD_Mixer-Building_1_AE131

PLOT DATE/TIME: 9/18/2024 9:53:27 AM