


9/18/2024 9:53:26 AM
A:\Projects\3754500_FED_Aerojet Rocketdyne\3754500_CADD\OSD_Mixer-Building_1_ARCH\INT.rvt
A:\Projects\3754500_FED_Aerojet Rocketdyne\3754500_CADD\OSD_Mixer-Building_1_ARCH\INT.rvt

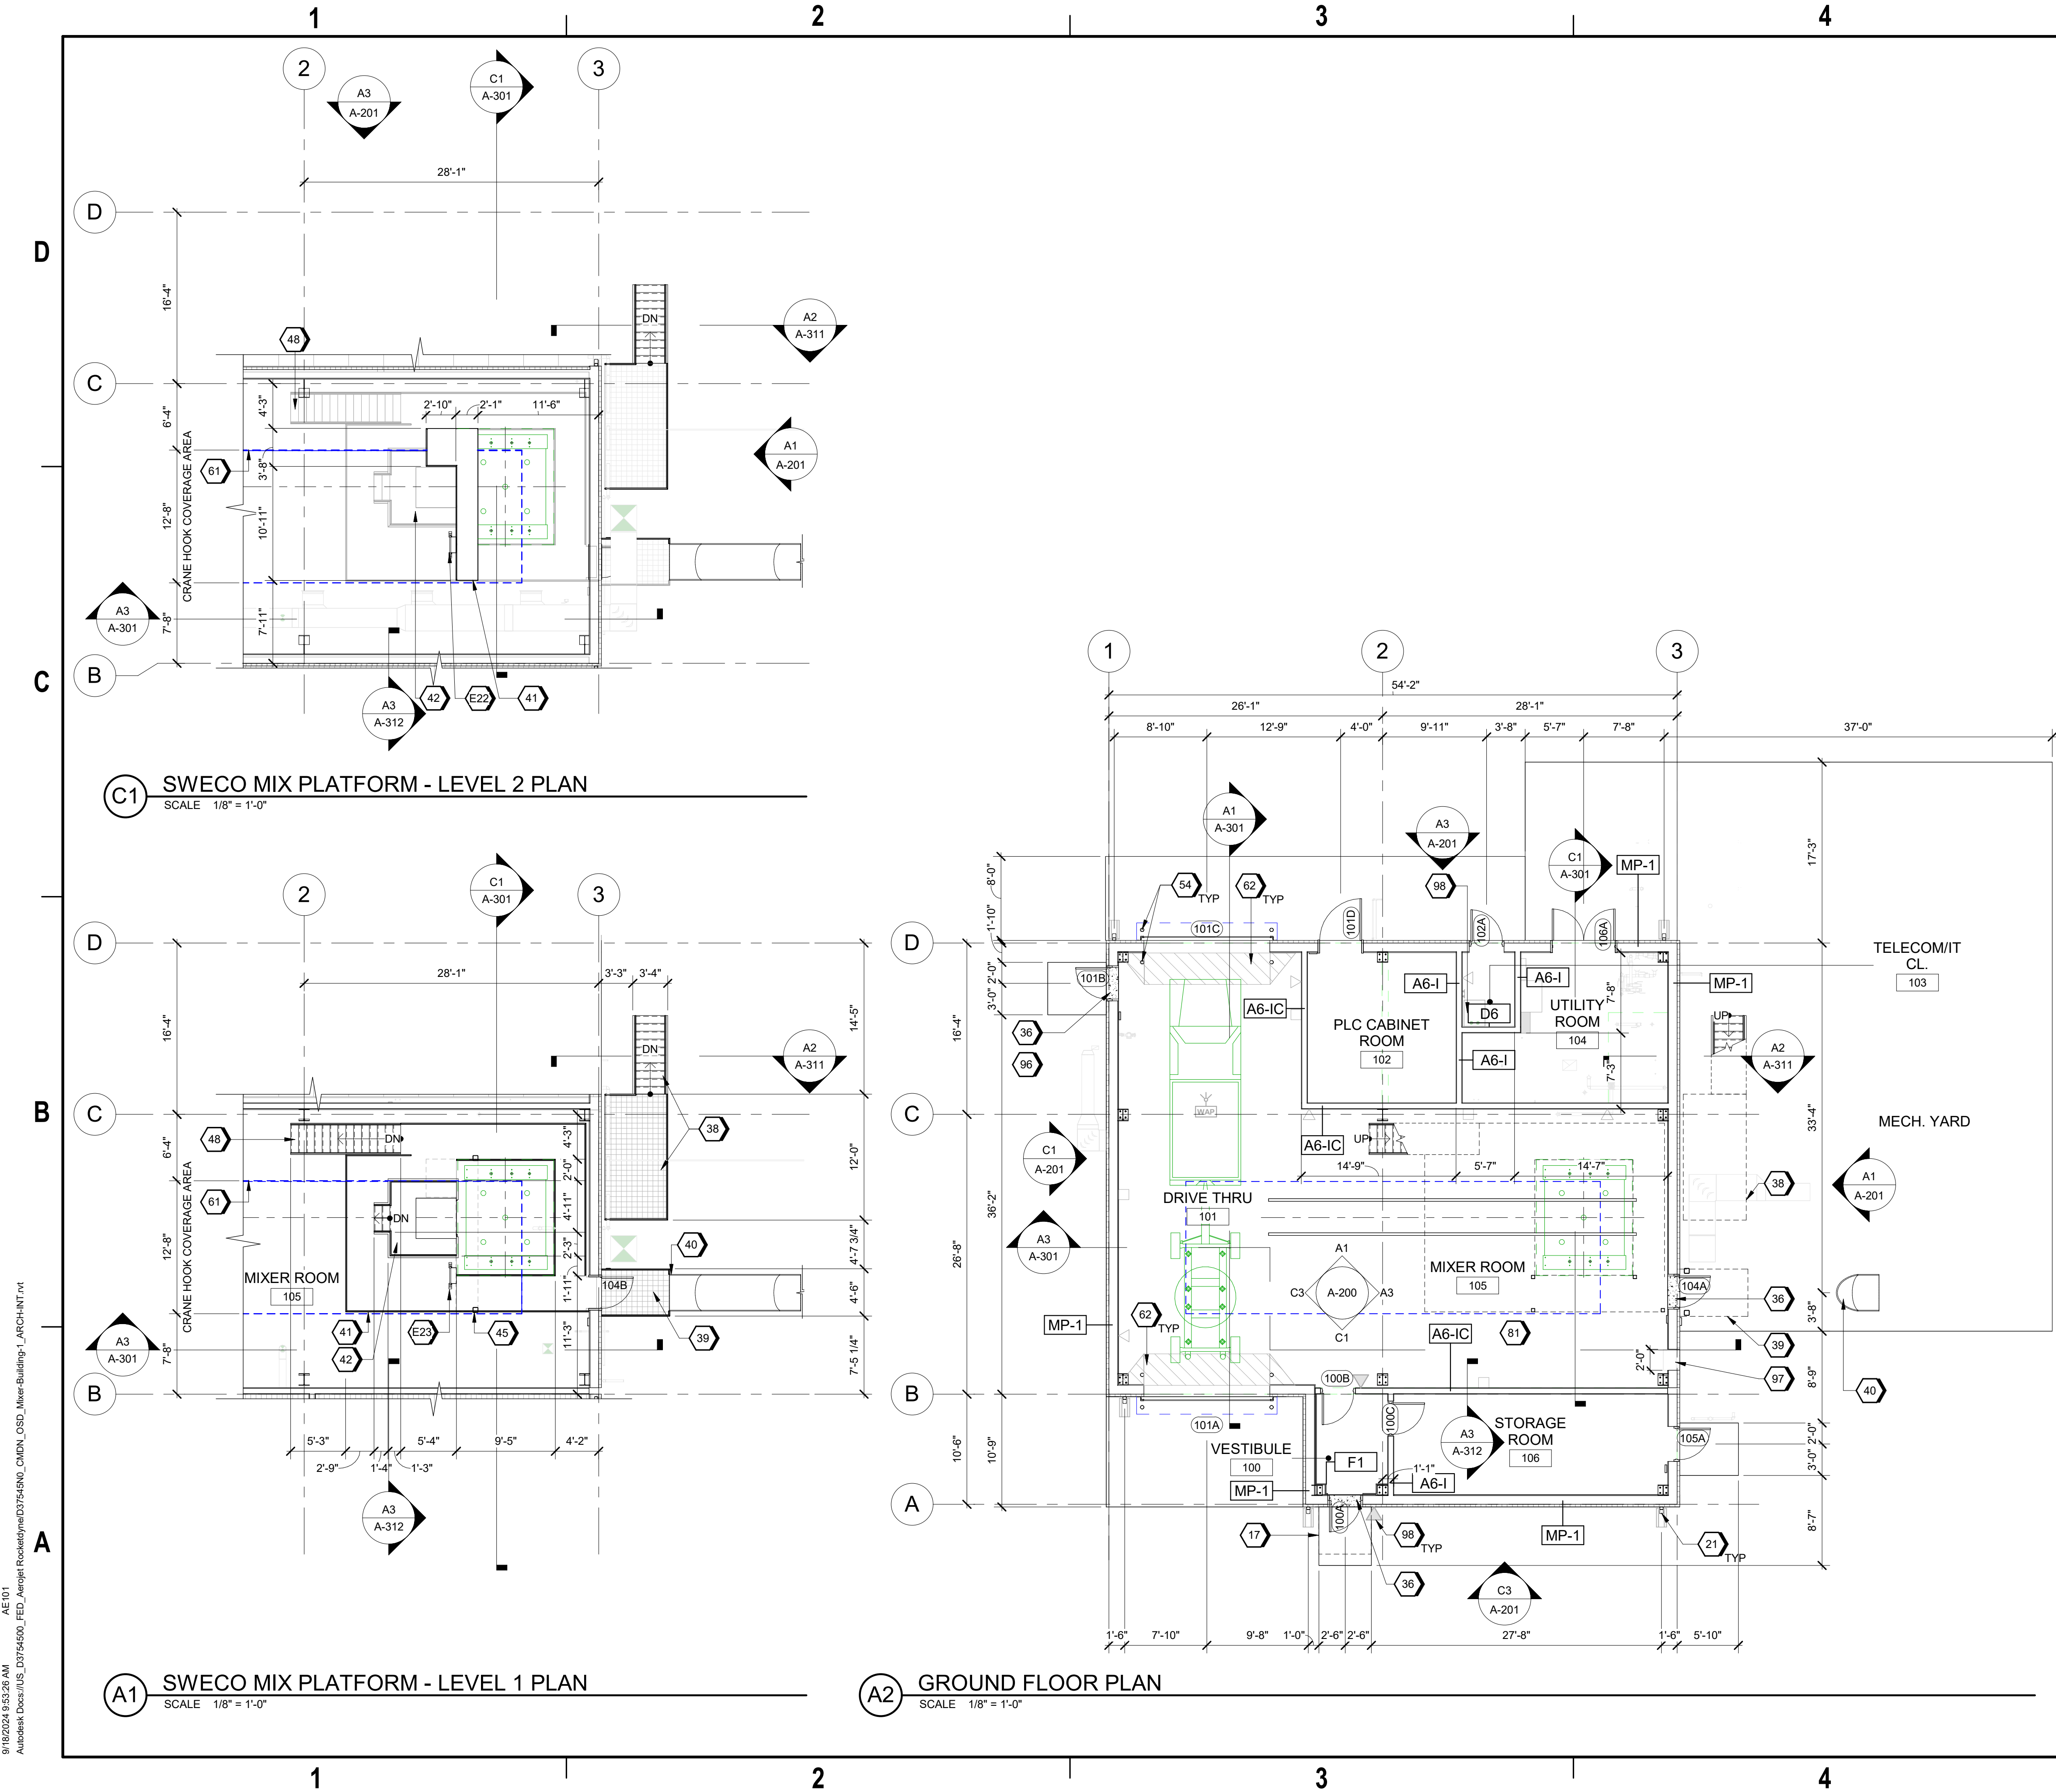


GENERAL SHEET NOTES

- FINISHED FLOOR ELEVATION 0'-0" IS A REFERENCE ELEVATION FOR COORDINATION WITH BUILDING ELEMENTS. ACTUAL ELEVATION IS INDICATED ON CIVIL DRAWINGS.
- FOR ARCHITECTURAL GENERAL NOTES, SYMBOLS, AND LEGEND, REFER TO DRAWING G-003.
- FOR BUILDING CODE DATA AND LIFE SAFETY PLAN, REFER TO DRAWING G-101.
- FOR FURNITURE AND EQUIPMENT, REFER TO EQUIPMENT PLAN SHEET A-150.

SHEET KEYNOTES

- CANOPY OVERHANG ABOVE
- PEMB: SHEET METAL DOWNSPOUT AND BRACKETS - TYP. 5" DIAMETER. COLOR TO MATCH THE BUILDING
- 6"x8" CONCRETE CURB AT DOOR SILL, "REFER TO A-803"
- FILTER PLATFORM AND STAIRS, PLATFORM AND STAIRS ARE DELEGATED DESIGN OF THE STAIR MANUFACTURER
- EMERGENCY ESCAPE PLATFORM
- EMERGENCY ESCAPE SLIDE
- SWECO MIX PLATFORM AND RAILING
- SMALL SWECO STAND
- 42" WIDE EQUIPMENT ACCESS CATWALK AND RAILING
- 32" WIDE EQUIPMENT ACCESS STAIR
- TYP. CONCRETE FILLED GALV STL PIPE BOLLARD, PAINTED SAFETY YELLOW
- CRANE HOOK ENVELOPE (CFCI)
- SPEED BUMP - REFER TO B3/ A-803
- PEMB "X" BRACING - TYPICAL
- FIRE PROTECTION EQUIPMENT - TYPICAL
- MECHANICAL EQUIPMENT - TYPICAL
- TELECOM EQUIPMENT - TYPICAL
- LADDER TO LOWER PLATFORM LEVEL OF DUST COLLECTOR STAND (CFCI)
- LADDER TO UPPER PLATFORM LEVEL OF DUST COLLECTOR STAND (CFCI)

GRAPHIC SCALE(S)

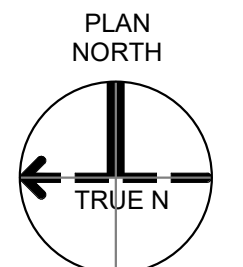

Jacobs
1888 Bryan Street Suite 3000 Dallas, TX 75201
Tel: 214-638-0145 Fax: 214-638-0447
Entity: Jacobs Consultants Inc.
License: Professional Engineer
Exp. Date: 01/31/2025



Mixer 1
Camden OSD
Calhoun County, Arkansas
Aerojet Rocketdyne

Jacobs **MABIOZ**
ARCHITECTURE
FLOOR PLANS

SHEET NO
AE101
SCALE As indicated
DATE 09/18/2024
PROJ D3754502
DWG C:\ADDN\OSD_Mixer-Building_1_AE101

PLOT DATE/TIME: 9/18/2024 9:53:26 AM