



Guard-Post


Aerojet Rocketdyne

Camden OSD


Calhoun County, Arkansas

DPA III SITE EXPANSION - 100% ISSUED FOR CONSTRUCTION

SEPTEMBER 18, 2024

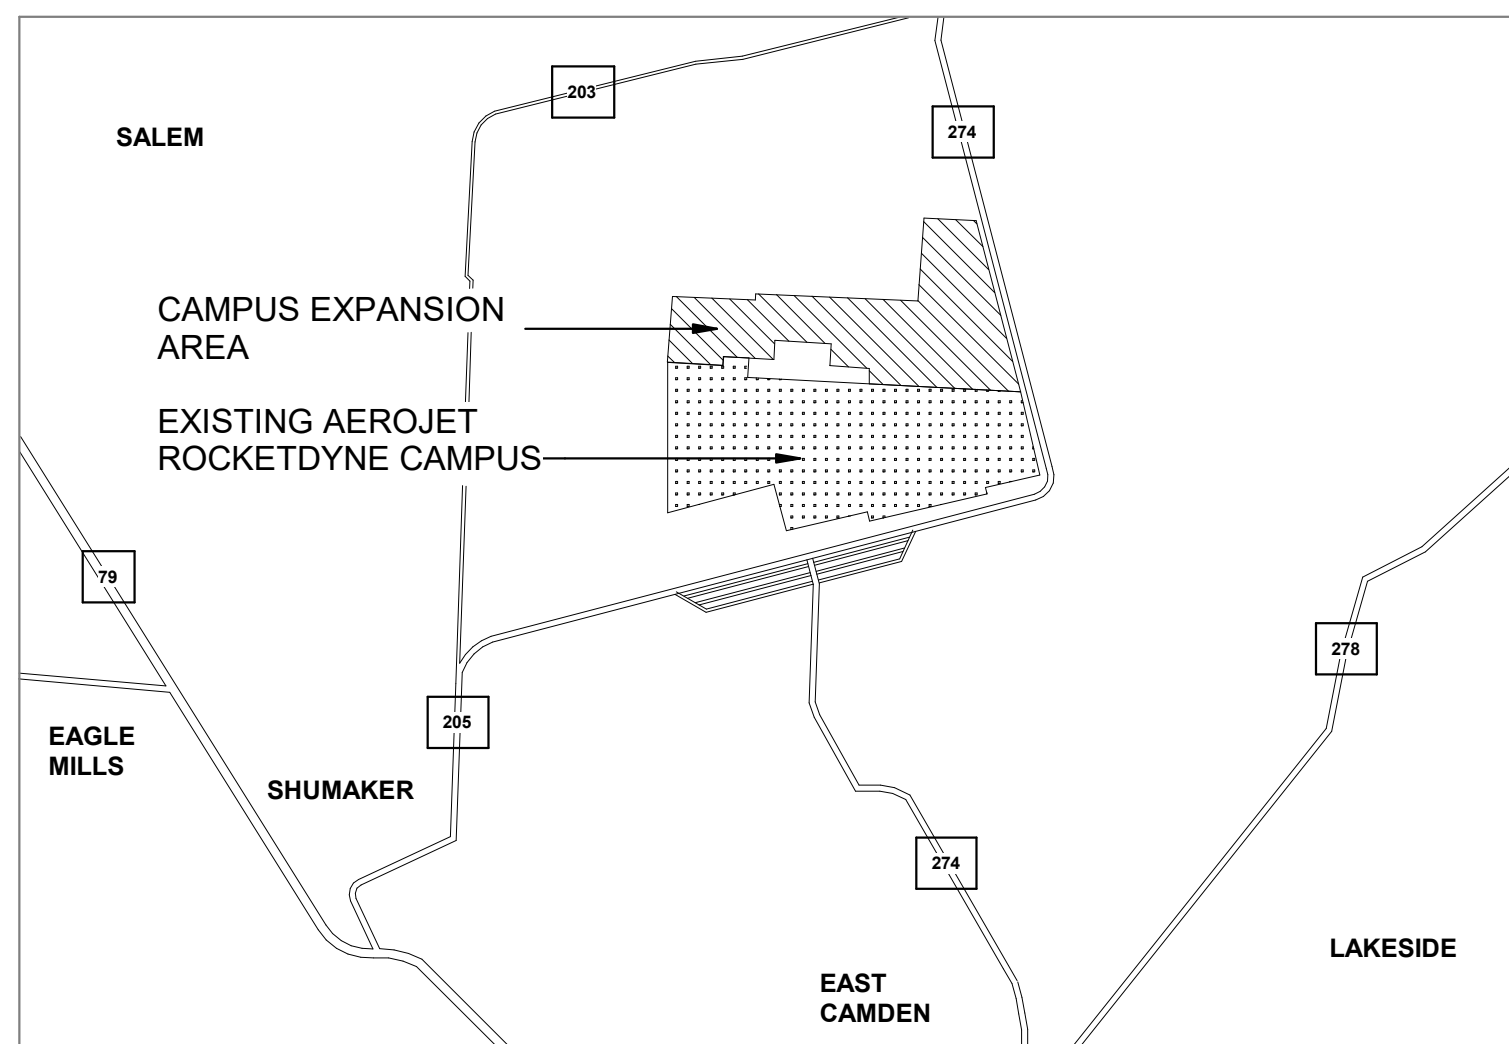

LOCATION MAP

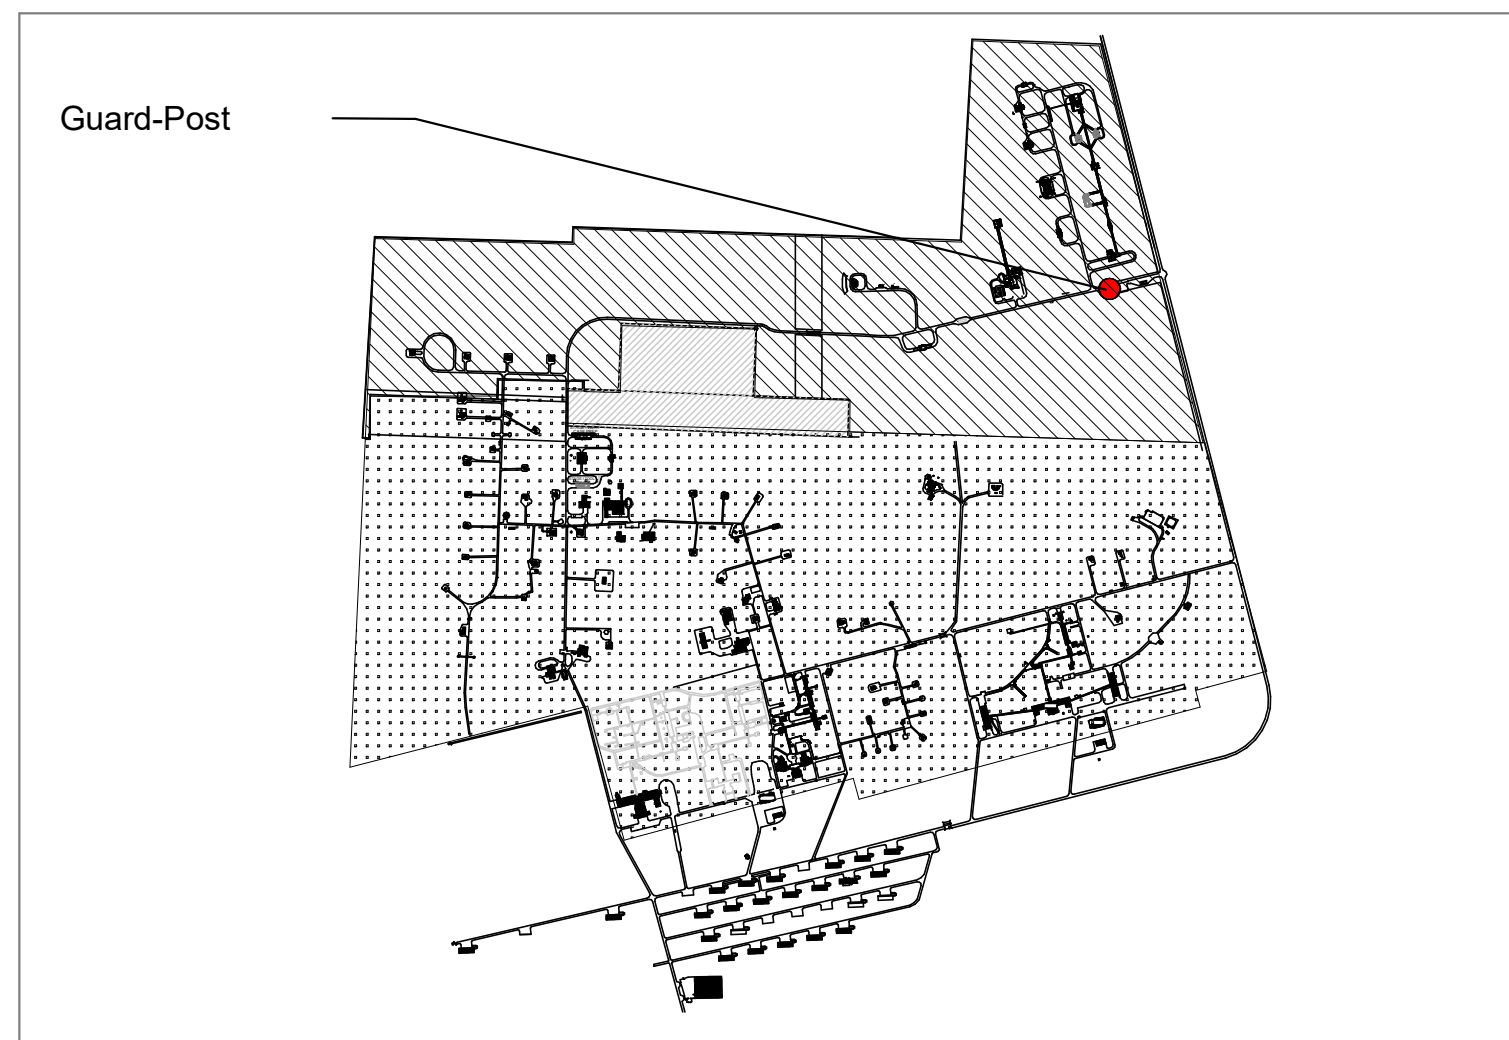

VICINITY MAP

GENERAL SHEET NOTES

- PRE-FABRICATED BUILDING (PREFAB) SYSTEMS IS THE DESIGN INTENT FOR BUILDING STRUCTURE, ENVELOPE, PENETRATIONS, AND ALL ASSOCIATED COMPONENTS FOR FACILITIES INDICATED IN ACCORDANCE WITH THE DIVISION 13 METAL BUILDING OF THE SPECIFICATIONS.
- THE PEMB MANUFACTURER WILL INCORPORATE ALL BUILDING CODE, INDUSTRY STANDARDS, AND OWNER DIRECTED REQUIREMENTS INTO THE DESIGN AND CONSTRUCTION OF THE INDICATED FACILITIES.
- ALL BUILDING MATERIALS ARE NEW AND PROVIDED BY THE PEMB MANUFACTURER.
- VERIFY ALL FIELD CONDITIONS AND DIMENSIONS PRIOR TO PROCEEDING WITH THE WORK. ALL DISCREPANCIES MUST BE BROUGHT TO THE IMMEDIATE ATTENTION OF THE ARCHITECT IN WRITING. OVERALL DIMENSIONS INDICATED ARE TO EXTERIOR FACE OF STRUCTURAL GIRT FRAMING, UNLESS OTHERWISE NOTED.
- STUDY AND COMPARE THE CONTRACT DOCUMENTS WITH EACH OTHER AND AT ONCE, REPORT TO THE ARCHITECT ANY ERRORS, INCONSISTENCIES OR OMISSIONS DISCOVERED.
- DO NOT SCALE THE DRAWINGS FOR CONSTRUCTION PURPOSES.
- VERIFY SIZE, LOCATION, AND CHARACTERISTICS OF ALL EQUIPMENT WITH THE OWNER, MANUFACTURERS, AND SUPPLIERS BEFORE BEGINNING CONSTRUCTION.
- REFER TO GA-SERIES SHEETS FOR TYPICAL CAMPUS EXTERIOR ASSEMBLIES UTILIZED AT EACH BUILDING IN THIS PROJECT SCOPE.
- REFER TO GA-SERIES DRAWINGS FOR TYPICAL CAMPUS DETAILS UTILIZED AT EACH BUILDING IN THIS PROJECT SCOPE.
- FINISH FLOOR ELEVATION OF 0' IS A RELATIVE ELEVATION USED FOR DESIGN COORDINATION, REFER TO CIVIL ENGINEERING DRAWINGS FOR ACTUAL TOPOGRAPHIC ELEVATIONS OF EACH BUILDING, TOPOGRAPHIC ELEVATIONS VARY BETWEEN BUILDINGS.
- REFER TO CIVIL FOR SITE ORIENTATION ON ALL BUILDINGS.

SHEET INDEX

| NO | SHEET NAME |
|------------------------|------------------------------------------------------------------------|
| 10 GENERAL | |
| G-001 | GENERAL - COVER SHEET AND SHEET INDEX |
| G-101 | GENERAL - LIFE SAFETY PLAN AND CODE REQUIREMENTS |
| 70 STRUCTURAL | |
| S-501 | STRUCTURAL DETAILS |
| SB101 | STRUCTURAL - FOUNDATION PLAN |
| 80 ARCHITECTURE | |
| AE101 | ARCHITECTURE - FLOOR PLAN |
| 130 PLUMBING | |
| P-001 | GENERAL NOTES AND SYMBOLS |
| P-100 | GROUND FLOOR SANITARY PLAN |
| 160 ELECTRICAL | |
| EP101 | ELECTRICAL - POWER PLAN, GROUNDING PLAN, SCHEDULE AND ONE-LINE DIAGRAM |
| 170 TELECOMMUNICATIONS | |
| T-001 | TELECOMMUNICATION - GENERAL NOTES, ABBREVIATIONS AND SYMBOLS |
| T-101 | TELECOMMUNICATION - SITE PLAN |
| T-102 | TELECOMMUNICATION - FLOOR PLAN |
| T-601 | TELECOMMUNICATION - ONE-LINE DIAGRAM |
| 180 SECURITY | |
| TY001 | SECURITY - GENERAL NOTES, ABBREVIATIONS AND SYMBOLS |
| TY101 | SECURITY - DEVICE LAYOUT FLOOR PLAN |
| TY501 | SECURITY - INSTALLATION DETAILS |
| TY601 | SECURITY - ONE-LINE DIAGRAM |



1888 Bryan Street Suite 1900 Dallas, TX 75201
Tel: 214-638-0145 Fax: 214-638-0447
Entity: Jacobs Consulting Inc.
License: Professional Engineer
Exp. Date: 01/31/2025

Guard-Post
Camden OSD
Calhoun County, Arkansas
Aerojet Rocketdyne



GENERAL
COVER SHEET AND SHEET INDEX

SHEET NO

G-001

SCALE As indicated

DATE 09/18/2024

PROJ D3754502

DWG CAMDEN OSD - Guard-Post - G-001

PLOT DATE/TIME: 9/18/2024 9:51:14 AM