


SEQUENCE OF OPERATIONS,
PROGRAMMING, AND ALL
CONTROL DEVICES PROVIDED
BY L&H AIRCO AND INSTALLED
AT EQUIPMENT FACTORY.

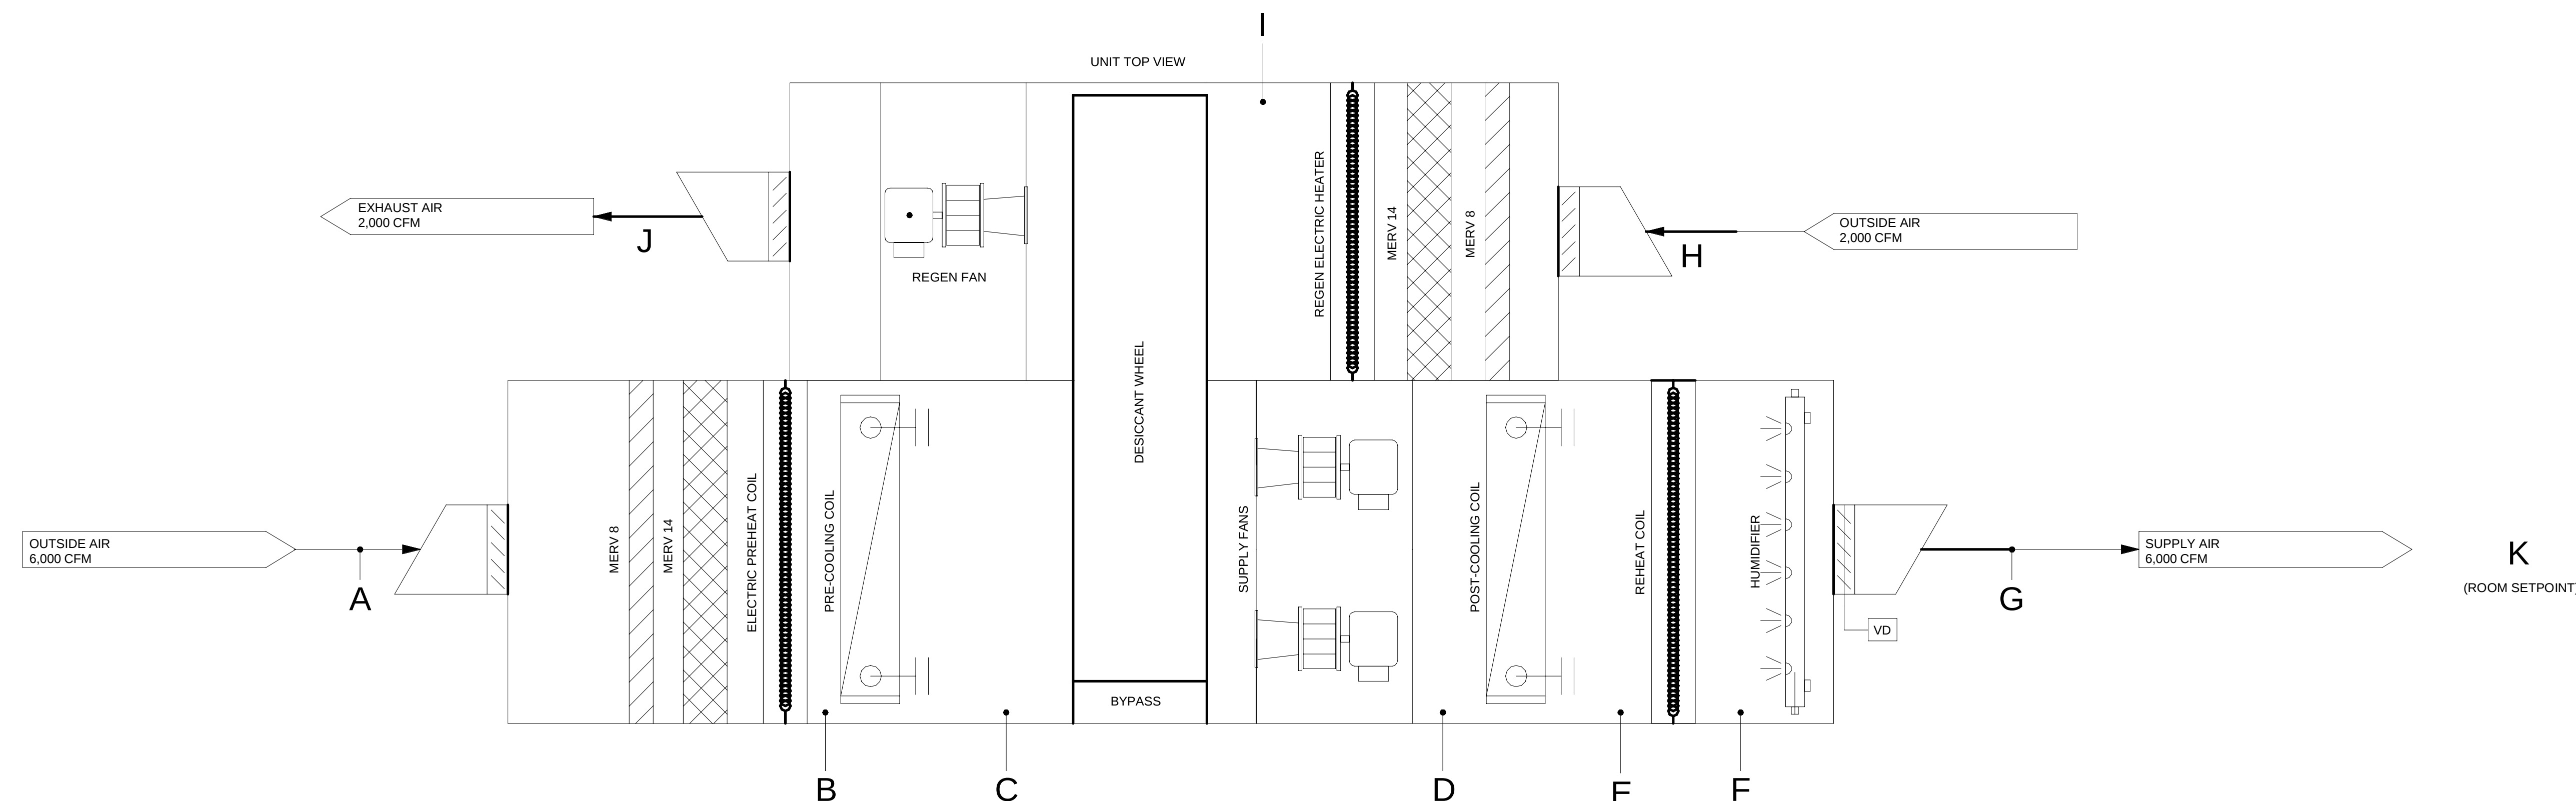

UNIT OPERATION - SUMMER											
	A	B	C	D	E	F	G	H	I	J	K
DB (°F)	105	105	54.5	99.9	53.3	53.3	53.3	105	250	119.6	70
WB (°F)	93	93	54.5	62.0	42.4	42.4	42.4	93	112.9	105	53
RH (%)	64	64	100	8.0	38	38	38	64	2.4	61	30
GRAINS/LB	214	214	62.9	22.8	22.8	22.8	22.8	214	214	314	32.5
ENTHALPY (BTU/LB)	58.5	58.5	22.8	27.5	16.3	16.3	16.3	58.5	94.4	77.8	21.8
FLOWRATE (CFM)	6,000	6,000	6,000	6,000	6,000	6,000	6,000	2,000	2,000	2,000	6,000


[illegible][illegible]

SPACE REQUIREMENTS		
STATE POINTS	WINTER MIN	SUMMER MAX
DB (°F)	70	70
RH (%)	>20%	N/A
GRAINS/LB	N/A	<40

	STEAM FLOWRATE (LB/HR)	STEAM PRESSURE (PSIG)
STEAM DISP. COIL	125	15

[illegible]

Jacobs
999 Bryan Street Suite 3500 Dallas, TX 75201
et. 214-638-0145 Fax: 214-638-0447
Entity: Jacobs Engineering Group Inc.
License Type: Engineering
License #: 176
Exp. Date: 12/31/2024

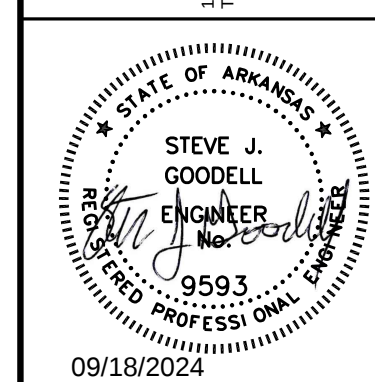

Mixer-Building-1
Camden OSD
Calhoun County, Arkansas
Aerojet Rocketdyne

Jacobs  **NABHOLZ**

MECHANICAL
MDU-1 STATE POINTS

SHEET NO.

MI-101

SCALE	12" = 1'-0"
DATE	09/18/2024
PROJ	D3754502
DWG	CMDN-QSD_Muex-Building-1_M8-101

PLOT DATE/TIME: 9/17/2024 10:01:28 PM