


FOR REFERENCE ONLY

CAMPUS VIEW TO IDENTIFY BUILDING LOCATIONS

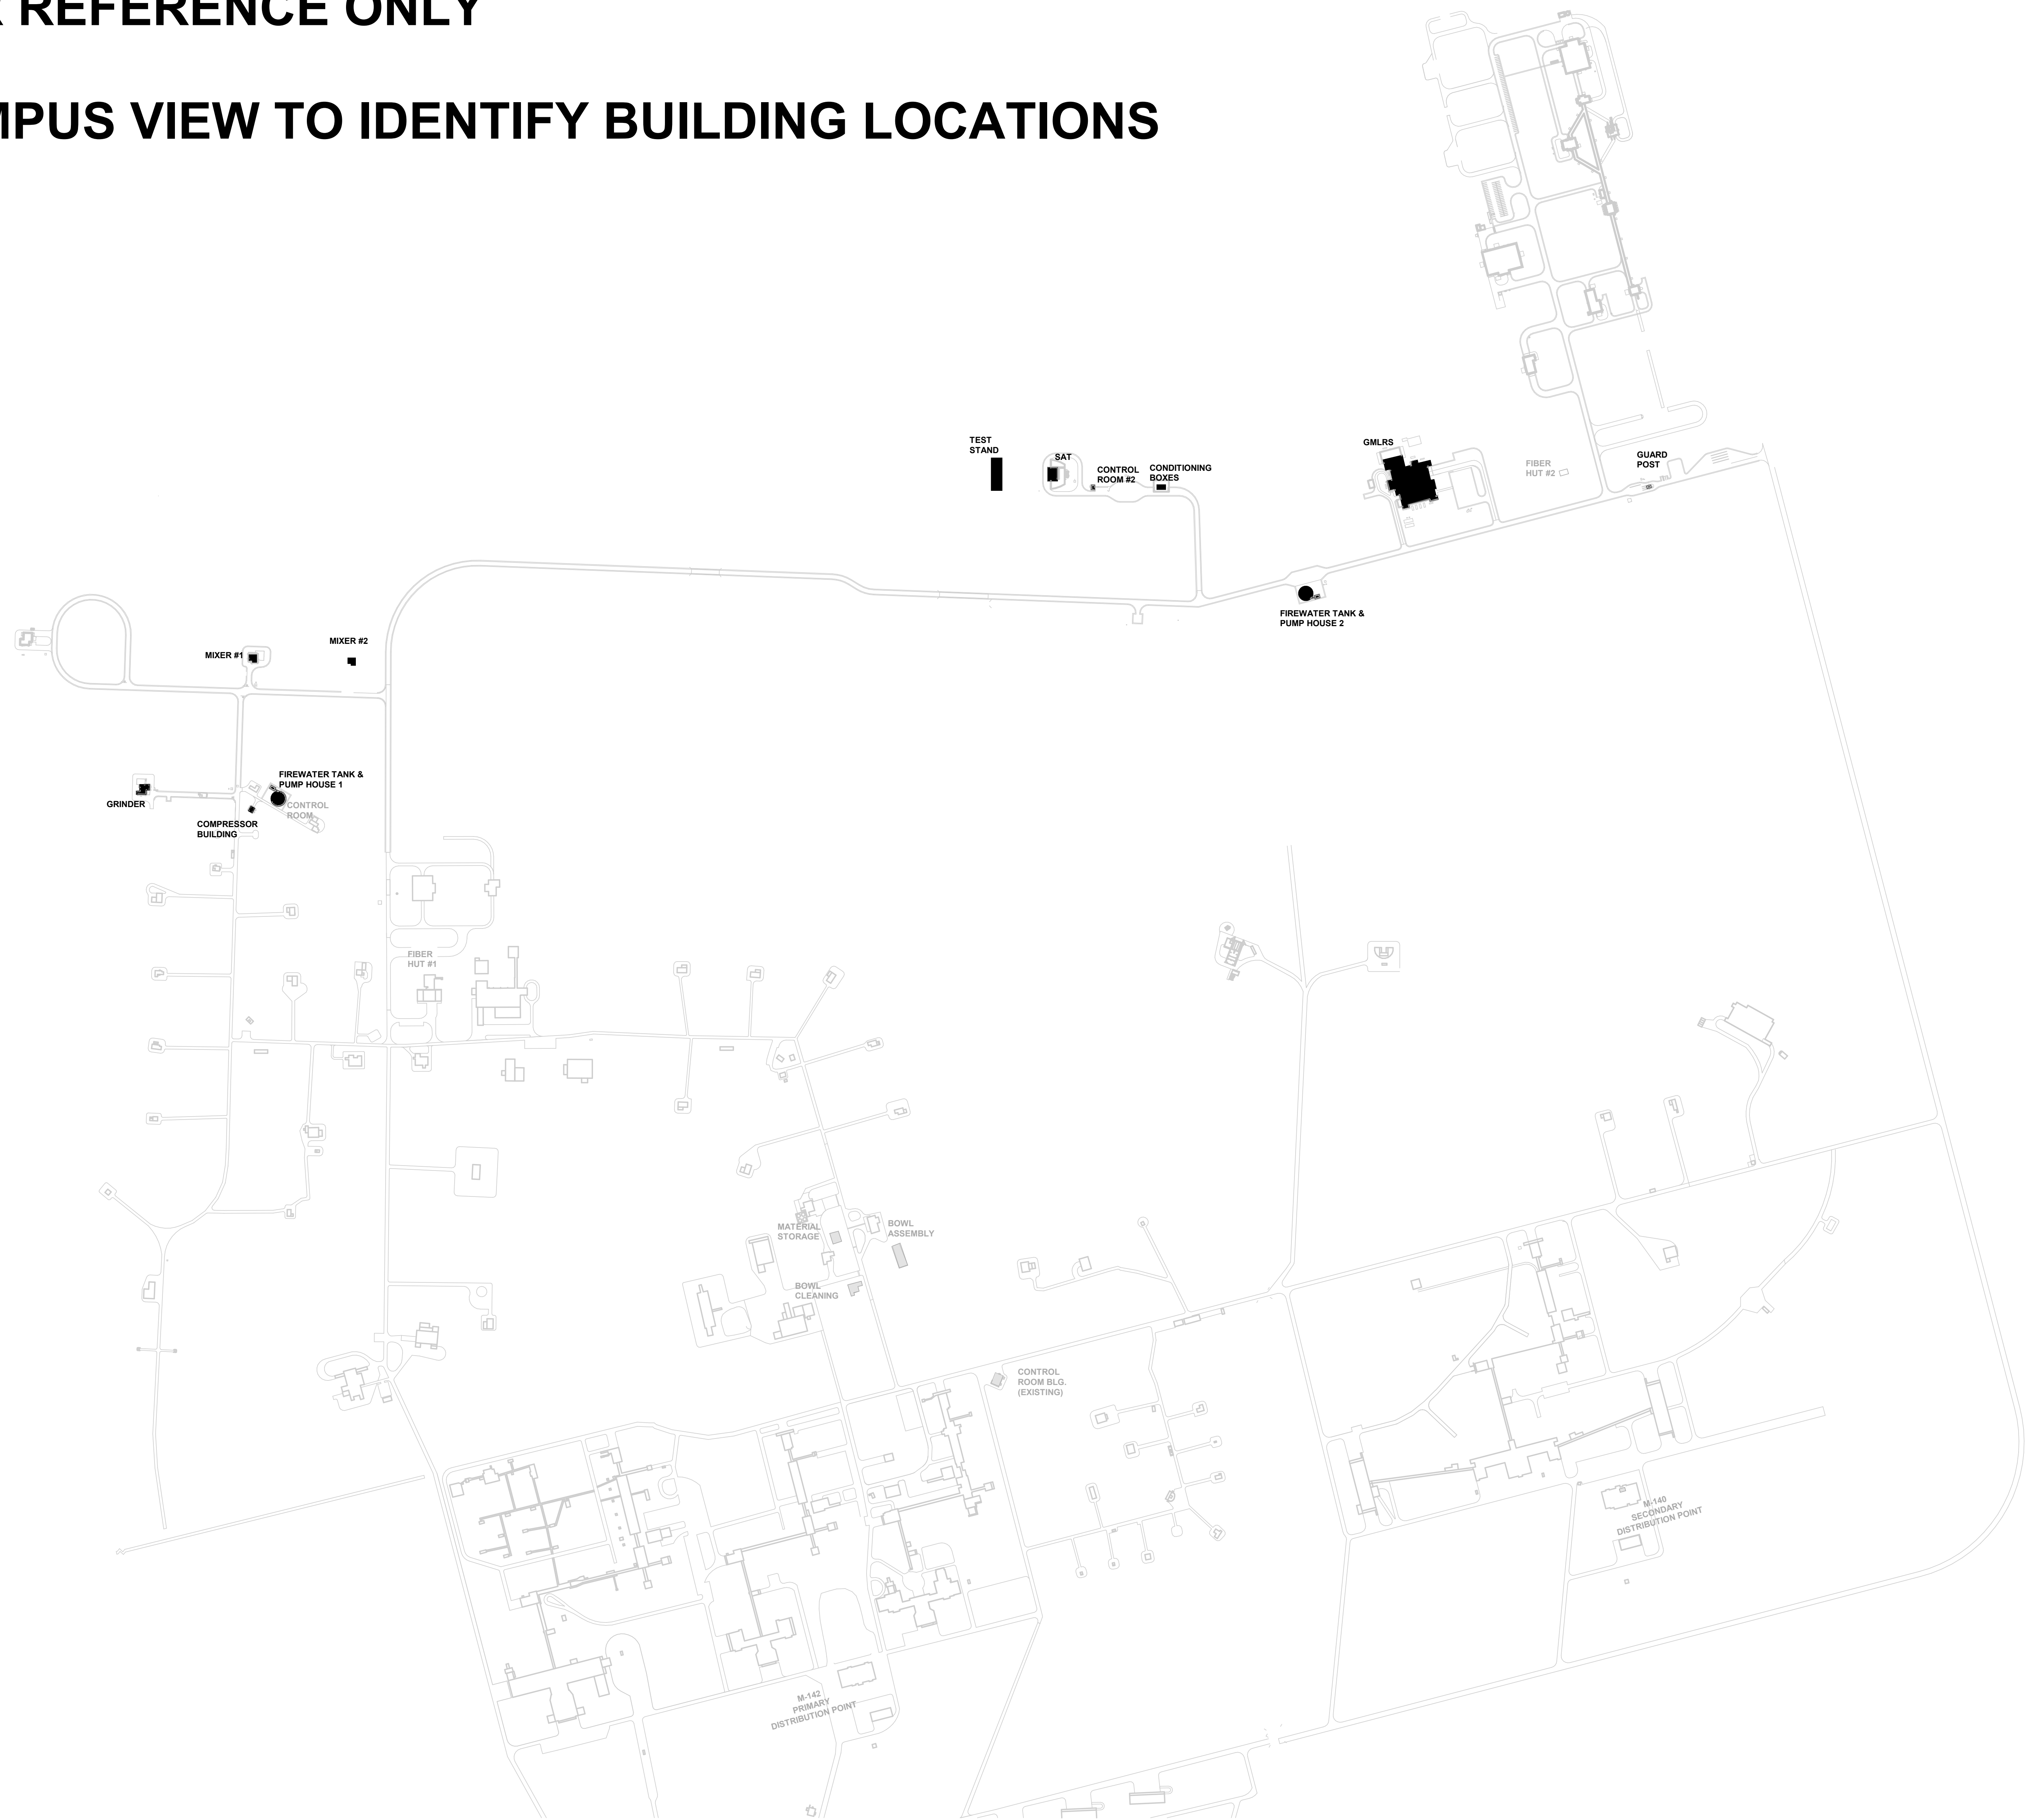


A1 TELECOM SITE PLAN - SITE DEVELOPMENT - REFERENCE VIEW

SCALE 1" = 500'

GRAPHIC SCALE(S)

1" = 500'-0" 0 500' 1000' 1500'

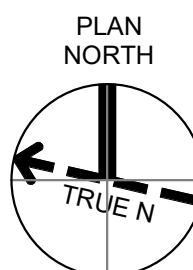

SITE DEVELOPMENT
Camden OSD
Calhoun County, Arkansas
Aerojet Rocketdyne

TELECOMMUNICATIONS SITE PLAN

SHEET NO		T-101
SCALE	1" = 500'	
DATE	09/18/2024	
PROJ	D3754502	
DWG	COMMUNICATIONS SITE PLAN	

DESIGN		NO.	DATE	DR	BY	APPROVED	MT
REVISION		NO.	DATE	DR	BY	APPROVED	MT
100% ISSUED FOR CONSTRUCTION - EXPANSION		0	09/18/2024	BP	BP	APPROVED	MT

Jacobs

19950 Bayview Road, Suite 3000
Dallas, TX 75224
Phone: 214.776.7200
Fax: 214.776.7201
Email: Jacobs Engineering Group, Inc.
License Type: Engineering License Exp. Date: 12/31/2024

REGISTERED COMMUNICATIONS DISTRIBUTION ENGINEER
Bicsi
Robert A. Pritchard
BICSITD # 4-107014
EXPIRES 12-31-25
RCCD

