

9/16/2024 12:30:38 PM  
Address: Docs\US\_D0754502\_FED\_Aerojet Rocketdyne\03754502\_CIMDN\_OSD\_Mixer-Building\_1\_TCOM-SEC.rvt


1 2 3 4 5

D

C

B

A

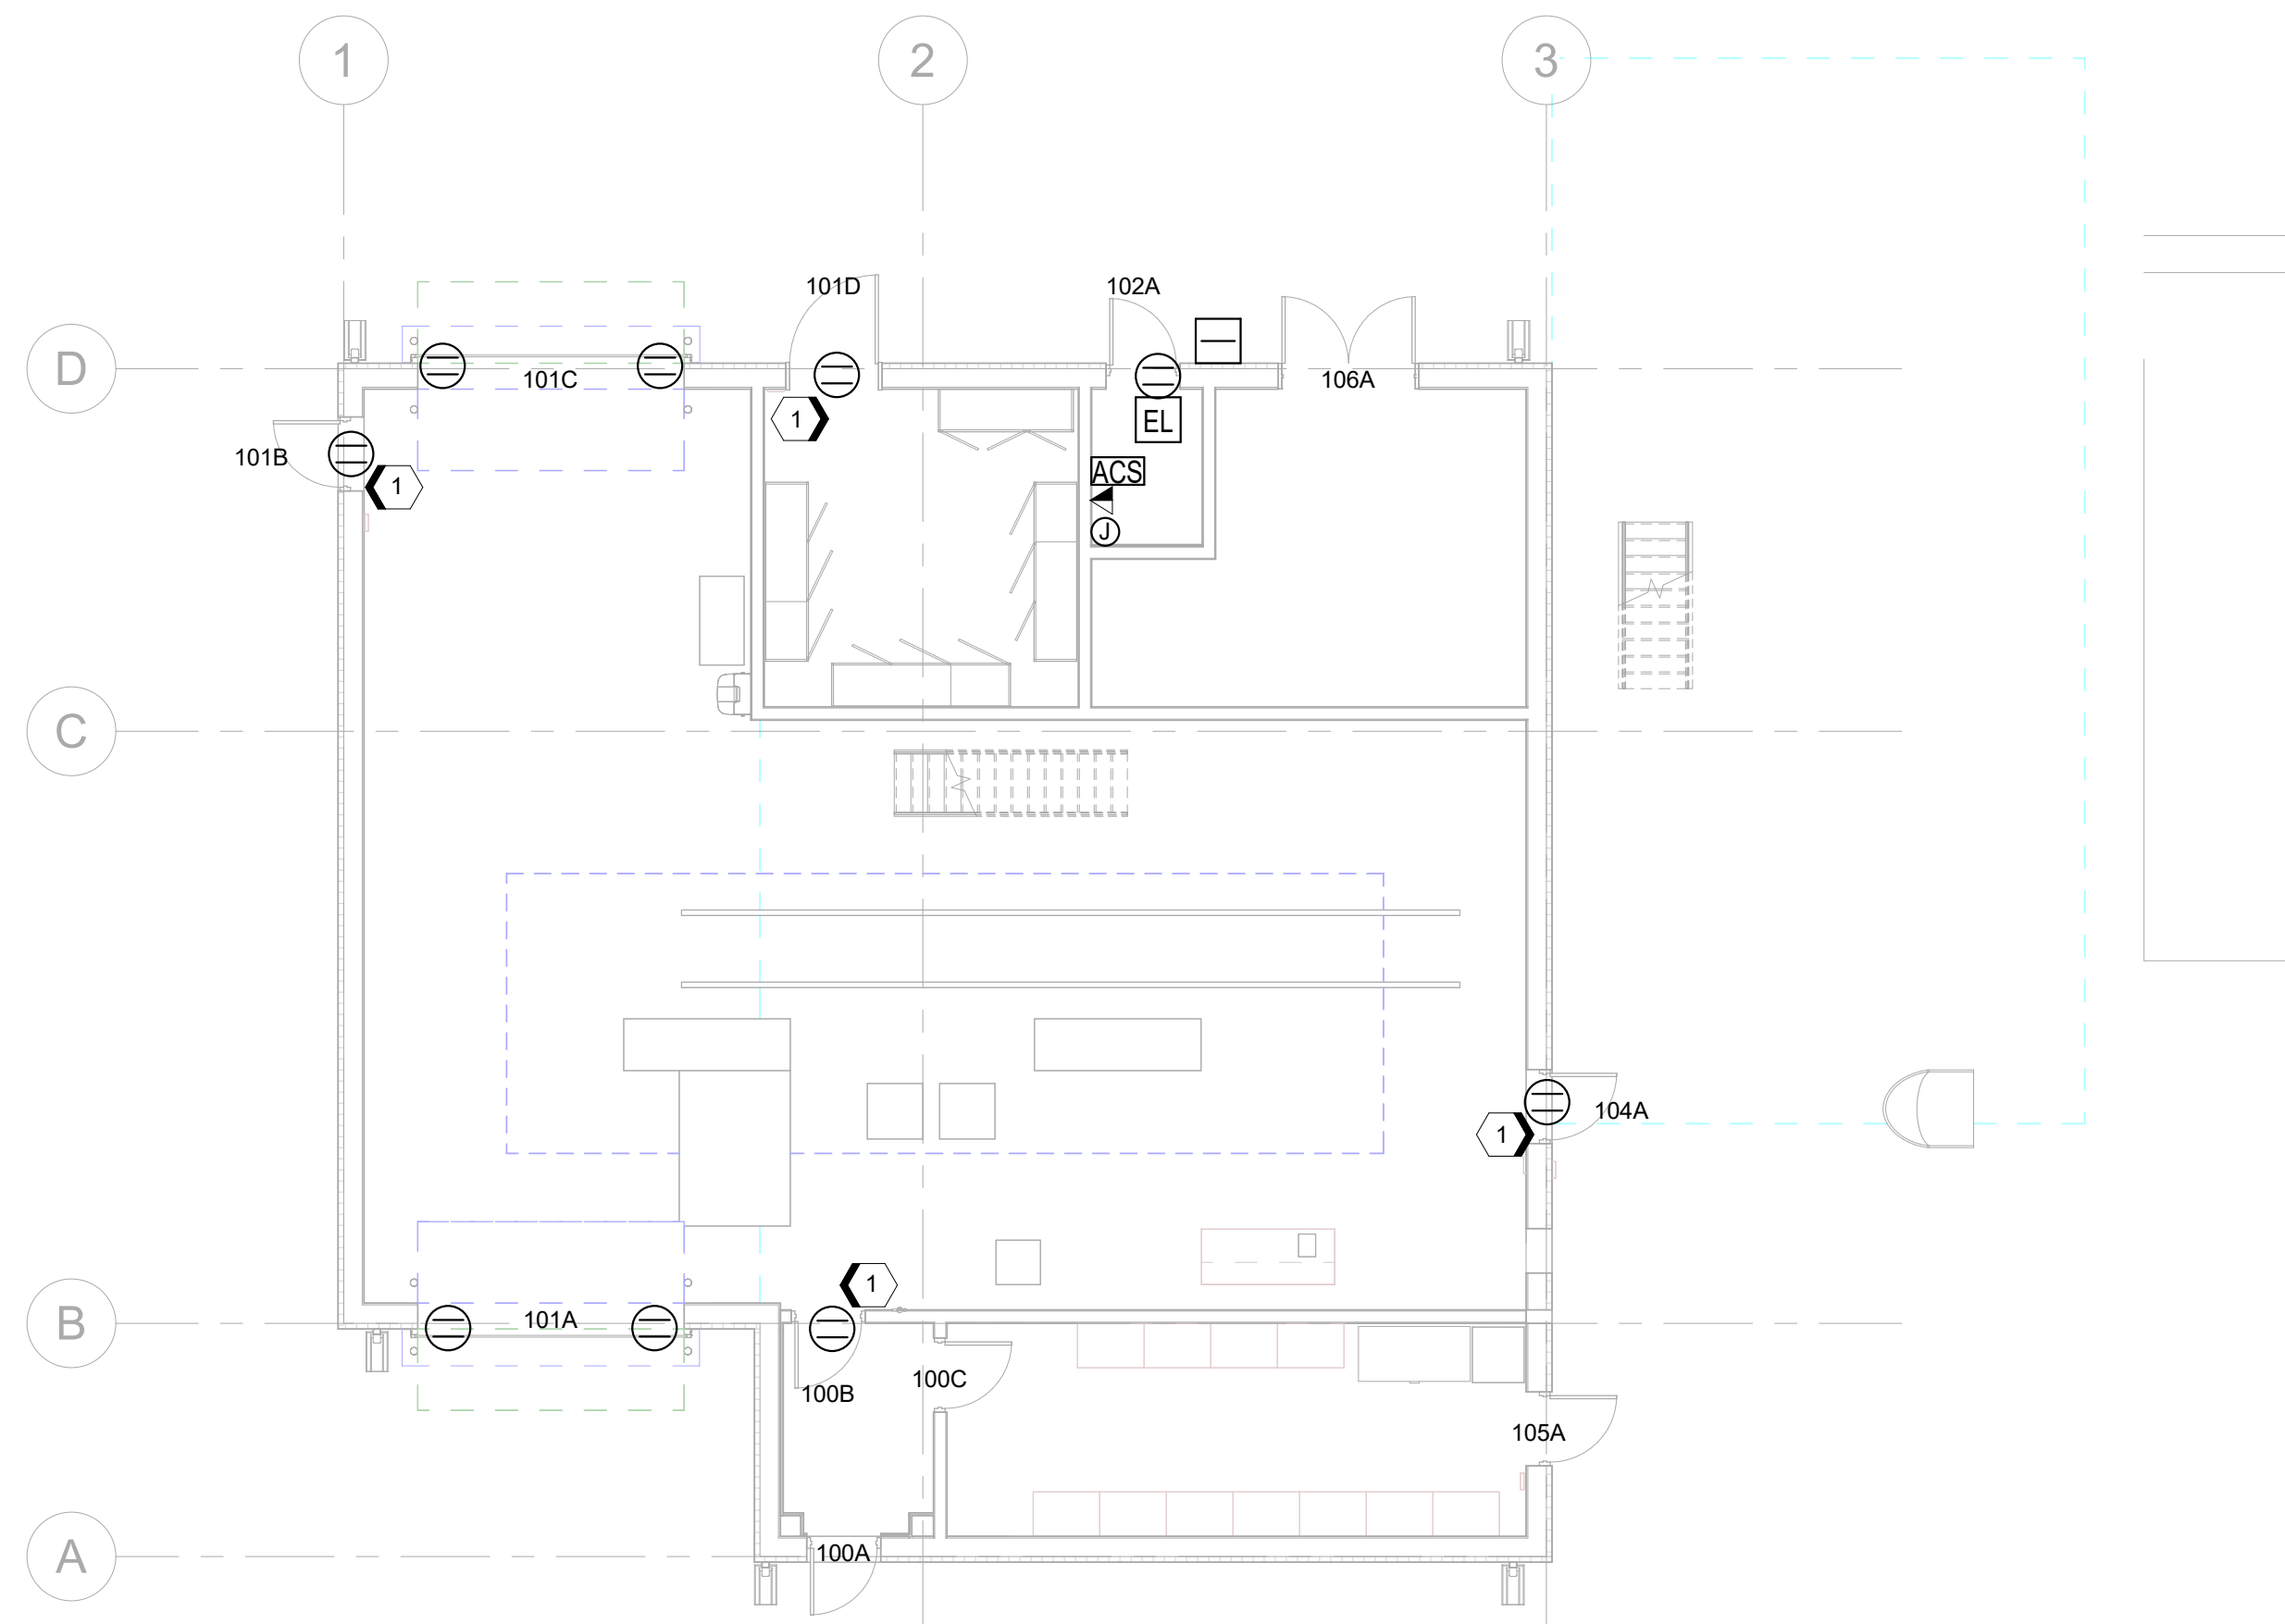

**A1** GROUND FLOOR ELECTRONIC SECURITY SYSTEM PLAN  
SCALE 1/8" = 1'-0"

**#) SHEET KEYNOTES**

1. PROVIDE 18/4C+22/3POAS+22/2C+22/4C - YELLOW COMPOSITE CABLE FROM THE JUNCTION BOX ABOVE THE DOOR TO THE ACS.



**Jacobs**  
1999 Bryan Street, Suite 3500, Dallas, TX 75201  
Tel: 214-638-0145 Fax: 214-638-0447  
Entity: Jacobs Engineering Group Inc.  
License No. 00000000000000000000  
License Exp. Date: 02/27/2024



Mixer 1 & 2  
Camden OSD  
Calhoun County, Arkansas  
Aerojet Rocketdyne

**Jacobs** **MABIOIZ**  
SECURITY  
GROUND FLOOR DEVICE LAYOUT  
FLOOR PLAN

**GRAPHIC SCALE(S)**

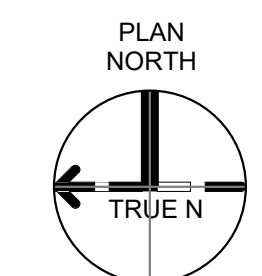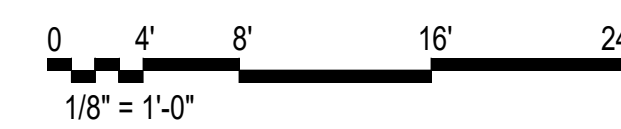

SHEET NO	
TY101	
SCALE	1/8" = 1'-0"
DATE	09/18/2024
PROJ	D3754502
DWG	CIMDN-OSD_Mixer-Building_1_TY101

PLOT DATE/TIME: 9/16/2024 12:30:38 PM

REUSE OF DOCUMENTS AND THE INFORMATION CONTAINED HEREIN IS UNAUTHORIZED. ANY REUSE OF THIS INFORMATION WITHOUT THE WRITTEN AUTHORIZATION OF JACOBS IS PROHIBITED. © Jacobs 2024. ALL RIGHTS RESERVED.

1 2 3 4 5