


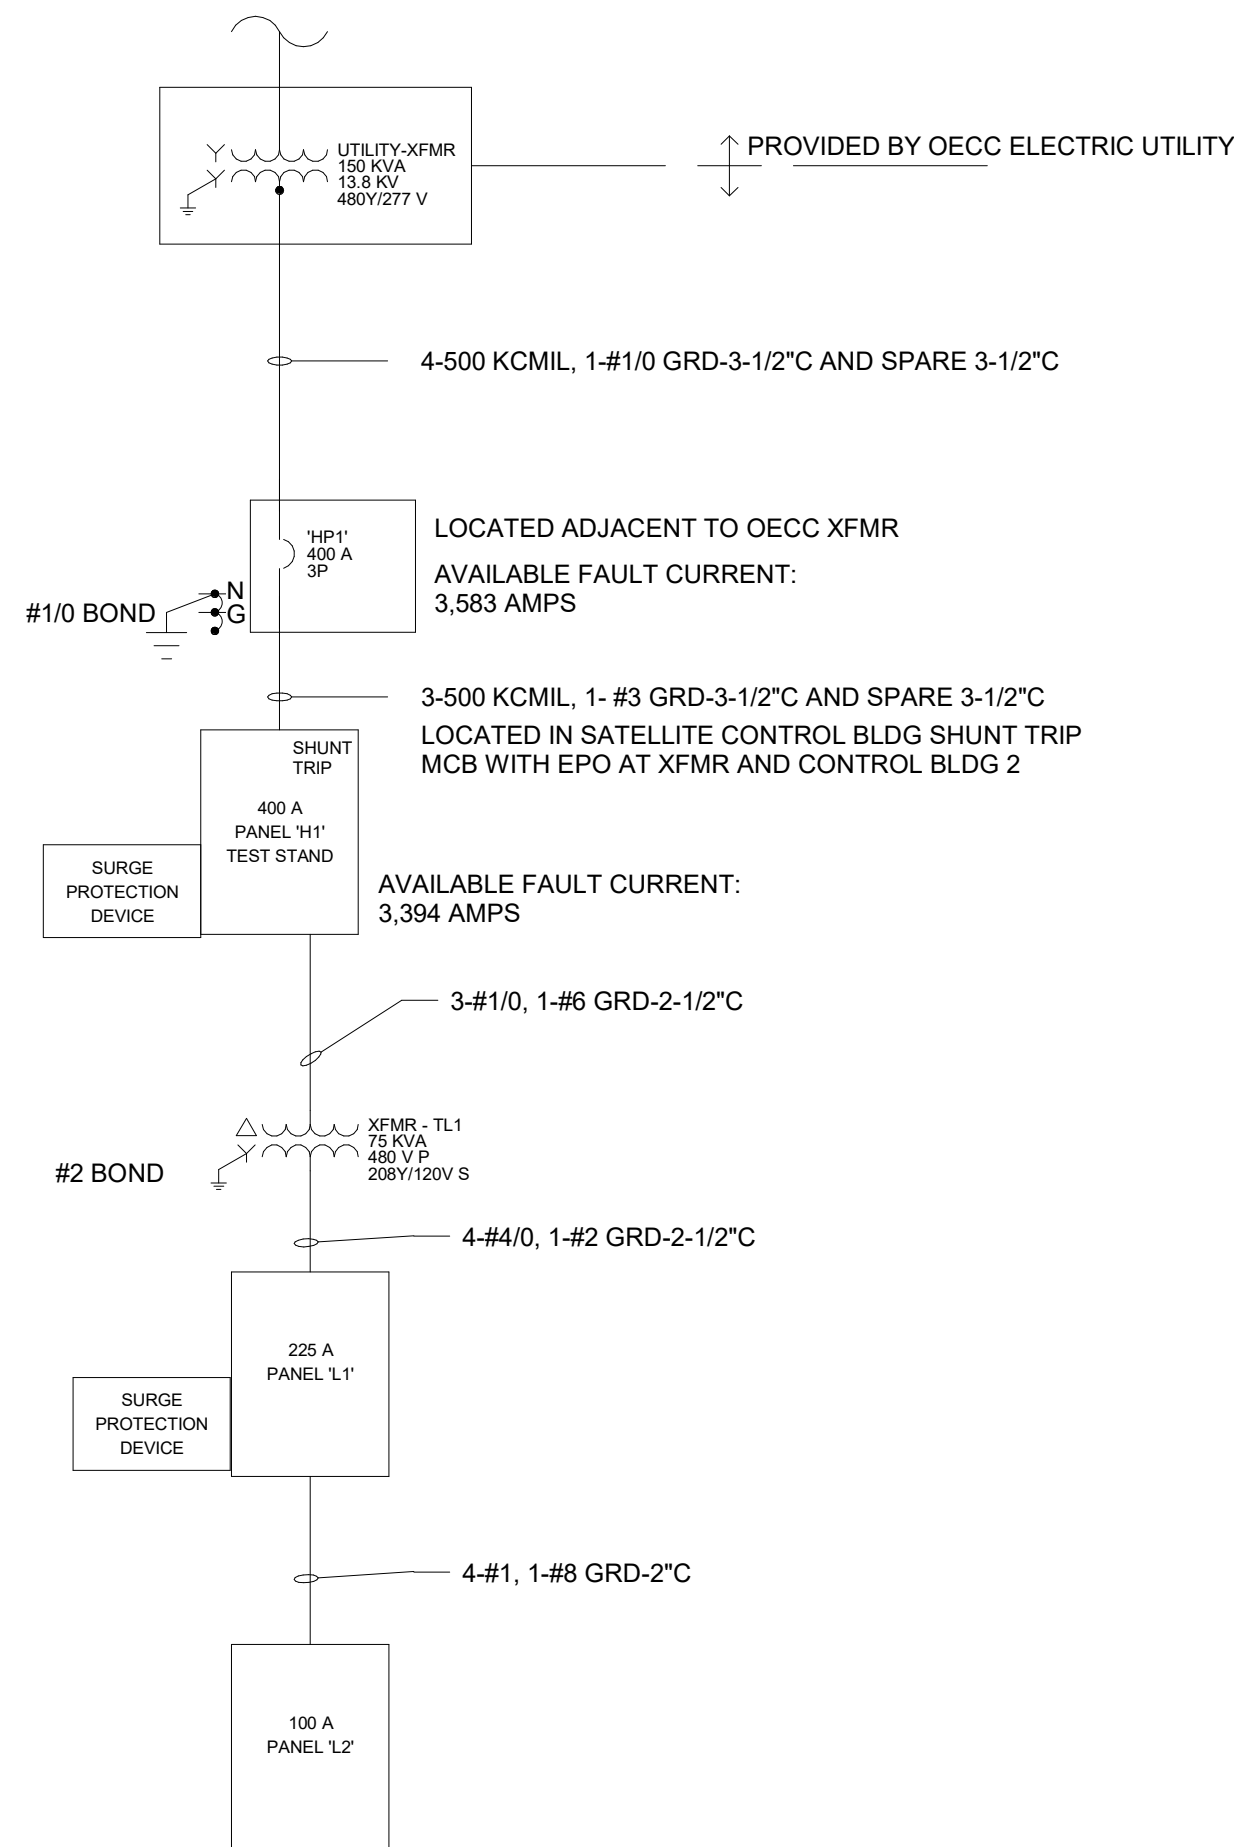

EQUIPMENT CONNECTIONS - CCH										
ID	VOLT	POLES	LOAD	FLA	MCA	OC PD RATING	D/S RATING	PANEL	CIRCUIT	WIRE/CONDUIT
AHU-1	480 V	3	12000 VA	17.6 A	22.0 A	25 A	30A/3P/NF	H1	1,3,5	3-#10, 1-#10 GROUND IN 3/4" CONDUIT
COMP-1	480 V	3	11639 VA	14.0 A	17.5 A	30 A	REFER TO MECH	H1	14,16,18	3-#10, 1-#10 GROUND IN 3/4" CONDUIT
CRANE-1	480 V	3	25000 VA	30.0 A	37.5 A	60 A	60A/3P/NF	H1	2,4,6	3-#4, 1-#10 GROUND IN 1" CONDUIT
CU/ FC-1	208 V	2	3827 VA	18.4 A	15.2 A	30 A	REFER TO MECH	L1	1,3	2-#10, 1-#10 GROUND IN 3/4" CONDUIT
DRYER-1	120 V	1	1000 VA	8.1 A	10.2 A	20 A	REFER TO MECH	L1	18	2-#10, 1-#10 GROUND IN 3/4" CONDUIT

NOTES: COORDINATE WITH MECHANICAL SCHEDULES AND PLANS

[illegible]

(A1) TEST STAND & SATELITE CONTROL RM - ONE-LINE DIAGRAM
SCALE NTS

[illegible]