



9/17/2024 9:08:14 PM M-101
Autodesk Docs\\US_D3754502_FED_Aerojet Rocketdyne\\03754502_CADD\\OSD_TestStand_MECH.rvt

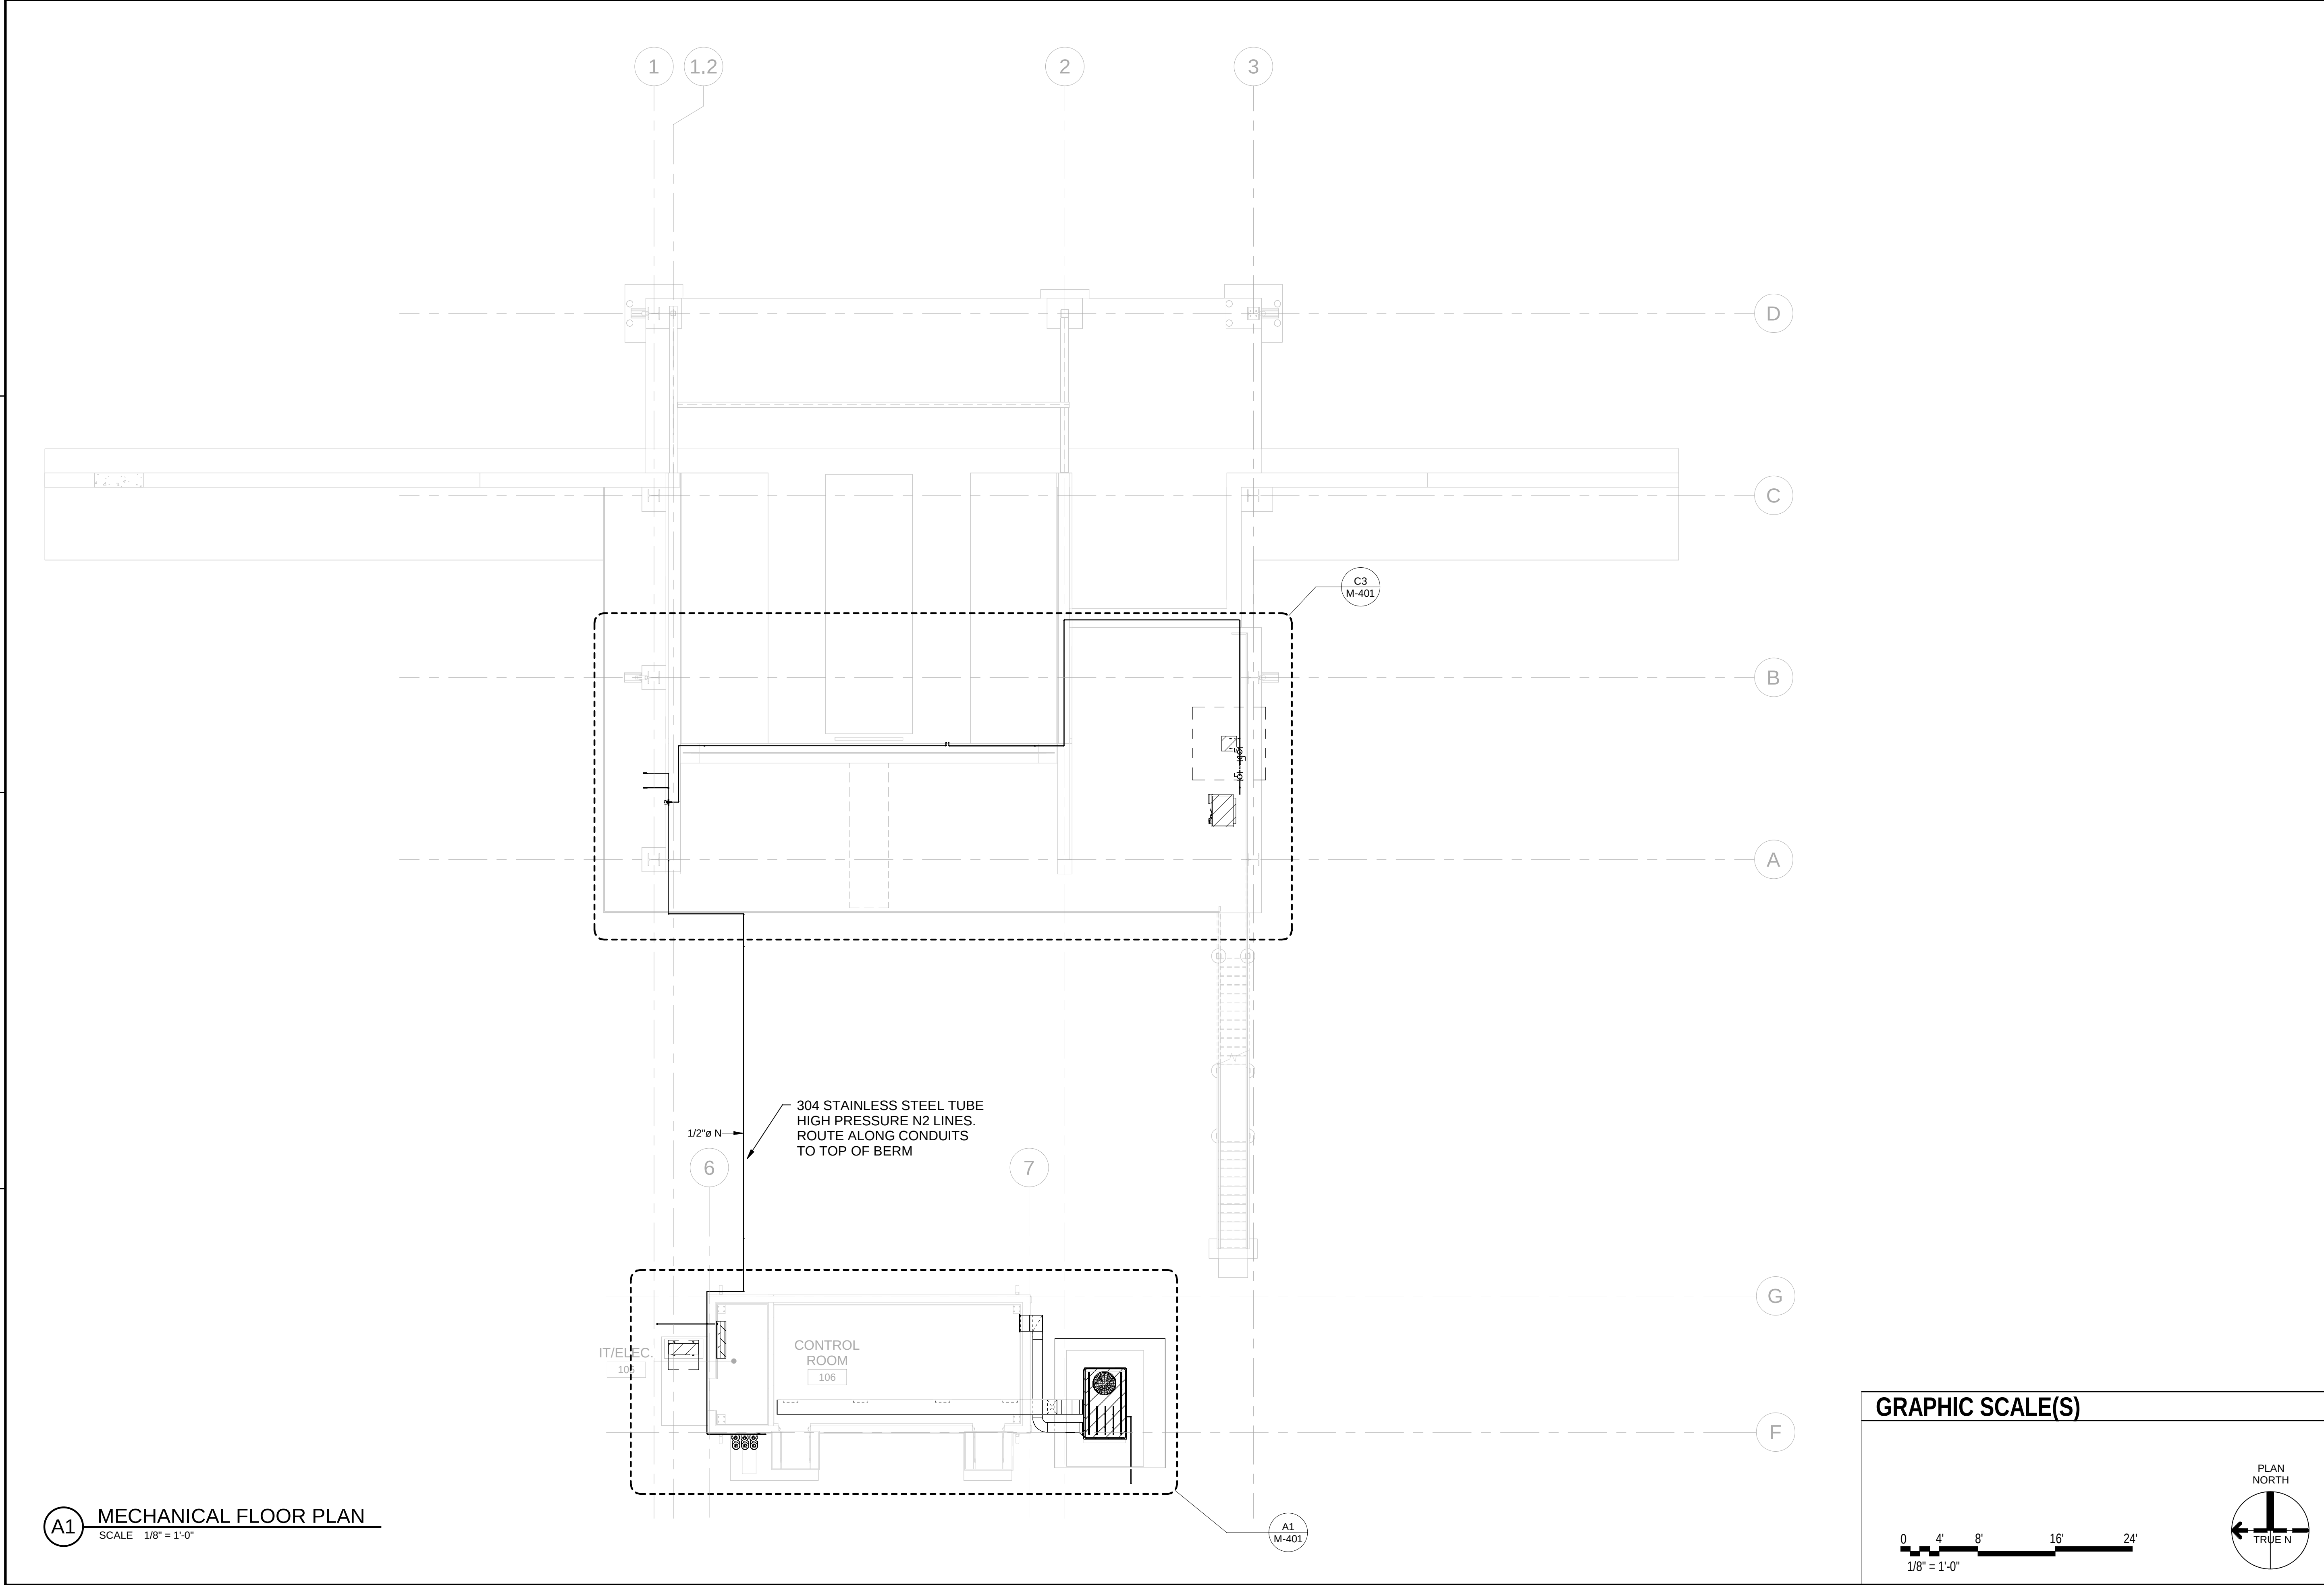

A1 MECHANICAL FLOOR PLAN
SCALE 1/8" = 1'-0"


GRAPHIC SCALE(S)

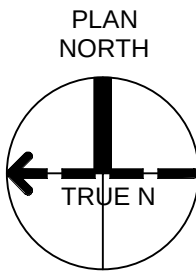

SHEET NO		M-101
SCALE	1/8" = 1'-0"	
DATE	09/18/2024	
PROJ	D3754502	
DWG	CADD\\OSD_TestStand_M-101	



Test Stand and SAT Building
Camden OSD
Calhoun County, Arkansas
Aerojet Rocketdyne

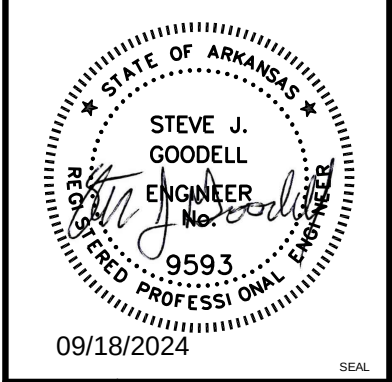

Jacobs
1909 Bryan Street Suite 2000 Dallas, TX 75201
Tel: 214-638-0145 Fax: 214-638-0447
Entity: Jacobs Engineering Group Inc.
License: State of Arkansas
Exp. Date: 12/31/2024

NO.	DATE	REVISION	CHK	RPA	DR	JWG	APVD	SIG
0	09/18/2024	100% ISSUED FOR CONSTRUCTION - EXPANSION	JWG					
			BY					
			APVD					

REUSE OF DOCUMENTS: THIS DRAWING AND THE DATA AND DESIGN INFORMATION CONTAINED HEREIN ARE THE PROPERTY OF JACOBS AND IS NOT TO BE USED IN WHOLE OR IN PART FOR ANY OTHER PROJECT WITHOUT THE WRITTEN AUTHORIZATION OF JACOBS.