


GENERAL NOTES

- 1 REFER TO SHEET P-001 FOR LEGEND AND NOTES.

DOMESTIC WATER SUPPLY:  
ROUTE 1-1/4" CW BELOW GRADE TO  
BUILDING. PROVIDE WATER METER IN  
STRICT ACCORDANCE WITH THE LOCAL  
WATER UTILITY'S REQUIREMENTS  
INCLUDING SIZE, TYPE, AND INSTALLATION  
DETAILS. CONFIRM ALL REQUIREMENTS  
PRIOR TO BID OR ROUGH-IN. ANTICIPATED  
PEAK WATER DEMAND=15 GPM.

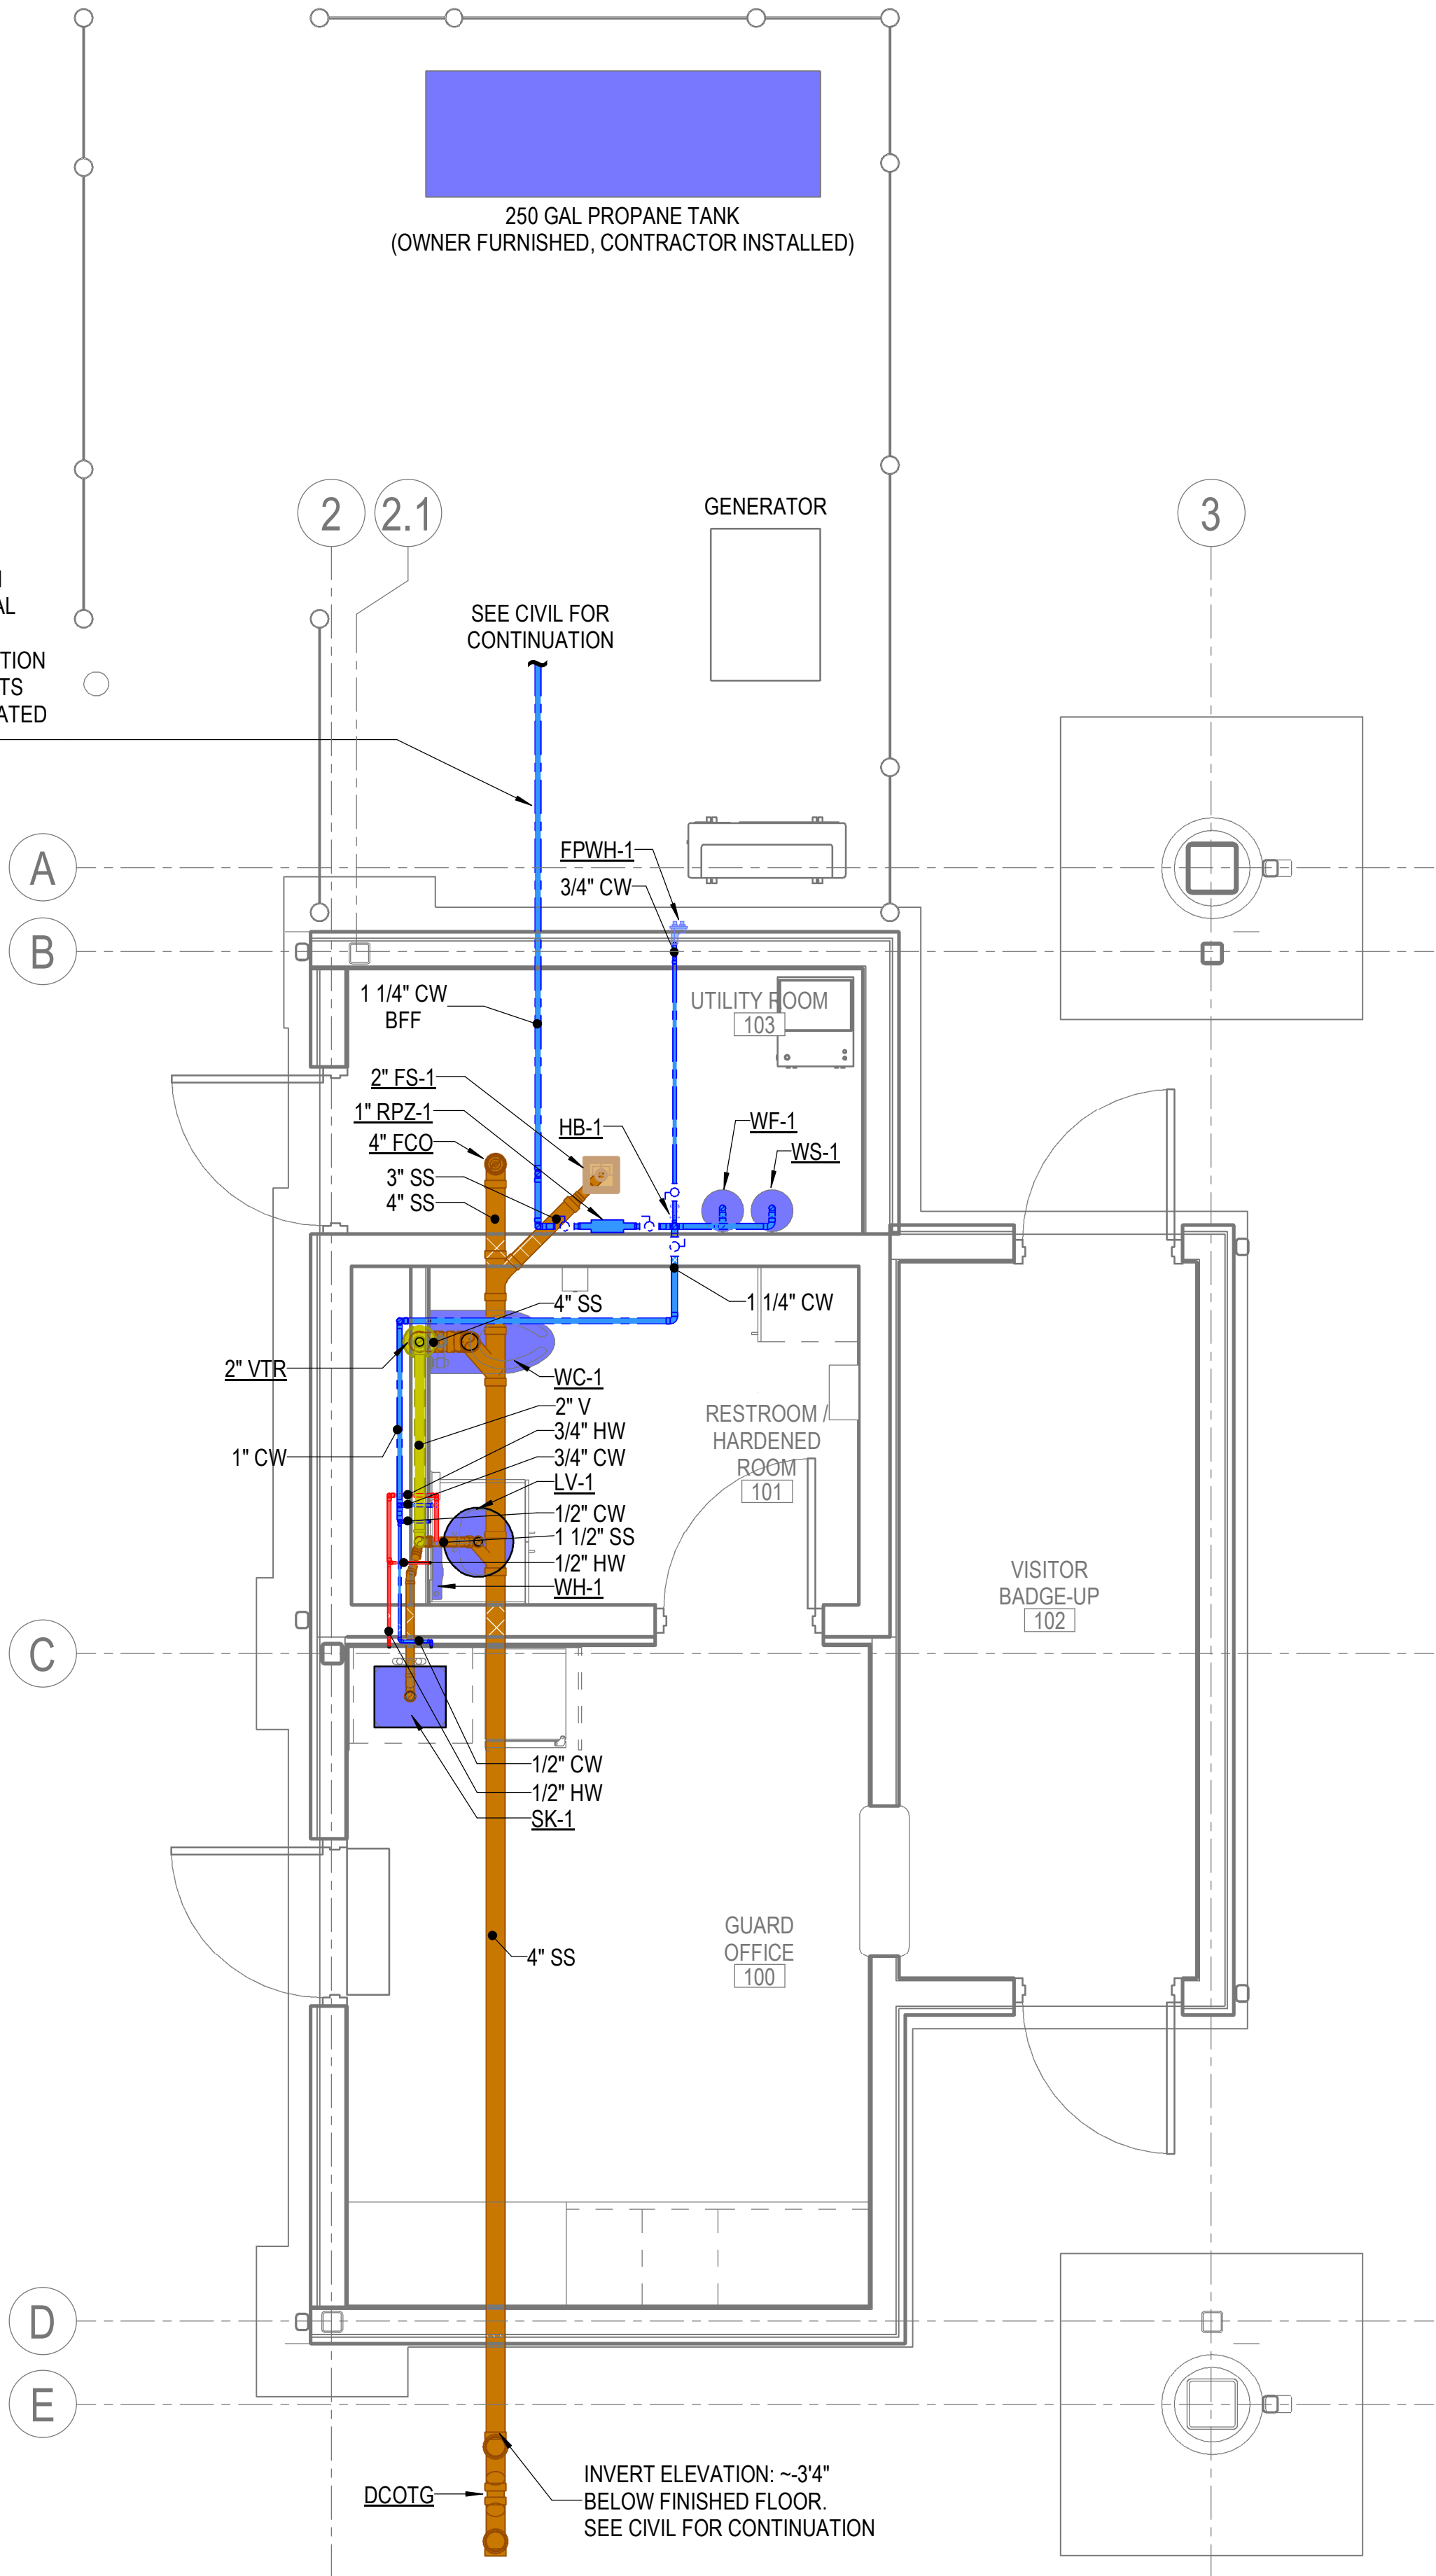

1 OVERALL PLUMBING PLAN  
3/8" = 1'-0"

Project

# AEROJET New Guard Post - 2

Design Phase

## CONSTRUCTION DOCUMENTS

Revisions

No.	Date	Description

Stamp

CROMWELL  
ARCHITECTS/  
ENGINEERS  
#5  
ARKANSAS ENGINEER

REGISTERED  
PROFESSIONAL  
ENGINEER  
NO. 12375  
JAMIE L. GUIDRY  
07-17-2024

Notes

- CROMWELL ARCHITECTS ENGINEERS, INC.  
ALL RIGHTS RESERVED
- THIS SHEET DESIGNED FOR COLOR PRINTING.  
CRITICAL INFORMATION MAY BE LOST WITH  
BLACK AND WHITE PRINTING.

Project Number 2024-052

Issue Date 07-17-2024

Sheet Title

## OVERALL PLUMBING PLAN

Sheet Number

# P-101