


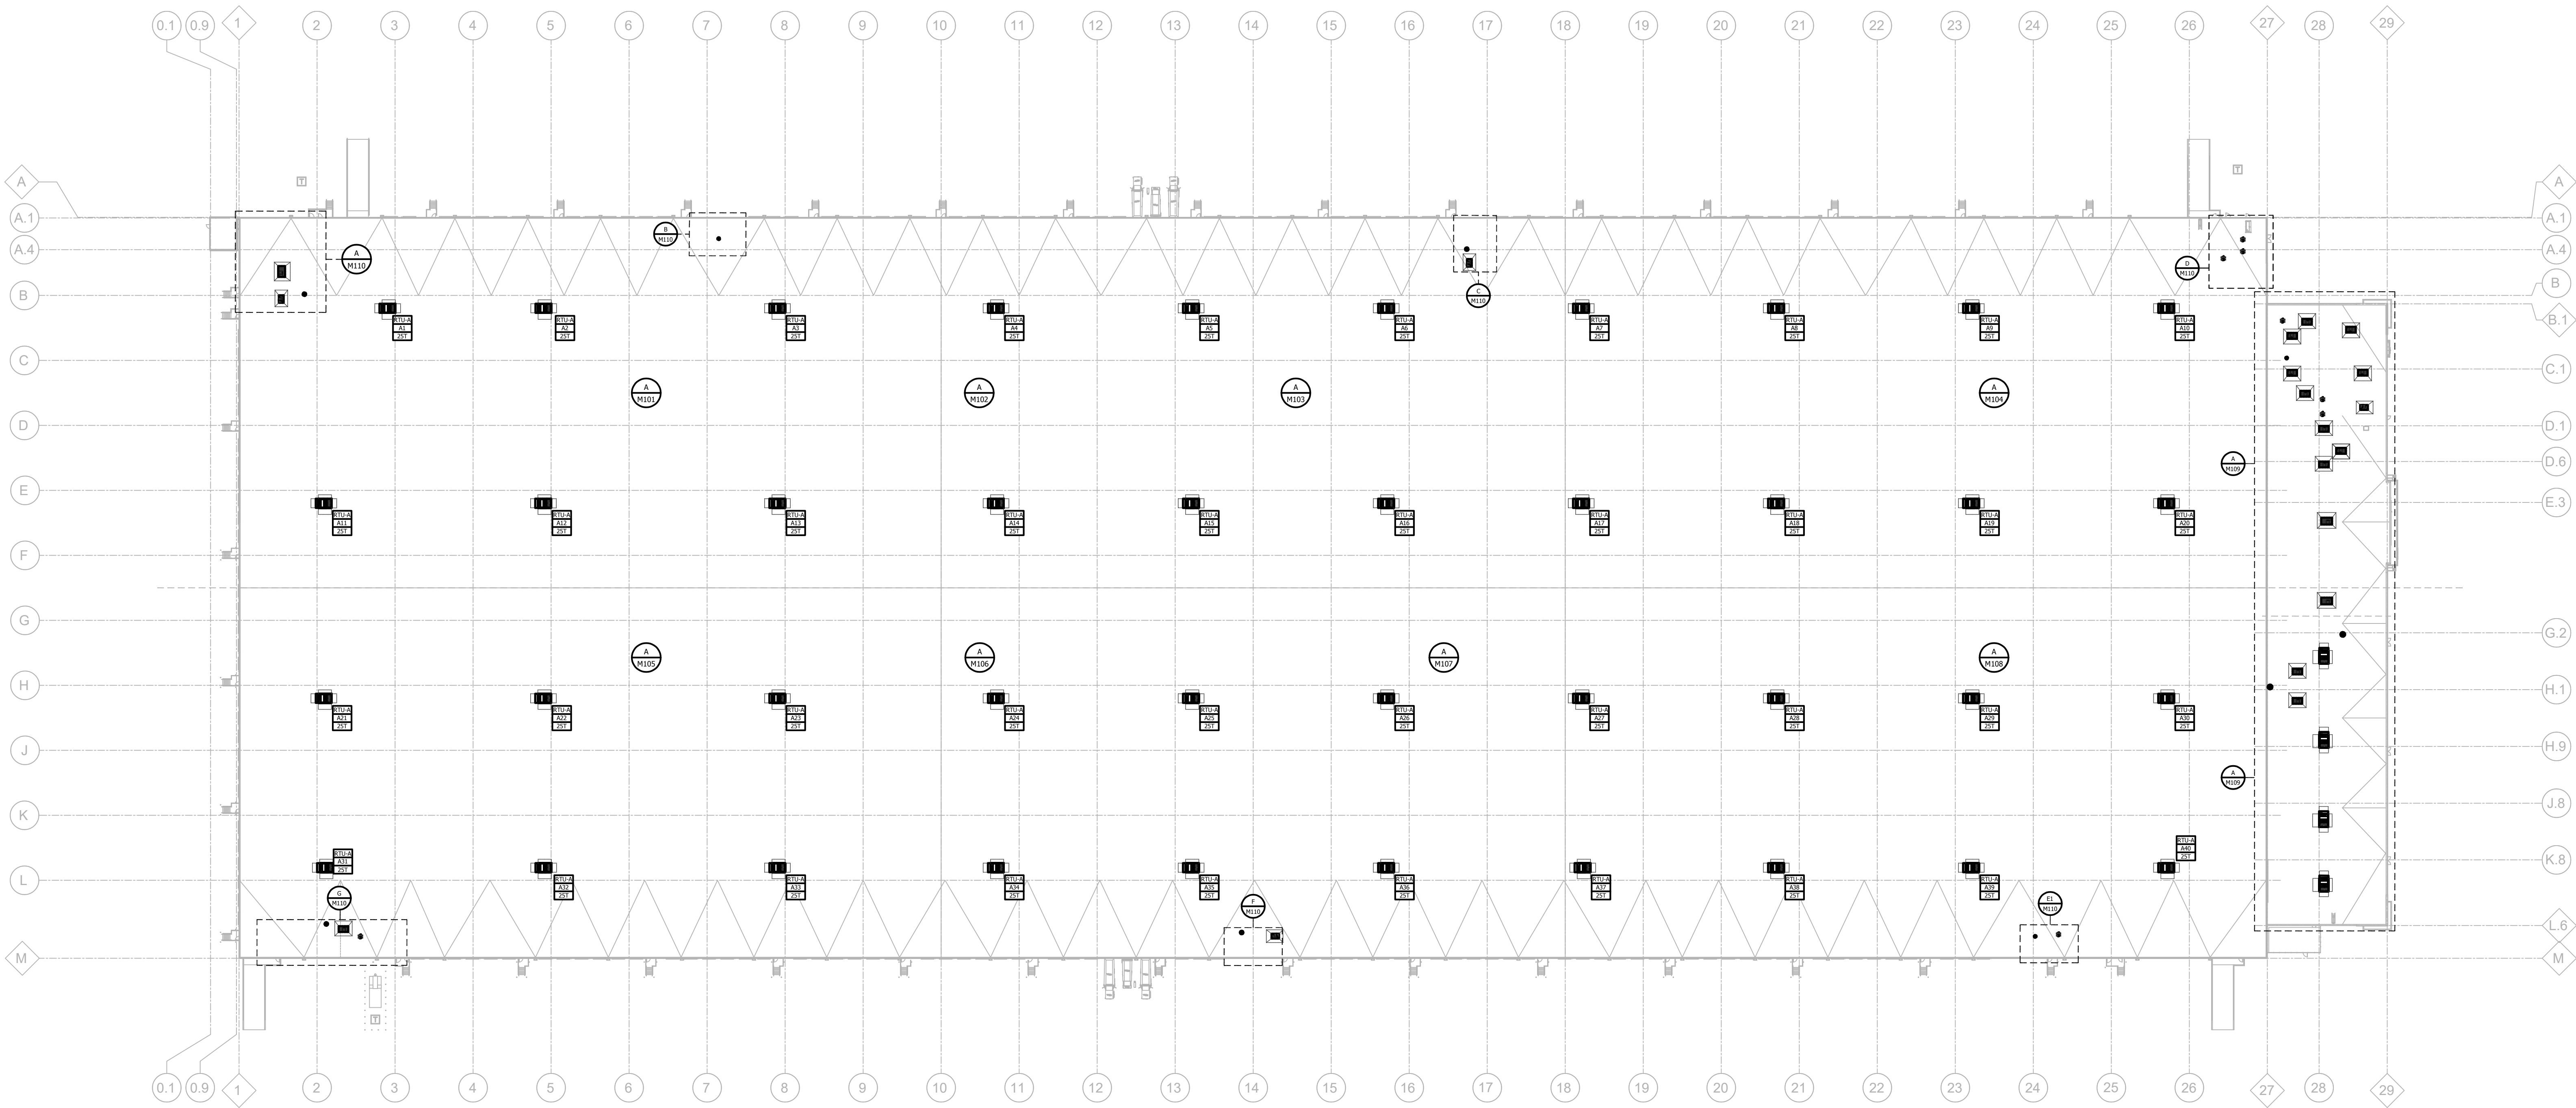

OVERALL HVAC ROOF PLAN

0 30' 60' 120'
SCALE: 1" = 60'-0"

APPROVAL STAMP:

HAMILTON

DEVELOPMENT

ONE MUSIC SQUARE SOUTH,
SUITE 110
NASHVILLE, TN 37203

SMC

ARCHITECTS

SM DESIGN & CONSULTING, PC
855 Bloomfield Avenue, Suite 220
Glen Ridge, NJ 07028
Telephone 973-259-9500
www.smdcpc.com

CONSULTANT

SHIRK & O'DONOVAN

CONSULTING ENGINEERS

STRUCTURAL CONSULTANTS

SHIRK & O'DONOVAN
CONSULTING ENGINEERS, INC.
370 EAST WILSON BRIDGE ROAD
WORTHINGTON, OH 43085
PH: 614.436.6465

MEP CONSULTANTS

KRAEMER CONSULTING ENG PLLC
2050 W. WHISPERING WIND DR. STE 158
PHOENIX, AZ 85065
PH: 602.285.1669

harrington

GROUP

FIRE PROTECTION CONSULTANTS

HARRINGTON GROUP, INC.
3237 SATELLITE BOULEVARD, SUITE 525
DULUTH, GA 30096
PH: 770.564.3505

HARGIS

TELECOMMUNICATIONS CONSULTANTS

HARGIS ENGINEERS, INC.
1201 THIRD AVENUE, SUITE 600
SEATTLE, WA 98101
PH: 206.448.3376

Pickering

Pickering Firm, Inc.
Engineering
Planning - Surveying

SITE CIVIL

PICKERING FIRM, INC.
1700 KIRK RD, SUITE 120
LITTLE ROCK, AR 72223
PH: 501.246.3578

SEAL

STATE OF ARKANSAS

REGISTERED PROFESSIONAL ENGINEER

NO. 16886

03.26.25

M. J. K.

KCE 308 #24-240

END USER

amazon

PROJECT DESCRIPTION

AMAZON LIT3

2026 IUD GENSM

CROSS-DOCK WAREHOUSE FACILITY
(RECEIPT & REDISTRIBUTION)

PROJECT LOCATION

Port of Little Rock

PORT OF LITTLE ROCK
(INDUSTRIAL PARK)
LITTLE ROCK, ARKANSAS 72206
(UNINCORPORATED PARCELS) PULASKI COUNTY

SHEET TITLE

OVERALL HVAC ROOF
PLAN

SHEET MANAGEMENT

PROJECT NO.:

DATE ISSUED:

DRAWN BY:

REVIEWED BY:

ISSUANCE / REVISION SCHEDULE

#	DATE	DESCRIPTION
02/20/2025	REVIEW SET (10.88%)	
03/20/2025	100% CD - FOR PERMIT	

SHEET NUMBER

M-100

C:\Users\Chad\Documents\2025\1\AMZ\22-24-AR_Plan overall HVAC.dwg

COPYRIGHT AND NOTES: THE COPYRIGHT FOR THIS PROJECT IS VESTED IN THE ARCHITECT. VERIFY ALL DIMENSIONS AND LEVELS ON SITE. DISCREPANCIES TO BE REPORTED IMMEDIATELY TO THE ARCHITECT. DRAWINGS TO BE READ IN CONJUNCTION WITH THE SPECIFICATION. DO NOT SCALE OFF DRAWINGS.

Submital Type - Working Documents