



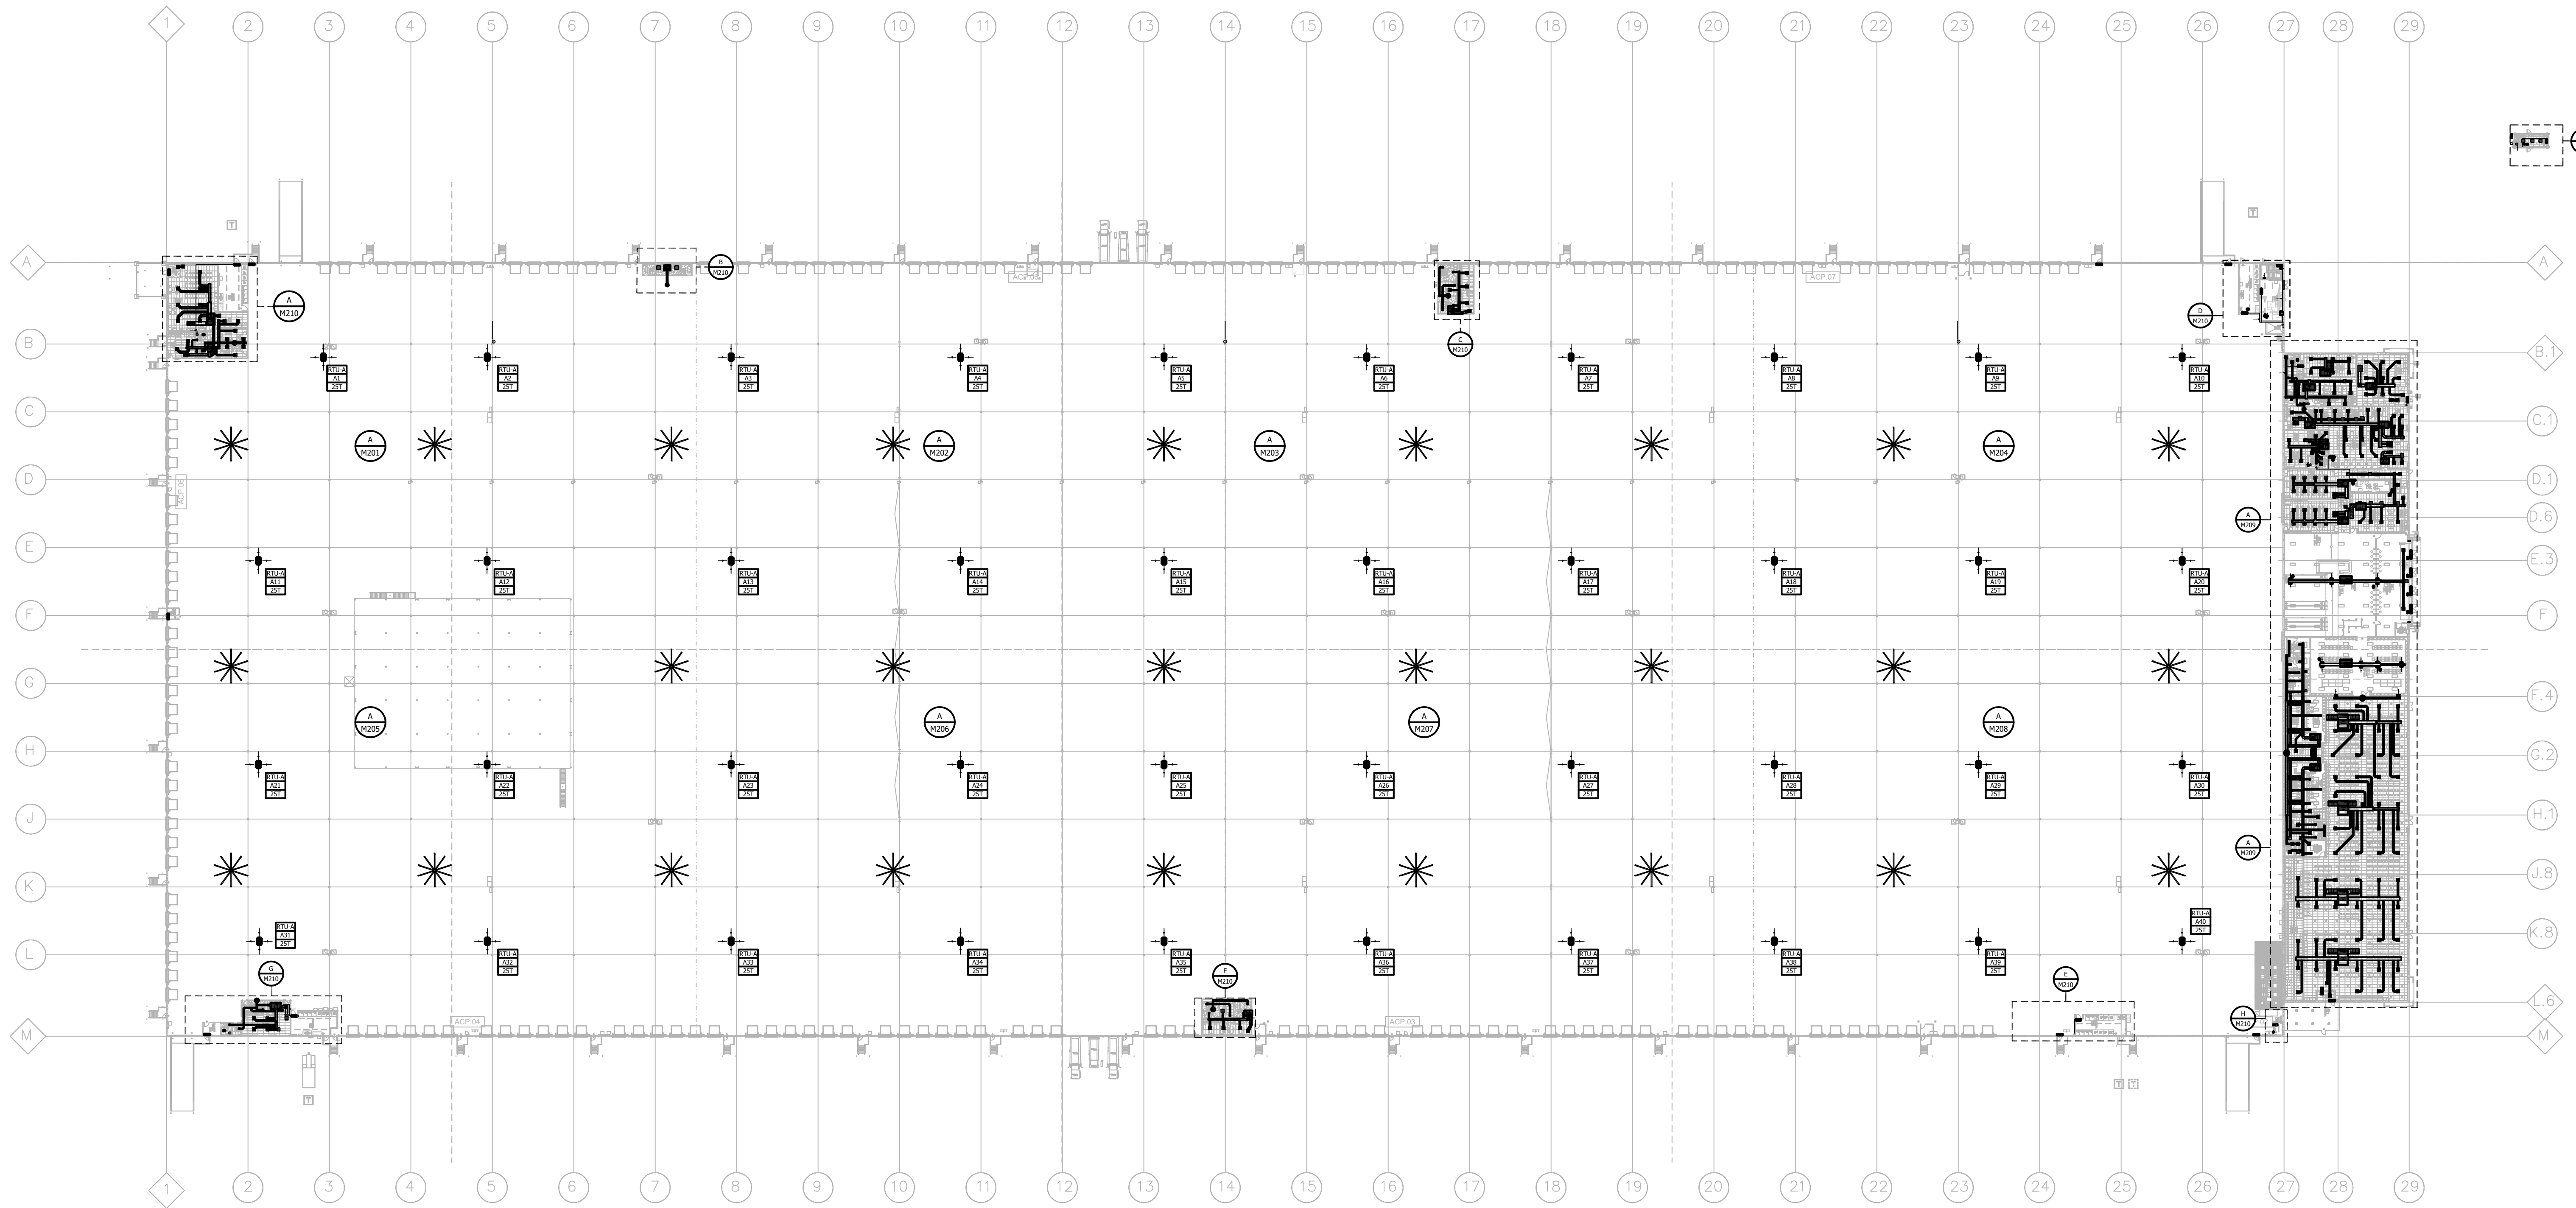


OVERALL HVAC PLAN

0 30' 60' 120'
SCALE: 1" = 60'-0"

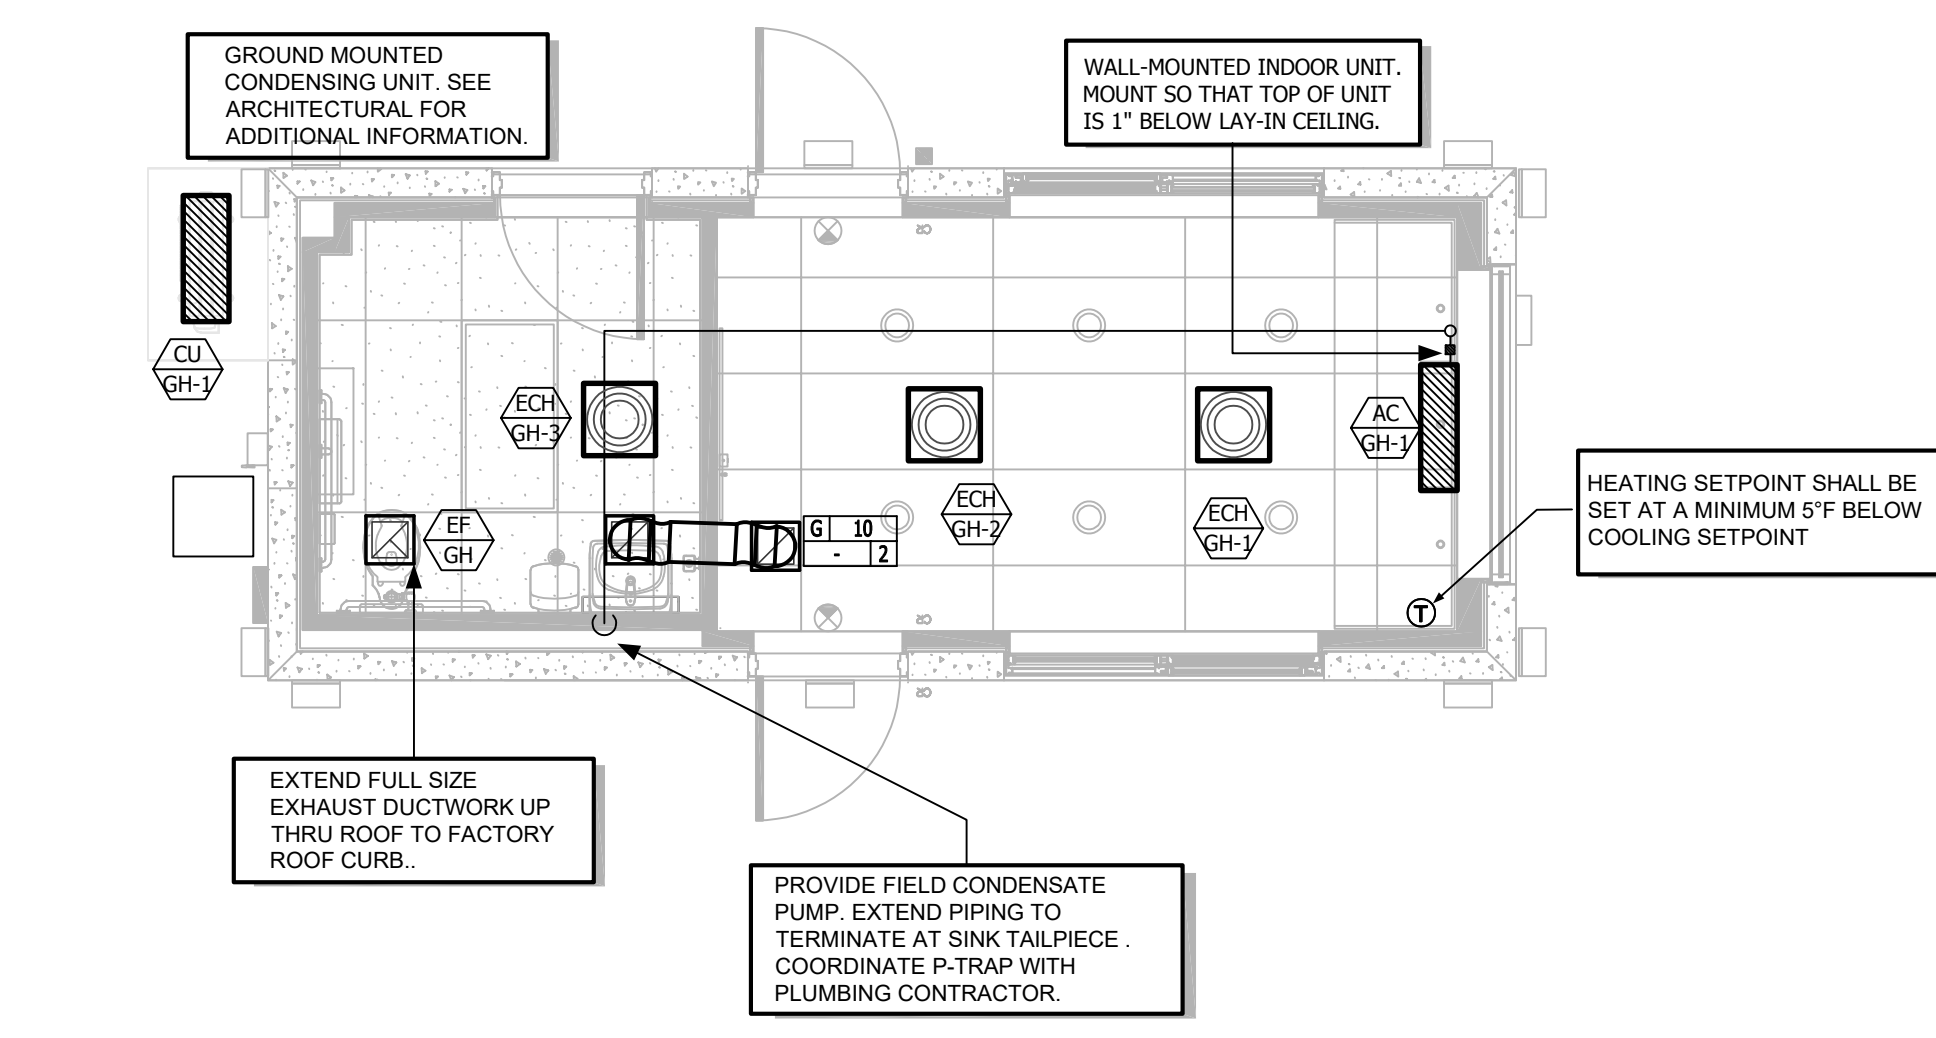

C) SITE GUARD HOUSE HVAC PLAN

0 2' 4' 8'
SCALE: 1/4" = 1'-0"

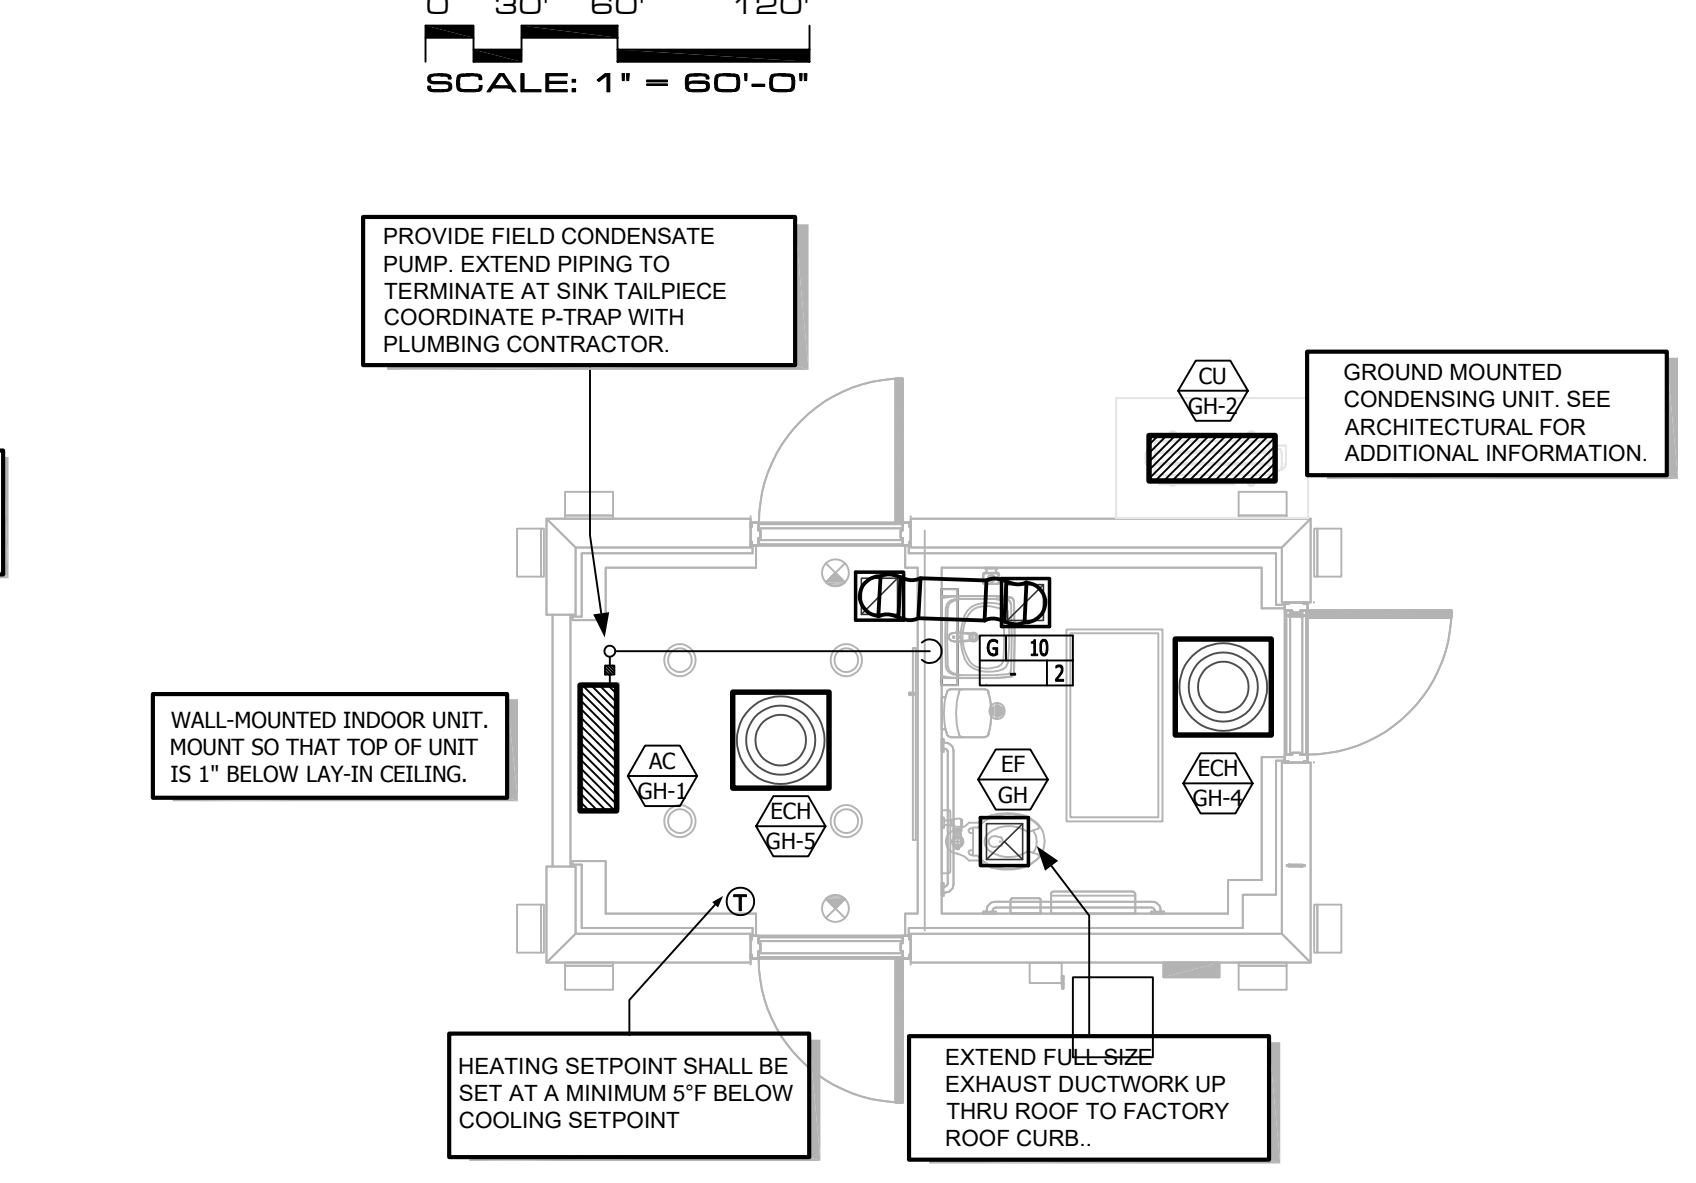

D) HVAC SITE GUARD HOUSE PLAN

0 2' 4' 8'
SCALE: 1/4" = 1'-0"

APPROVAL STAMP:

HAMILTON
DEVELOPMENT
ONE MUSIC SQUARE SOUTH,
SUITE 110
NASHVILLE, TN 37203

SMC
ARCHITECTS
SM DESIGN & CONSULTING, PC
855 Bloomfield Avenue, Suite 220
Glen Ridge, NJ 07028
Telephone 973-259-9500
www.smdcpc.com

CONSULTANT
SHIRK & O'DONOVAN
CONSULTING ENGINEERS
SHIRK & O'DONOVAN
CONSULTING ENGINEERS, INC.
370 EAST WILSON BRIDGE ROAD
WORTHINGTON, OH 43085
PH: 614.436.6465

MEP CONSULTANTS
KRAEMER CONSULTING ENG PLLC
2050 W. WHISPERING WIND DR. STE 158
PHOENIX, AZ 85065
PH: 602.285.1669
harrington
FIRE PROTECTION CONSULTANTS
HARRINGTON GROUP, INC.
3237 SATELLITE BOULEVARD, SUITE 525
DULUTH, GA 30096
PH: 770.564.3505

HARGIS
TELECOMMUNICATIONS CONSULTANTS
HARGIS ENGINEERS, INC.
1201 THIRD AVENUE, SUITE 600
SEATTLE, WA 98101
PH: 206.448.3376

IN COORDINATION WITH DEVELOPERS
CONSULTANT WORKING IN PARALLEL:
Pickering
Pickering Firm, Inc.
Engineering
Planning - Surveying
SITE CIVIL
PICKERING FIRM, INC.
1700 KIRK RD. SUITE 120
LITTLE ROCK, AR 72223
PH: 501.246.3578

SEAL
KCE JOB #24-240
03.26.25
amazon
PROJECT DESCRIPTION
AMAZON LIT3
2026 KU GENSM
CROSS-DOCK WAREHOUSE FACILITY
(RECEIPT & REDISTRIBUTION)
PROJECT LOCATION
Port of Little Rock
(INDUSTRIAL PARK)
LITTLE ROCK, ARKANSAS 72206
(UNINCORPORATED PARCELS) PULASKI COUNTY
SHEET TITLE
OVERALL HVAC PLAN
SHEET MANAGEMENT
PROJECT NO.:
DATE ISSUED:
DRAWN BY: VARIOUS
REVIEWED BY: MK
ISSUANCE / REVISION SCHEDULE
DATE DESCRIPTION
02/20/2025 REVIEW SET (100%)
03/20/2025 100% CD - FOR PERMIT
SHEET NUMBER
M-200