


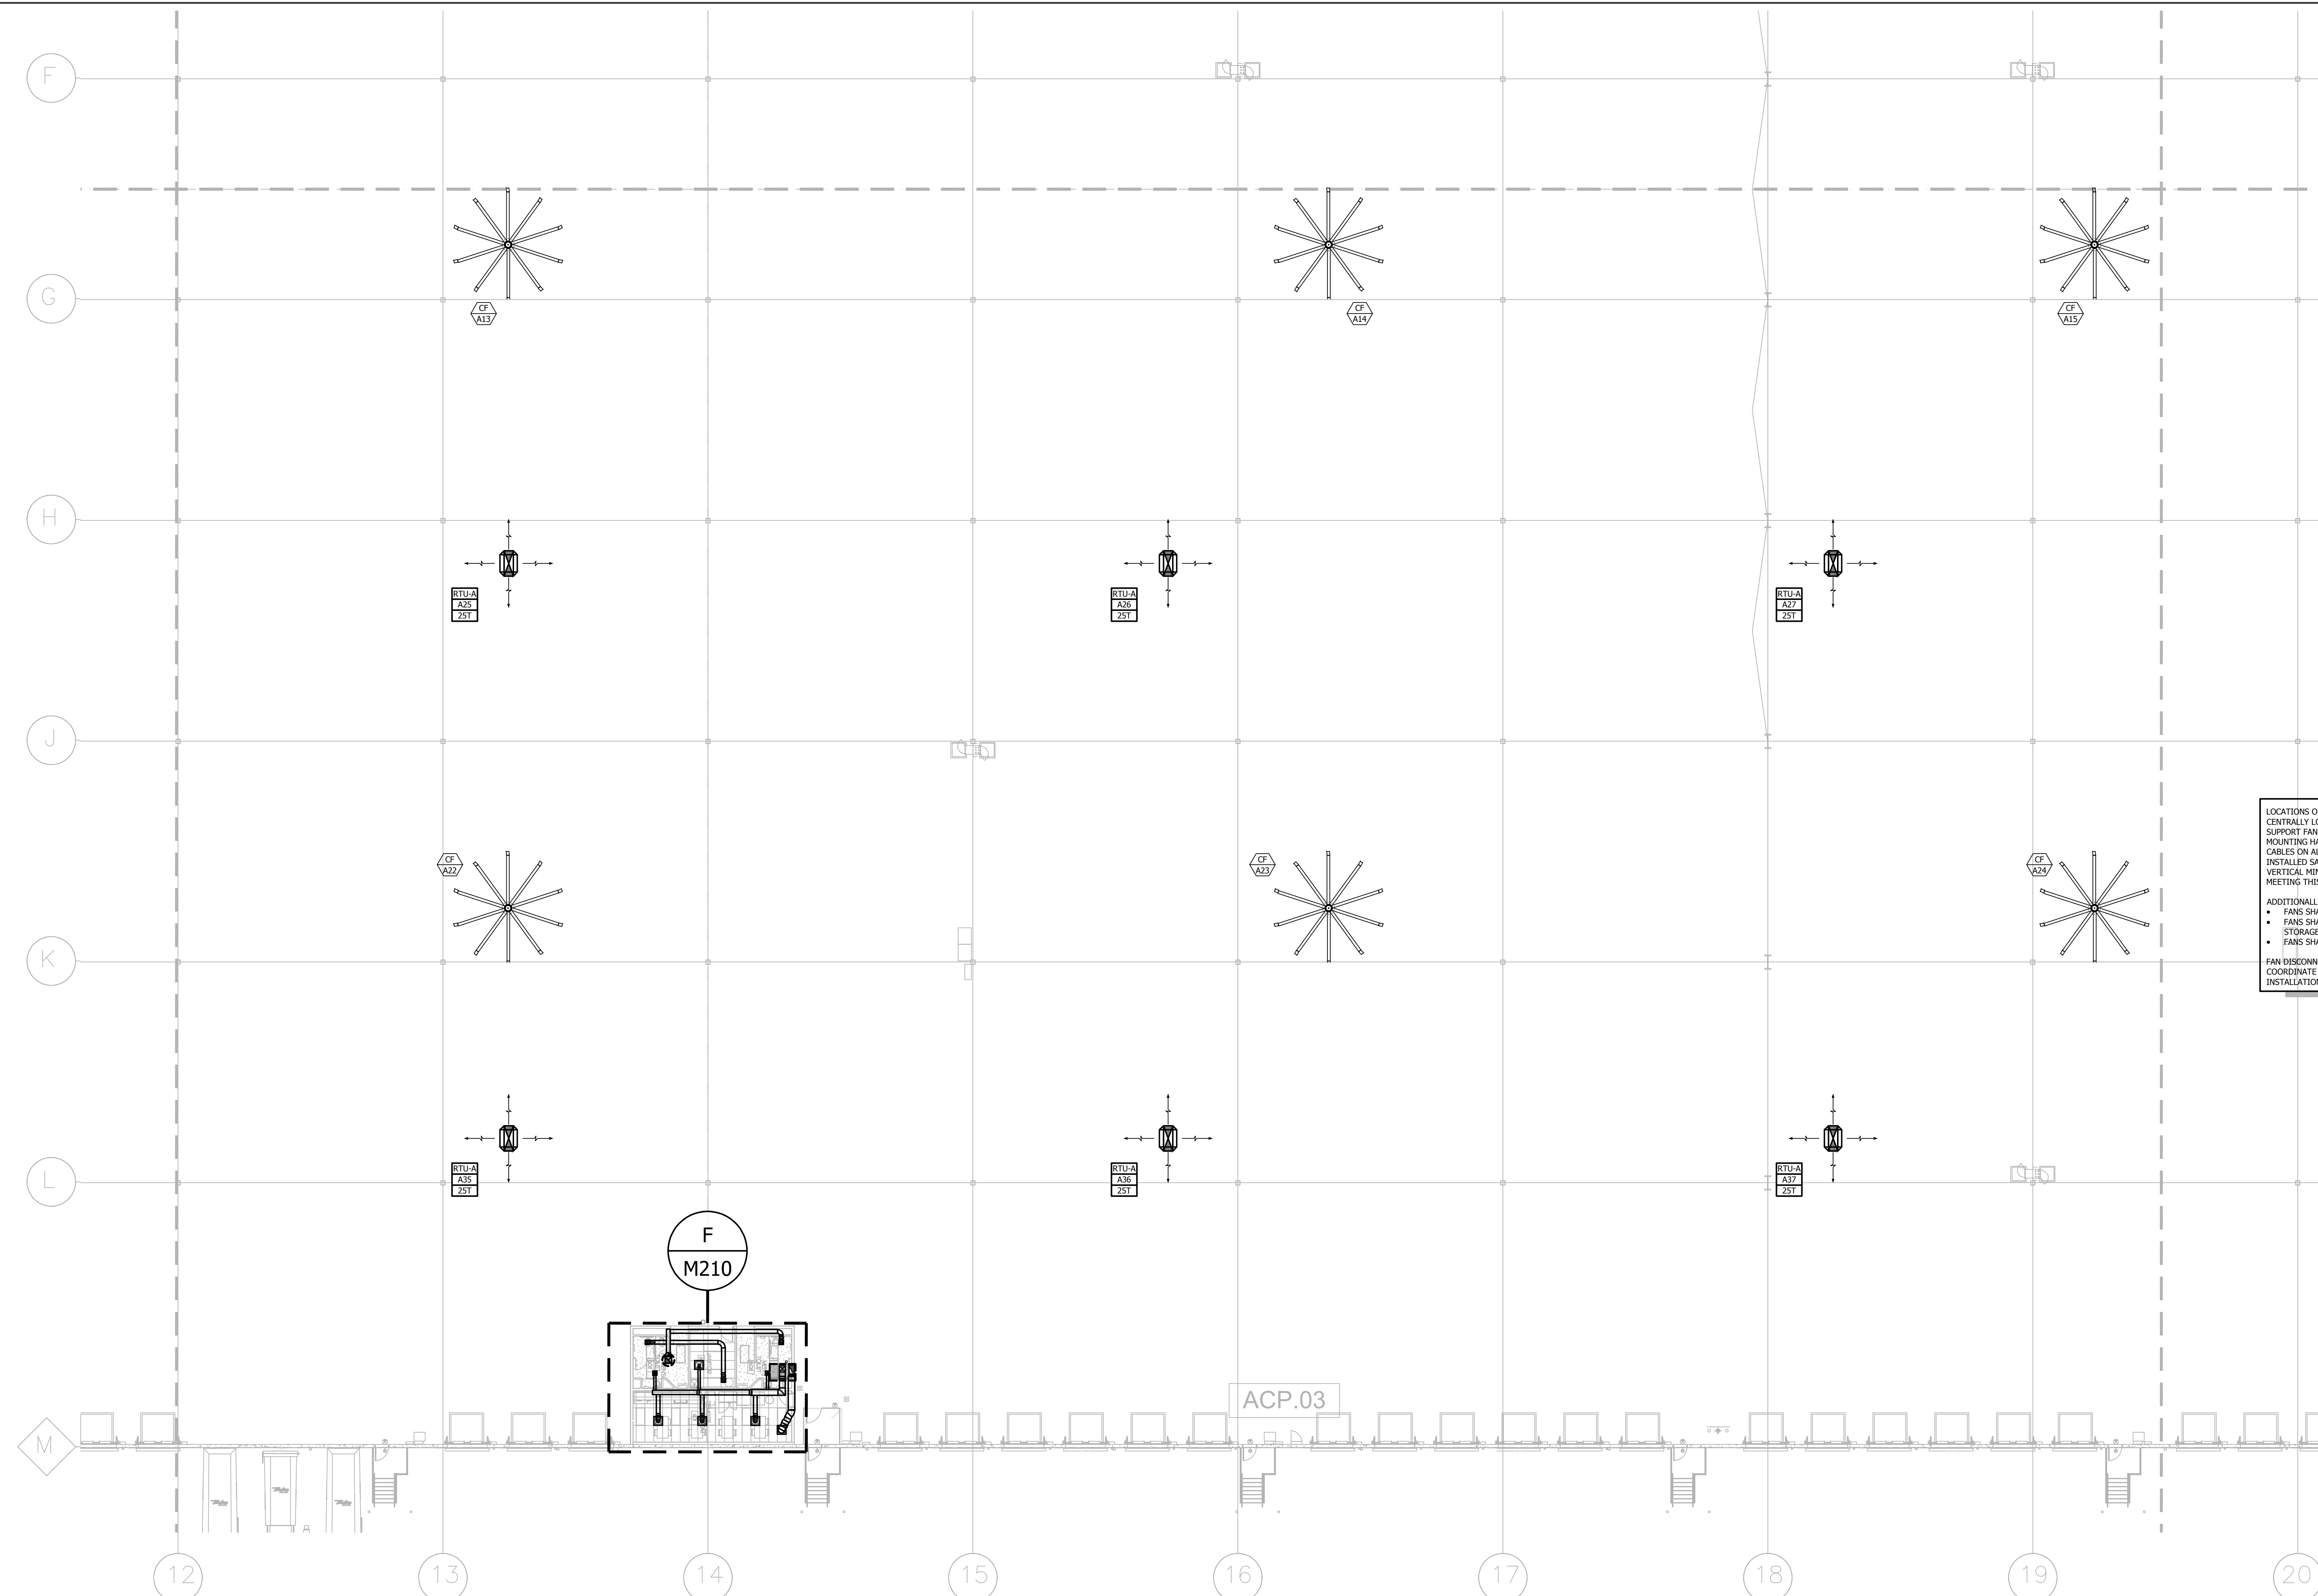

PARTIAL WAREHOUSE HVAC PLAN

0 8' 16' 32'

SCALE: 1/16" = 1'-0"

M201	M202	M203	M204
M205	M206	M207	M208

KEY PLAN