

NEW ARcare MEDICAL OFFICE BUILDING
2709 Massard Rd
FT. SMITH, AR 72903




CODE AND PROJECT DEVELOPMENT DATA

Table with 2 columns: Code/Category and Value/Requirement. Includes sections for Building Code, Occupancy, Type Construction, Fire Separation Distances, Allowable Height & Building Area, Total Enclosed Area, Total Occupants, Means of Egress Sizing, Travel Distance Allowed, and Required Plumbing Fixtures.

Sheet Index table with 4 columns: #, Sheet Name, #, Sheet Name. Lists architectural and plumbing sheets from A0.0 to P002.

Project Team Data and Notes section. Includes Architect (Key Architecture Inc.), Mechanical (Terrell Engineering Consultant), Civil (Davidson Engineering), and a detailed disclaimer/notes section regarding construction responsibilities and approvals.

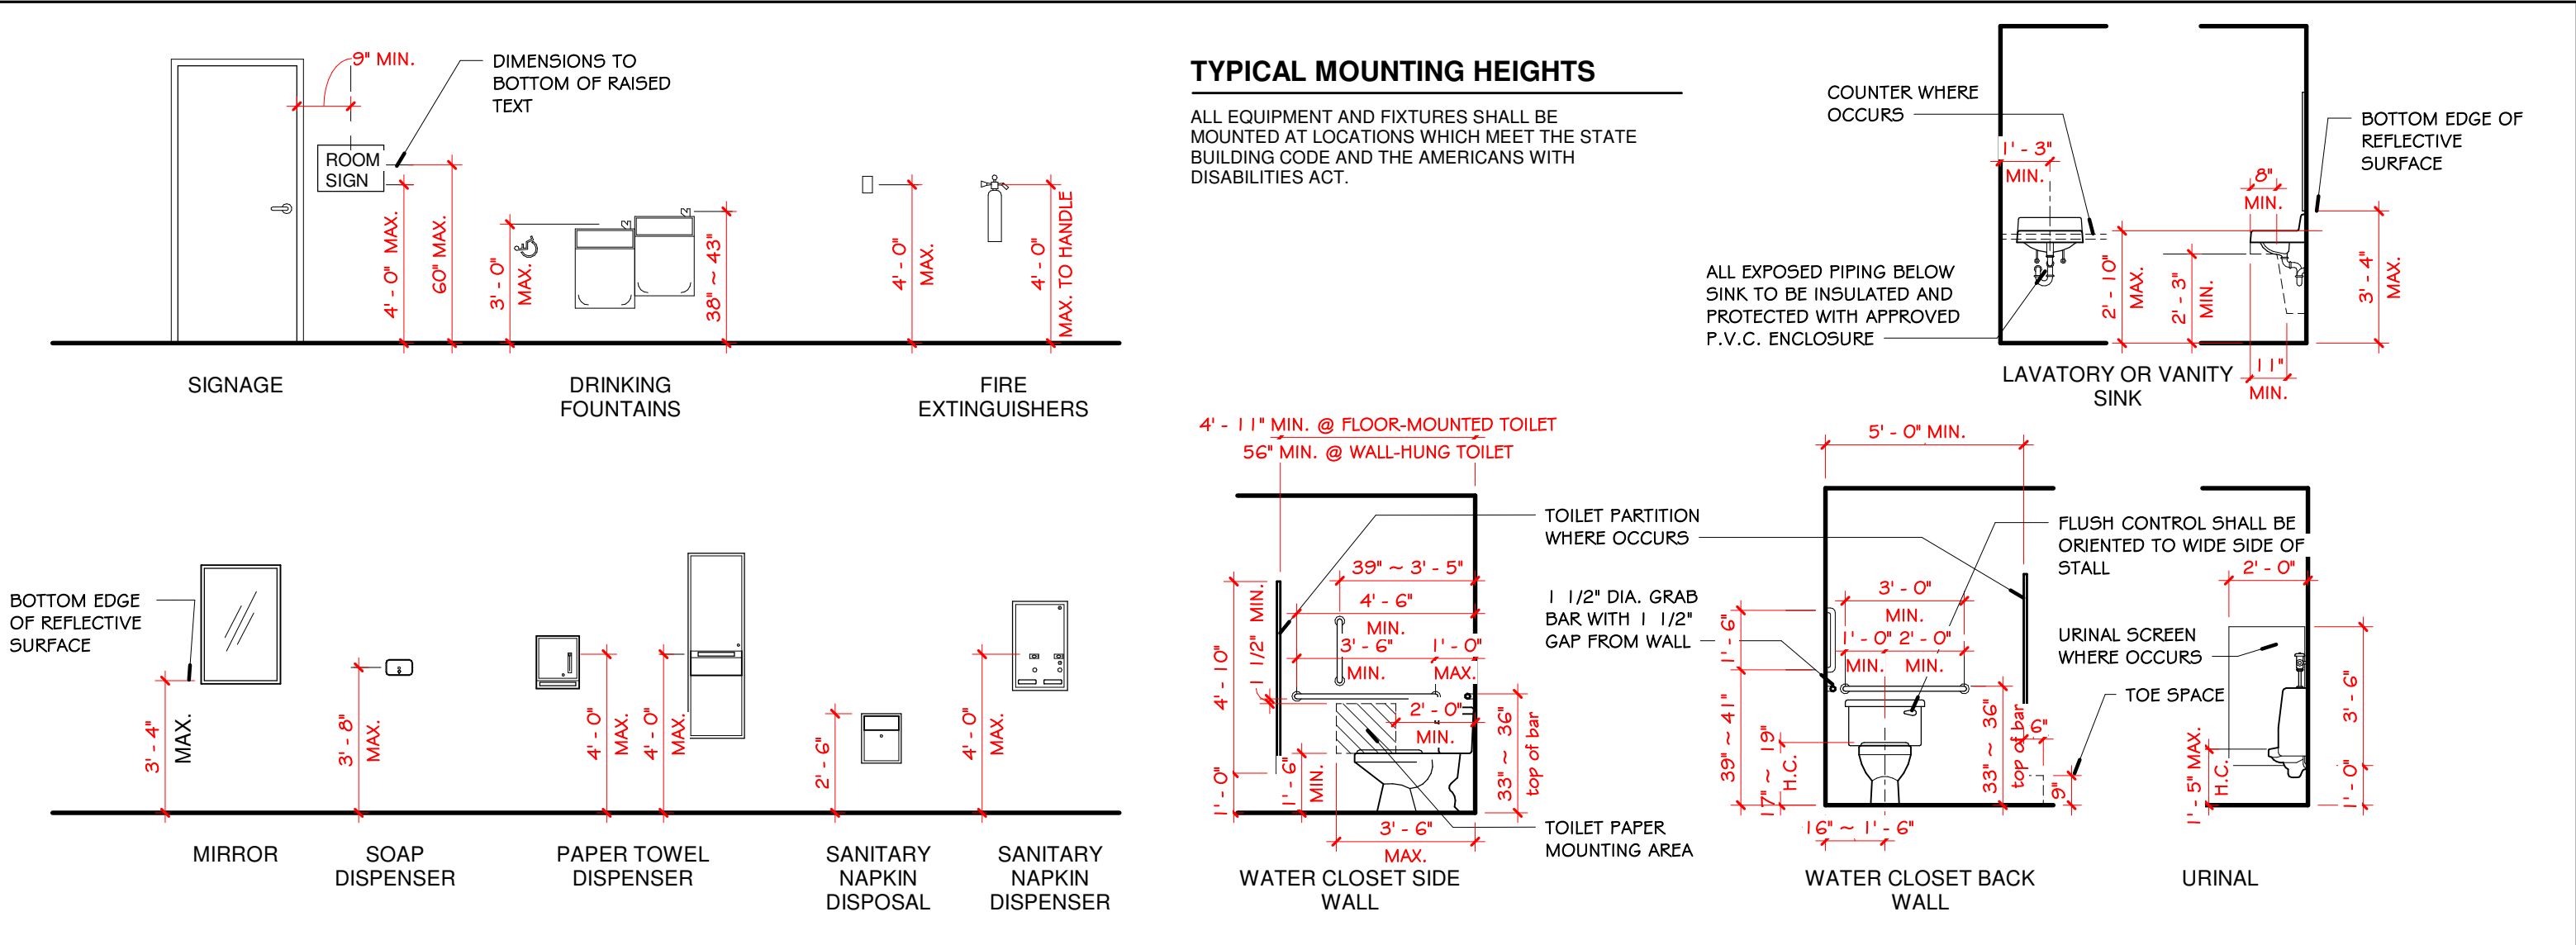

Key Architecture Inc. logo and contact information: P.O. BOX 748, FAYETTEVILLE, ARKANSAS 72702, PH: 479.444.6066, FAX: 479.444.1445.

FOR PERMIT & CONSTRUCTION section. Includes a revision schedule table and project details for the New ARcare Medical Office Building at 2709 Massard Rd, Ft. Smith, AR 72903.