




As indicated 6/16/2026 12:49:07 PM S:\2517 Delta Blue - New ARcare\2517 NEW ARCADE CLINIC - FT.SMITH.rvt

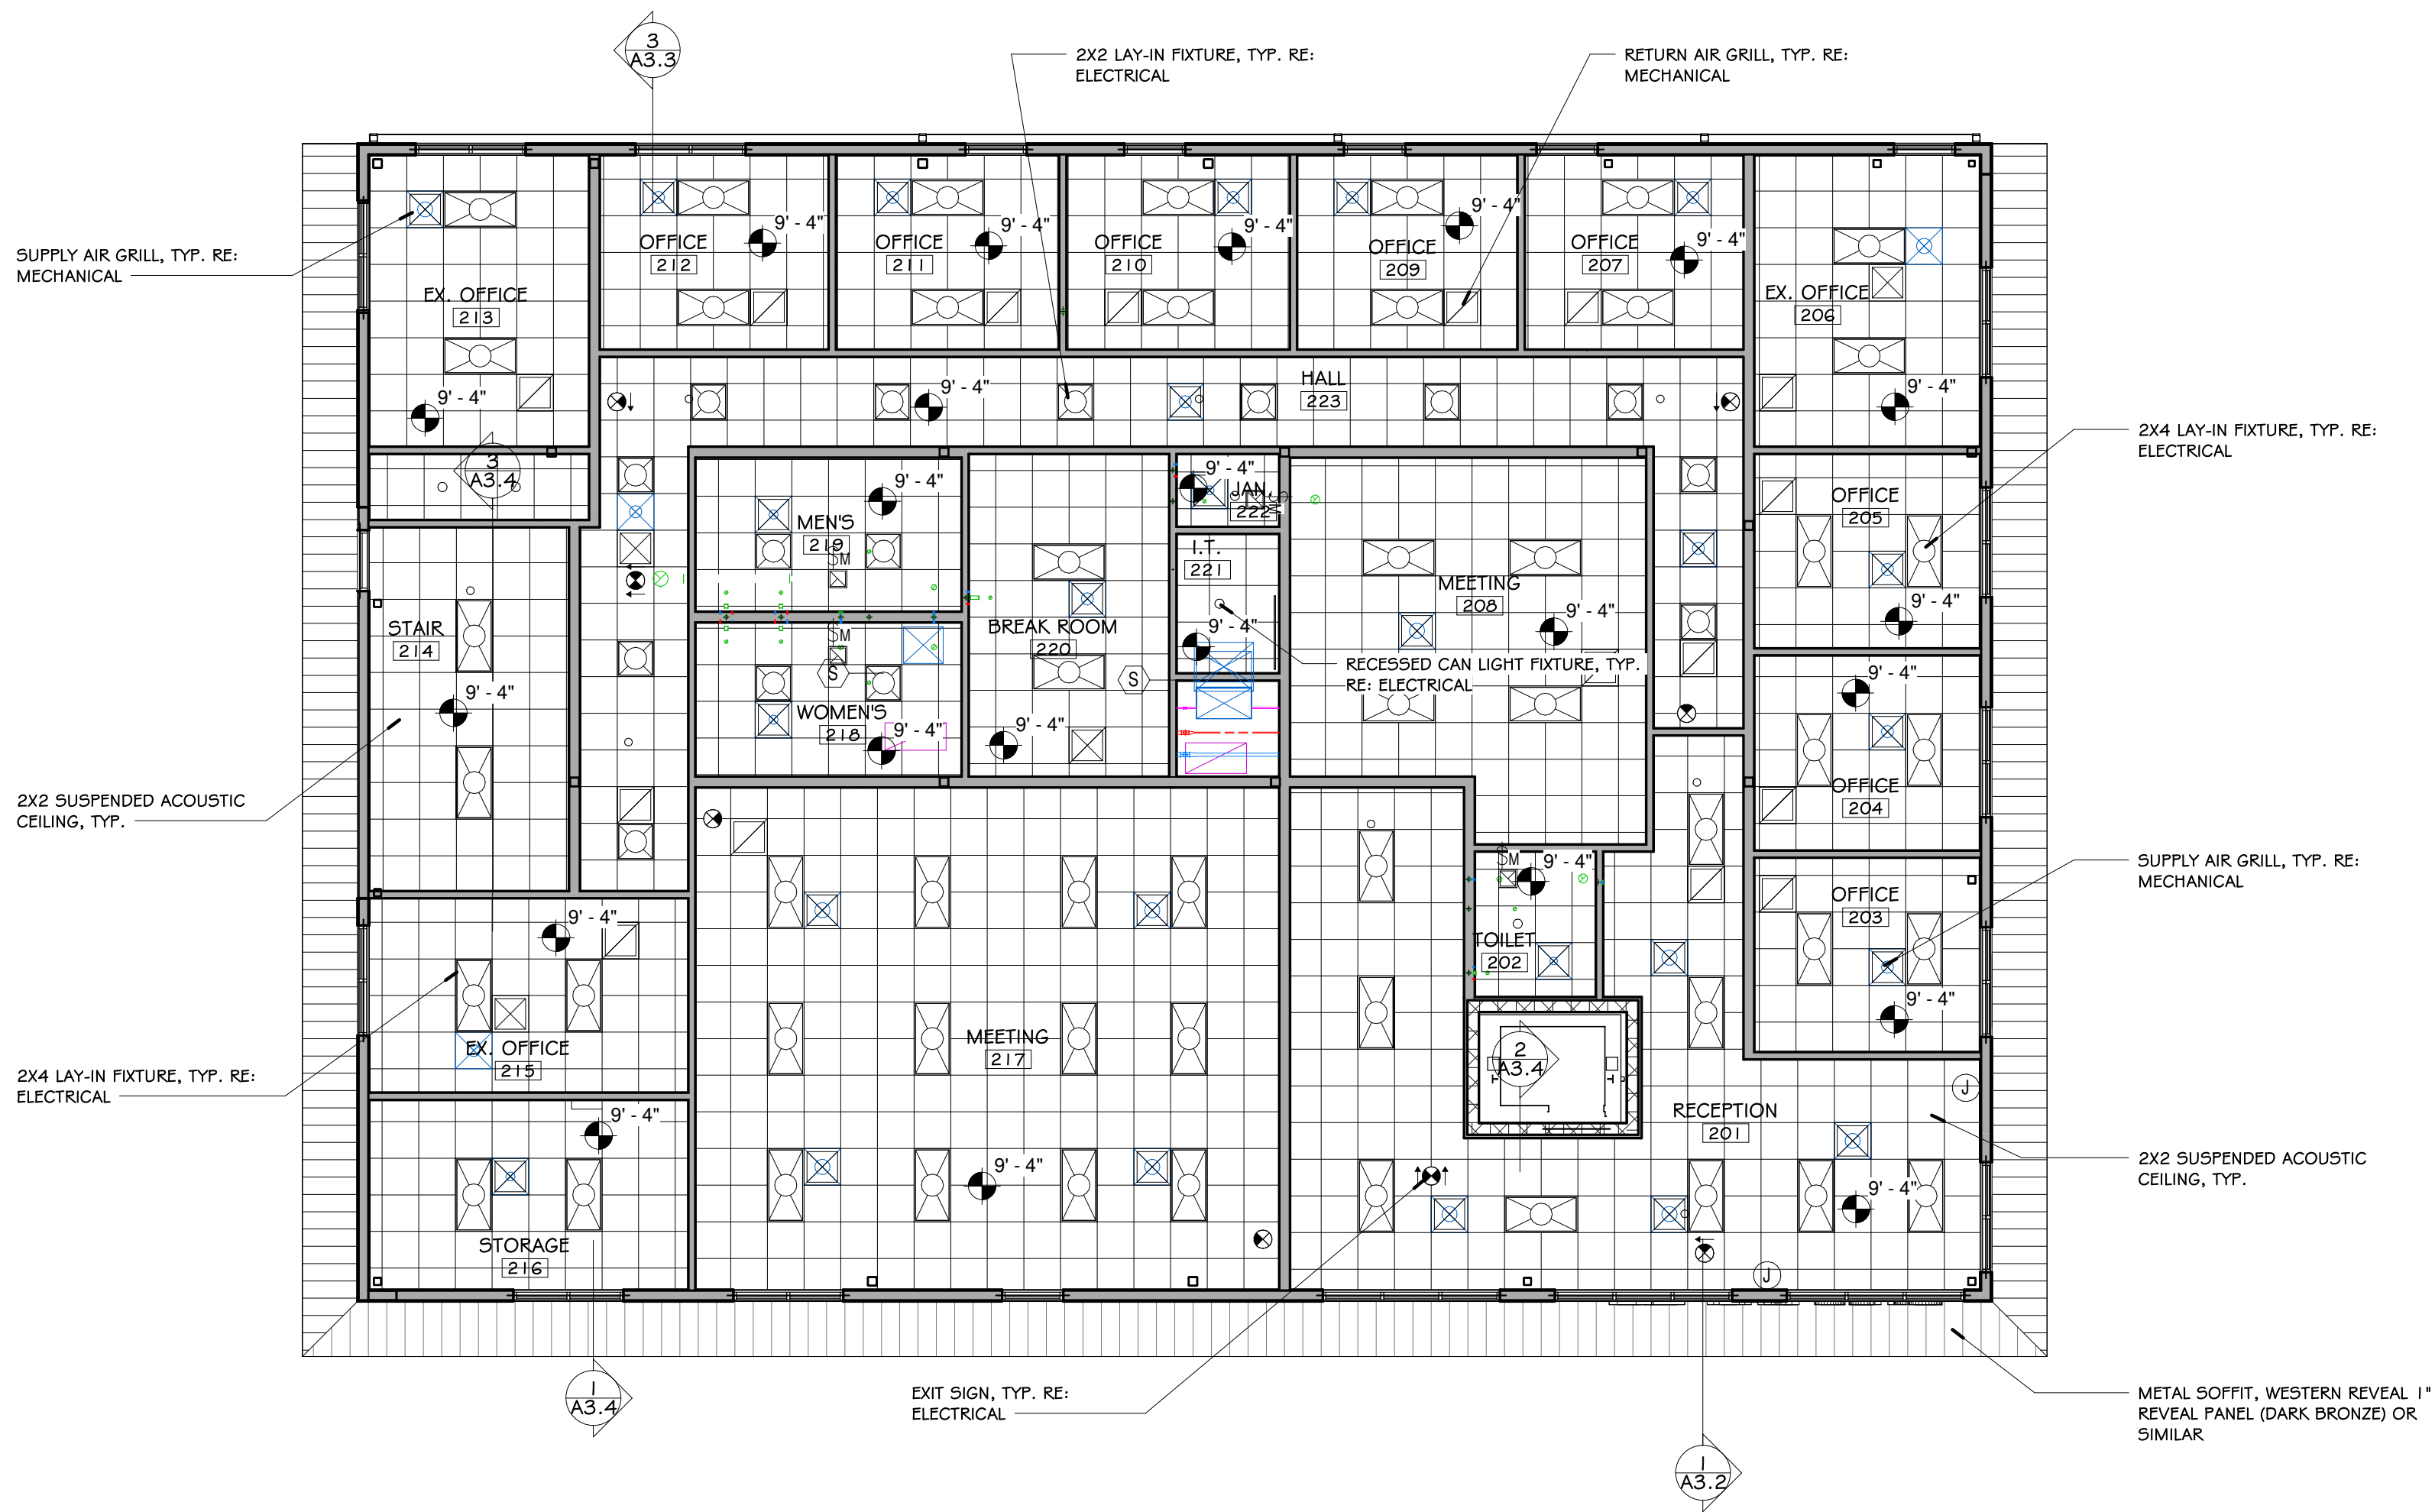

1 2ND FLOOR CEILING PLAN
SCALE = 1/8" = 1'-0"

GENERAL CEILING NOTES

1. REFER TO THIS PLAN FOR LOCATION AND DESCRIPTION OF CEILING TYPES.
2. REFER TO FINISH SCHEDULE FOR ACOUSTICAL CEILING INFORMATION.
3. THE STARTING POINT FOR THE GRID IS EITHER NOTED OR DIMENSIONED. IF THE STARTING POINT IS NOT INDICATED, THEN THE GRID IS CENTERED WITHIN THE ROOM.
4. REFER TO ENGINEERED LIGHTING PLAN FOR TYPES OF LIGHTING FIXTURES.
5. REFER TO MECHANICAL PLAN FOR LOCATION OF MECHANICAL SUPPLY AND RETURN AIR GRILLS.
6. INSTALL NEW SPRINKLER HEADS, OR TURN DOWN HEADS, AT AREAS OF NEW CONSTRUCTION AS REQUIRED PER CODE AND OCCUPANCY TYPE.

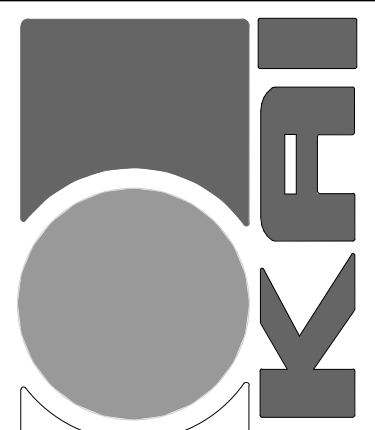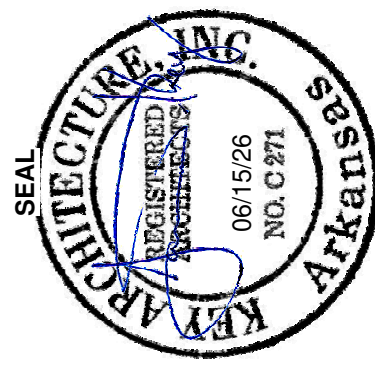

KEY ARCHITECTURE INC.

P.O. BOX 748 FAYETTEVILLE, ARKANSAS 72702
PH: 479.444.6066 FAX: 479.444.1445

FOR PERMIT & CONSTRUCTION

Revision Schedule	
Rev. #	Description

NEW ARcare MEDICAL OFFICE BUILDING

2709 Massard Rd
FT. SMITH, AR 72903

ARcare
117 S. 2ND ST.
AUGUSTA, AR 72006

DATE 06/15/26	DRAWN BY ELP
PROJECT # 2517	CHECKED BY JTK

SHEET

A1.5

2ND FLOOR CEILING PLAN

These Drawings and Specifications are the exclusive property of Key Architecture Inc. and are protected by Copyright. Use or reproduction is prohibited without written consent.