
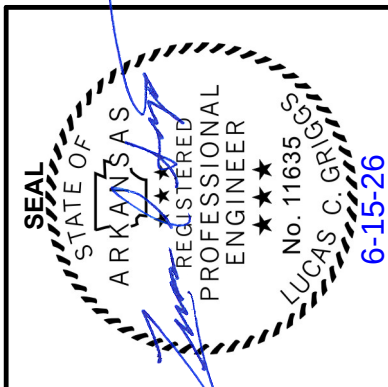


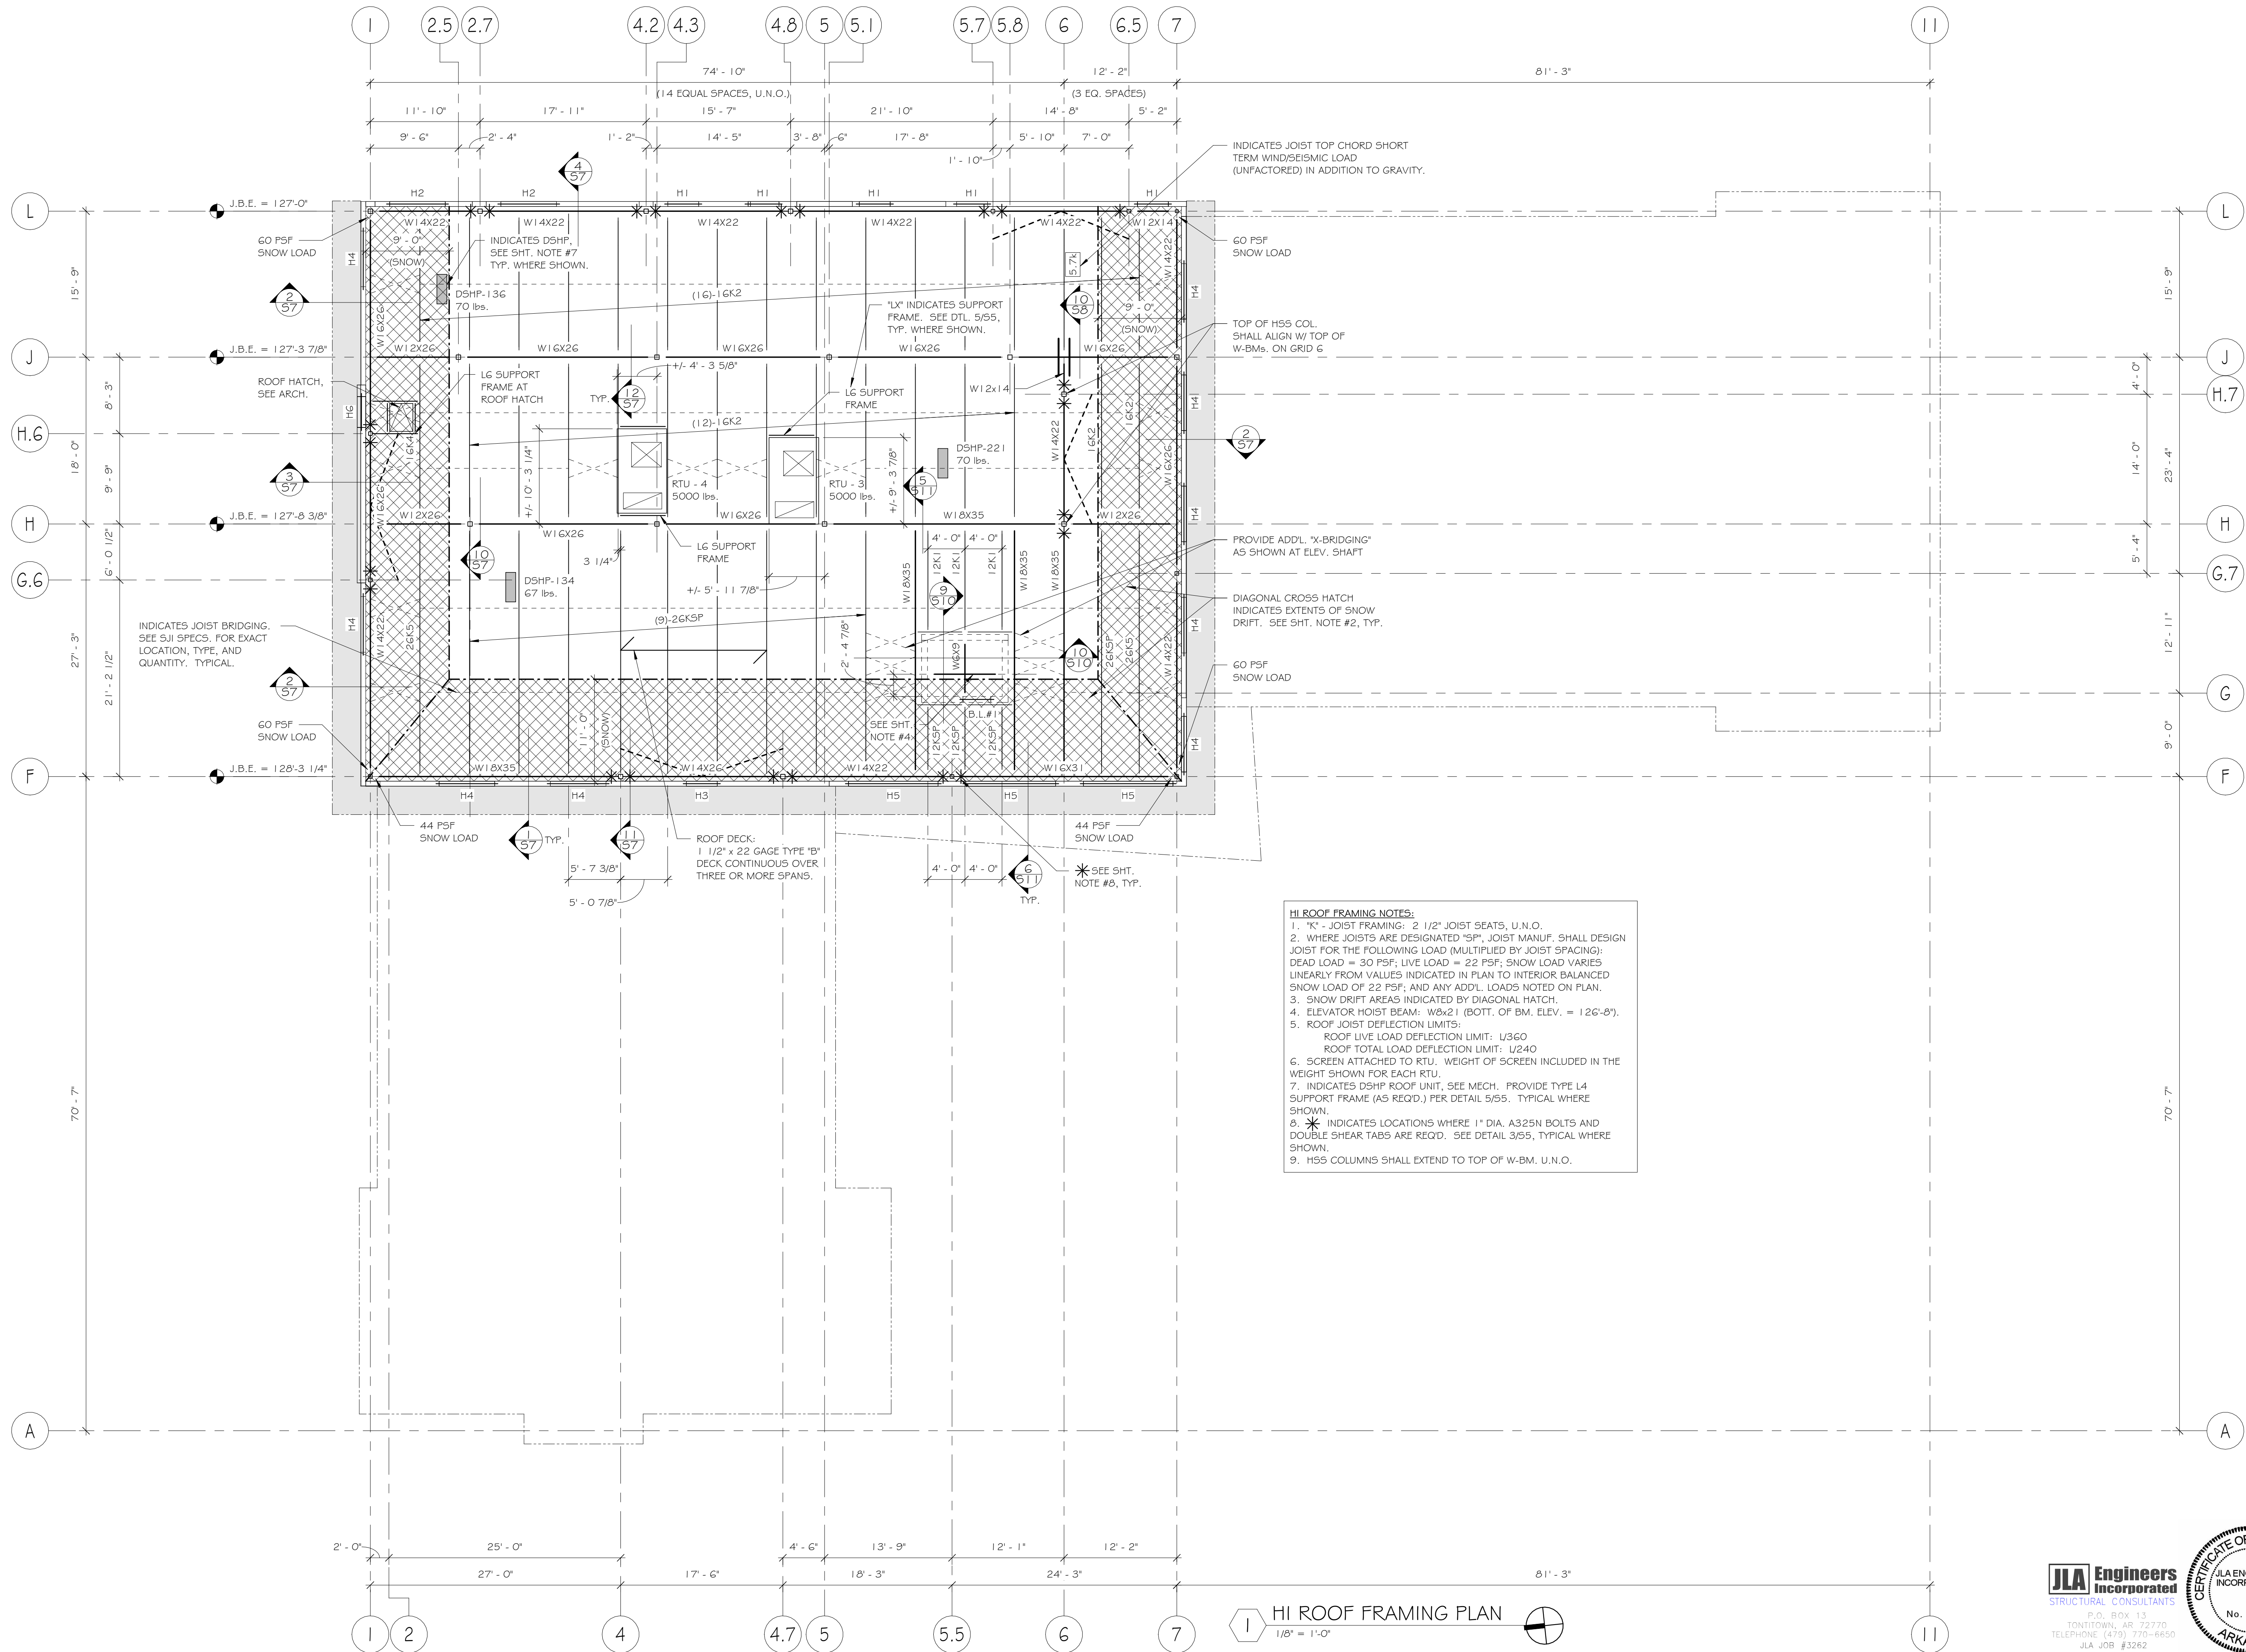

KEY ARCHITECTURE INC.

P.O. BOX 748 FAYETTEVILLE, ARKANSAS 72702
PH: 479.444.6066 FAX: 479.444.1445

FOR PERMIT & CONSTRUCTION

NEW Arcare MEDICAL OFFICE BUILDING
2709 Massard Rd
FT. SMITH, AR 72903

ARCARE
117 S. 2ND ST.
AUGUSTA, AR 72006

DATE	DRAWN BY
06/15/26	LCG
PROJECT #	CHECKED BY
2517	LCG

SHEET
S3
HIGH ROOF FRAMING PLAN

These Drawings and Specifications are the exclusive property of Key Architecture Inc. and are protected by Copyright. Use or reproduction is prohibited without written consent.

