
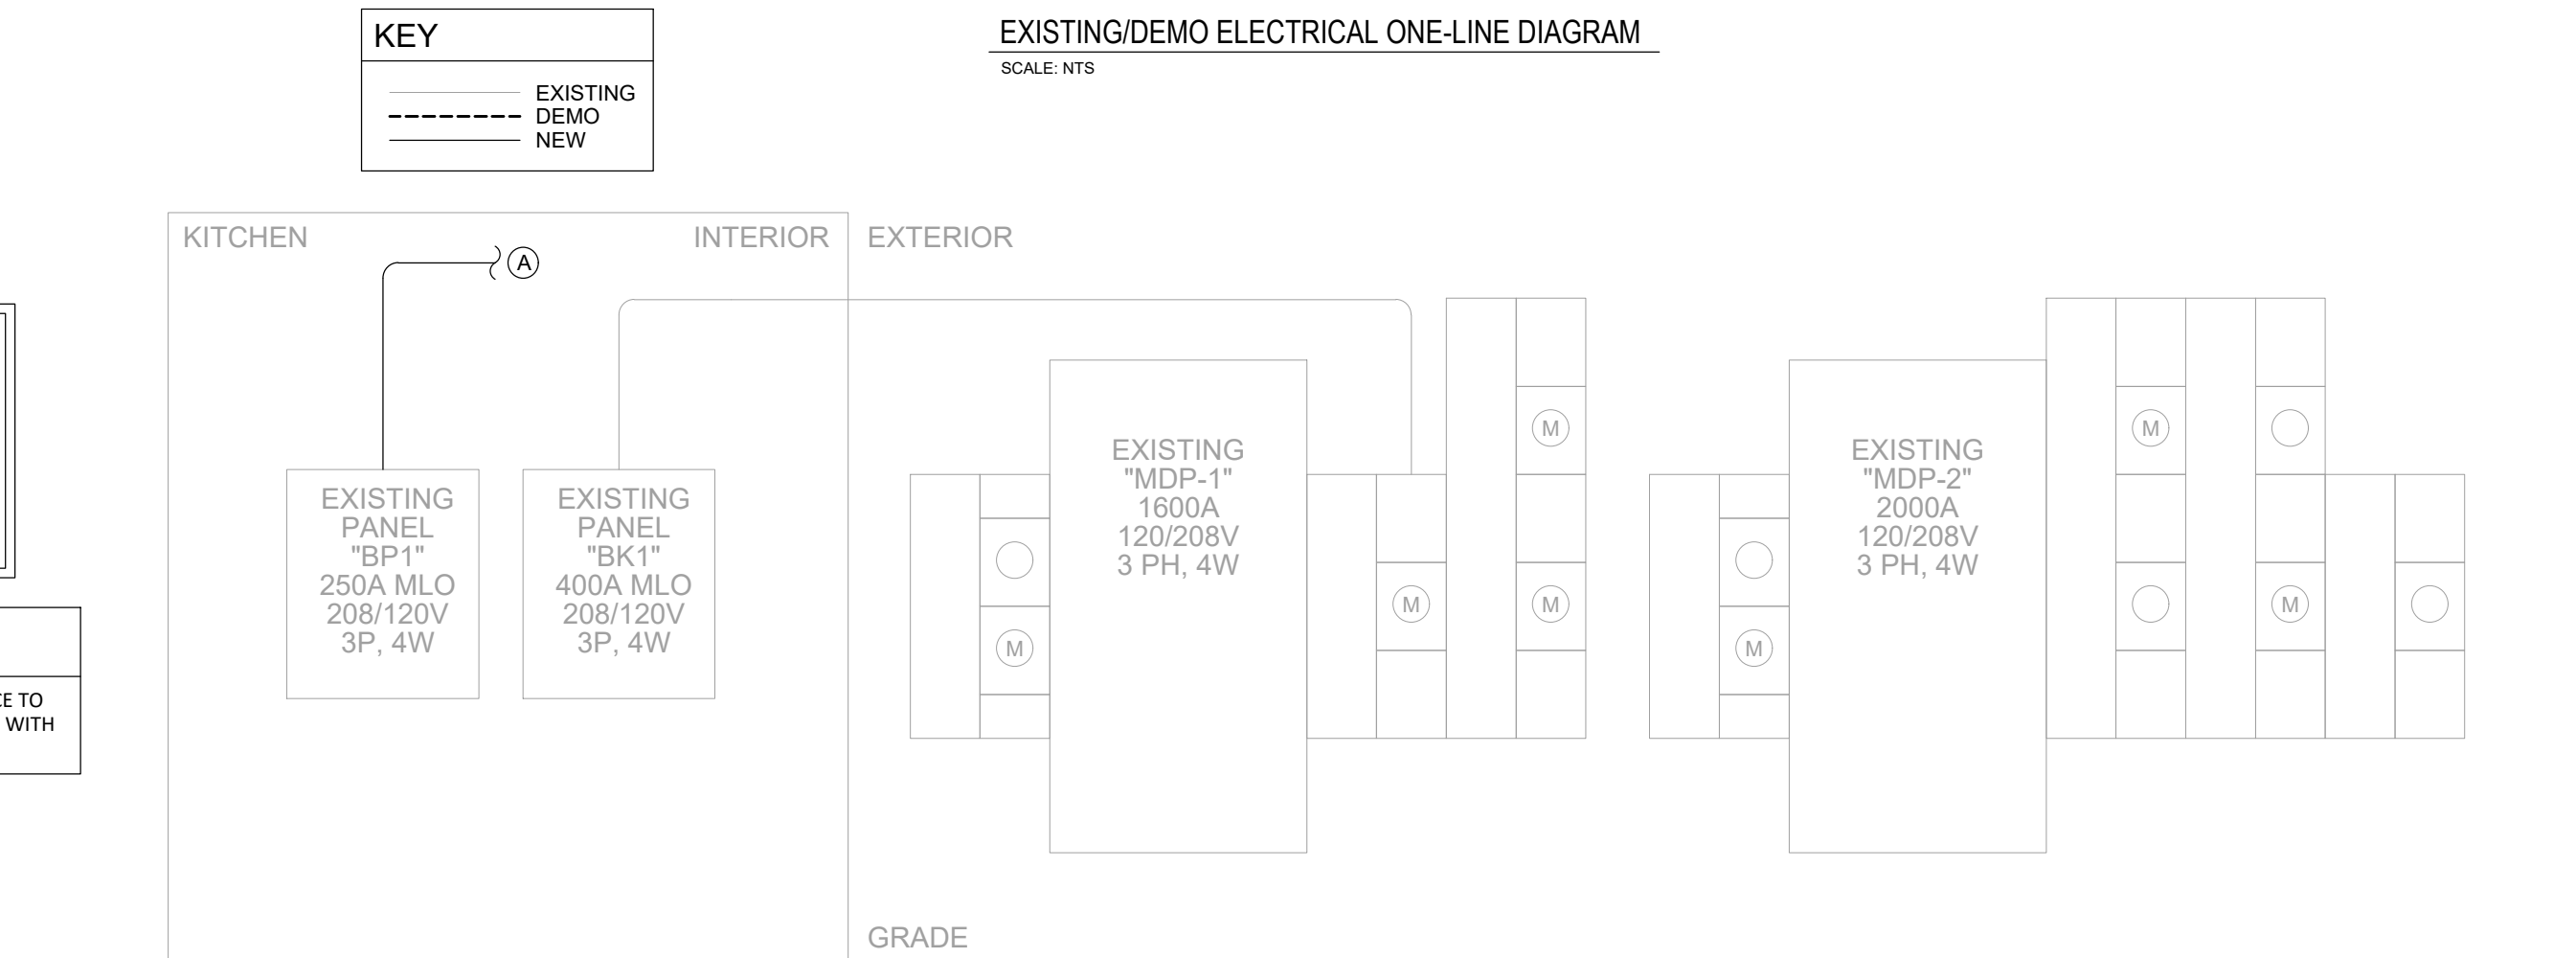


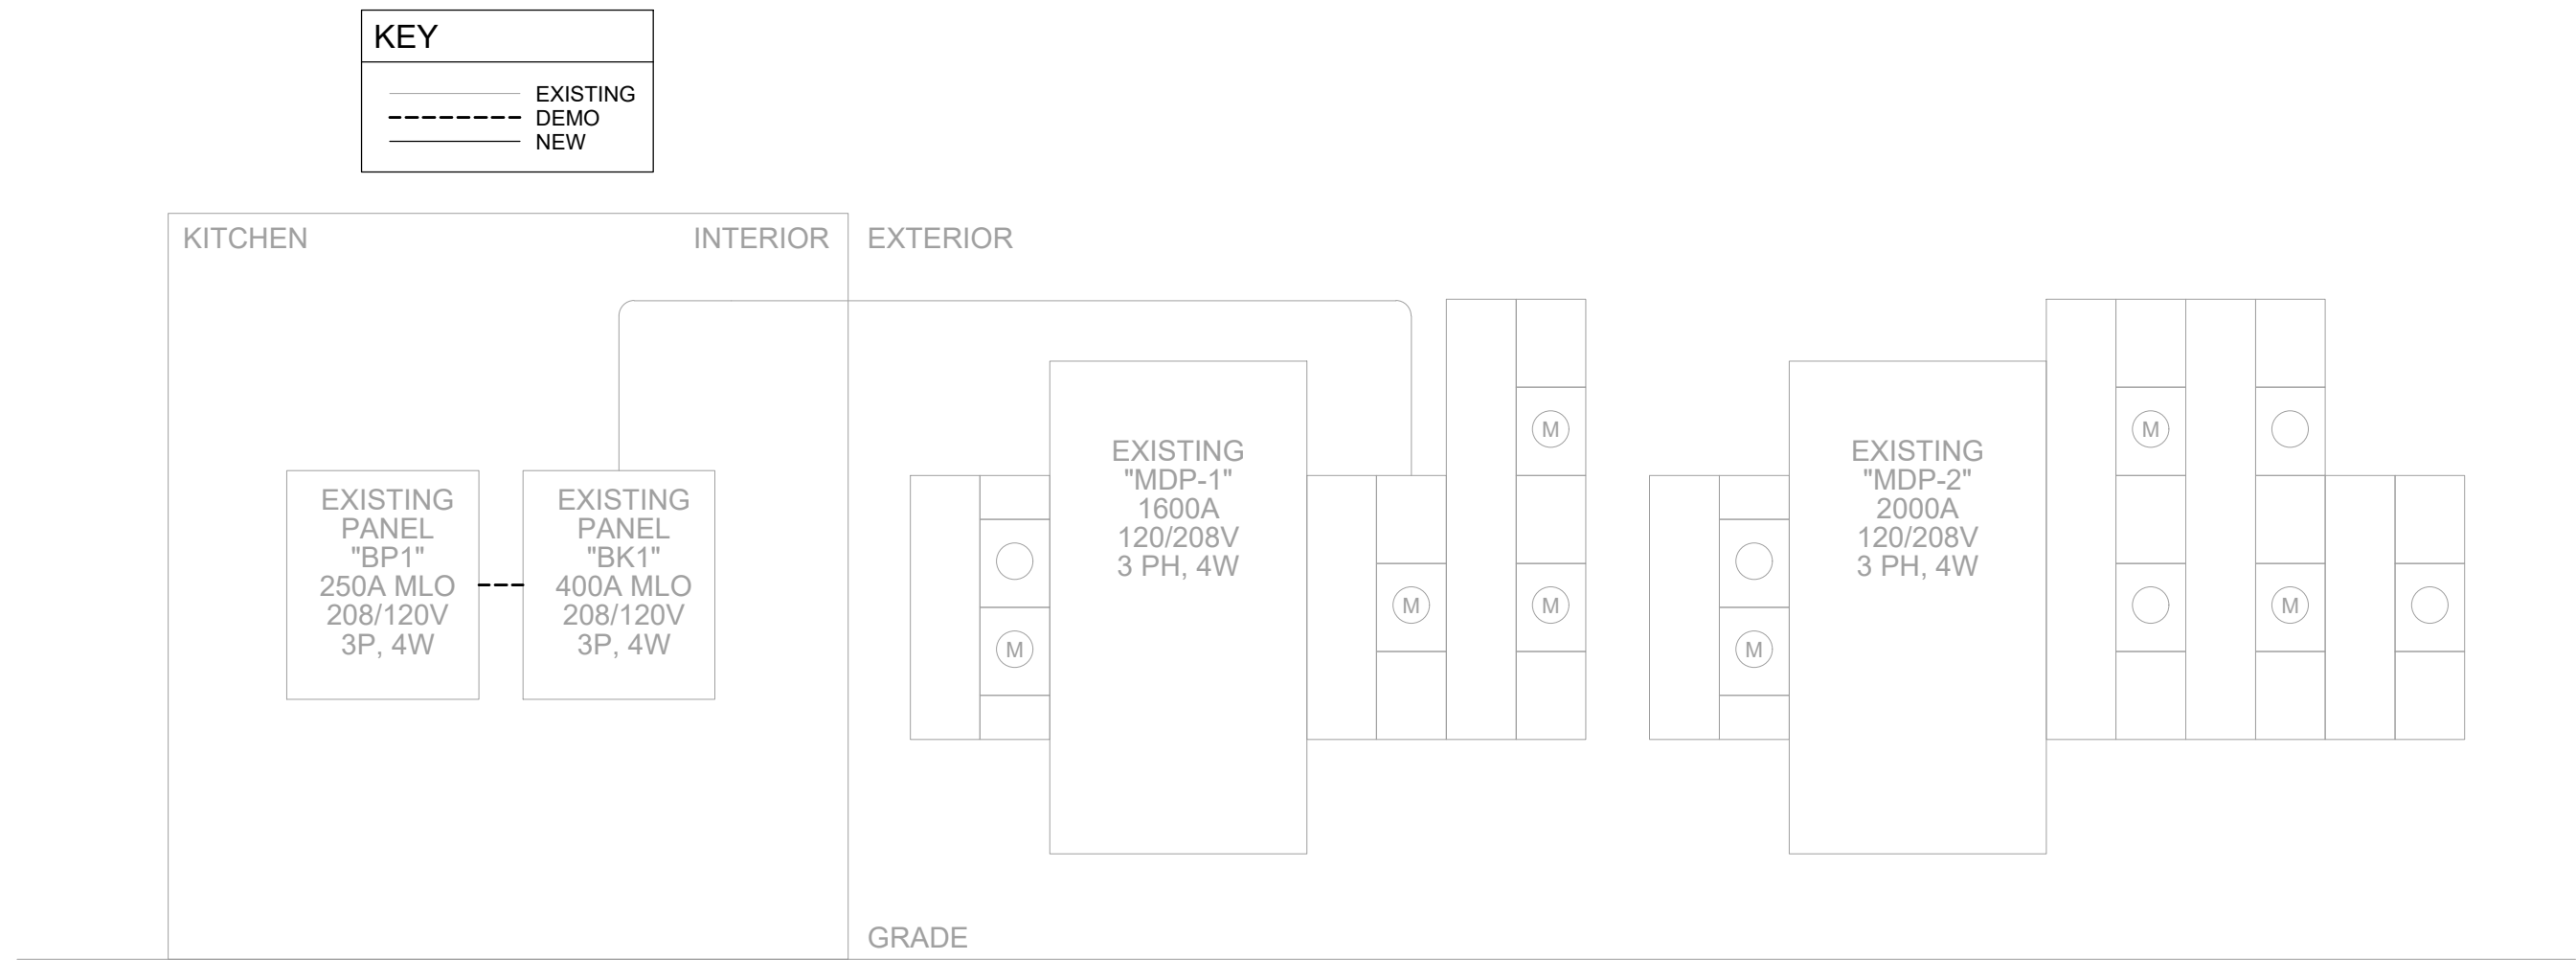


FAULT CURRENT NOTE
SHORT CIRCUIT RATINGS INDICATED IN SCHEDULES ARE FOR PRICING ONLY. ELECTRICAL CONTRACTOR TO WORK WITH SELECTED EQUIPMENT VENDOR AND UTILITY COMPANY TO PROVIDE SHORT CIRCUIT CALCULATIONS BASED ON ACTUAL INSTALL CONDITIONS. CALCULATIONS ARE TO BE SUBMITTED TO ENGINEER VIA SUBMITTAL PROCESS FOR REVIEW.

FEEDER SCHEDULE
(A) (4)-#250, (1)-#4, IN 2-1/2" CONDUIT, ASSUMED >100 FEET DISTANCE TO EXTEND TO EMPTY 250A METER BANK ON EXTERIOR. COORDINATE WITH UTILITY.


IMPROVEMENT ELECTRICAL ONE-LINE DIAGRAM

SCALE: NTS

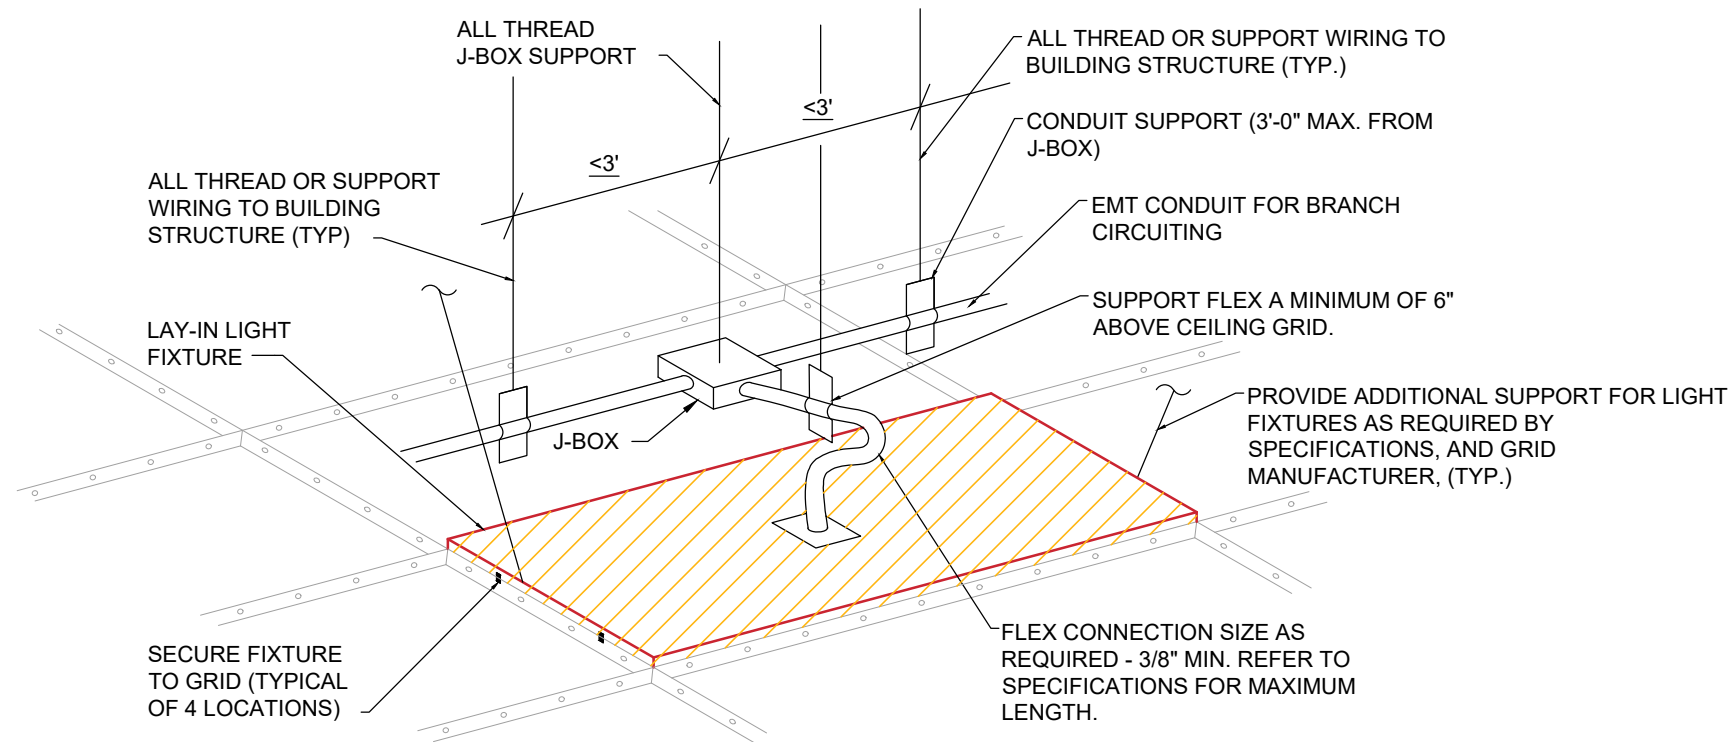


LIGHT FIXTURE INSTALLATION DETAIL

SCALE: NTS

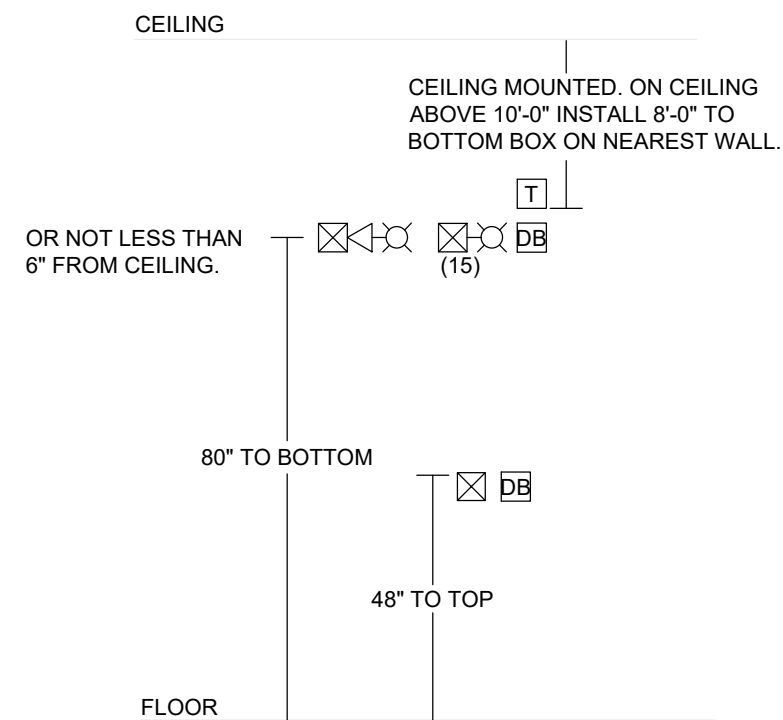


FIRE ALARM DEVICE MOUNTING DETAIL

SCALE: NTS

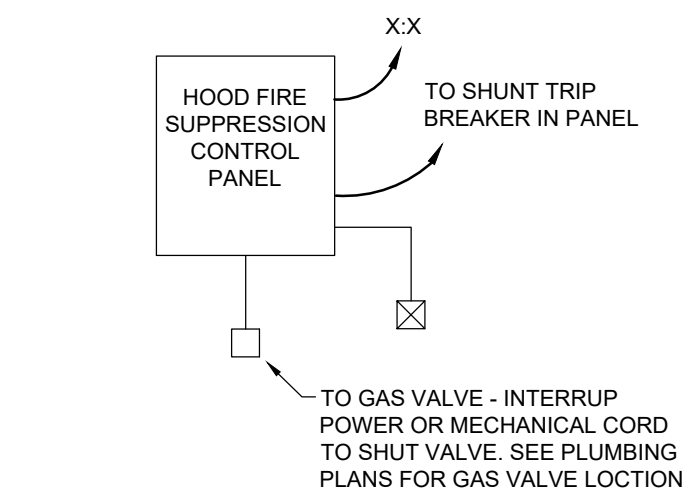


FIRE SUPPRESSION SYSTEM RISER DIAGRAM

SCALE: NTS

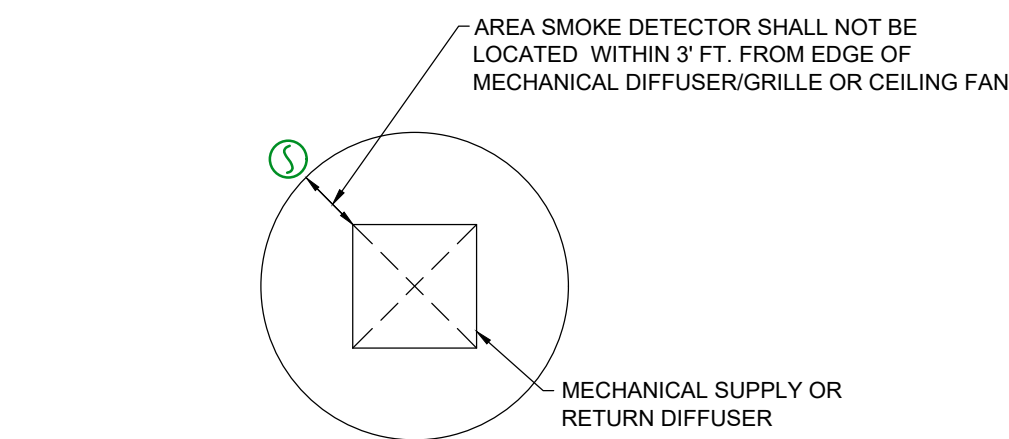

SMOKE DETECTOR INSTALLATION DETAIL

SCALE: NTS

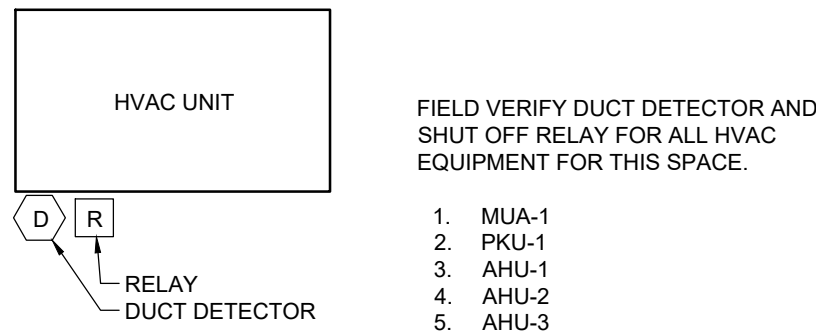

DUCT DETECTOR/SHUT-OFF RELAY

SCALE: NTS