


ADDITION / ALTERATION OF
FIRE STATION
 ARKANSAS AIR NATIONAL GUARD
 FORT SMITH, ARKANSAS

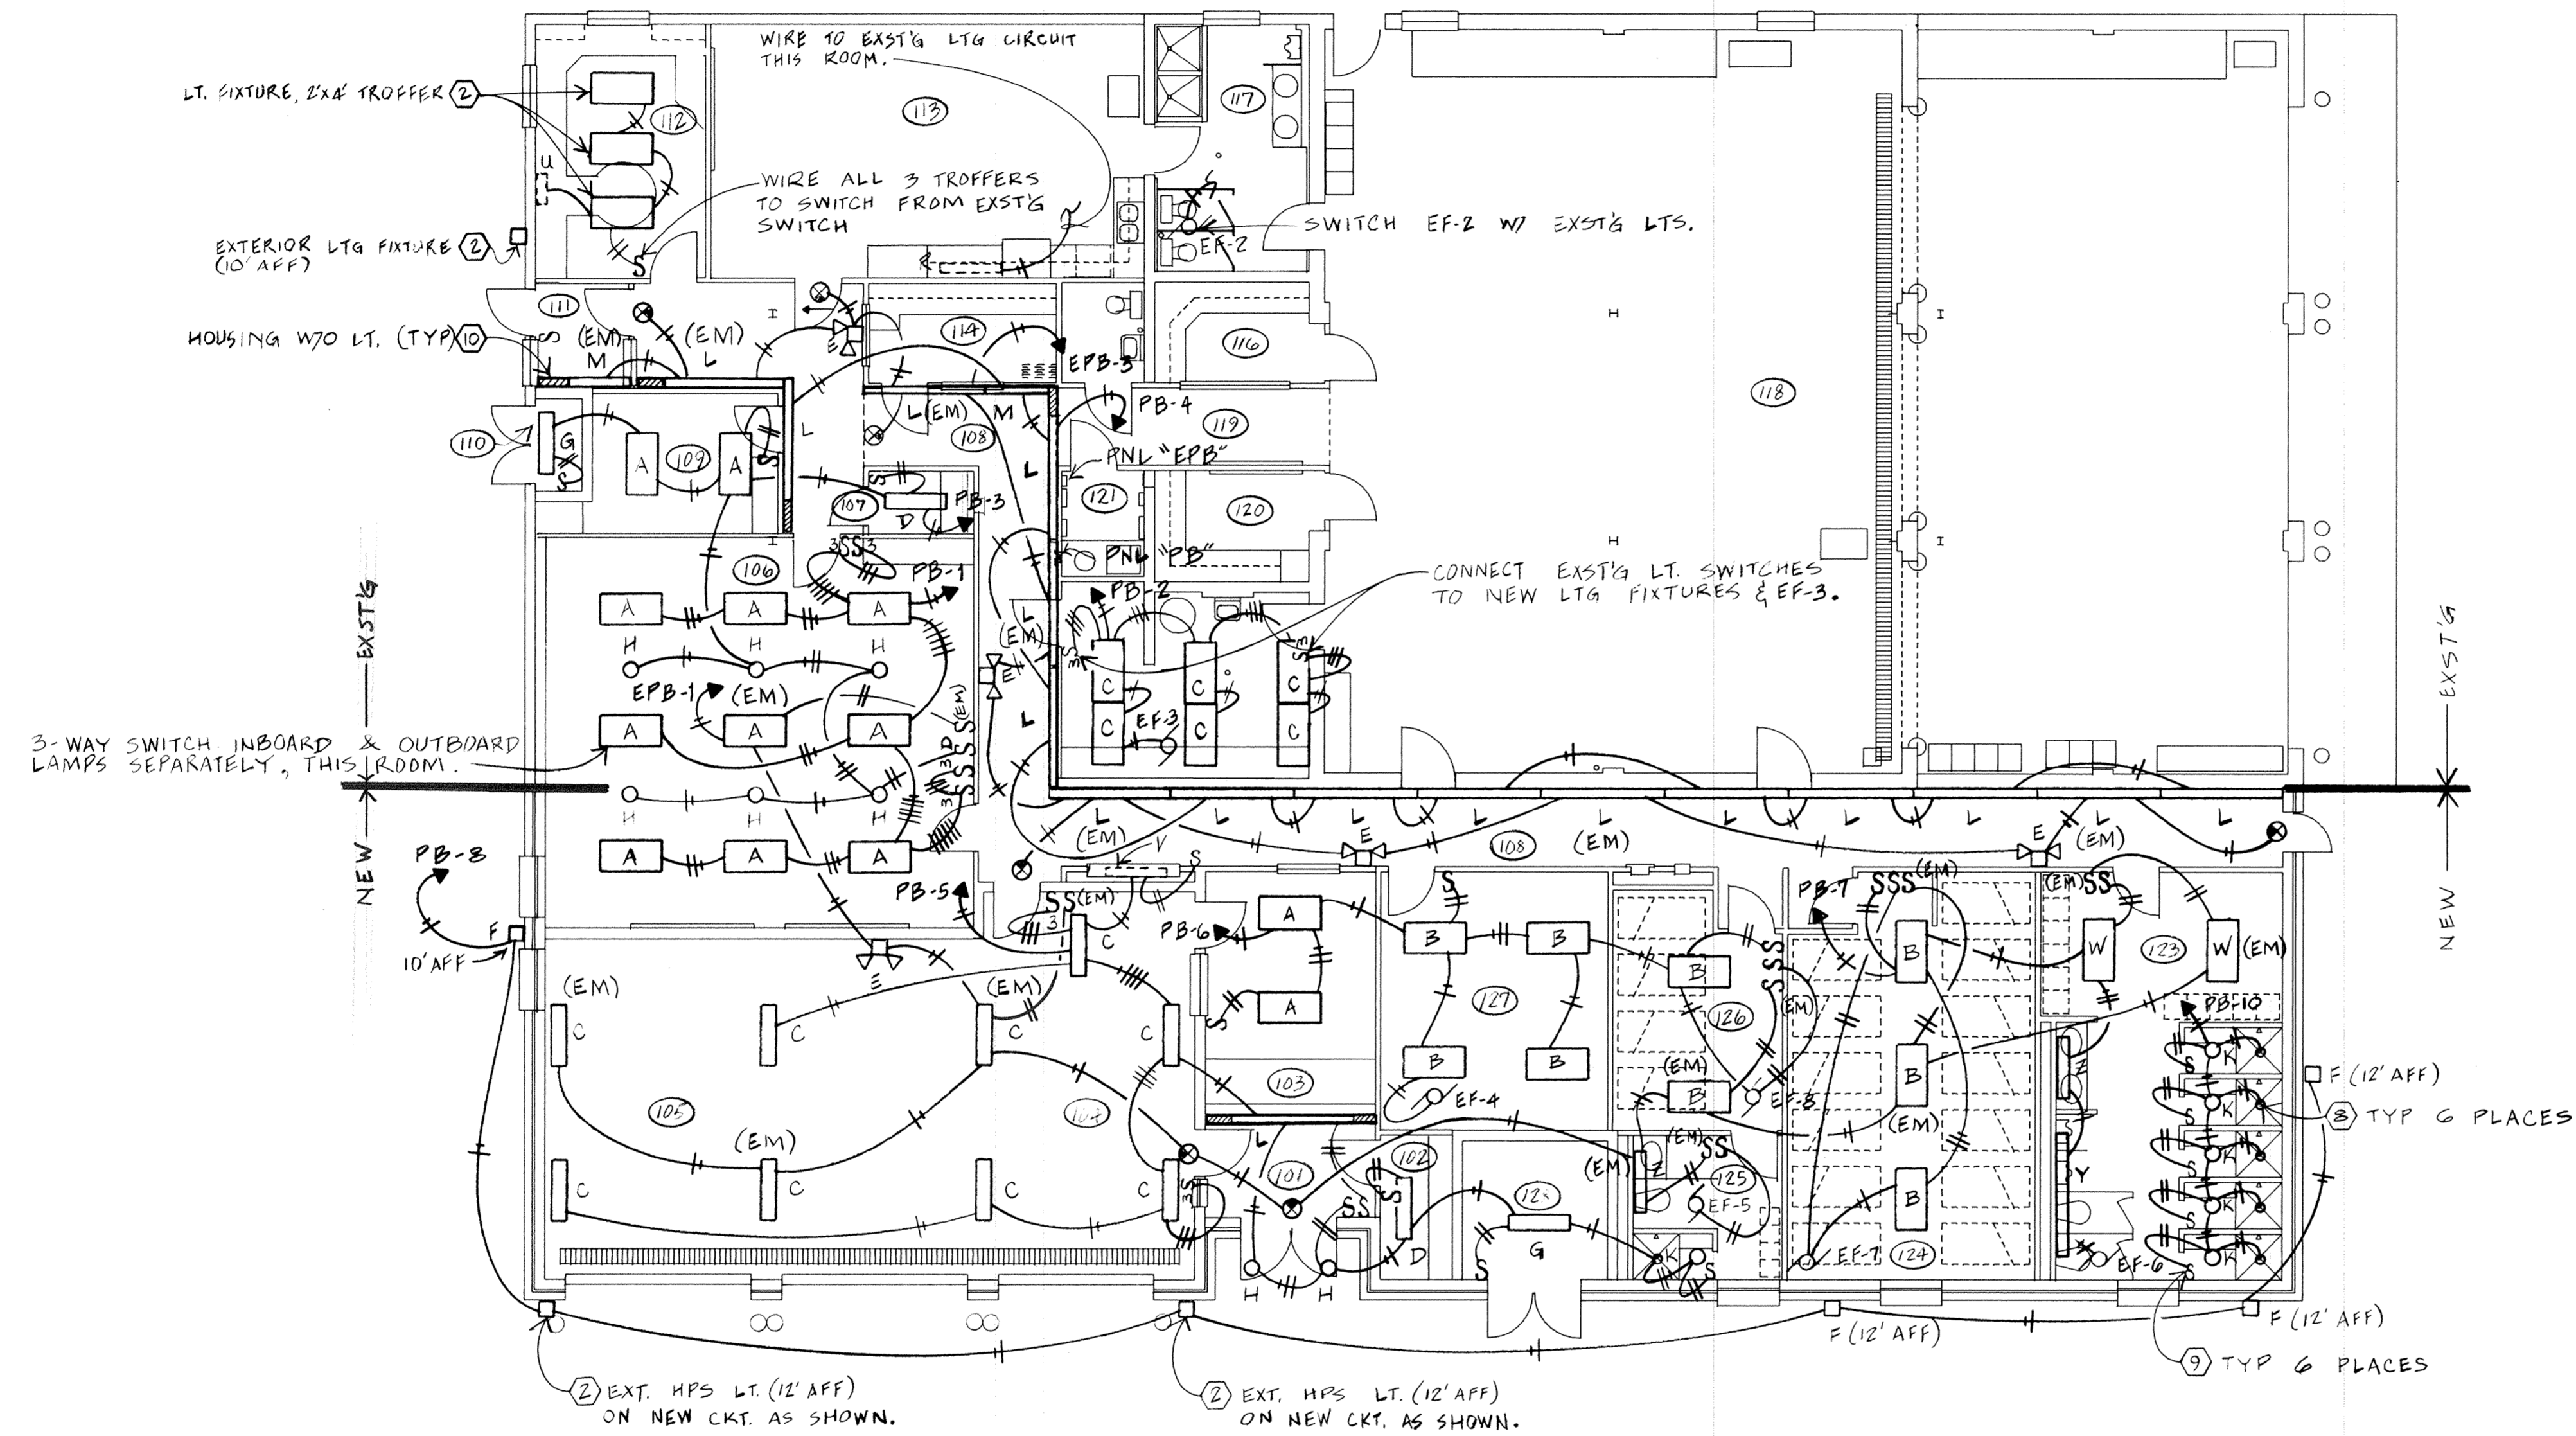

A LIGHTING PLAN
 SCALE: 1/8" = 1'-0"
 NORTH

REF:SEE SHT. E-2 FOR ELECT. NOTES & LEGEND.
 SEE SHT. E-5 FOR ELECT SCHEDULES, DETAILS & RISERS

a+ architecture plus
 120 North 9th Street • Fort Smith, Arkansas • 501/783-8395
OMG O. MICHAEL GREEN ENGINEERING INC
 SUITE 610 FIRST PLACE • FAJETEVILLE ARKANSAS • (501) 442-4682

LIGHTING PLAN

REVISIONS:

PROJECT: **88-18**

DATE: 7-24-89

SHT. **E-3** of **5**

