


ADDITION / ALTERATION OF  
**FIRE STATION**  
 ARKANSAS AIR NATIONAL GUARD  
 FORT SMITH, ARKANSAS

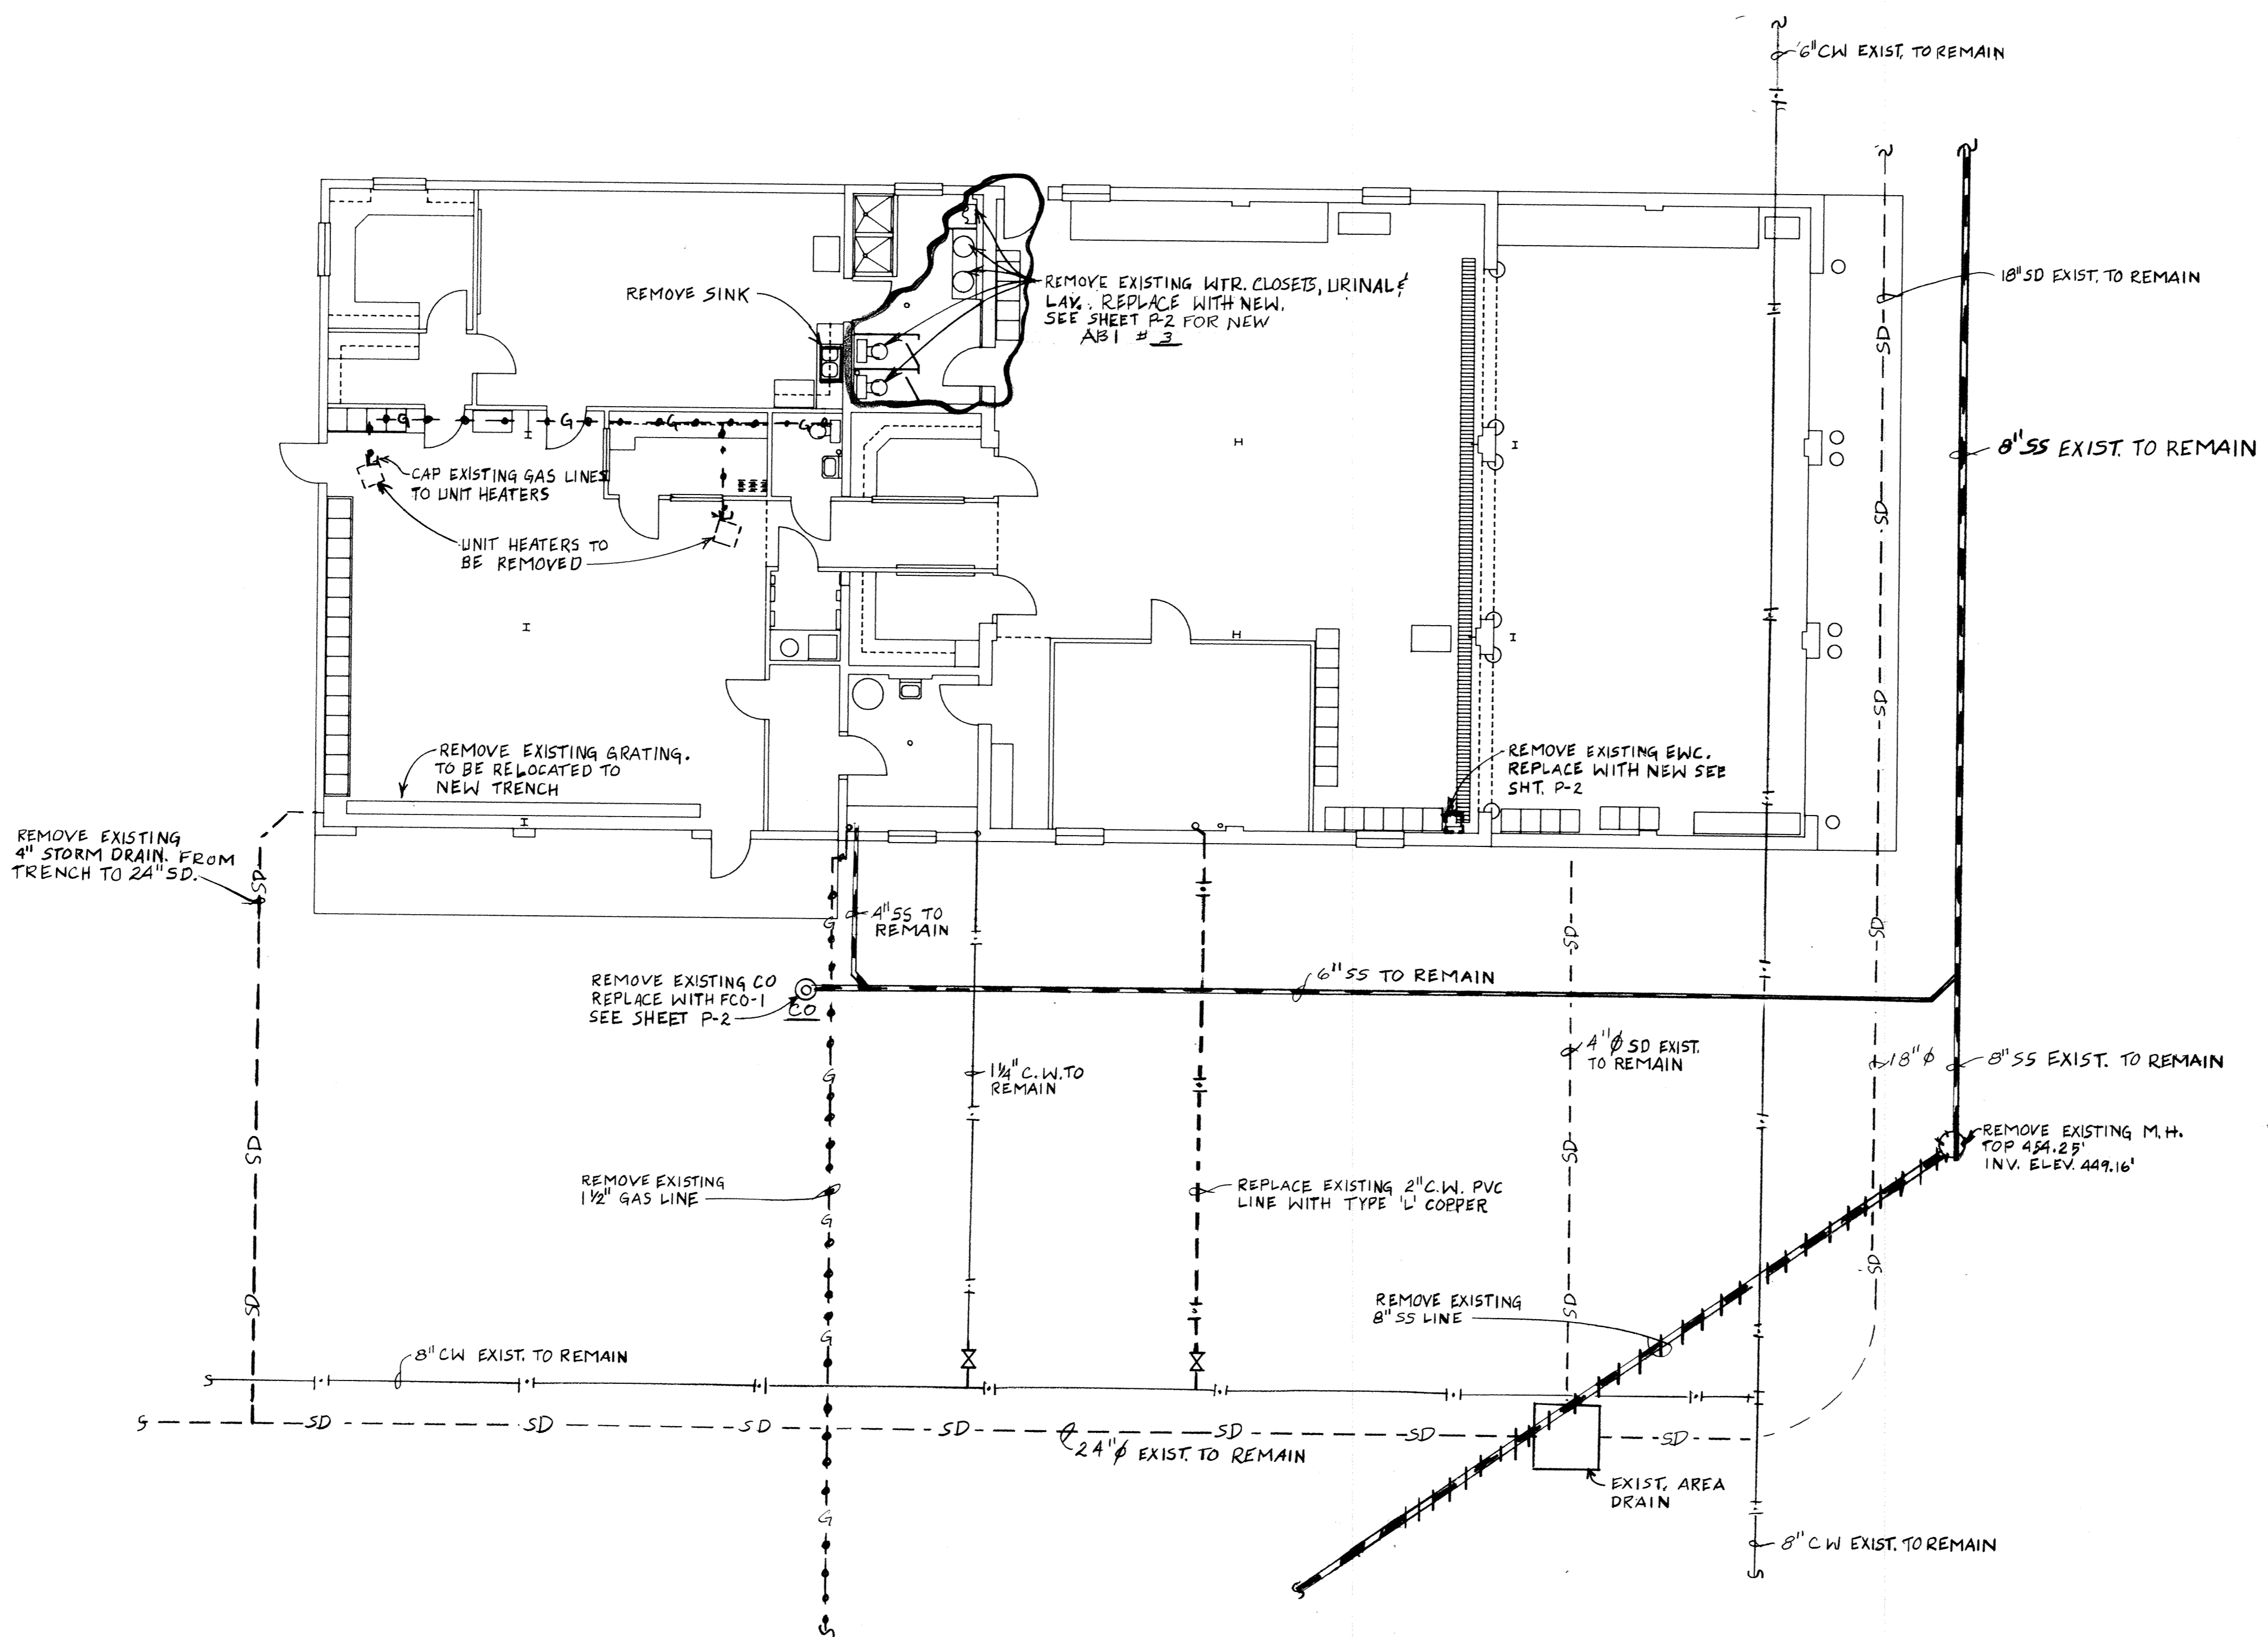

**PLUMBING LEGEND**

- SD--- EXIST'G STORM DRAIN
- SD--- EXIST'G SANITARY DRAIN
- SD--- DRAIN, SANITARY SEWER (SS)
- SD--- COLD WATER (CW)
- SD--- HOT WATER (HW)
- SD--- GAS (G)
- SD--- VENT (V)
- SD--- VENT THRU ROOF (VTR)
- SD--- HOT WATER RETURN (HWR)
- SD--- PIPE ELEVATION CHANGE
- SD--- PIPE RISER
- SD--- GATE VALVE
- SD--- FROST PROOF HOSE BIBB (FPHB)
- SD--- FLOOR DRAIN (FD), SAFE WASTE DRAIN (SWD)
- SD--- FLOOR CLEAN OUT (FCO)
- SD--- CLEAN OUT TO GRADE (COTG)
- SD--- WALL CLEAN OUT (WCO)
- SD--- TEMPERATURE & PRESSURE (T&P) RELIEF VALVE
- SD--- WATER HAMMER ARRESTOR
- SD--- CONDENSATE DRAIN
- SD--- PRESSURE REDUCING VALVE (PRV)
- SD--- UNION
- SD--- CHECK VALVE
- SD--- EXISTING TO BE REMOVED
- SD--- EXIST'G CW
- SD--- EXIST'G HW
- SD--- EXIST'G GAS
- SD--- EXIST'G VENT

**PLUMBING DEMOLITION PLAN**  
 SCALE: 1/8" = 1'-0"

**PLUMBING DEMOLITION NOTES**

- 1 EXST'G ITEMS OF VALUE TO BE REMOVED AND NOT RELOCATED ARE TO BE DELIVERED TO THE BASE CIVIL ENGR FOR DISPOSAL. THOSE OF NO VALUE TO BE DISPOSED OF BY CONTRACTOR. DISPOSAL OF ANY ITEMS IN QUESTION TO BE DETERMINED BY BASE CIVIL ENGR.

**a+ architecture plus**  
 120 North 9th Street • Fort Smith, Arkansas • 501/783-8395

**OMG O. MICHAEL GREEN ENGINEERING INC.**  
 SUITE 610 FIRST PLAZA • FAYETTEVILLE, ARKANSAS • (501) 442-4882

**PLUMBING DEMOLITION PLAN**

REVISIONS:

PROJECT: **88-18**

DATE: **7-24-89**

SHT. **P-1** of **3**

