


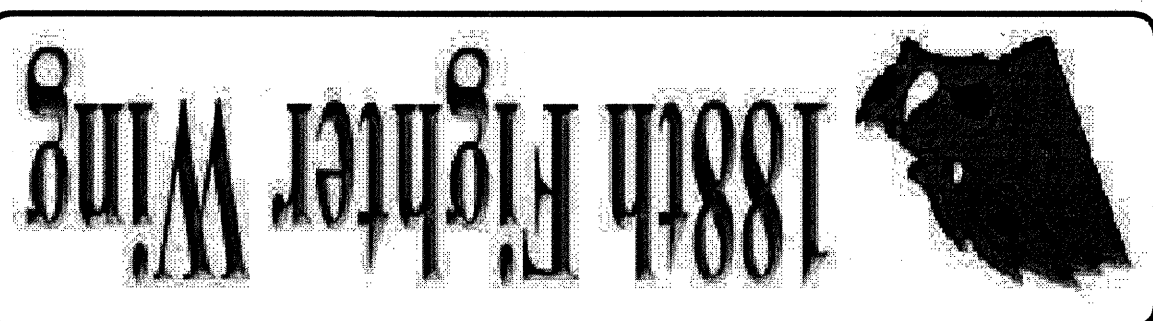

POND
Architects • Engineers • Planners
3500 Parkway Lane
Atlanta, GA 30302
Phone 770-336-7744
Fax 770-336-7744
Web www.pondco.com

Copyright 2008 by Pond & Company. All rights reserved. This document is the property of Pond & Company. It is to be used only for the specific project identified or referred to herein and is not to be used on other projects, in whole or part, except by the express written agreement of Pond & Company.





Mark	Description	Date	Appr.
0	ISSUED FOR CONSTRUCTION	4/11/08	

Designed By:	SRS
Drawn By:	CMR
Checked By:	SHR
Reviewed By:	KES
Date:	4-11-08

COMPOSITE A-10 AIRCRAFT MAINTENANCE FACILITY
FL. SMITH, ARKANSAS
ROOF PLAN

Sheet reference number:
A-102
Sheet 17 of 69

- NOTES:**
- SEE MECHANICAL, PLUMBING, AND ELECTRICAL DRAWINGS FOR MISCELLANEOUS ROOF ITEMS.
 - FOLLOW SMAGNA AND MANUFACTURER'S FLASHING DETAILS AS A BASIS FOR DESIGN.
 - ROOF SYSTEM IS TO COMPLY WITH FM 1-90 CRITERIA.

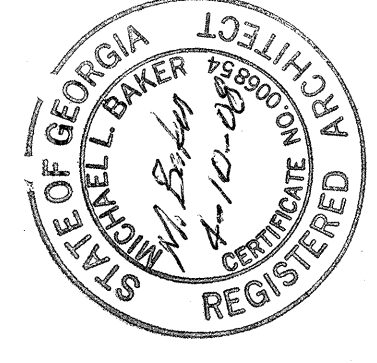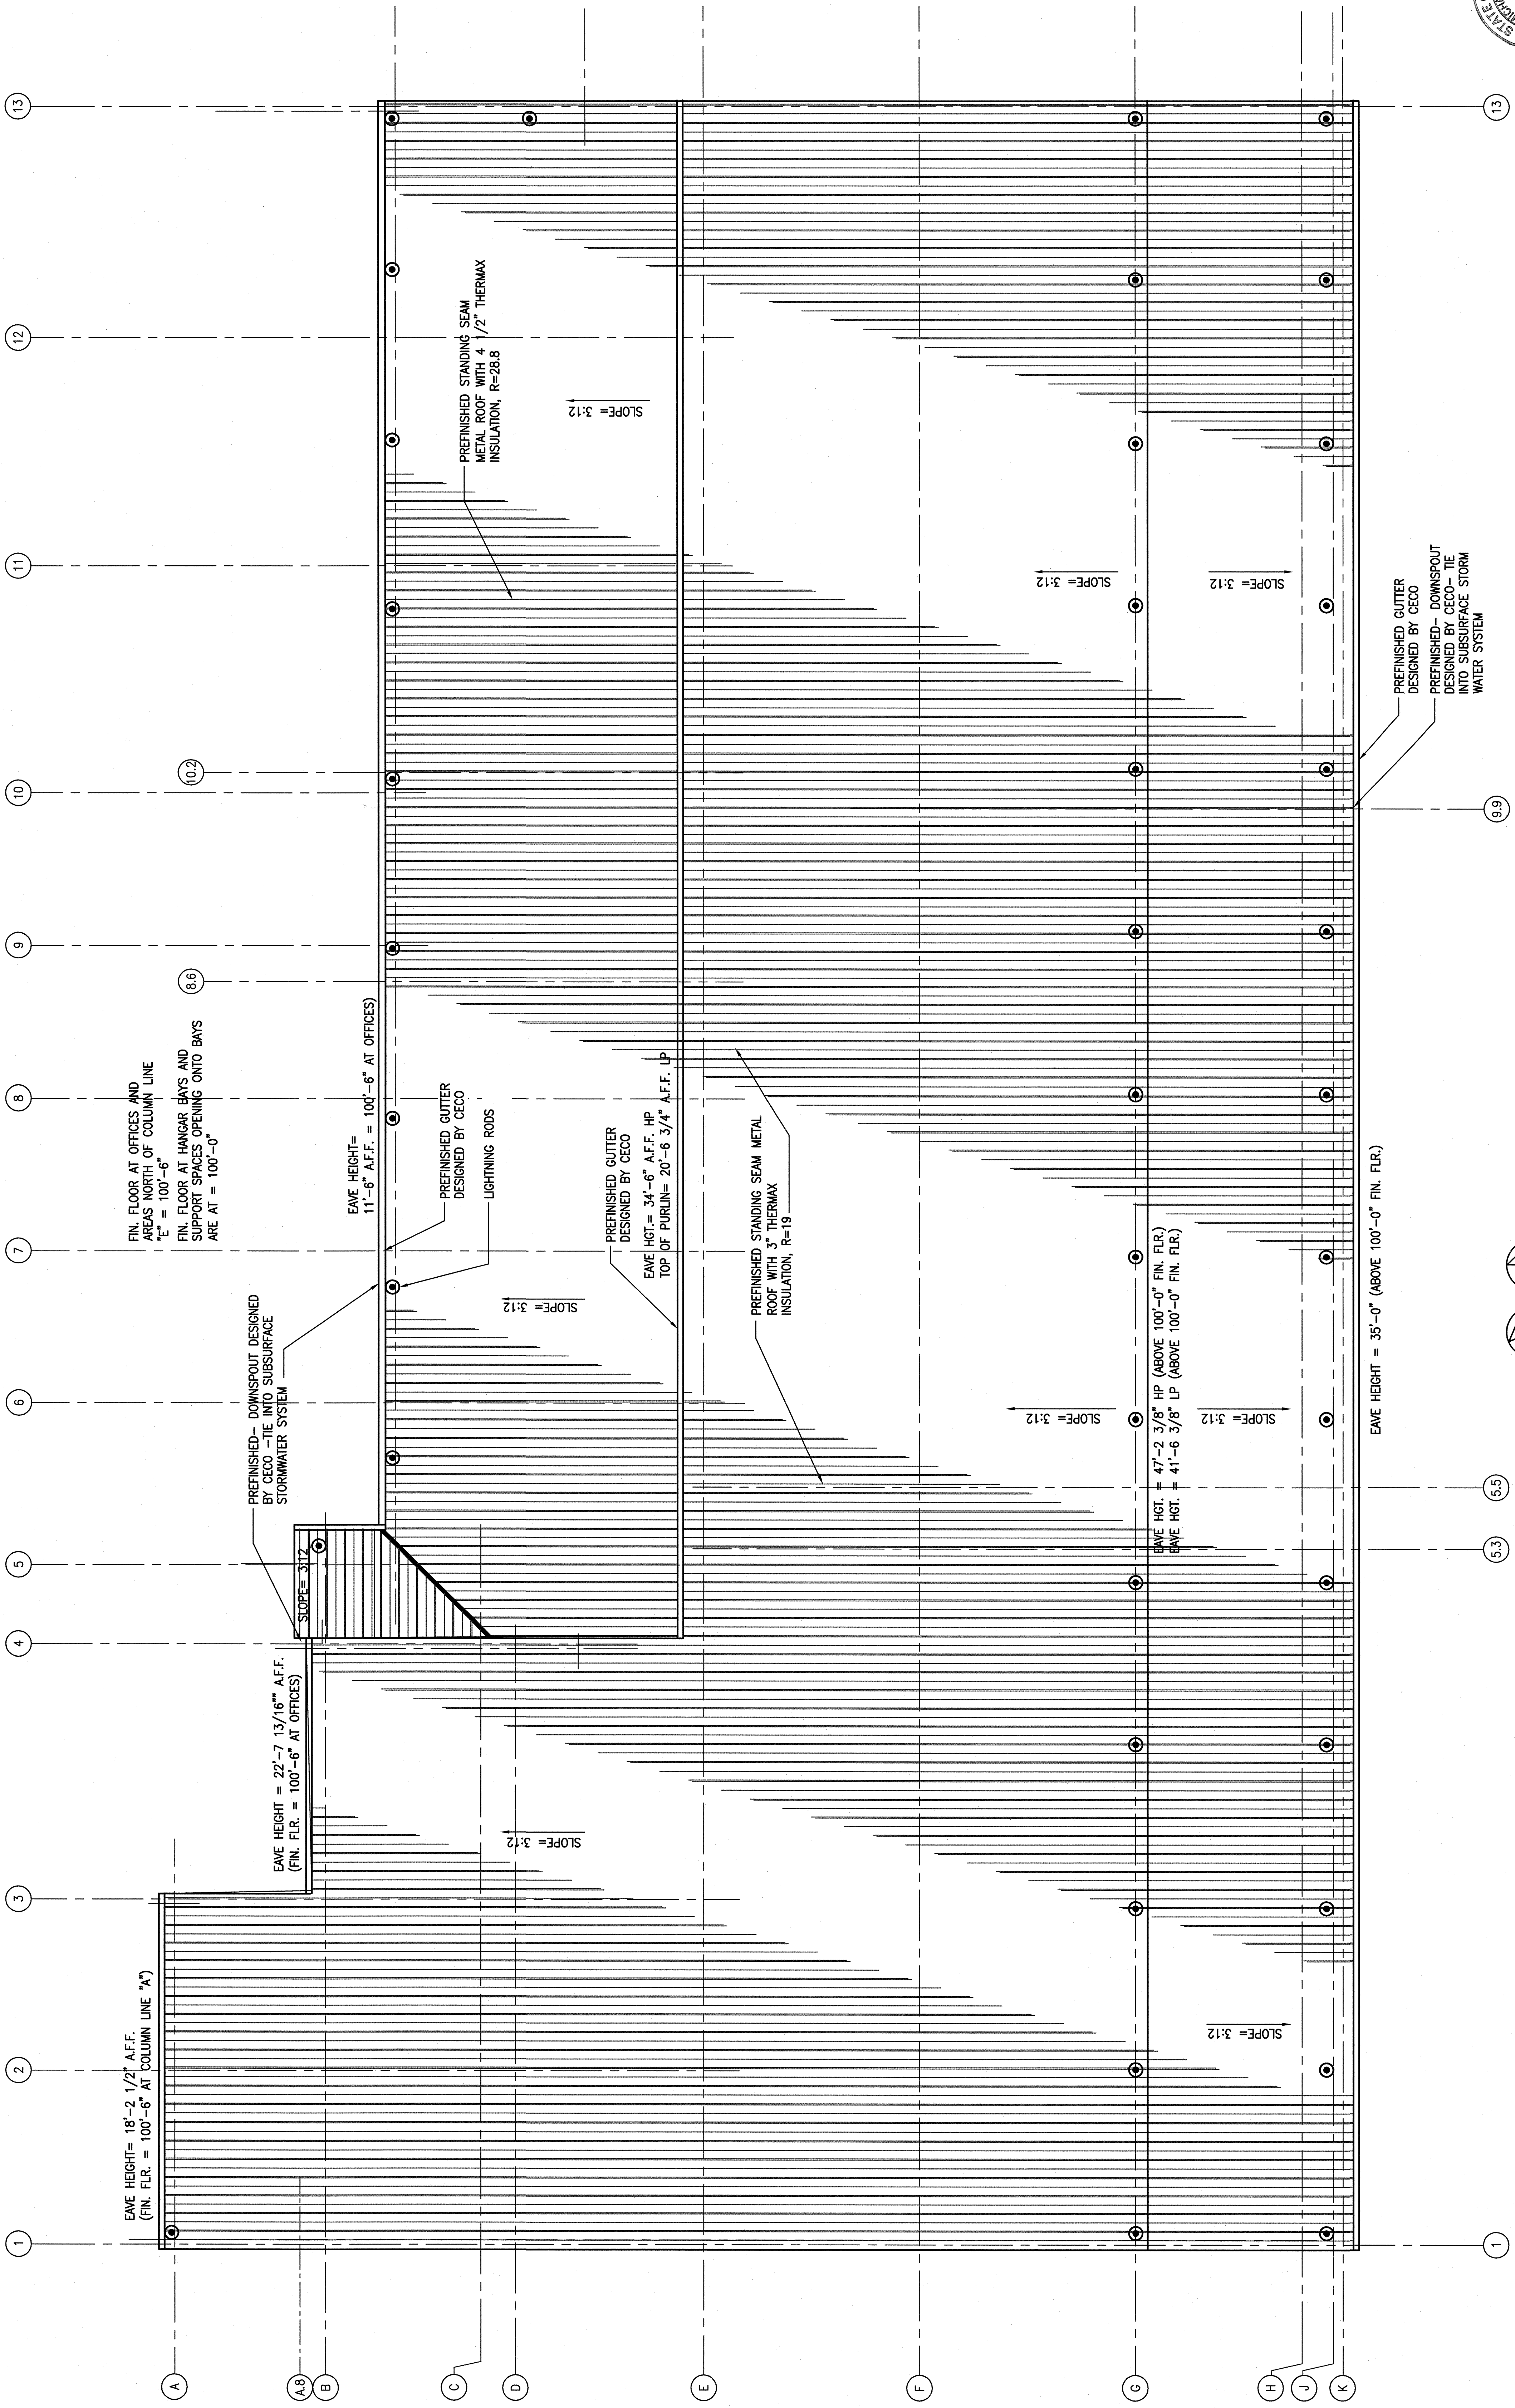

ROOF PLAN
SCALE: 1/8" = 1'-0"

