

**POND**  
 Architects • Engineers • Planners  
 3500 Parkway Lane  
 Suite 600  
 Atlanta, GA 30302  
 Phone 678-336-7740  
 Fax 678-336-7744  
 Web www.pondco.com

Copyright 2008 by Pond & Company. All rights reserved. This document is the property of Pond & Company. It is to be used only for the specific project identified or referred to herein and is not to be used on other projects, in whole or in part, except by the express written agreement of Pond & Company.





**188th Fighter Wing**

Mark	Description	Date	Appr.

Designed by: SRG	
Drawn by: SRG	
Checked by: SRG	
Reviewed by: KCS	
Date: 4-11-08	

COMPOSITE A-10 AIRCRAFT MAINTENANCE FACILITY  
 FT. SMITH, ARKANSAS  
**WALL SECTIONS**

Sheet reference number:  
**A-302**  
 Sheet 23 of 69

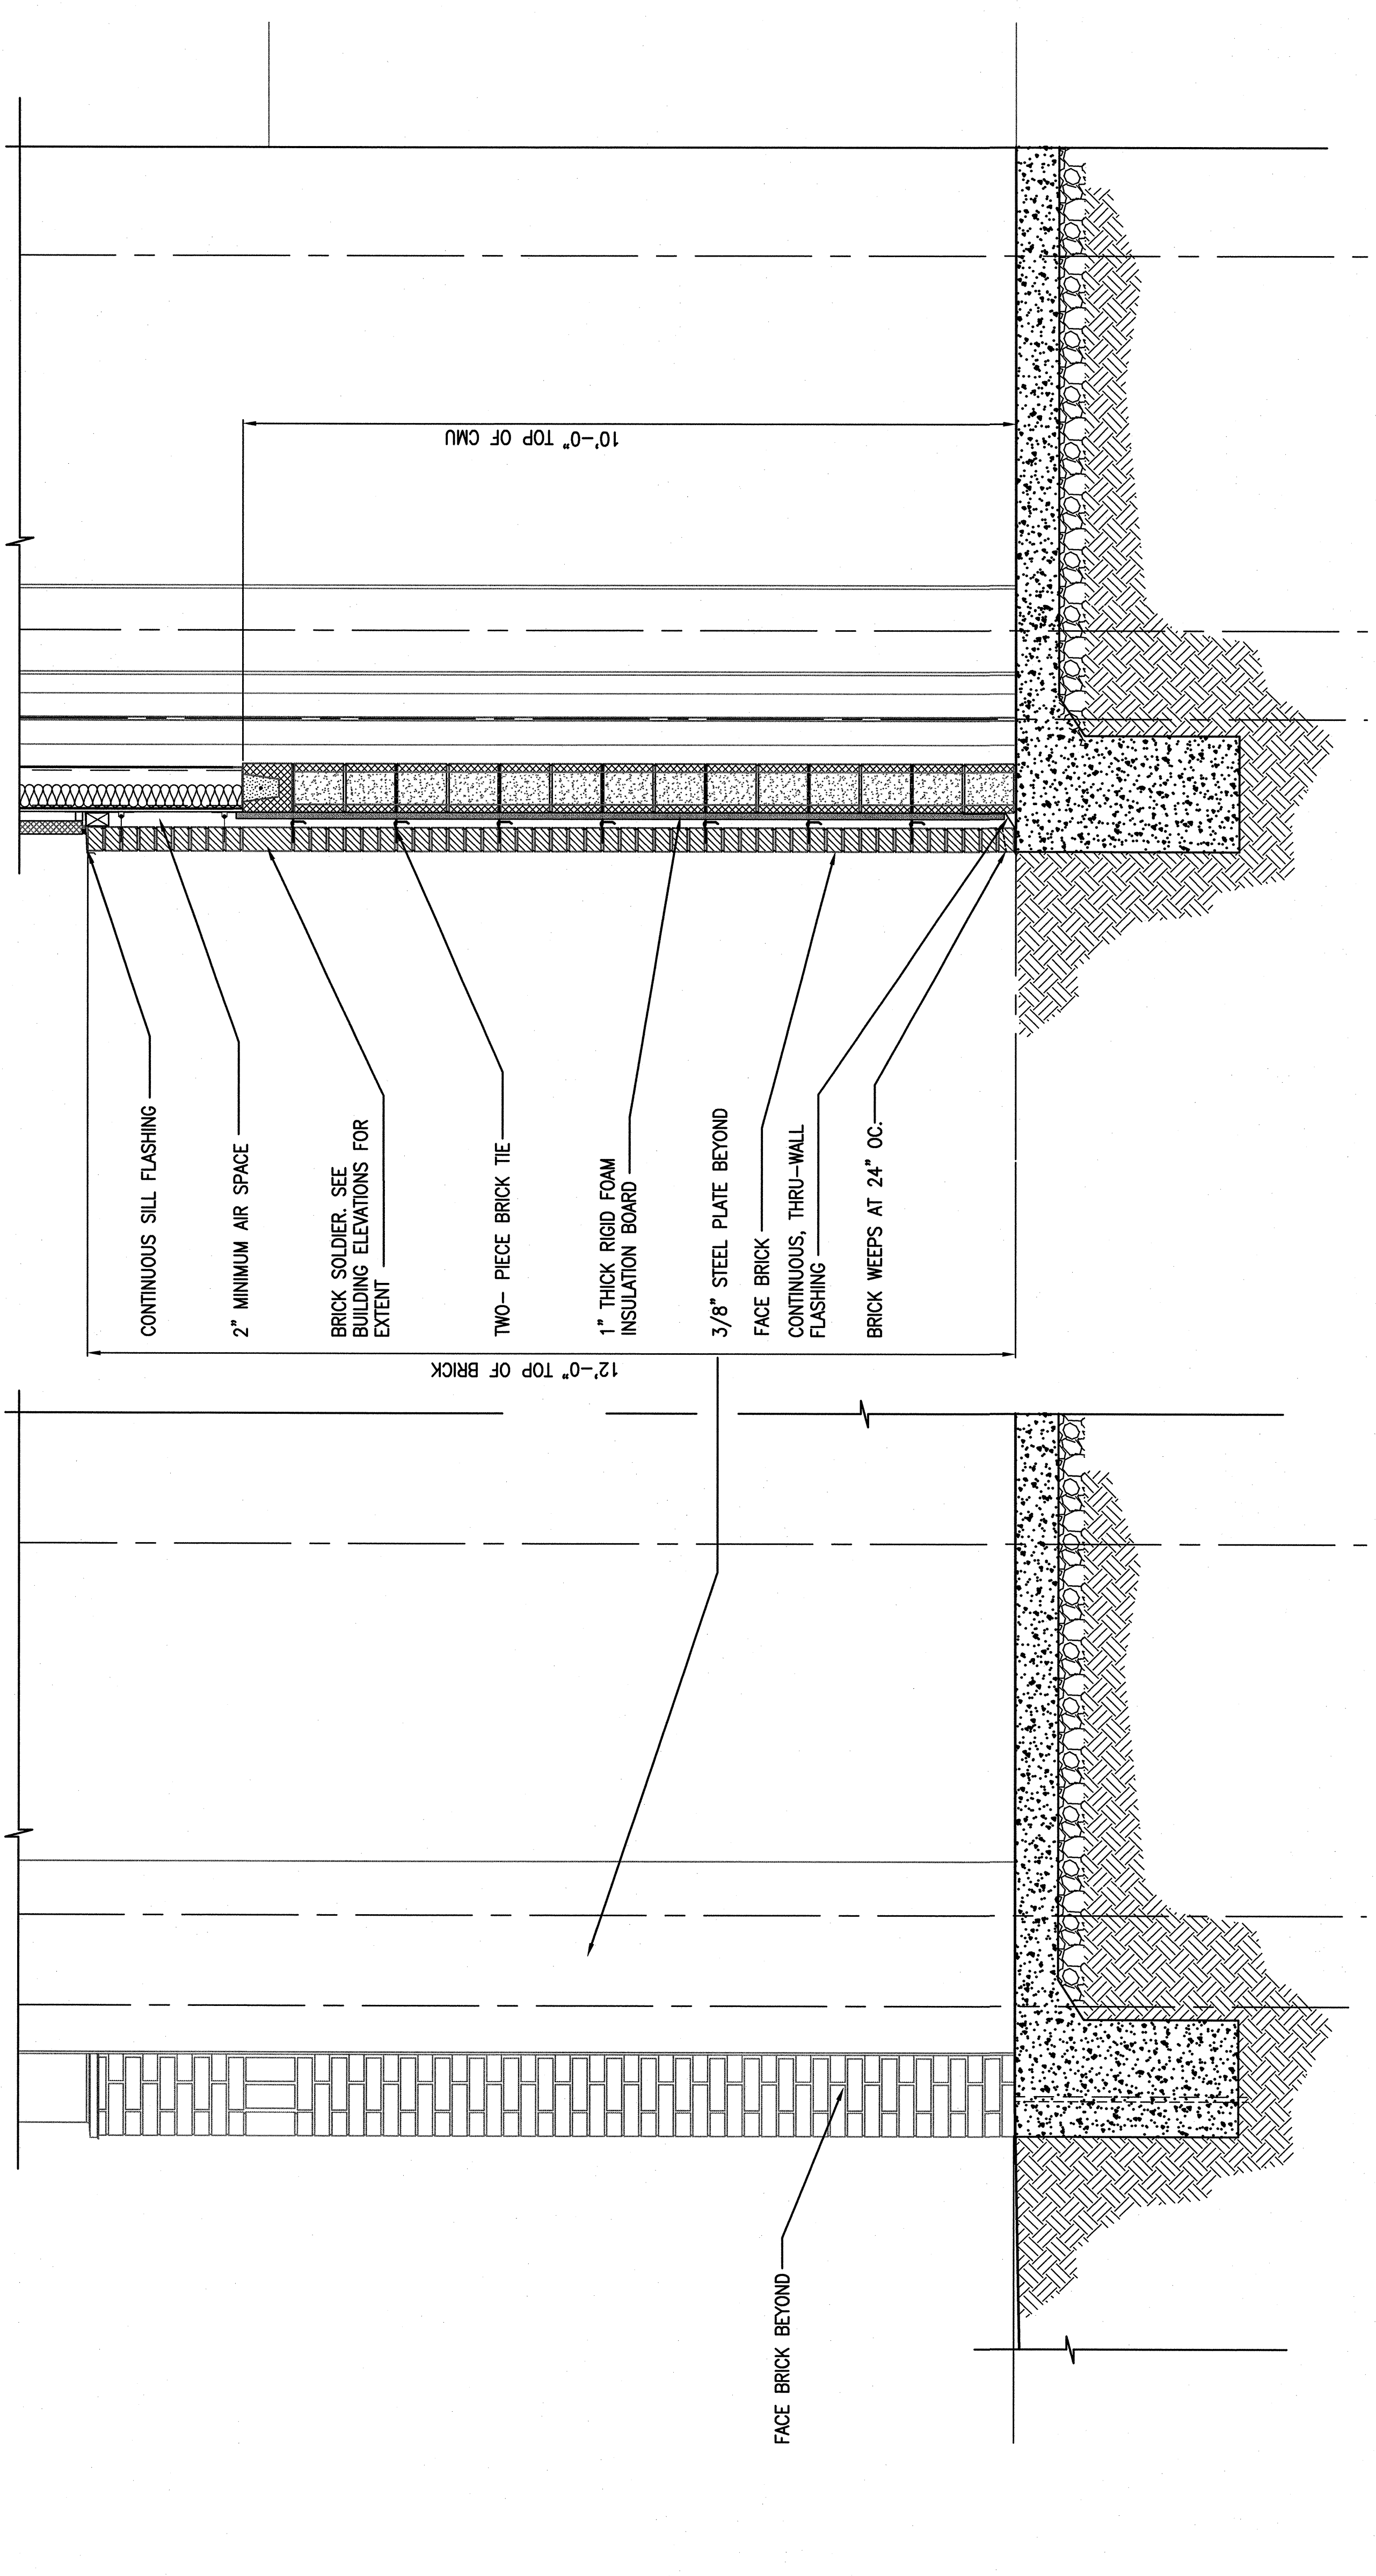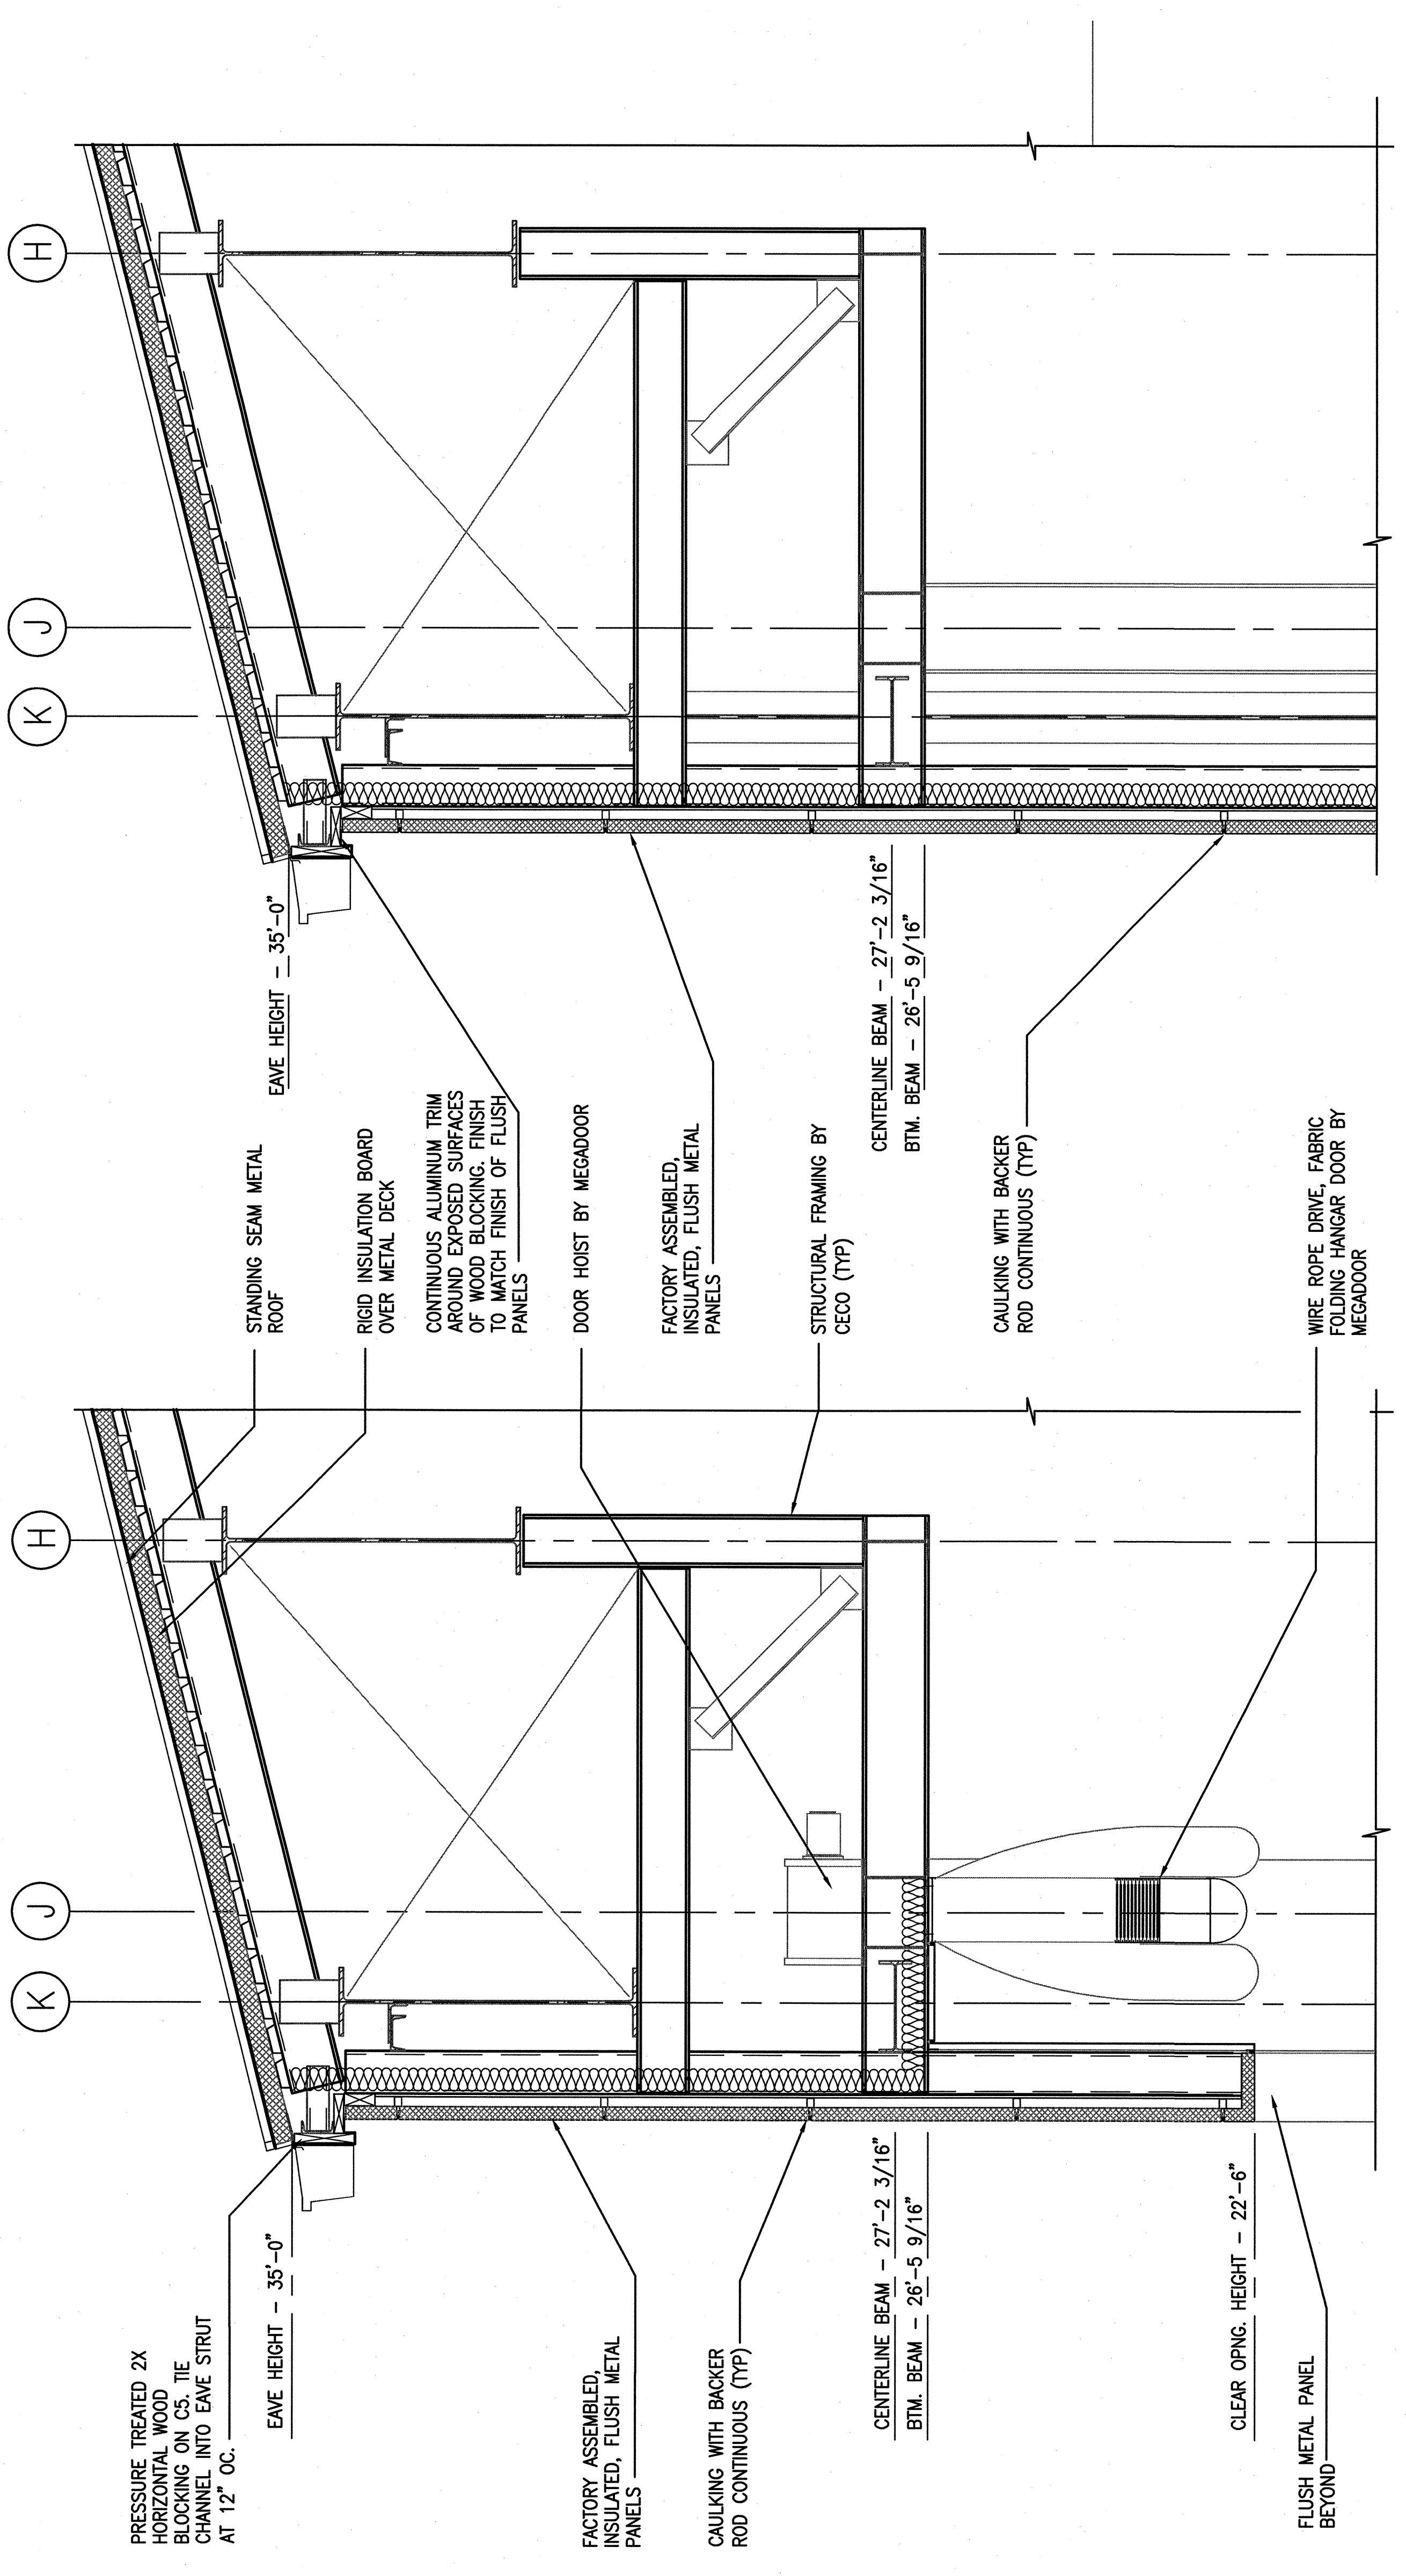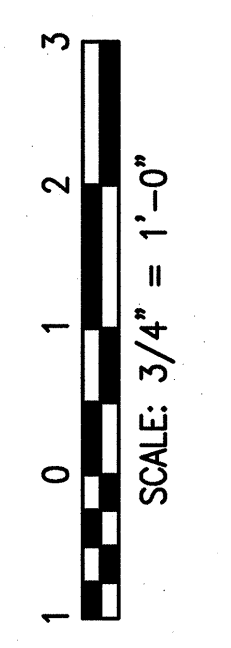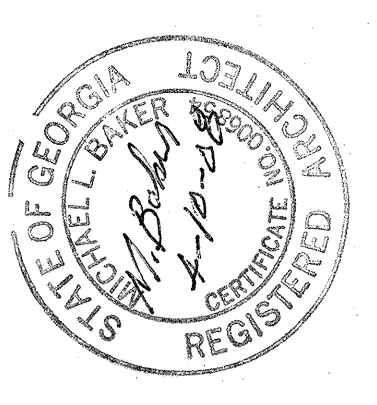

**1 WALL SECTION**  
 SCALE: 3/4\"/>

**2 WALL SECTION**  
 SCALE: 3/4\"/>