


LIGHTING FIXTURE SCHEDULE


NO.	DESCRIPTION	LAMPS	VOLTS	FINISH	REMARKS
⊙	INTEGRAL LUMINAIRE FOR 120W MERCURY VAPOR LAMP; W/ INTEGRAL REGULATING BALLAST, DUSTPROOF ALUMINUM CONSTRUCTION, TEMPERED GLASS LENS, HEAT DISSIPATING SYSTEM, ALUM. DIFFUSING REFLECTOR W/ 82% MIN. REFLECTANCE FACTOR.	1-H36-12GWC	208v	ALUM.	HANGER MTD. FROM BAR JOIST AT 24" FROM FIN. FLOOR.
△ B	AUTOMATIC FLOODLIGHT FOR 400W MERCURY VAPOR LAMP; W/ INTEGRAL REGULATING BALLAST, DUST & WATER-PROOF ALUMINUM CONSTRUCTION, TEMPERED GLASS LENS, ALUM. SPECULAR REFLECTOR W/ 85% MIN. REFLECTANCE FACTOR. EQUIP W/ BUILT-IN HOIST. & VERT. AIMING ADJUSTMENT DEVICES.	1-H33-14/C	208v	ALUM.	WALL BRACKET MTD. AT 23" ABOVE GRADE
FC	SURFACE MOUNTING FLUORESCENT FIXTURE 20 GA. PORCELAIN ENAMEL, INDUSTRIAL REFLECTOR WITH 107% UPLIGHT	4-F40T12	120v	WHITE	MTD. ON BOTTOM CHORD OF JOISTS.
D	HINGED & FEATHERED FLUORESCENT RECESSED TRAFFER, 2"x4", W/ PRISMATIC ACRYLIC DIFFUSER.	4-F40T12	120v	WHITE	EQUIP W/ FRAME BR FLUSH MOUNTING IN 2"x4" ADJUST. GRID CLG.
REV A					
▽	DOUBLE REFLECTOR FLOOD LAMP HOLDER W/ CAST ALUM. CONSTRUCTION & UNIVERSAL AIMING DEVICE.	2-150A-R40	120v	ALUM.	WALL BRACKET MTD. 12" ABOVE FIN. FLR.
G	DOUBLE REFLECTOR FLOOD LAMP HOLDER W/ CAST ALUM. WEATHERPROOF CONSTRUCTION & UNIVERSAL AIMING DEVICE.	2-150A-R33	120v	ALUM.	WALL BRACKET MTD. 11-3" ABOVE FIN. GRADE EQUIP W/ P.E. SWITCH
⊕	VAPOR PROOF INCANDESCENT FIXTURE W/ CAST ALUM. FIXTURE BODY & PROTECTIVE GUARD	1-100A-25	120v	ALUM.	LAMP BRACKET MTD. BELT/ EXHAUST HOOD.
K	SAME AS TYPE C EXCEPT FOR TWO F40T12 LAMPS				
⊗	INCANDESCENT FIXTURE, CERAMIC LAMPHOLDER FOR MEDIUM SCREEN BASE LAMPS, AND STANDARD DOME REFLECTOR	1-200 W	120	PORCELAIN ENAMEL	PENDANT MTD. FROM BAR JOIST. 12" STEM

LEGEND OF ELECTRICAL SYMBOLS

⊙	LIGHTING FIXTURE, MERCURY VAPOR, PEND. MOUNT
△	LIGHTING FIXTURE - FLOOR, CLG. JOIST MOUNT
△	LIGHTING FIXTURE - WALL BRACKET.
△	LIGHTING FIXTURE - WALL BRACKET.
S	SWITCH - SINGLE POLE 120-277V 20AMP
S	SWITCH - THREE WAY 120V, 20 AMP
⊕	120V CONVENIENCE OUTLET - DUPLEX
⊕	120V CONVENIENCE OUTLET - SINGLE, WEATHERPROOF
⊕	220V CONVENIENCE OUTLET - SINGLE, FEEDS AS SCHEDULED.
—	CONDUIT CONCEALED IN WALLS OR CEILING
—	CONDUIT RUN UNDER FLOOR
—	CONDUIT RUN UNDER FLOOR
—	INDICATE NUMBER OF CONDUCTORS.
—	120V FRACTIONAL HP MANUAL MOTOR STARTER, WITH THERMAL ELEMENT.
⊠	CIR. BRK. PANEL - SURFACE MOUNTED.
⊠	DISCONNECT SWITCH, MOTOR, SIZE AS INDICATED
⊠	MAIN DISTRIBUTION PANEL
⊠	JUNCTION BOX - SIZE AS REQ.
⊠	PROTECTIVE SWITCH, MTD. ON LAMPHOLDER CLUSTER BOX
⊠	3-POSITION PUSHBUTTON SWITCH (1P-30P/PA), MTD. 5' W/ HGT.

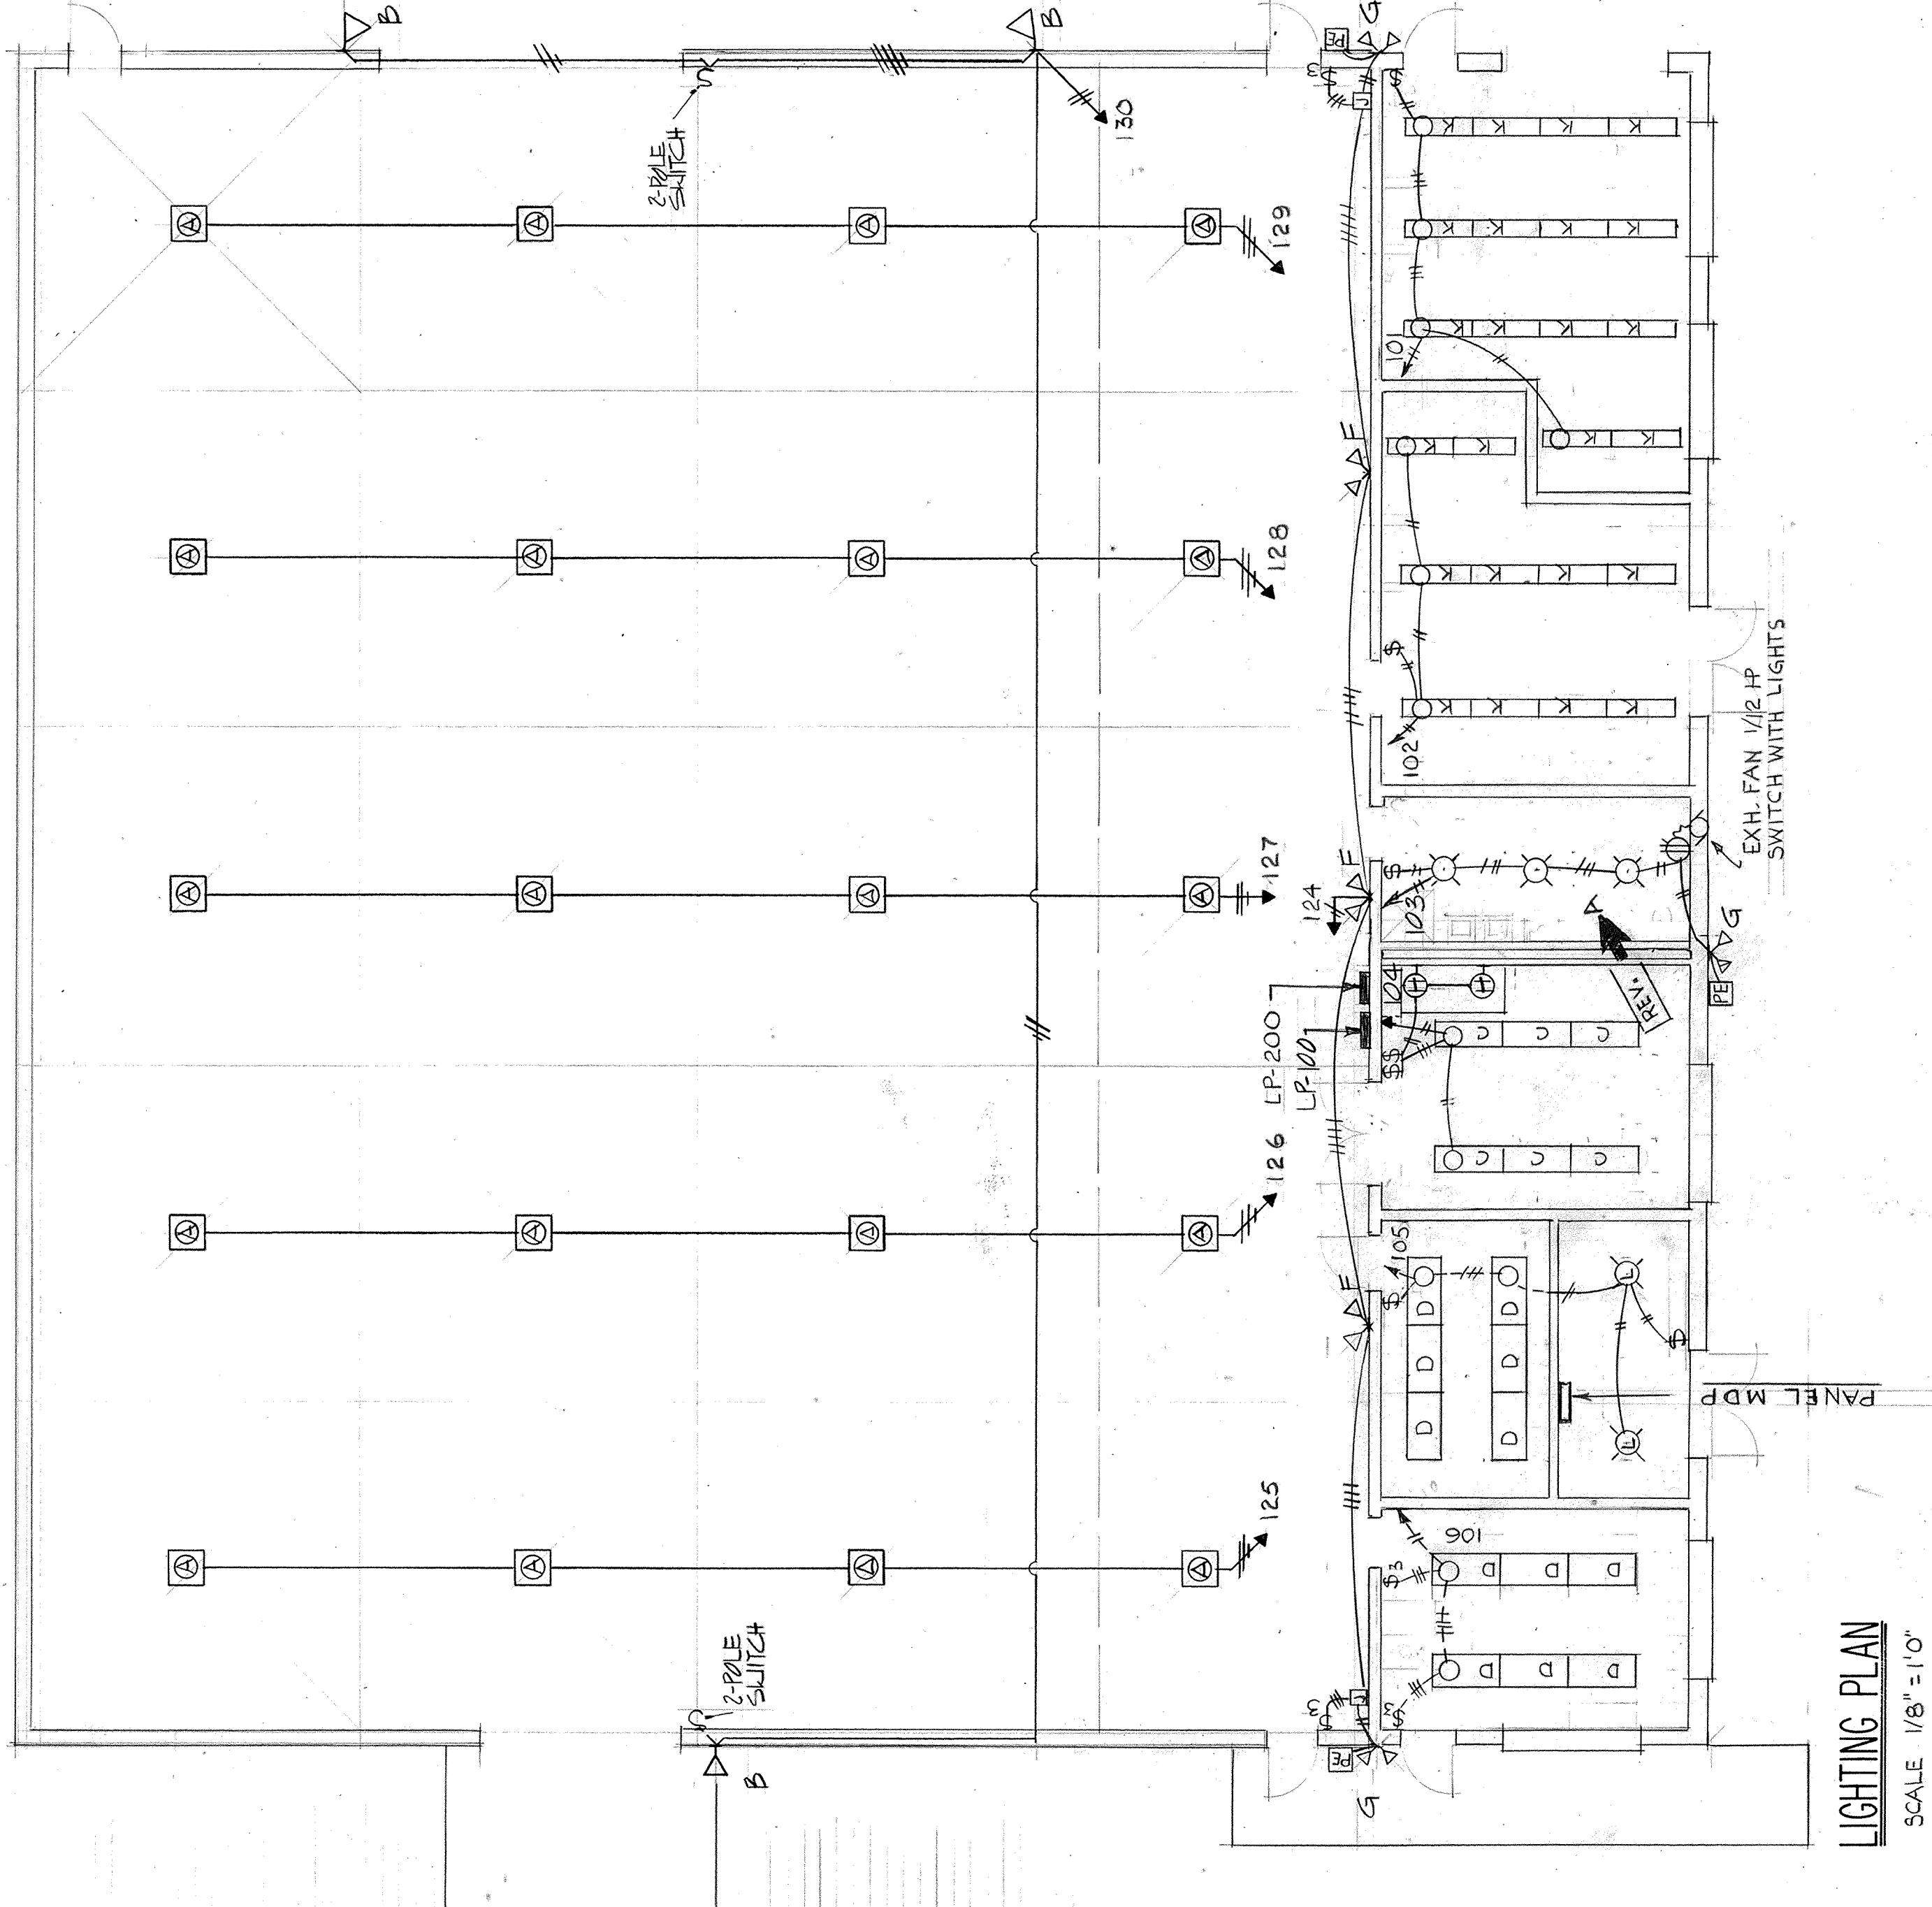

LIGHTING PLAN
SCALE 1/8" = 1'0"

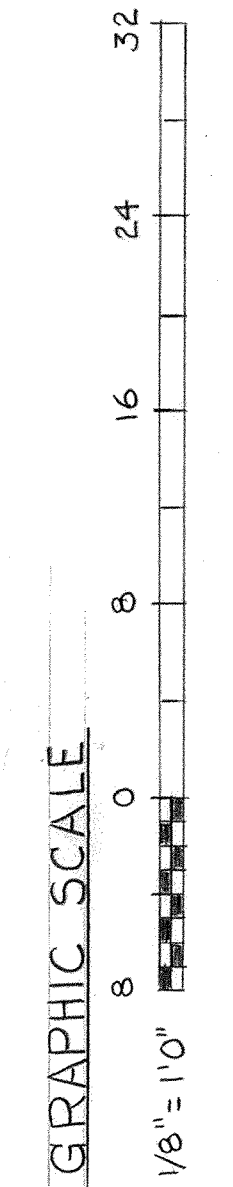

LET	DESCRIPTION	DATE	APPROVED
A	CHANGED LIGHTING FIXTURES IN LATRINE	11/2/72	HVM
	AS-BUILT DRAWING, NO CORRECTIONS	7-24-73	HVM

RECORD DRAWING
DATE 30 JUL 1973

DEPARTMENT OF THE NAVY - NAVAL FACILITIES ENGINEERING COMMAND
SOUTHERN DIVISION
CHARLESTON, S. C.

MAHAFFEY & ASSOC. - ENGINEERS
FAYETTEVILLE, ARKANSAS

AIR NATIONAL GUARD - MUNICIPAL AIRPORT, FT. SMITH, ARKANSAS
AIRCRAFT ENGINE INSPECTION
AND REPAIR SHOP

ELECTRICAL - LIGHTING PLAN

OFFICE IN CHARGE: DATE: 11-18-71
APPROVED: [Signature]
SIZE: 30" X 42" DRAWING NO.: 5017393
F 80091
CONSTR. CONTR. NO. H62467-10-C-0556
SCALE: GRAPHIC SPEC 06-70-0556 SHEET 13 OF 13