


**SECTION "A"-"A"**

SCALE: 1/4"=1'-0"

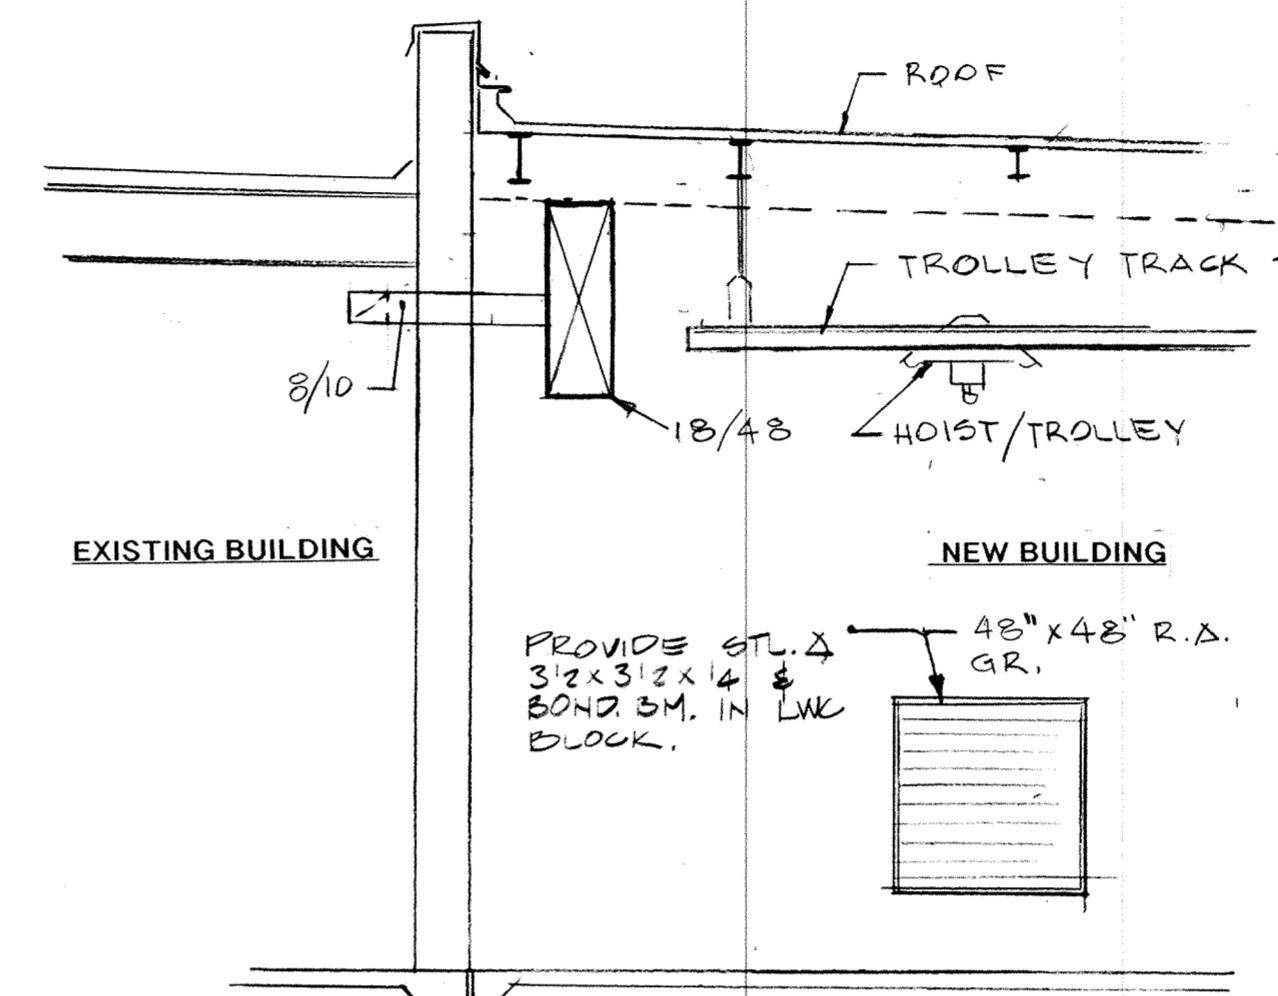


**SECTION "B"-"B"**

SCALE: 1/4"=1'-0"

**PARTIAL FLOOR PLAN-HVAC**

SCALE: 1/4"=1'-0"

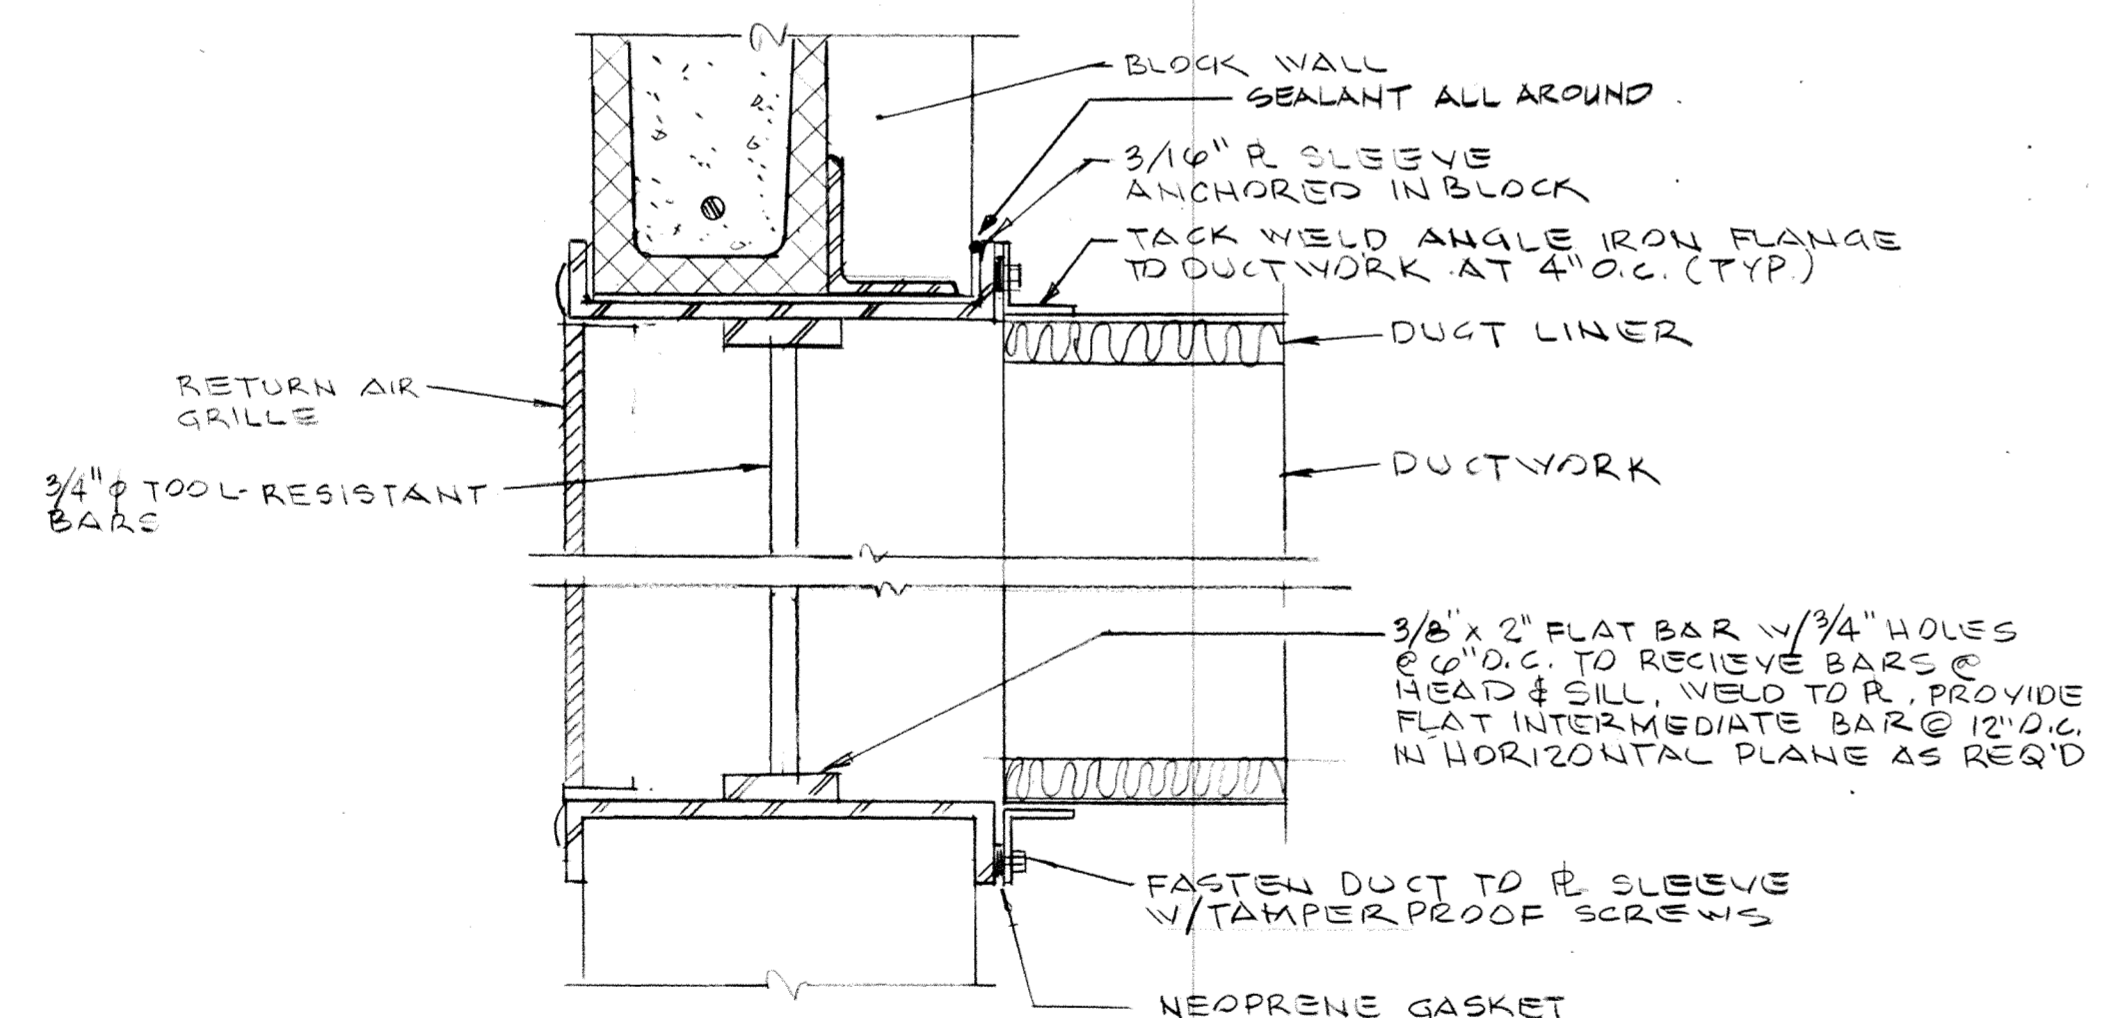



**SECURITY BAR DETAIL**

NOT TO SCALE

NOTE:  
DETAIL TYP FOR SUPPLY DUCT  
& LOUVER

**MM  
MG**

Mott Mobley McGowan & Griffin, P.A.: Architects  
302 North Sixth Street  
Fort Smith, Arkansas 72901

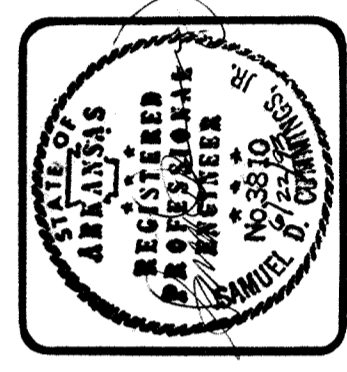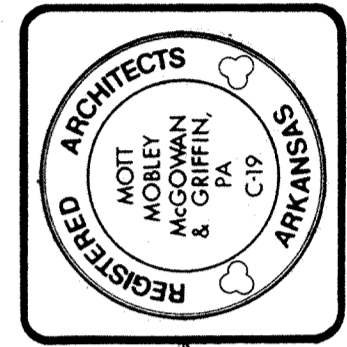

CONTRACT NO. DMAH03-93-R-0001

PROJECT NO. HKRZ929948

ADD./ ALTER. ECM POD SHOP

AIR NATIONAL GUARD TRAINING FACILITY

MUNICIPAL AIRPORT - FT. SMITH, ARKANSAS

DETAILS-HVAC

Revisions	
1440	M1.2
Plan Number	
7-30-93	
Date	Or

BRUNING 40 72 85201