



**GROUPED WIRING DEVICE DETAIL**

N.T.S.

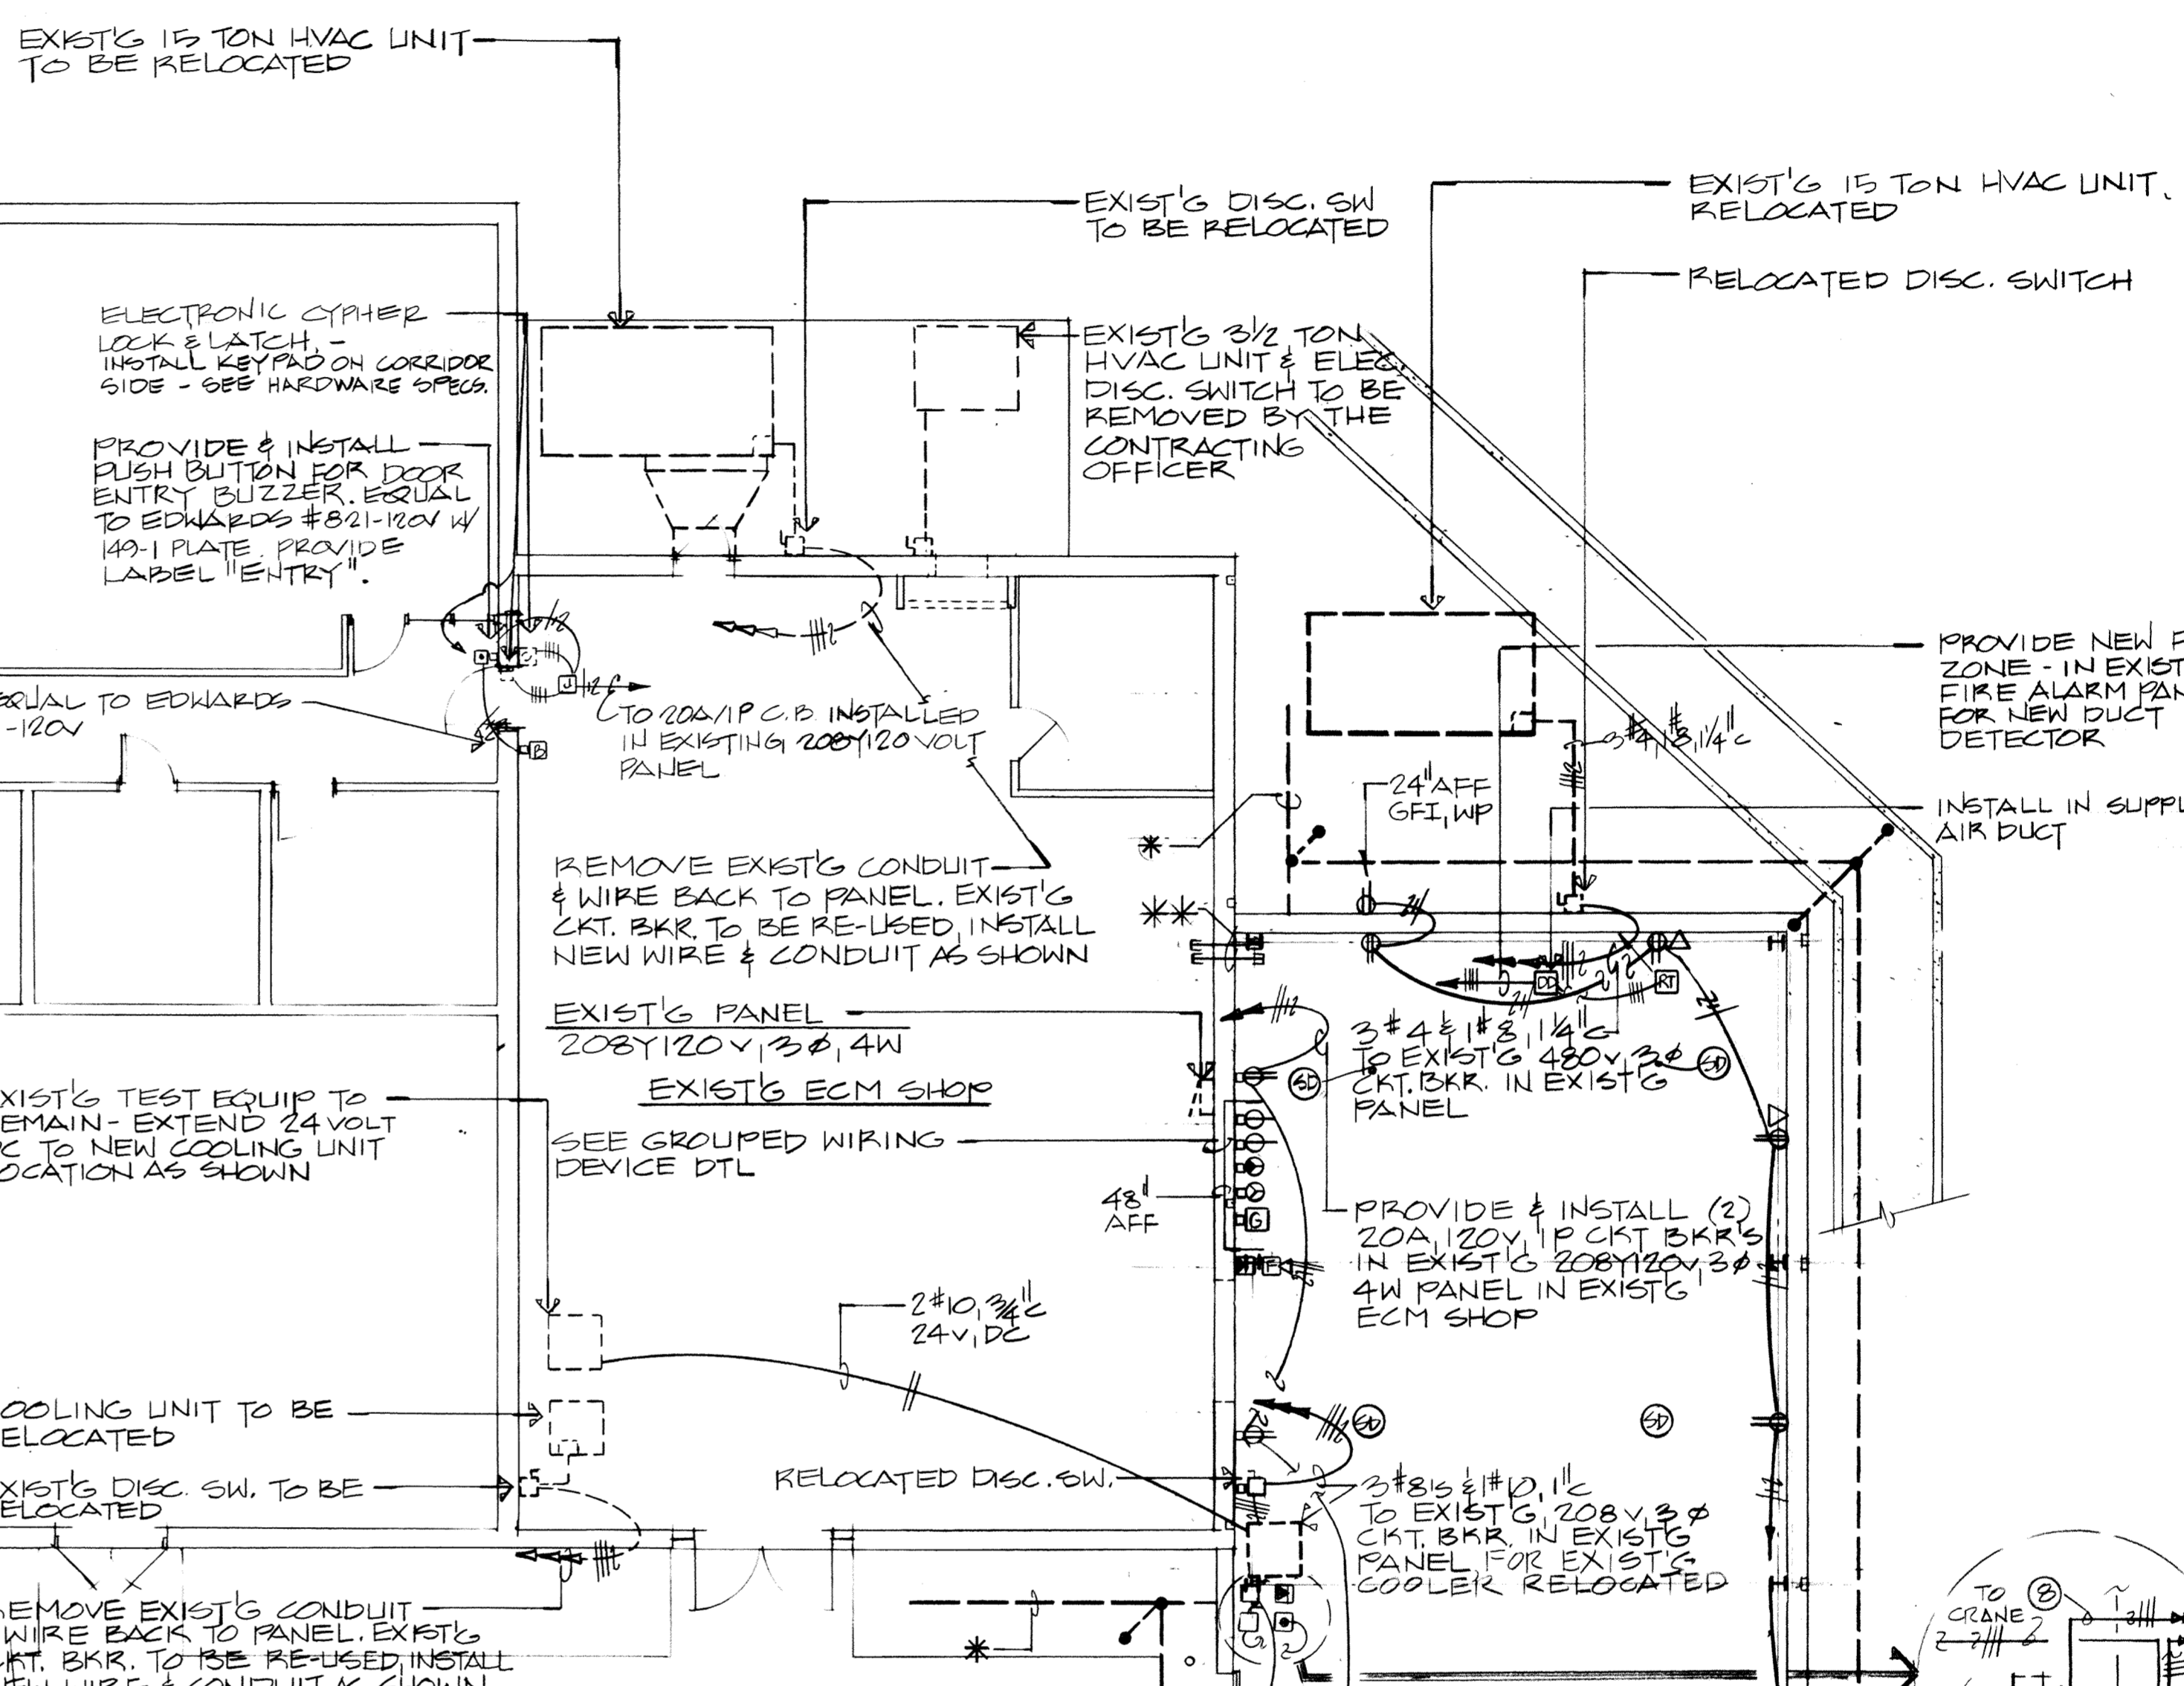


**FLOOR PLAN-POWER & AUXILIARY SYSTEMS**

SCALE: 1/8"=1'-0"

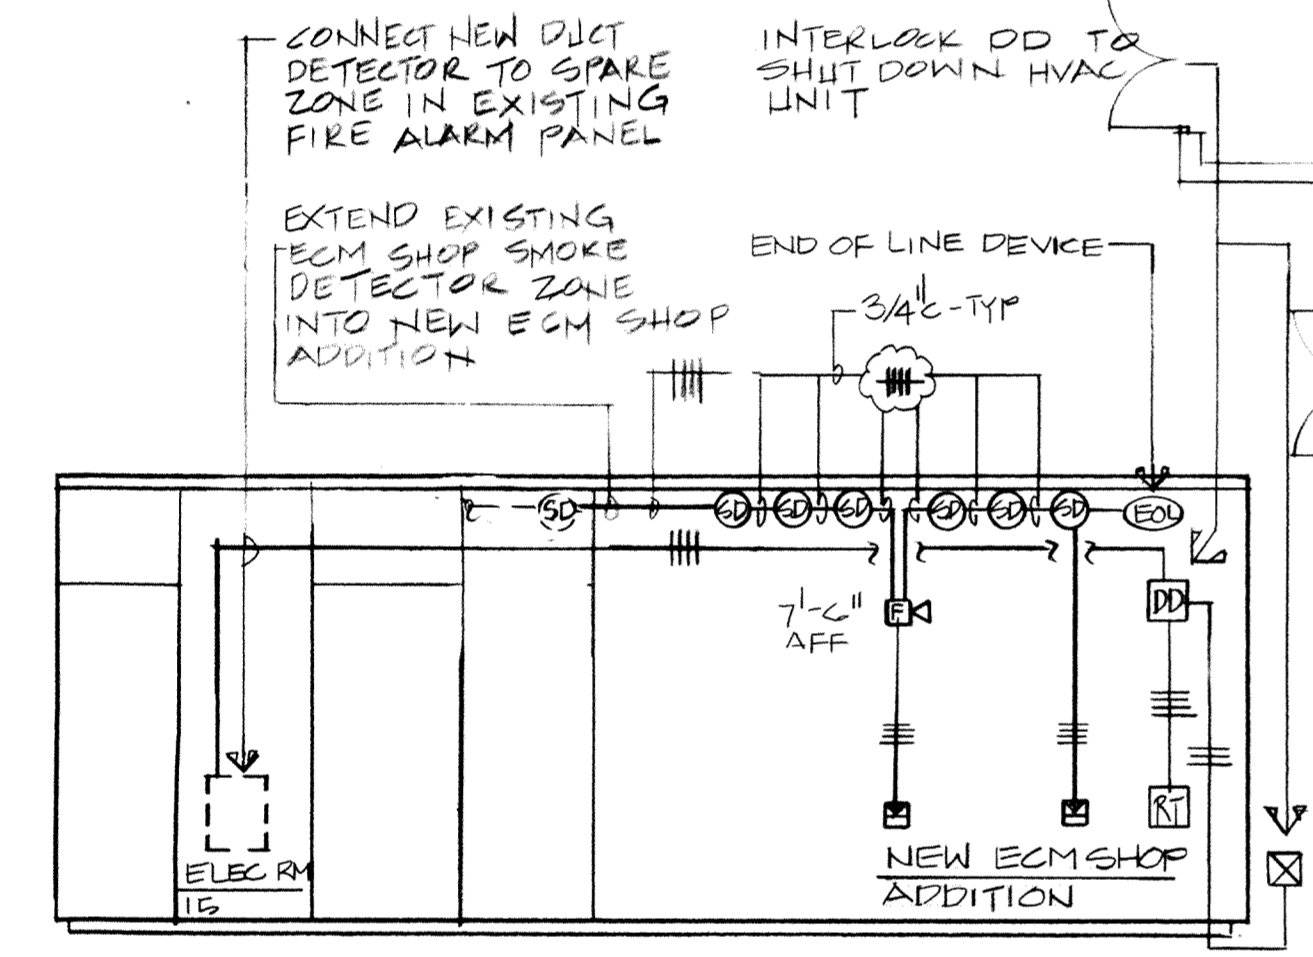


**FIRE ALARM SYSTEMS RISER DIAGRAM**

N.T.S.

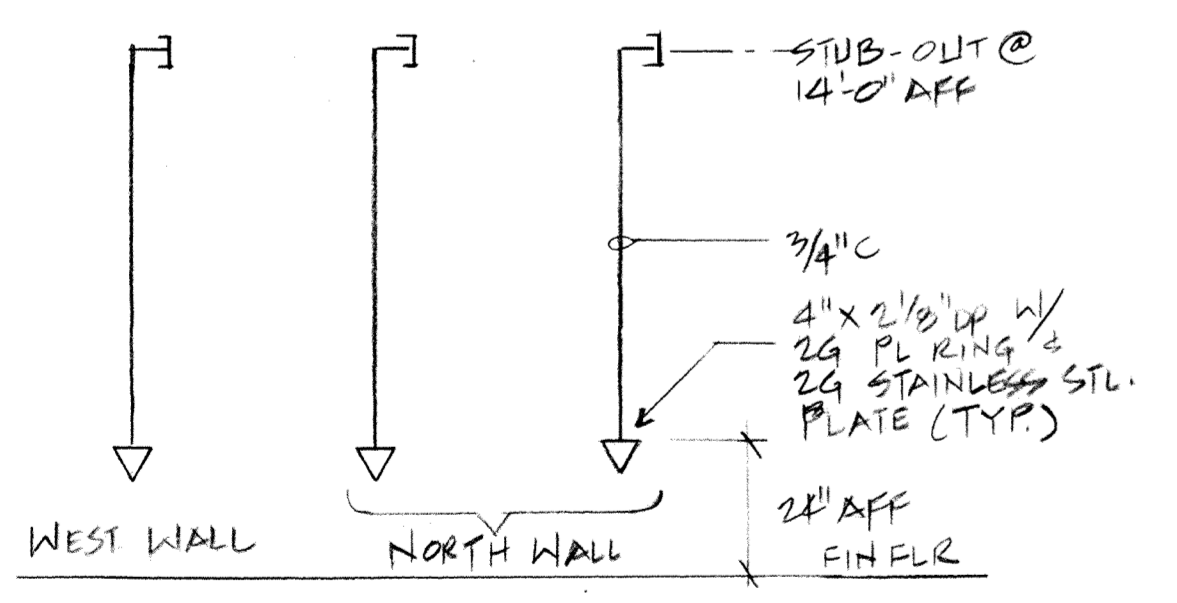



**COMMUNICATIONS OUTLETS RISER DIAGRAM**

NOT TO SCALE

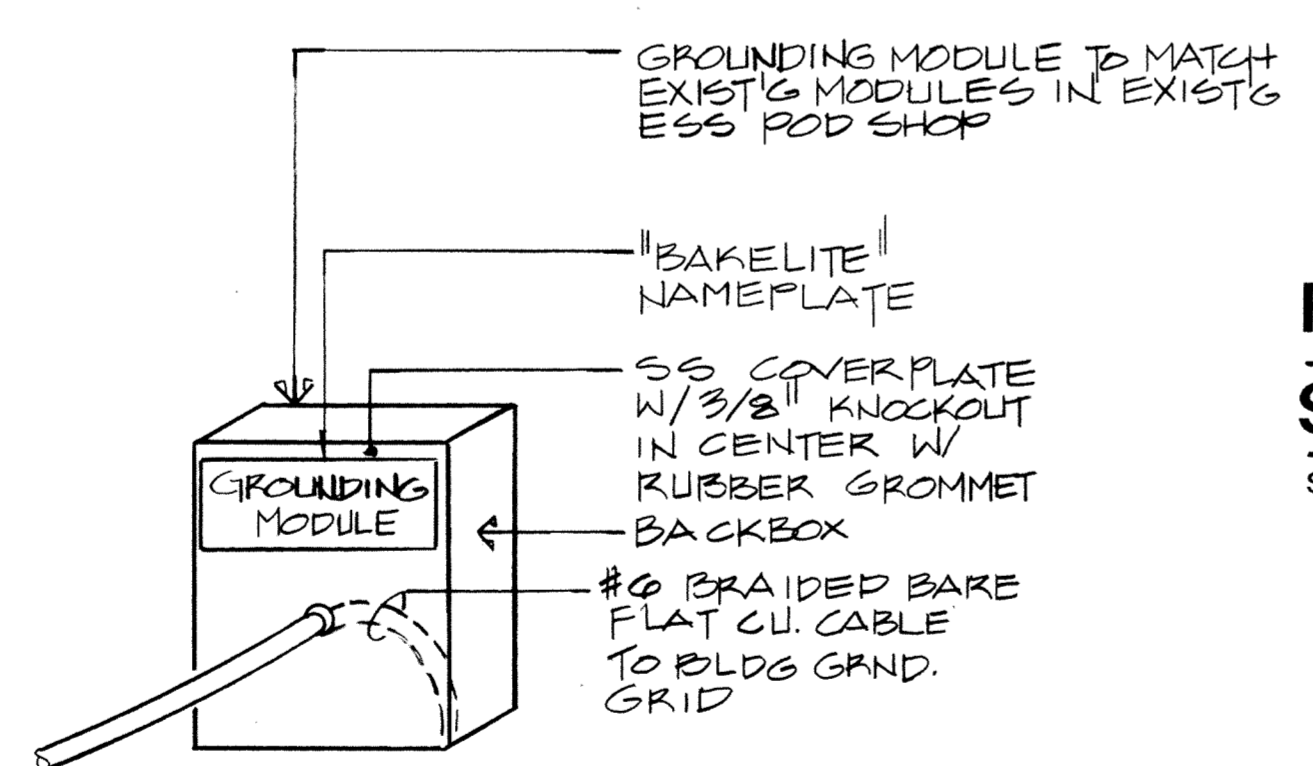

**GROUNDING MODULE DETAIL**

N.T.S.

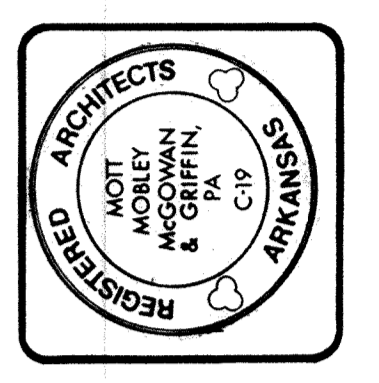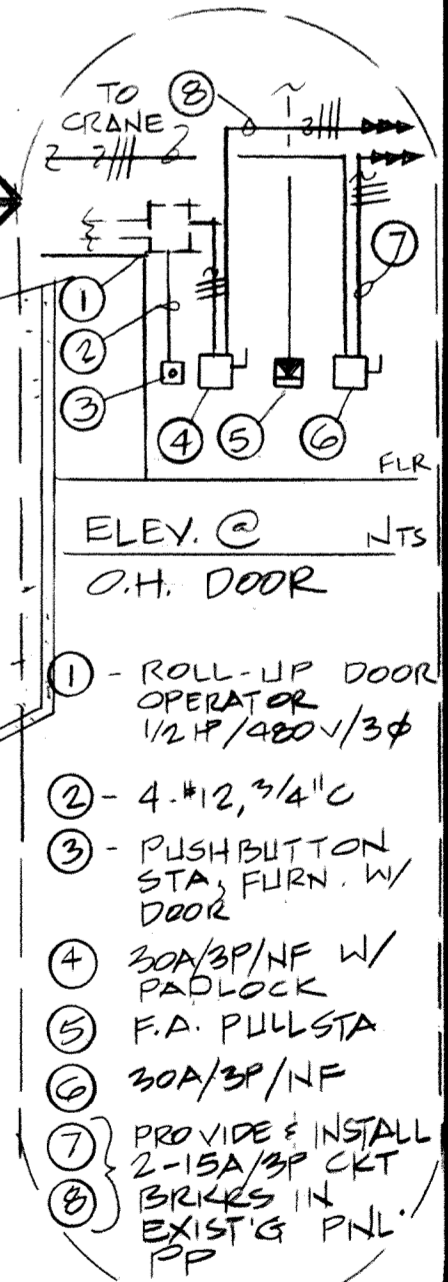

PROJECT NO. HKR929948  
ADD./ ALTER. ECM POD SHOP  
AIR NATIONAL GUARD TRAINING FACILITY  
MUNICIPAL AIRPORT - FT. SMITH, ARKANSAS

Revisions

1440  
Plan Number  
7-30-93  
Date  
E-3