


SECTION "A"-"A"

SCALE: 1/4"=1'-0"

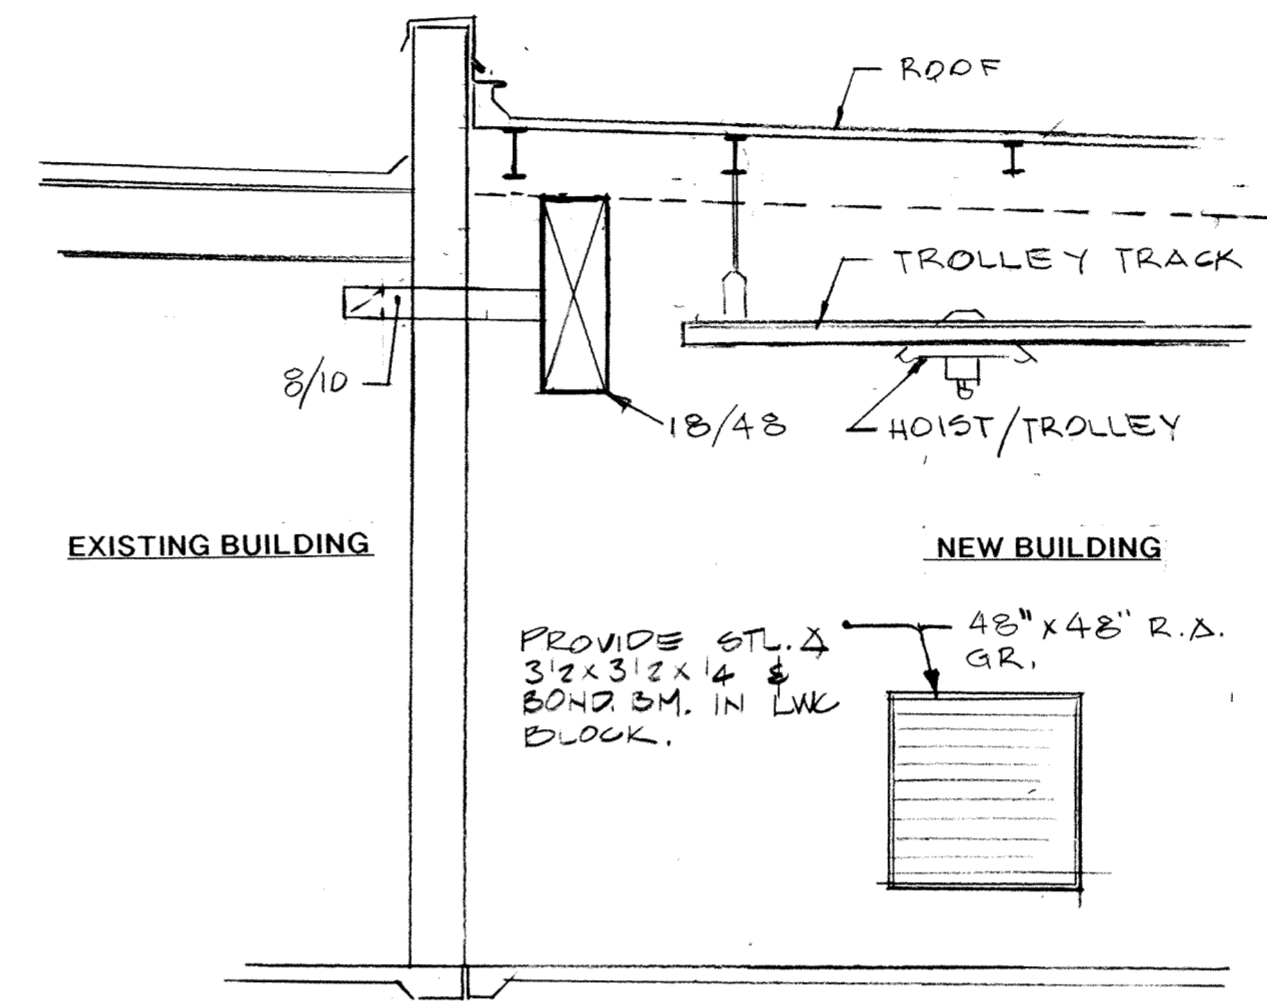


SECTION "B"-"B"

SCALE: 1/4"=1'-0"

PARTIAL FLOOR PLAN-HVAC

SCALE: 1/4"=1'-0"


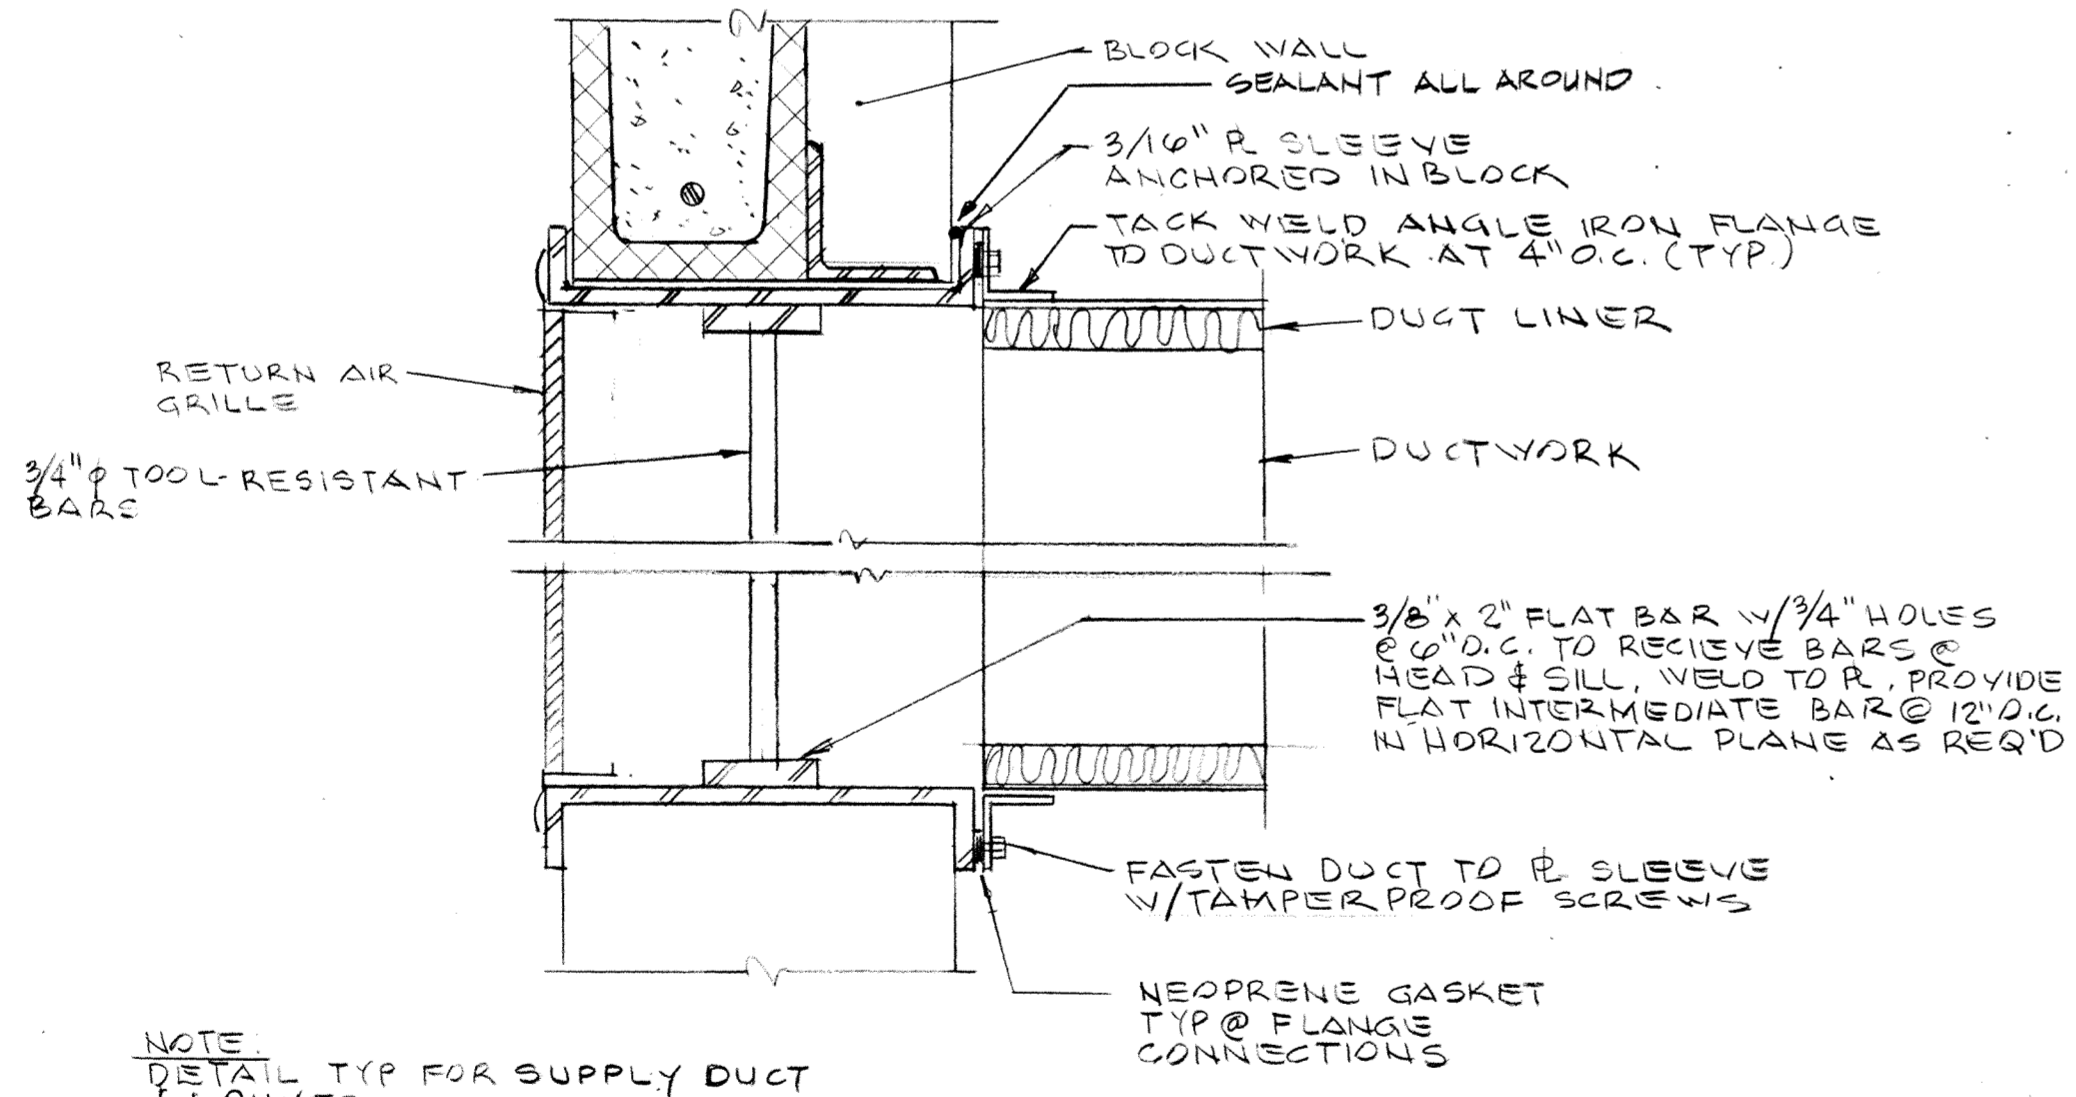


NOTE
DETAIL TYP FOR SUPPLY DUCT
& FLOWER

SECURITY BAR DETAIL

NOT TO SCALE

**MM
MG**

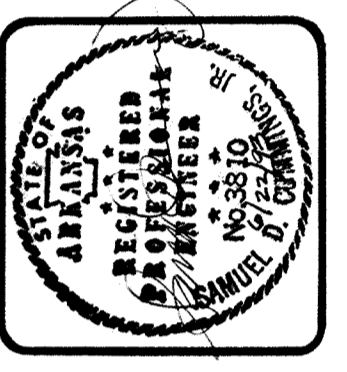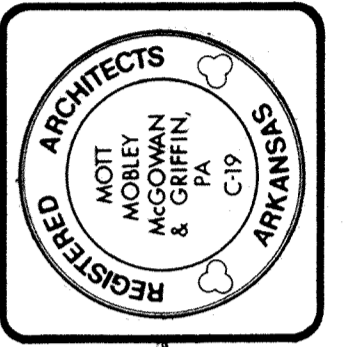

CONTRACT NO. DHA403-93-R-0001
PROJECT NO. HKRZ929948
ADD./ ALTER. ECM POD SHOP
AIR NATIONAL GUARD TRAINING FACILITY
MUNICIPAL AIRPORT - FT. SMITH, ARKANSAS

DETAILS-HVAC

Revisions	
1440	M1.2
7-30-93	
Date	Of

Mott Mobley McGowan & Griffin, P.A.: Architects
Fort Smith, Arkansas 72901

BRUNING 02.17.93