 


NOTE: PROVIDE TWO AT EACH CONDENSING UNIT.

DETAIL - CONDENSING UNIT SUPPORT STAND ROOF PENETRATION

B1 1 1/2" = 1'-0"



SHEET KEYNOTES

- 01.18 EXISTING ROOF CONDITIONS TO BE PROTECTED DURING CONSTRUCTION PERIOD WORK ACTIVITIES.
- 01.19 EXISTING AIR HANDLING UNIT.
- 01.20 EXISTING STEEL BEAM.
- 01.21 EXISTING FLUTED METAL ROOFING PANEL.
- 01.22 EXISTING CONCRETE ROOF DECK.
- 01.23 EXISTING POLYSTYRENE FOAM INSULATION.
- 01.24 EXISTING PVC ROOF MEMBRANE.
- 05.08 VERTICAL TUBE STEEL CONDENSING UNIT SUPPORT STAND POST ANCHORED TO EXISTING CONCRETE ROOF DECK.
- 06.04 FRT WOOD BLOCKING, TYPICAL ALL SIDES OF EACH VERTICAL STAND SUPPORT. (2) 2x8s AND (1) 2x4 PER SIDE.
- 06.05 FRT WOOD BLOCKING W/ 3/8" COUNTERSUNK EXPANSION BOLT AT 8" O.C. TYPICAL ALL SIDES.
- 07.26 PVC BOOT.
- 07.27 HOSE CLAMP.
- 07.28 WELDED SEAM (2" MINIMUM - ALL SIDES).
- 07.30 PVC ROOFING MEMBRANE. UPTURN MEMBRANE ONTO CURB ALL SIDES.
- 23.01 NEW EXHAUST FAN. SEE MECHANICAL DRAWINGS.
- 23.02 NEW CONDENSING UNIT. SEE MECHANICAL DRAWINGS.
- 23.03 NEW CONDENSING UNIT SUPPORT STAND. SEE DETAILS B1/AE103-A AND D6/MH502-A.


PARTITION LEGEND

- EXISTING PARTITION / BARRIER - WALL TO REMAIN
- EXISTING PARTITION / BARRIER - WALL TO BE REMOVED
- NEW PARTITION / BARRIER - WALL

PARTITION GRAPHICS


- NO RATING
- SMOKE RESISTIVE PARTITION - NON RATED
- 1 HOUR FIRE BARRIER
- 1 HOUR FIRE/SMOKE BARRIER
- 2 HOUR FIRE BARRIER
- 2 HOUR FIRE/ SMOKE BARRIER

KEY PLAN

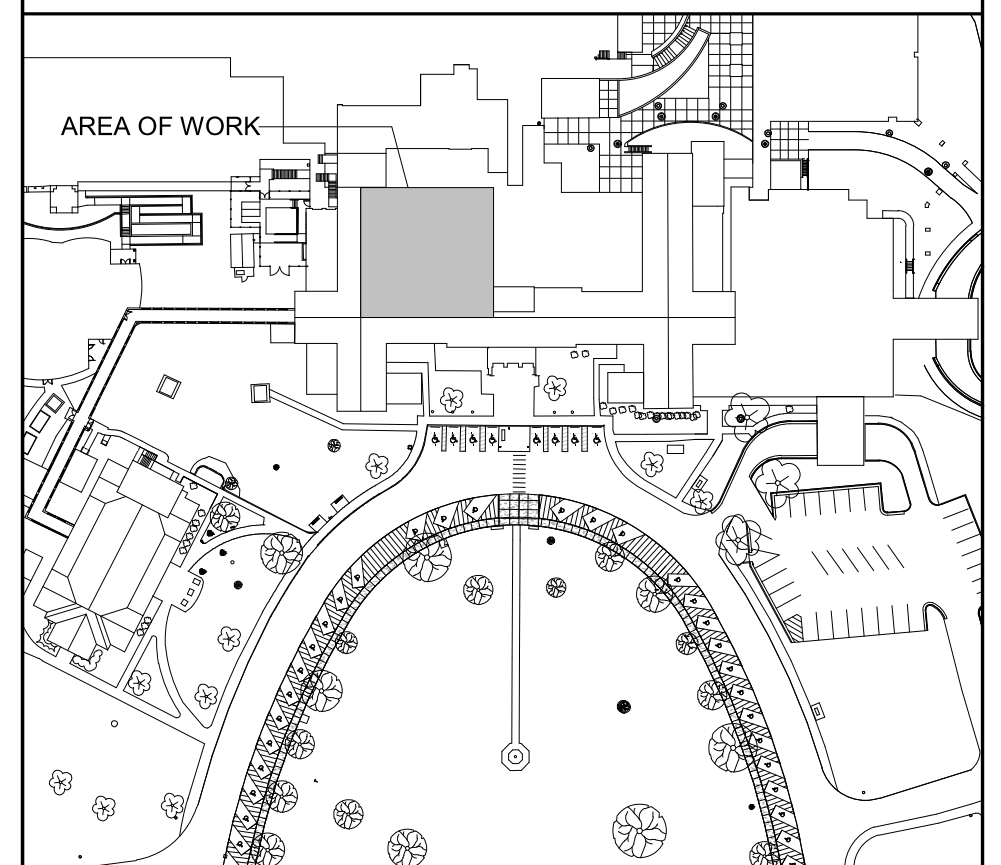


NORTH LEGEND

PLAN TRUE NORTH

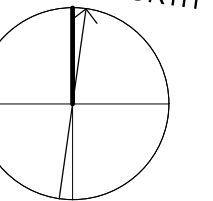


FIRST FLOOR - FFE: 0'-0"

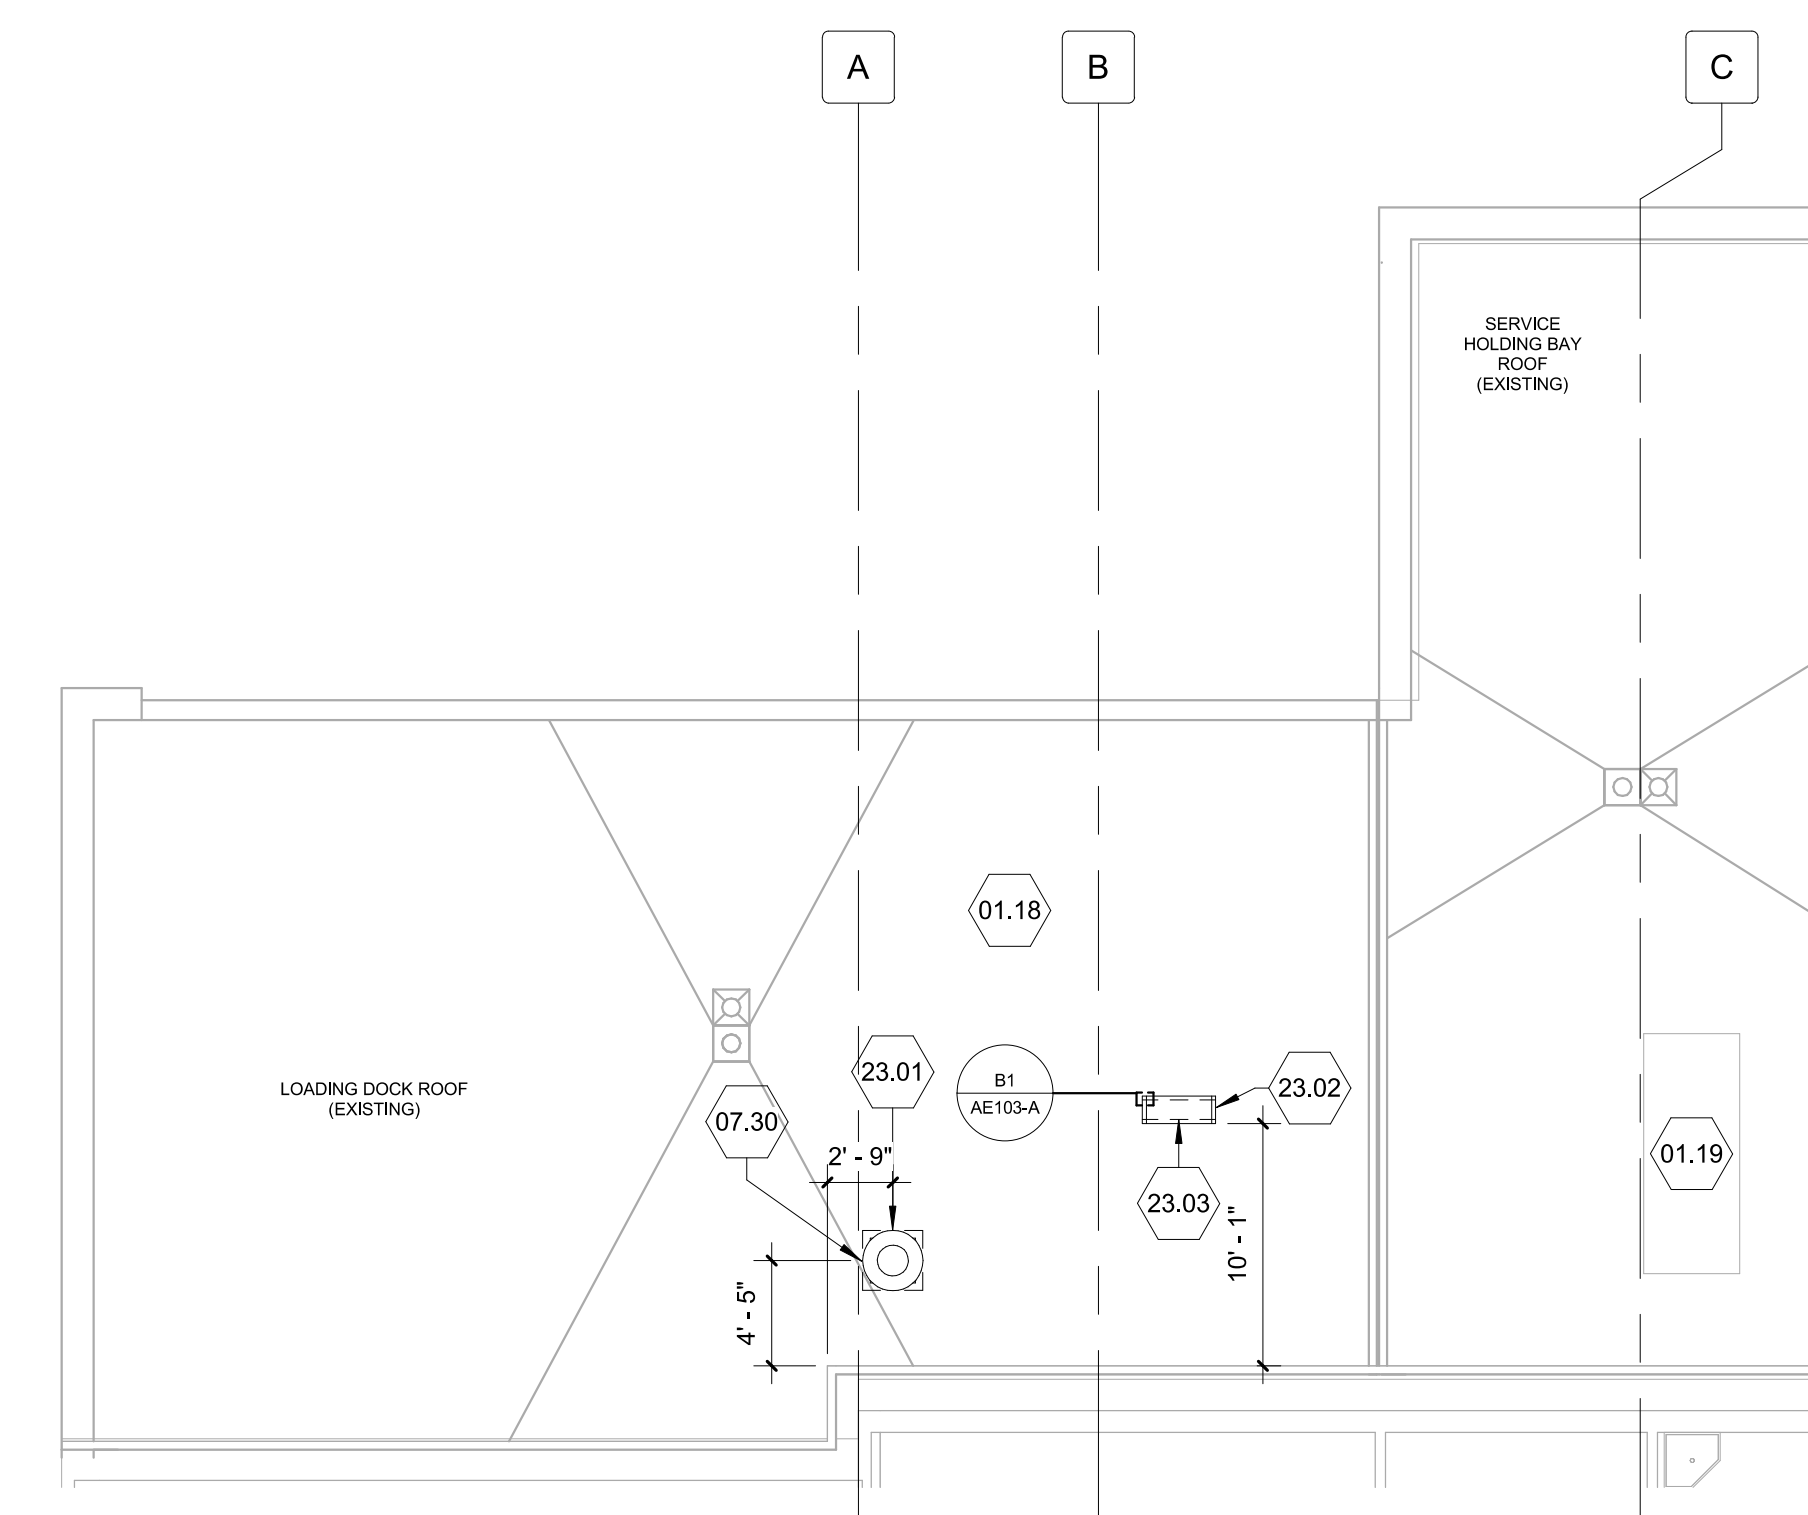

F1 ROOF PLAN - LOADING DOCK - NEW CONSTRUCTION

 1/8" = 1'-0"



4/12/2024 11:19:00 AM
BIM 360/19022 - Fayetteville, ID/D Project No. 664-19-403 Renovation of SPS/19022 - ARCH - R2020.rvt

Revision Number	Revisions:	Date:

CONSULTANTS	
CONSULTING STRUCTURAL ENGINEERS	

ARCHITECT/ENGINEER OF RECORD	
A/E:	HARRELL DESIGN GROUP PC
	10720 SIKES PLACE, SUITE 100
	CHARLOTTE, NC 28277
	704-814-1346
	POC: LEE HARRELL PE, LEED AP, QCCP
	PRESIDENT
	HGD PROJECT: 19022

STAMP

DRAWING TITLE
ROOF PLAN
APPROVED

PHASE
CONSTRUCTION DOCUMENTS SUBMISSION
FULLY SPRINKLERED

PROJECT TITLE		
RENOVATE SPACE FOR LOGISTICS (B-1)		
LOCATION FAYETTEVILLE VA MEDICAL CENTER		
ISSUE DATE	CHECKED	DRAWN
11 APRIL 2024	JC	MS

PROJECT NUMBER
564-24-104
BUILDING NUMBER
1
DRAWING NUMBER
AE103-A

Engineering Service

VETERANS HEALTH CARE SYSTEM OF THE OZARKS

VA U.S. Department of Veterans Affairs