


A4 CABLE TRAY DETAILS - A
NO SCALE

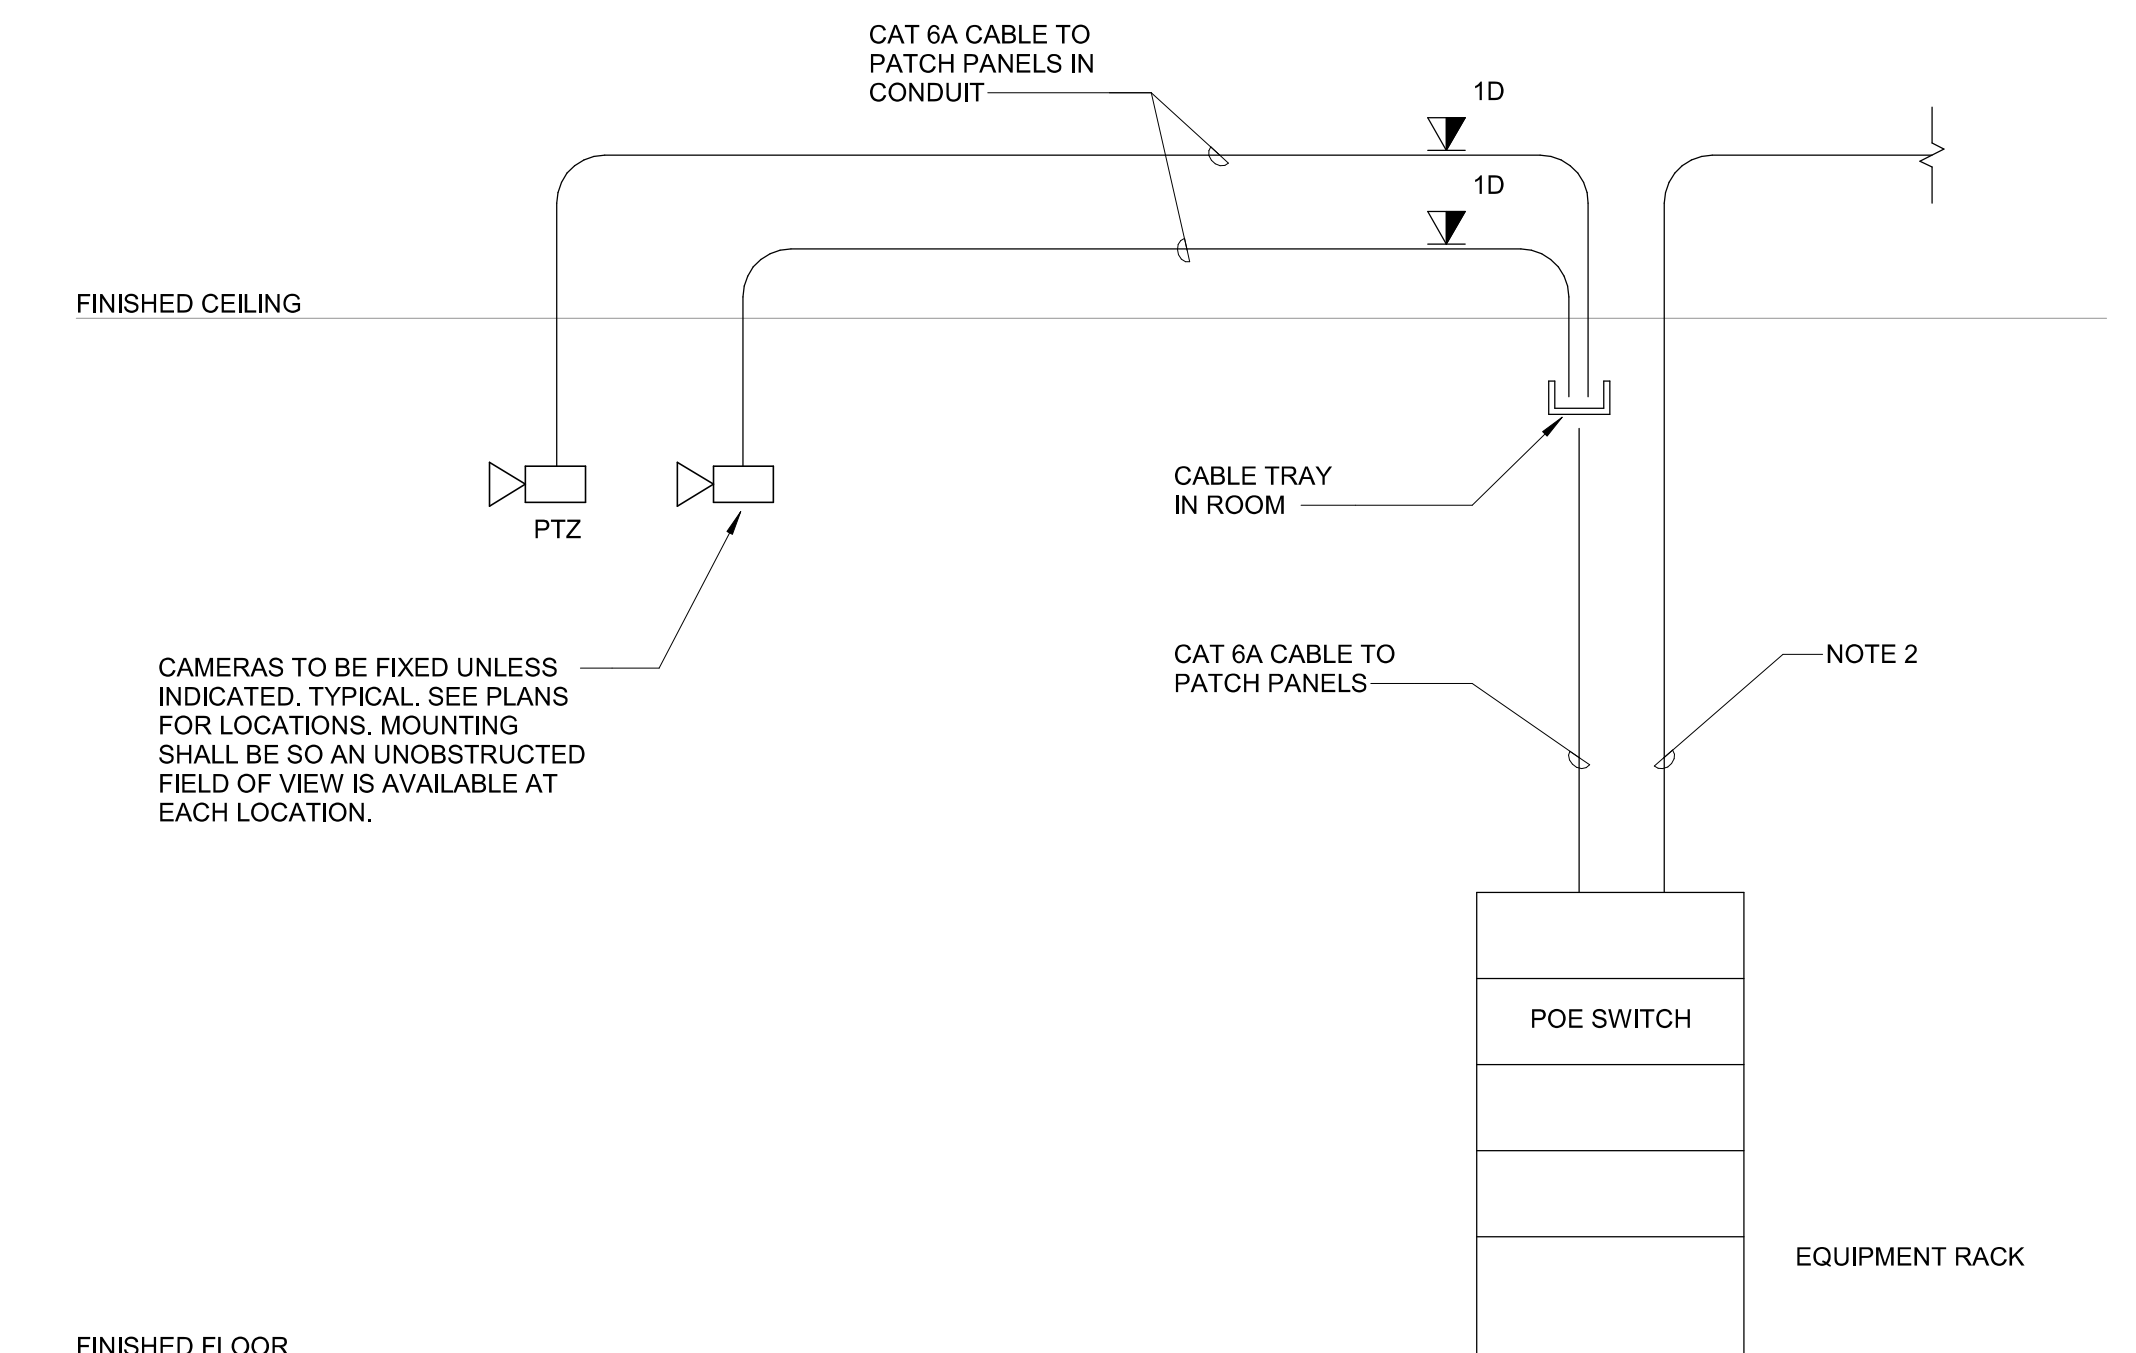

- NOTES:**
1. THE MAXIMUM NUMBER OF DATA CABLES IN A CONDUIT SLEEVE SHALL NOT EXCEED 40% FILL.
 2. 12 STRAND SINGLE MODE FIBER OPTIC CABLE TO MAIN SYSTEMS ROOM 147A ON FIRST FLOOR.

B6 CAMERA RISER DIAGRAM - A
NO SCALE

4/12/2024 11:23:59 AM
BIM 360://19022 - Fayetteville, IDIQ Project No. 664-19-403 Renovation of SPS/19022 - ELECT - R2026.rvt

Revision Number	Revisions:	Date:

CONSULTANTS
CONSULTING STRUCTURAL ENGINEERS

BRITT, PETERS AND ASSOCIATES
INC.
consulting engineers

ARCHITECT/ENGINEER OF RECORD

A/E:
HARRELL DESIGN GROUP PC
10720 SIKES PLACE, SUITE 100
CHARLOTTE, NC 28277
704-814-1346
POC: LEE HARRELL PE, LEED AP, QCxP
PRESIDENT
HDG PROJECT: 19022

HARRELL
DESIGN GROUP, P.C.
WWW.HARRELLDG.COM
COPYRIGHT © 2024

Digital Signature not valid without Certificate below seal.

John G. Ross, PE
Digitally signed by John G. Ross, PE
Date: 2024.04.12 11:53:17 -0400

DRAWING TITLE
ELECTRICAL DETAILS

APPROVED

PHASE
CONSTRUCTION DOCUMENTS SUBMISSION

FULLY SPRINKLERED

PROJECT TITLE
RENOVATE SPACE FOR LOGISTICS (B-1)

LOCATION
FAYETTEVILLE VA MEDICAL CENTER

ISSUE DATE
11 APRIL 2024

CHECKED
CSR

DRAWN
CSR

PROJECT NUMBER
564-24-104

BUILDING NUMBER
1

DRAWING NUMBER
EE502-A

Engineering Service
VETERANS HEALTH CARE SYSTEM OF THE OZARKS

U.S. Department of Veterans Affairs