 
 


C2 FIRST FLOOR - LIGHTING PLAN - TEMPORARY
1/8" = 1'-0"



D4 FIRST FLOOR - LIGHTING PLAN - A
1/8" = 1'-0"



GENERAL LIGHTING NOTES


- REFER TO DRAWING E001 FOR TYPICAL SYMBOLS AND ABBREVIATIONS USED IN THIS DRAWING.
- REFER TO ARCHITECTURAL REFLECTED CEILING PLAN FOR EXACT LOCATIONS OF ALL CEILING MOUNTED FIXTURES AND DEVICES.
- CONNECT ALL EMERGENCY EGRESS LIGHTING AND EXIT SIGNS AHEAD OF ANY LOCAL SWITCHING.
- REVIEW THE CONSTRUCTION DOCUMENTS OF ALL TRADES FOR ADDITIONAL PHASING REQUIREMENTS.

SHEET KEYNOTES

- COORDINATE DUCT ALTERNATE 1 WITH ARCHITECTURE.
- CONNECT TO EXISTING CORRIDOR NORMAL LIGHTING CIRCUIT.
- PROVIDE EXIT SIGN DURING INITIAL CONSTRUCTION, AND REMOVE WHEN TEMPORARY WALL IS DEMOLISHED AT THE END OF THE PROJECT. CONNECT EXIT SIGN TO EXISTING AREA EMERGENCY LIGHTING CIRCUIT.
- PROVIDE EXIT SIGN DURING INITIAL CONSTRUCTION, AND RELOCATE WHEN TEMPORARY WALL IS DEMOLISHED AT THE END OF THE PROJECT. CONNECT EXIT SIGN TO EXISTING AREA EMERGENCY LIGHTING CIRCUIT. SEE D4 ON THIS SHEET FOR FINAL PHASE LIGHTING PLAN.

PARTITION GRAPHICS

- NO RATING
- SMOKE RESISTIVE PARTITION - NON RATED
- 1 HOUR FIRE BARRIER
- 1 HOUR FIRE/SMOKE BARRIER
- 2 HOUR FIRE BARRIER
- 2 HOUR FIRE/SMOKE BARRIER

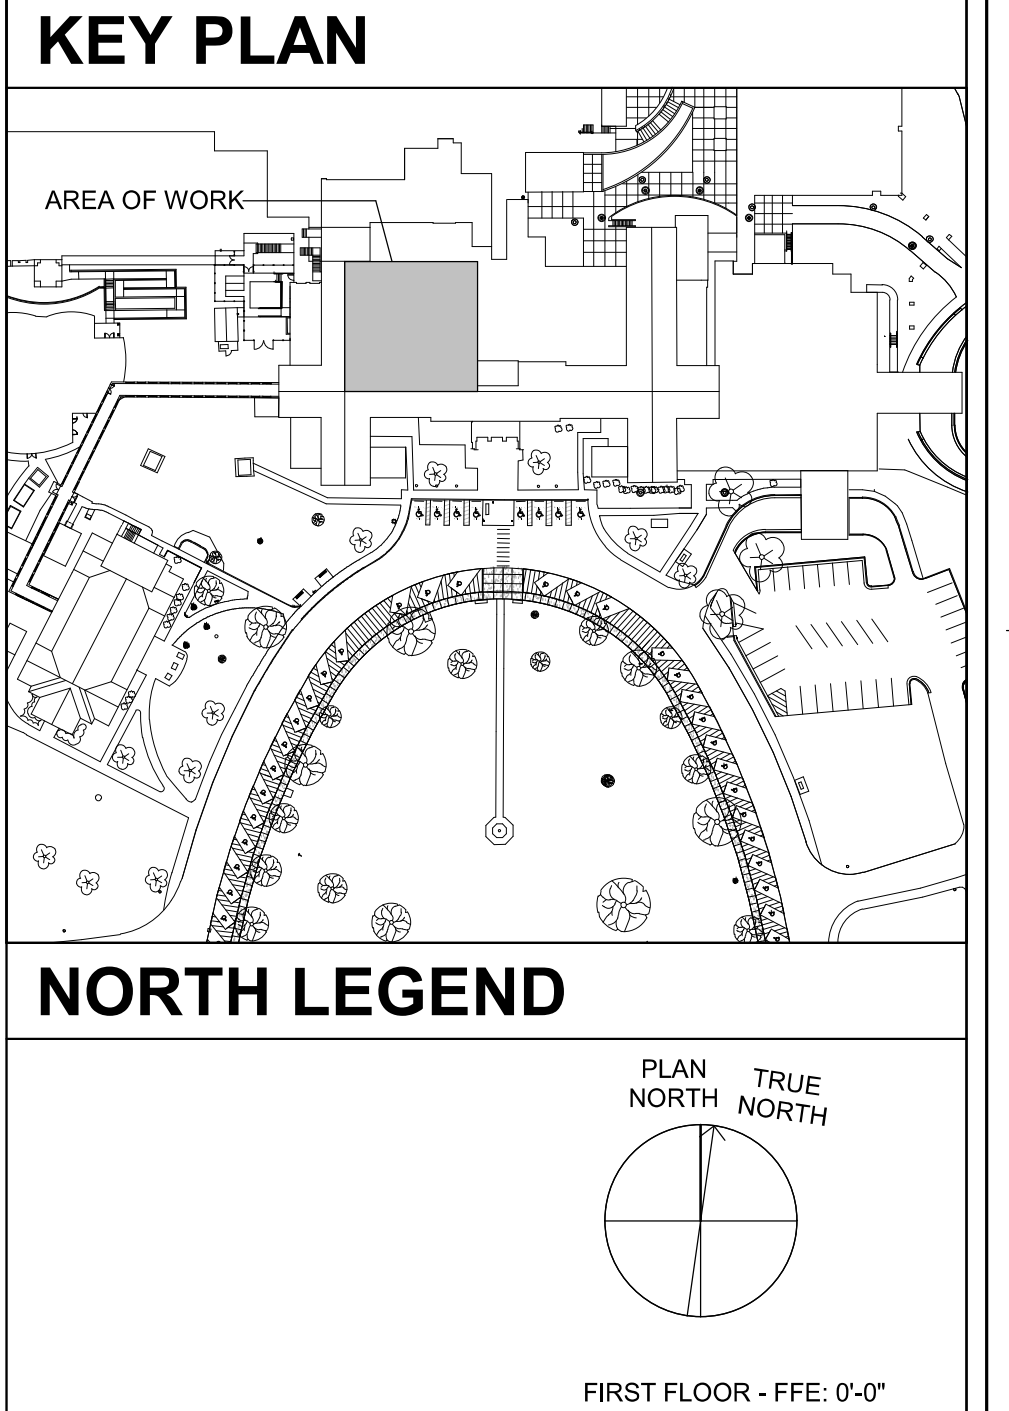

4/12/2024 11:24:05 AM
BIM 360/191022 - Fayetteville (D) Project No. 664-19-103 Renovation of SPS/191022 - ELECT - R2026.rvt

Revision Number	Revisions:	Date:

CONSULTANTS
CONSULTING STRUCTURAL ENGINEERS

ARCHITECT/ENGINEER OF RECORD

A/E:
HARRELL DESIGN GROUP PC
10720 SIKES PLACE, SUITE 100
CHARLOTTE, NC 28277
704-814-1346
POC: LEE HARRELL PE, LEED AP, QCCP
PRESIDENT
HDG PROJECT: 19022

www.harrelldg.com
COPYRIGHT © 2024

Digital Signature not valid without Certificate below seal.

John G. Ross, PE
Date: 2024.04.12 11:53:13-0400'

DRAWING TITLE
FIRST FLOOR - LIGHTING PLAN

APPROVED

PHASE
CONSTRUCTION DOCUMENTS SUBMISSION

FULLY SPRINKLERED

PROJECT TITLE
RENOVATE SPACE FOR LOGISTICS (B-1)

LOCATION
FAYETTEVILLE VA MEDICAL CENTER

ISSUE DATE
11 APRIL 2024

CHECKED
CSR

DRAWN
CSR

PROJECT NUMBER
564-24-104

BUILDING NUMBER
1

DRAWING NUMBER
EL101-A

Engineering Service

VETERANS HEALTH CARE SYSTEM OF THE OZARKS

VA U.S. Department of Veterans Affairs