
 


A B C

A B C D E F

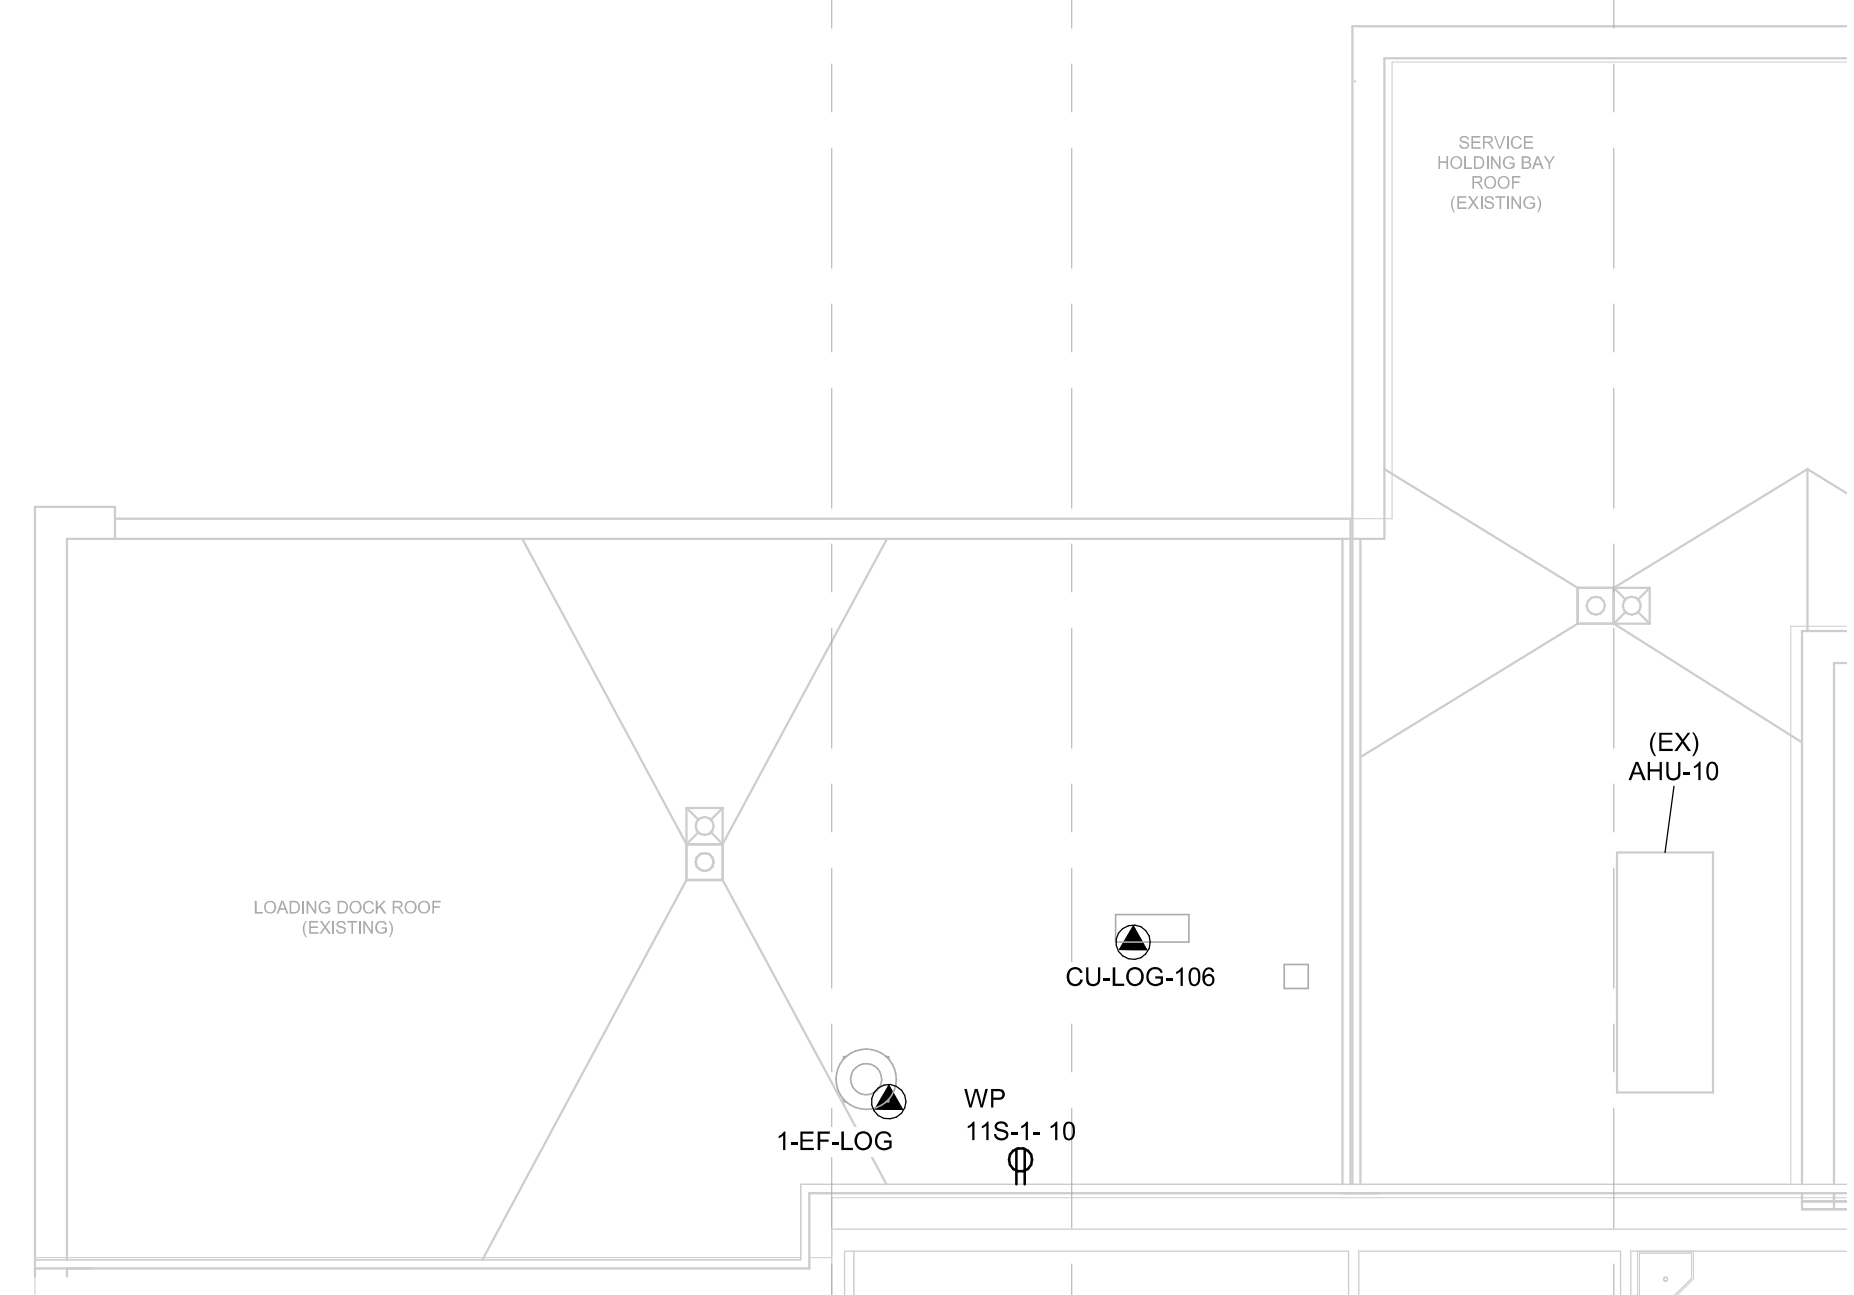

B2 ROOF PLAN - LOADING DOCK - POWER PLAN
1/8" = 1'-0"




1


2

3

4

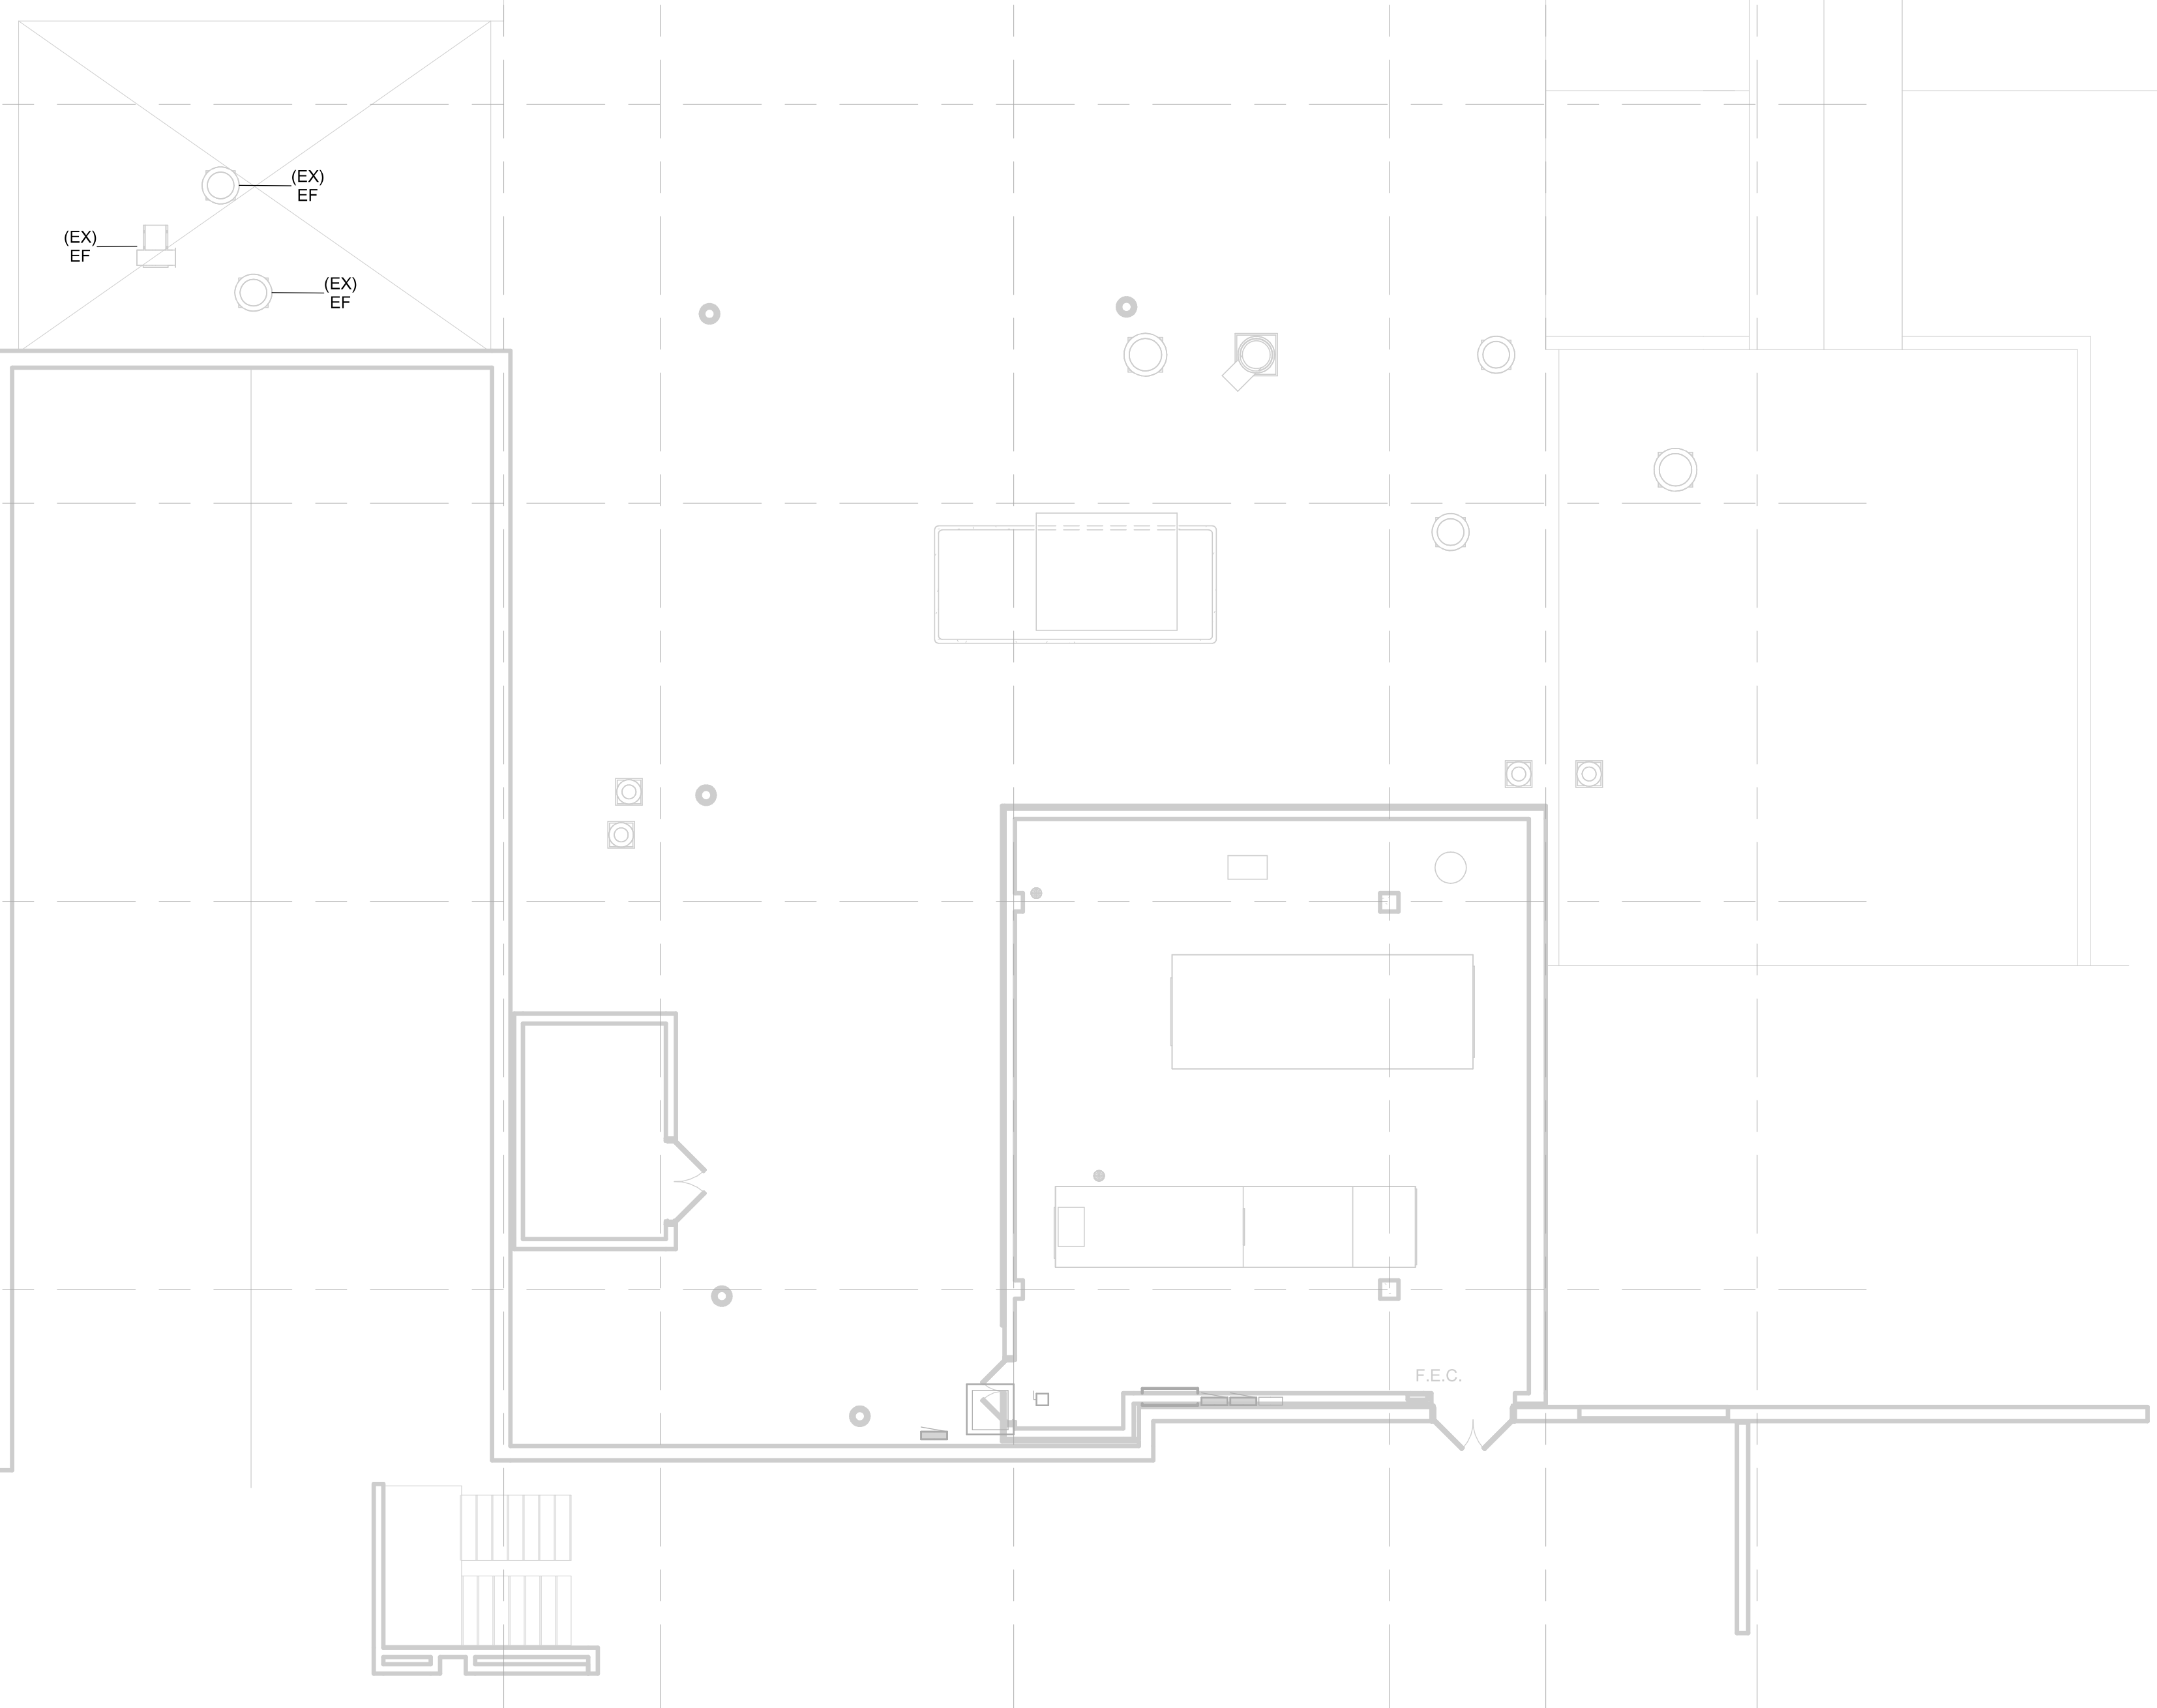

F5 ROOF PLAN - POWER - A
1/8" = 1'-0"

 

GENERAL POWER NOTES

- A. REFER TO DRAWING EG001-A FOR TYPICAL SYMBOLS AND ABBREVIATIONS USED IN THIS DRAWING.
- B. CONFIRM RECEPTACLE LOCATIONS AND MOUNTING HEIGHTS WITH ARCHITECTURAL INTERIOR ELEVATIONS PRIOR TO ROUGH-IN.
- C. ALL RECEPTACLES WITHIN 6'-0" OF SNK SHALL BE OF THE GFCI TYPE.
- D. REVIEW THE CONSTRUCTION DOCUMENTS OF ALL TRADES FOR PHASING REQUIREMENTS.


SHEET KEYNOTES

- 1. CONNECT NEW MECHANICAL EQUIPMENT TO EXISTING LIGHTNING PROTECTION SYSTEM


PARTITION GRAPHICS

- NO RATING
- SMOKE RESISTIVE PARTITION - NON RATED
- 1 HOUR FIRE BARRIER
- 1 HOUR FIRE/SMOKE BARRIER
- 2 HOUR FIRE BARRIER
- 2 HOUR FIRE/ SMOKE BARRIER

KEY PLAN

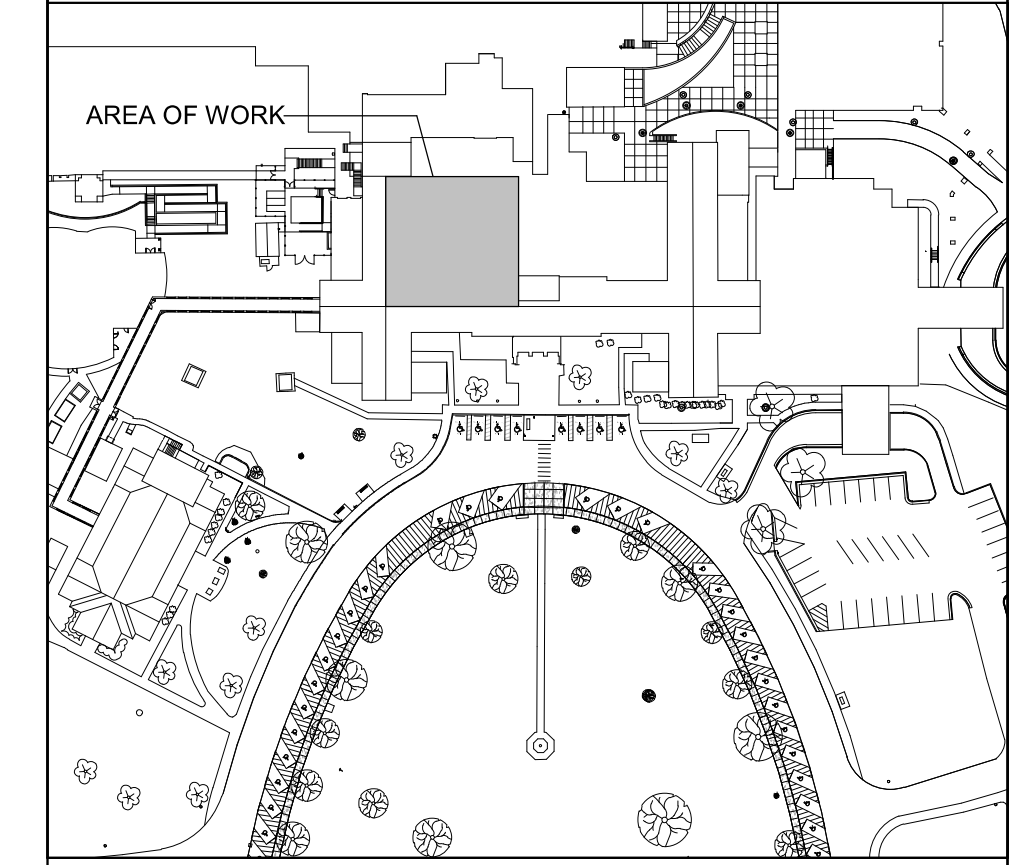

NORTH LEGEND

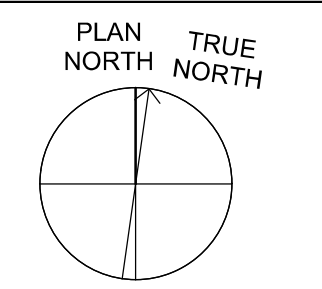

FIRST FLOOR - FFE: 0'-0"

4/12/2024 11:24:06 AM
B:\1360191922 - Fayetteville IDIC Project No. 664-19-403 Renovation of SPS/19022 - ELECT - R0206.rvt

Revision Number	Revisions:	Date:

CONSULTANTS
CONSULTING STRUCTURAL ENGINEERS

ARCHITECT/ENGINEER OF RECORD

A/E:
HARRELL DESIGN GROUP PC
10720 SIKES PLACE, SUITE 100
CHARLOTTE, NC 28277
704-814-1346
POC: LEE HARRELL PE, LEED AP, QCCP
PRESIDENT
HDG PROJECT: 19022

WWW.HARRELLDG.COM
COPYRIGHT © 2024

Digital Signature not valid without Certificate below seal.

John G. Ross, PE
Digitally signed by John G. Ross, PE
Date: 2024.04.12 11:23:14-0400'

DRAWING TITLE
ROOF PLAN - POWER

APPROVED

PHASE
CONSTRUCTION DOCUMENTS SUBMISSION

FULLY SPRINKLERED

PROJECT TITLE
RENOVATE SPACE FOR LOGISTICS (B-1)

LOCATION
FAYETTEVILLE VA MEDICAL CENTER

ISSUE DATE
11 APRIL 2024

CHECKED
CSR

DRAWN
CSR

PROJECT NUMBER
564-24-104

BUILDING NUMBER
1

DRAWING NUMBER
EP104-A

Engineering Service

VA U.S. Department of Veterans Affairs