

GENERAL SYSTEMS NOTES

- A. REFER TO ARCHITECTURAL REFLECTED CEILING PLAN FOR EXACT LOCATION OF ALL CEILING MOUNTED FIXTURES AND DEVICES. CONFIRM TELEPHONE DATA OUTLET LOCATIONS AND MOUNTING HEIGHTS WITH ARCHITECTURAL INTERIOR ELEVATIONS PRIOR TO ROUGH-IN.
- B. CONFIRM TV OUTLET LOCATIONS AND MOUNTING HEIGHT WITH ARCHITECTURAL INTERIOR ELEVATIONS PRIOR TO ROUGH-IN.
- C. COORDINATE LOCATION AND MOUNTING HEIGHT OF ALL DOOR SECURITY DEVICES AND HARDWARE (CARD READERS ETC.) WITH ARCHITECTURAL FLOOR PLANS AND INTERIOR ELEVATIONS PRIOR TO ROUGH-IN.
- D. REVIEW THE CONSTRUCTION DOCUMENTS OF ALL TRADES FOR PHASING REQUIREMENTS.


SHEET KEYNOTES

1. PORTION OF ACoustICAL CEILING TILE SYSTEM TO BE COMPLETED AT CONCLUSION OF CONSTRUCTION PERIOD. ACoustICAL CEILING TILE SYSTEM, LIGHTING, AND CEILING DEVICES TO BE INSTALLED ONCE TEMPORARY CONSTRUCTION BARRIER HAS BEEN REMOVED. SEE ARCHITECTURAL PLANS FOR MORE DETAILS.


PARTITION GRAPHICS

- NO RATING
- SMOKE RESISTIVE PARTITION - NON RATED
- 1 HOUR FIRE BARRIER
- 1 HOUR FIRE/SMOKE BARRIER
- 2 HOUR FIRE BARRIER
- 2 HOUR FIRE/ SMOKE BARRIER

KEY PLAN

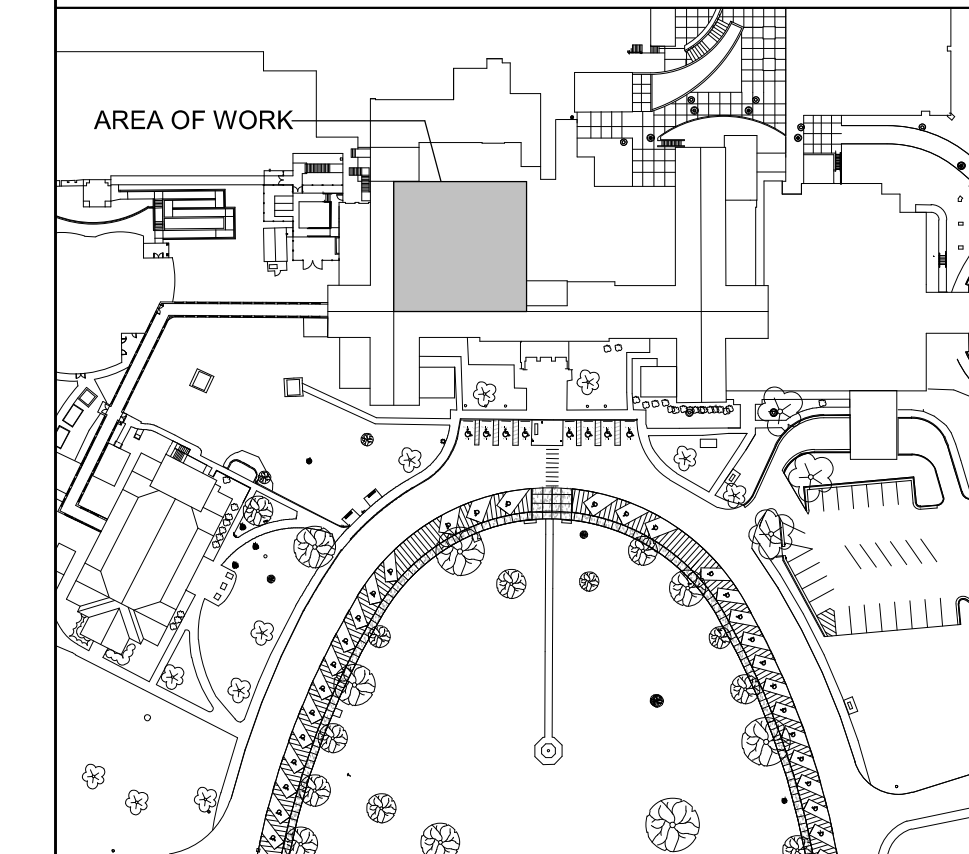


NORTH LEGEND

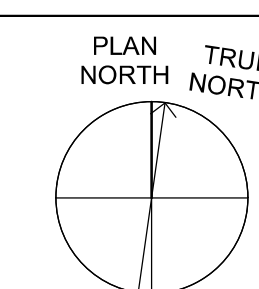

FIRST FLOOR - FFE: 0'-0"

 D4 FIRST FLOOR - SYSTEMS PLAN - A
1/8" = 1'-0"



Revision Number	Revisions:	Date:

CONSULTANTS
CONSULTING STRUCTURAL ENGINEERS

ARCHITECT/ENGINEER OF RECORD

A/E:
HARRELL DESIGN GROUP PC
10720 SIKES PLACE, SUITE 100
CHARLOTTE, NC 28277
704-814-1346
POC: LEE HARRELL PE, LEED AP, QCCP
PRESIDENT
HDG PROJECT: 19022

WWW.HARRELLDG.COM
COPYRIGHT © 2024

Digital Signature not valid without Certificate below seal.

John G. Ross, PE
Digitally signed by John G. Ross, PE
Date: 2024.04.12 11:50:19-0400'

DRAWING TITLE
FIRST FLOOR - SYSTEMS PLAN

APPROVED

PHASE
CONSTRUCTION DOCUMENTS SUBMISSION

FULLY SPRINKLERED

PROJECT TITLE
RENOVATE SPACE FOR LOGISTICS (B-1)

LOCATION
FAYETTEVILLE VA MEDICAL CENTER

ISSUE DATE
11 APRIL 2024

CHECKED
CSR

DRAWN
CSR

PROJECT NUMBER
564-24-104

BUILDING NUMBER
1

DRAWING NUMBER
EY101-A

Engineering Service

VETERANS HEALTH CARE SYSTEM OF THE OZARKS

VA U.S. Department of Veterans Affairs