


FIRE ALARM NOTES

- A. FIRE ALARM DEVICES ARE TO BE INSTALLED IN ACCORDANCE WITH NFPA 72.
- B. ACTUATION OF ANY SYSTEM INITIATING DEVICE SHALL ACTIVATE ALL INDICATING DEVICES, UNLESS NOTED OTHERWISE.
- C. VERIFY COMPONENT TYPES AND QUANTITIES WITH PLAN DRAWINGS.
- D. ALL FIRE ALARM WIRING TO BE INSTALLED IN RACEWAYS.
- E. PROVIDE ALL REQUIRED POWER SUPPLIES, BOOSTER PANELS, MODULES, ETC. FOR A COMPLETE SYSTEM.
- F. FIRE PROTECTION CONTRACTOR TO COORDINATE SPECIFIC WIRING REQUIREMENTS WITH EQUIPMENT MANUFACTURER.
- G. REFER TO THE SPECIFICATIONS FOR MOUNTING HEIGHTS FOR INITIATING DEVICES AND NOTIFICATION APPLIANCES.
- H. REVIEW THE CONSTRUCTION DOCUMENTS OF ALL TRADES FOR PHASING REQUIREMENTS.


PARTITION GRAPHICS

- NO RATING
- SMOKE RESISTIVE PARTITION - NON RATED
- 1 HOUR FIRE BARRIER
- 1 HOUR FIRE/SMOKE BARRIER
- 2 HOUR FIRE BARRIER
- 2 HOUR FIRE/ SMOKE BARRIER

KEY PLAN


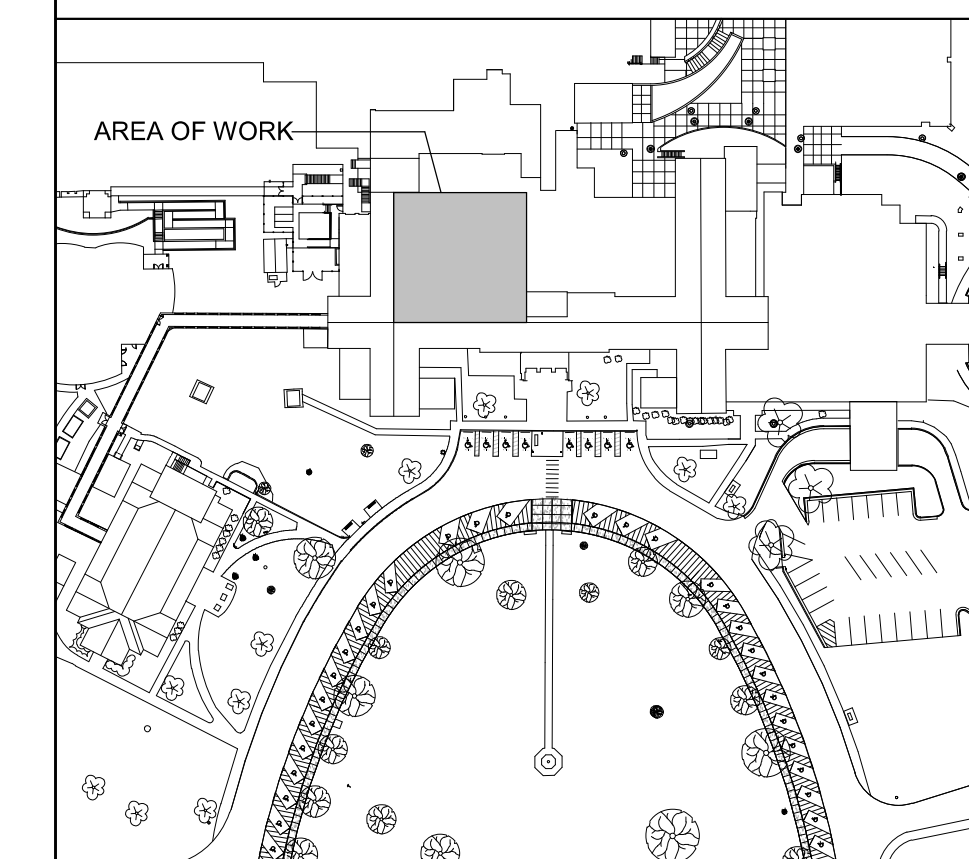


NORTH LEGEND

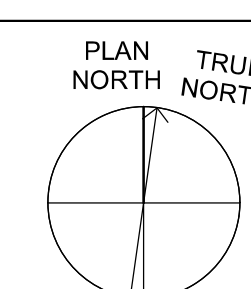

FIRST FLOOR - FFE: 0'-0"

 D4 FIRST FLOOR - FIRE ALARM PLAN -A
1/8" = 1'-0"

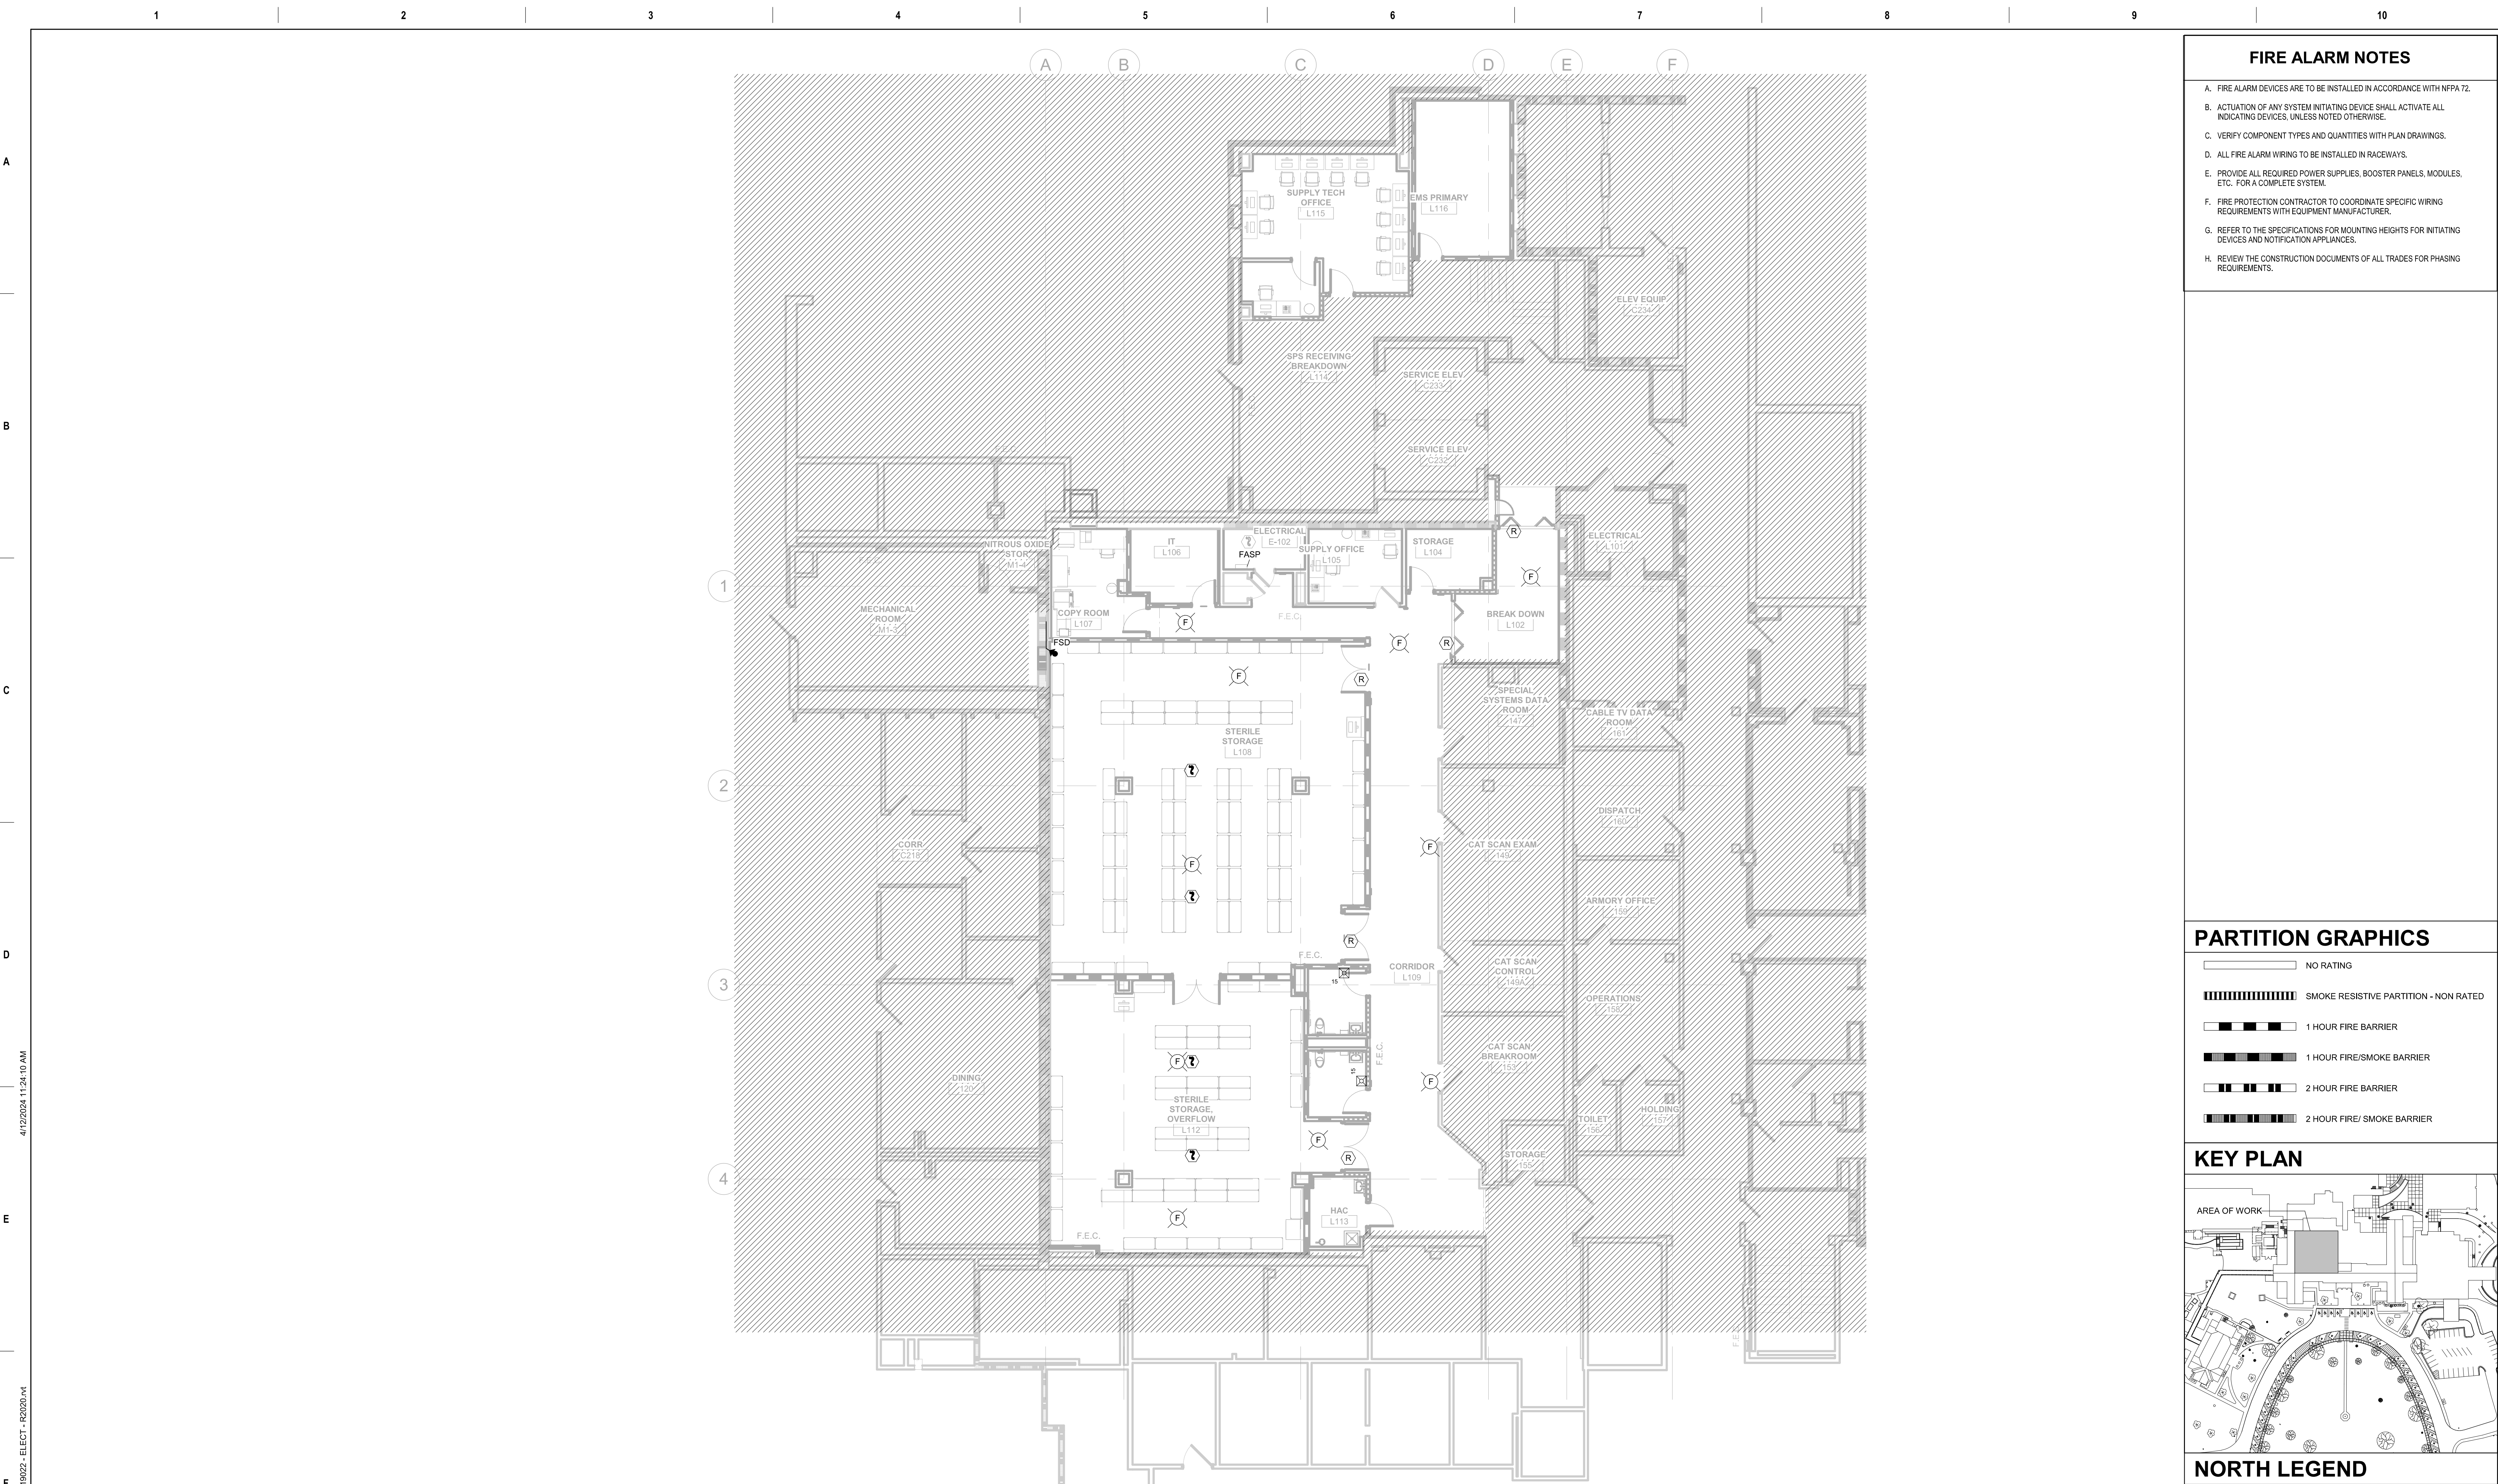

Revision Number	Revisions:	Date:

CONSULTANTS
CONSULTING STRUCTURAL ENGINEERS

ARCHITECT/ENGINEER OF RECORD

A/E:
HARRELL DESIGN GROUP PC
10720 SIKES PLACE, SUITE 100
CHARLOTTE, NC 28277
704-814-1346
POC: LEE HARRELL PE, LEED AP, QCCP
PRESIDENT
HDG PROJECT: 19022

WWW.HARRELLDG.COM
COPYRIGHT © 2024

Digital Signature not valid without Certificate below seal.

John G. Ross, PE
Date: 2024.04.12 11:53:20-0400'

DRAWING TITLE
FIRST FLOOR - FIRE ALARM PLAN

APPROVED

PHASE
CONSTRUCTION DOCUMENTS SUBMISSION

FULLY SPRINKLERED

PROJECT TITLE
RENOVATE SPACE FOR LOGISTICS (B-1)

LOCATION
FAYETTEVILLE VA MEDICAL CENTER

ISSUE DATE
11 APRIL 2024

CHECKED
CSR

DRAWN
CSR

PROJECT NUMBER
564-24-104

BUILDING NUMBER
1

DRAWING NUMBER
FA101-A

Engineering Service

VETERANS HEALTH CARE SYSTEM OF THE OZARKS

VA U.S. Department of Veterans Affairs