

**GENERAL NOTES**

- A. REFER TO SHEET FX01-A FOR LEGEND, ABBREVIATIONS, SCHEDULES AND GENERAL NOTES.
- B. TEMPORARY FIRE SPRINKLER COVERAGE SHALL BE MAINTAINED DURING DEMOLITION. PROVIDE SPRINKLER COVERAGE THROUGHOUT THE PROJECT. SPRINKLER SYSTEM SHALL BE FUNCTIONING AT END OF EACH SHIFT.

**SHEET KEYNOTES**

- 1. CONNECT NEW FIRE PROTECTION PIPING TO EXISTING.
- 2. EXISTING FHV TO REMAIN.
- 3. ALL WORK IN CORRIDOR L109 MUST BE PERFORMED AFTER HOURS AND MUST BE PATIENT ACCESSIBLE DURING FACILITY OPERATION HOURS. SEE SHEET AE111-A FOR MORE INFORMATION.
- 4. THE EXISTING FLOW AND TAMPER SWITCHES, IN STAIRWELL C227, SHALL REMAIN UNDISTURBED.
- 5. NEW FIRE MAIN TO BE LOCATED AND SIZED BY FIRE SPRINKLER CONTRACTOR.


**PARTITION LEGEND**

- EXISTING PARTITION / BARRIER - WALL TO REMAIN
- EXISTING PARTITION / BARRIER - WALL TO BE REMOVED
- NEW PARTITION / BARRIER - WALL



**PARTITION GRAPHICS**

- NO RATING
- SMOKE RESISTIVE PARTITION - NON RATED
- 1 HOUR FIRE BARRIER
- 1 HOUR FIRE/SMOKE BARRIER
- 2 HOUR FIRE BARRIER
- 2 HOUR FIRE/SMOKE BARRIER

**KEY PLAN**

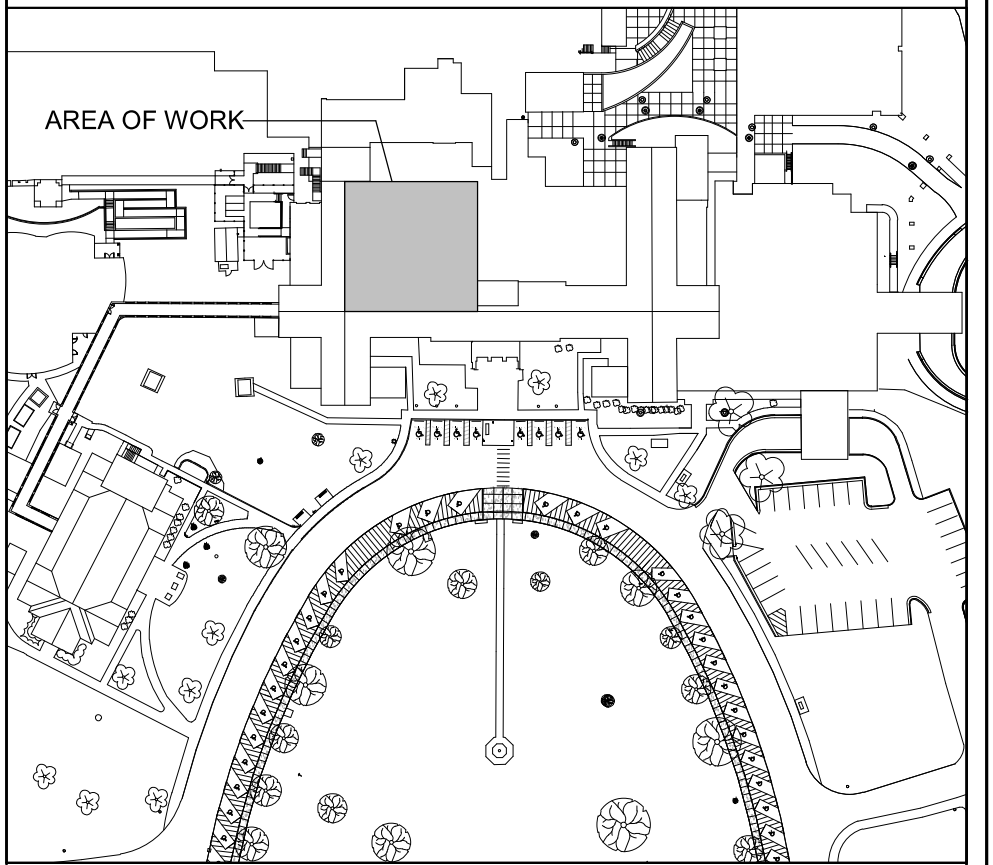

**NORTH LEGEND**

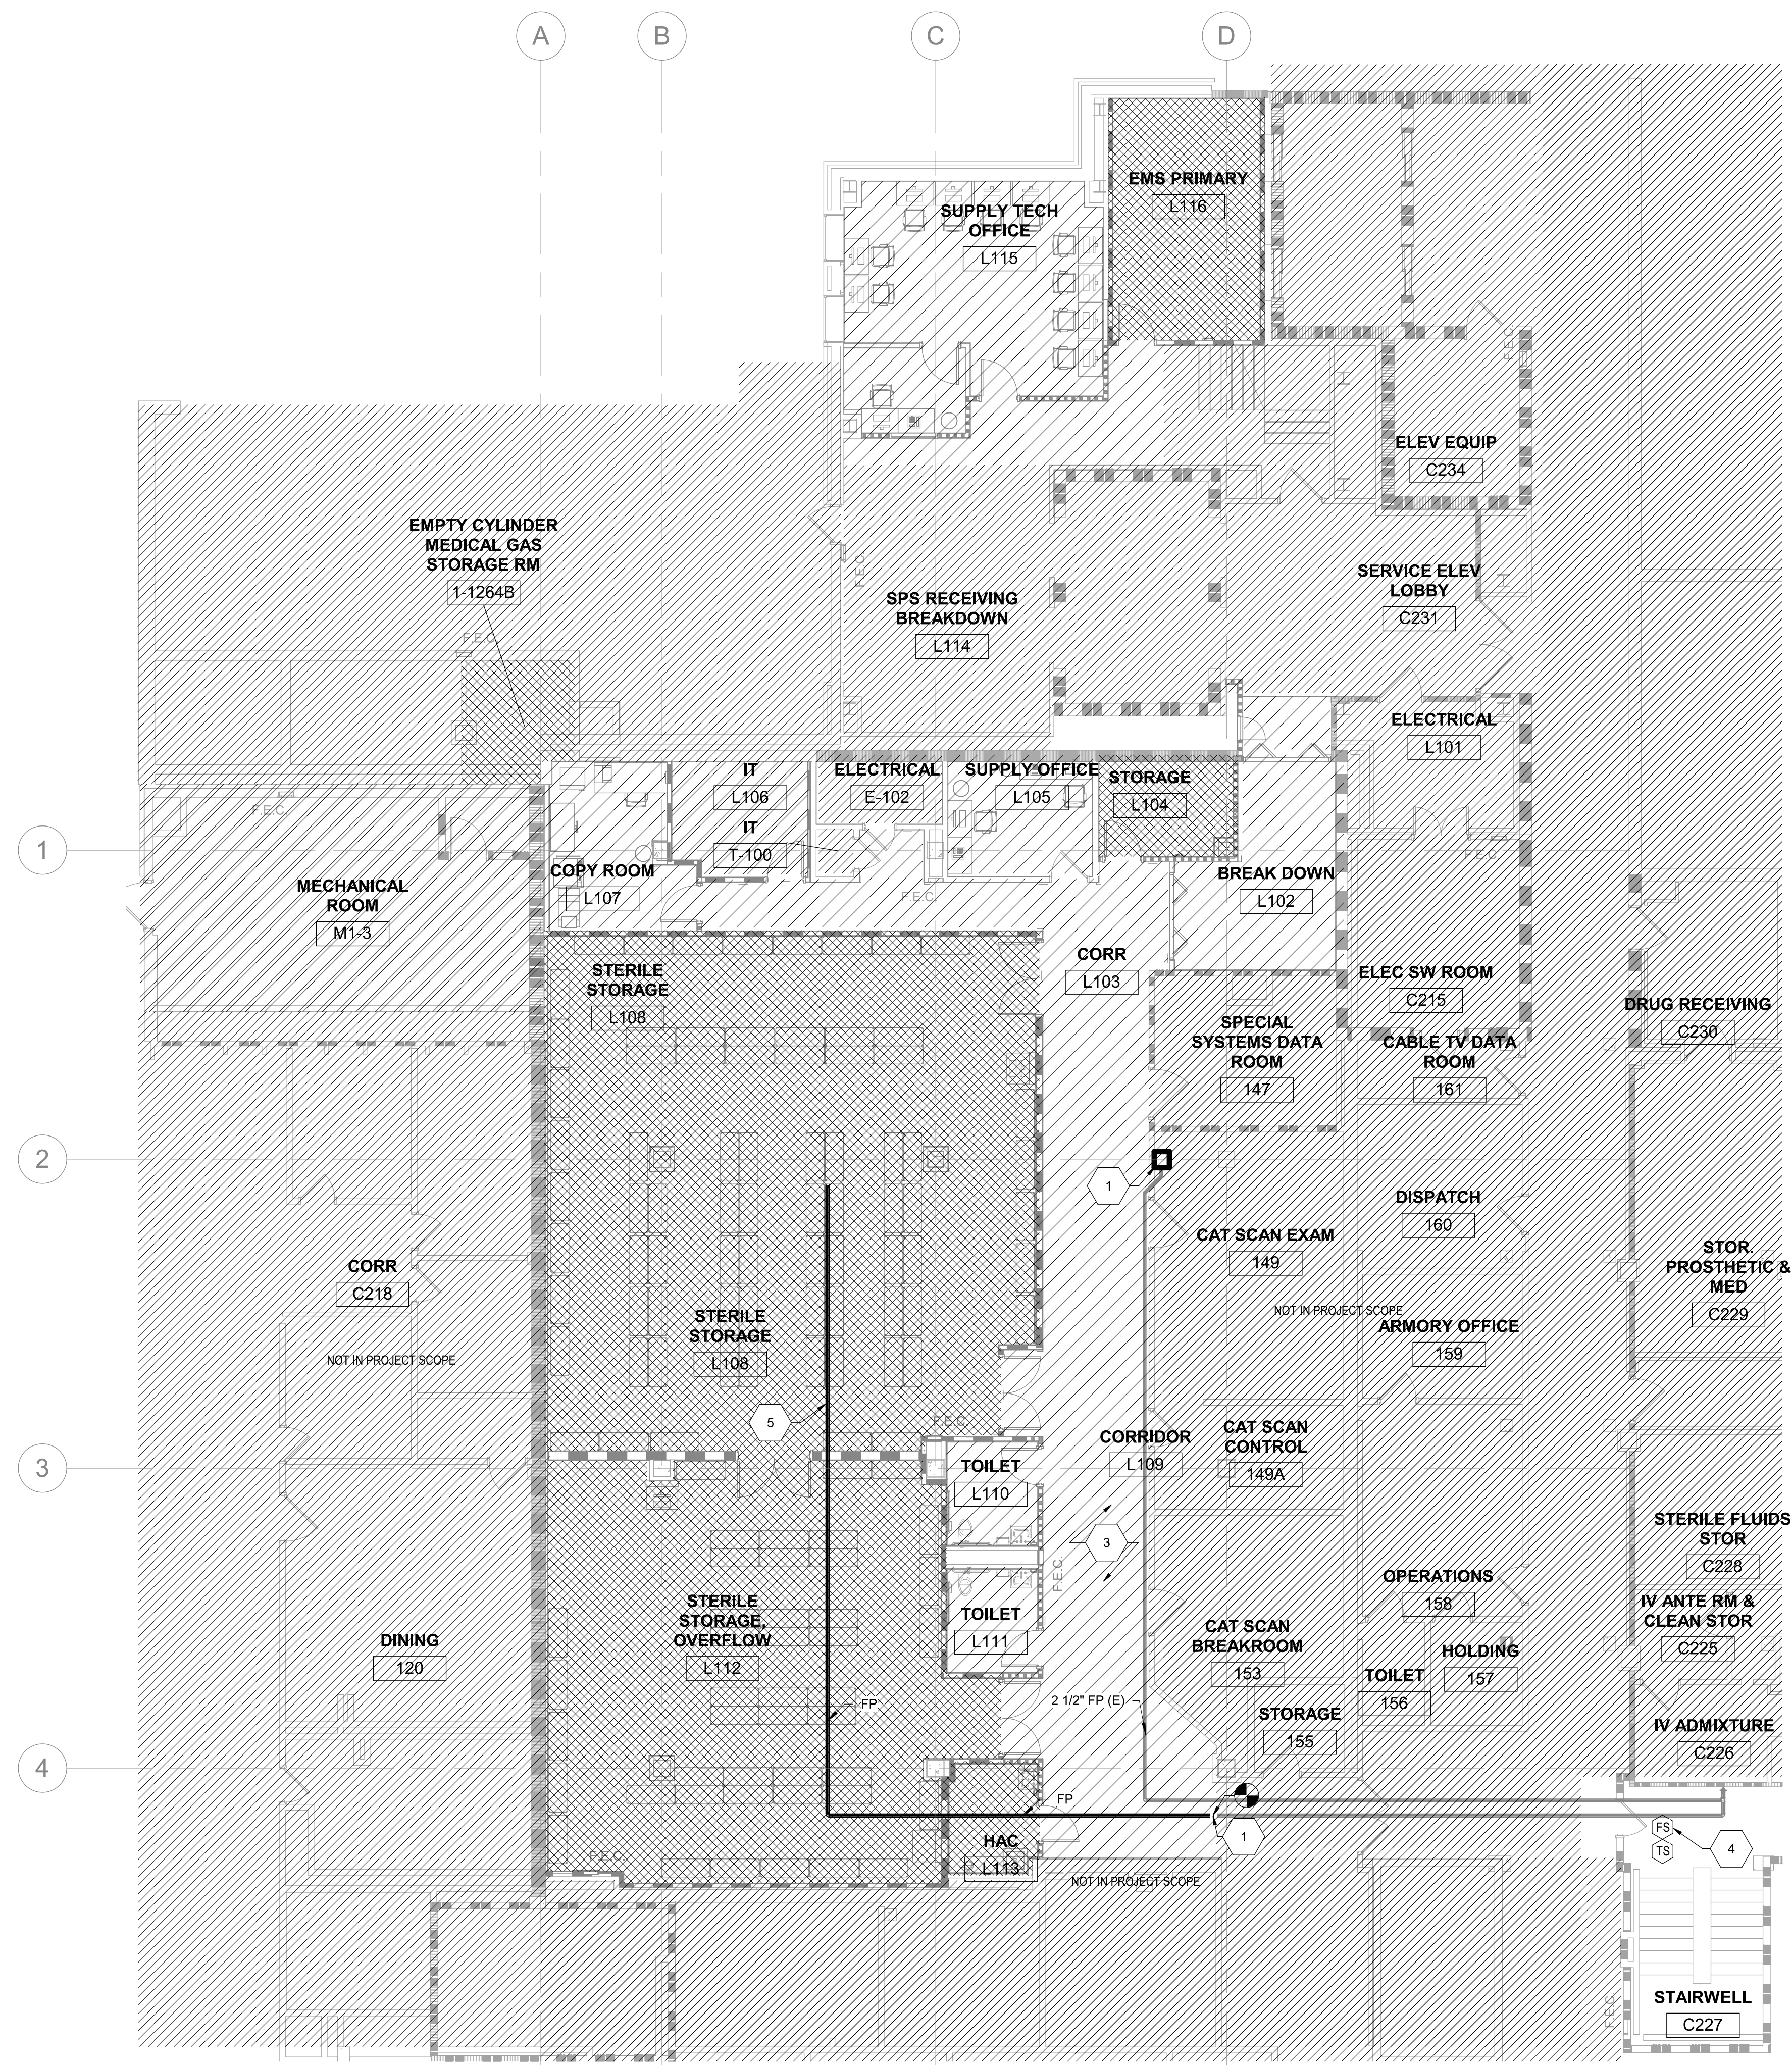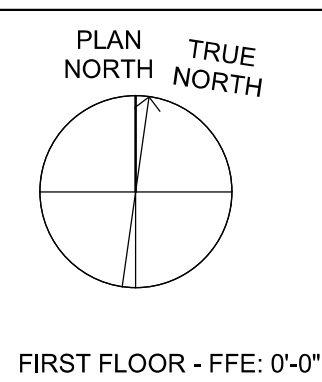

**F4 FIRST FLOOR FIRE PROTECTION PLAN**  
1/8" = 1'-0"



4/11/2024 4:01:27 PM  
BIM 360://19022 - Fayetteville, IDIC Project No. 964-19-003 Renovation of SPS/19022 - PLUMB - R2024.rvt

Revision Number	Revisions:	Date:

**CONSULTANTS**  
CONSULTING STRUCTURAL ENGINEERS

**ARCHITECT/ENGINEER OF RECORD**

A/E:  
HARRELL DESIGN GROUP PC  
10720 SIKES PLACE, SUITE 100  
CHARLOTTE, NC 28277  
704-814-1346  
POC: LEE HARRELL PE, LEED AP, QCCP  
PRESIDENT  
HDG PROJECT: 19022

WWW.HARRELLDG.COM  
COPYRIGHT © 2024

**STAMP**

**DRAWING TITLE**  
FIRST FLOOR FIRE PROTECTION PLAN

APPROVED

**PHASE**  
CONSTRUCTION DOCUMENTS SUBMISSION

FULLY SPRINKLERED

**PROJECT TITLE**  
RENOVATE SPACE FOR LOGISTICS (B-1)

**PROJECT NUMBER**  
564-24-104

**BUILDING NUMBER**  
1

**DRAWING NUMBER**  
FX101-A

**LOCATION**  
FAYETTEVILLE VA MEDICAL CENTER

**ISSUE DATE**  
11 APRIL 2024

**CHECKED**  
WGG

**DRAWN**  
DM

**Engineering Service**

VETERANS HEALTH CARE SYSTEM OF THE OZARKS

U.S. Department of Veterans Affairs