

**GENERAL NOTES**

1. REFER TO SHEET MH001-A FOR LEGENDS, STANDARDS, AND ABBREVIATIONS.


**SHEET KEYNOTES**

- ROUTE REFRIGERANT PIPING TO CONDENSING UNIT ON LOADING DOCK ROOF.
- ELECTRONIC ARRAY OF ALL ROOMS, PRESSURES, AND TEMPERATURES. 'RED' SIGNIFIES ALARM, 'GREEN' SIGNIFIES NORMAL OPERATION.
- 3 HP VFD W/ INTERNAL BYPASS FOR 1-AHJ-LOG.
- BAS CONTROL PANEL.
- ALL WORK IN CORRIDOR L108 MUST BE PERFORMED AFTER HOURS. CORRIDOR MUST BE PATIENT ACCESSIBLE DURING FACILITY OPERATION HOURS. SEE SHEET AE11-A FOR MORE INFORMATION.
- ONE INVERTED BUCKET AND TWO FLOAT AND THERMOSTATIC TRAPS SERVING 1-AHJ-LOG.
- PROVIDE A MINIMUM OF 12" BETWEEN EDGES OF PIPE OPENINGS.
- PROVIDE 3-WAY CONTROL VALVE.


**PARTITION GRAPHICS**

- NO RATING
- SMOKE RESISTIVE PARTITION - NON RATED
- 1 HOUR FIRE BARRIER
- 1 HOUR FIRE/SMOKE BARRIER
- 2 HOUR FIRE BARRIER
- 2 HOUR FIRE/SMOKE BARRIER

**KEY PLAN**

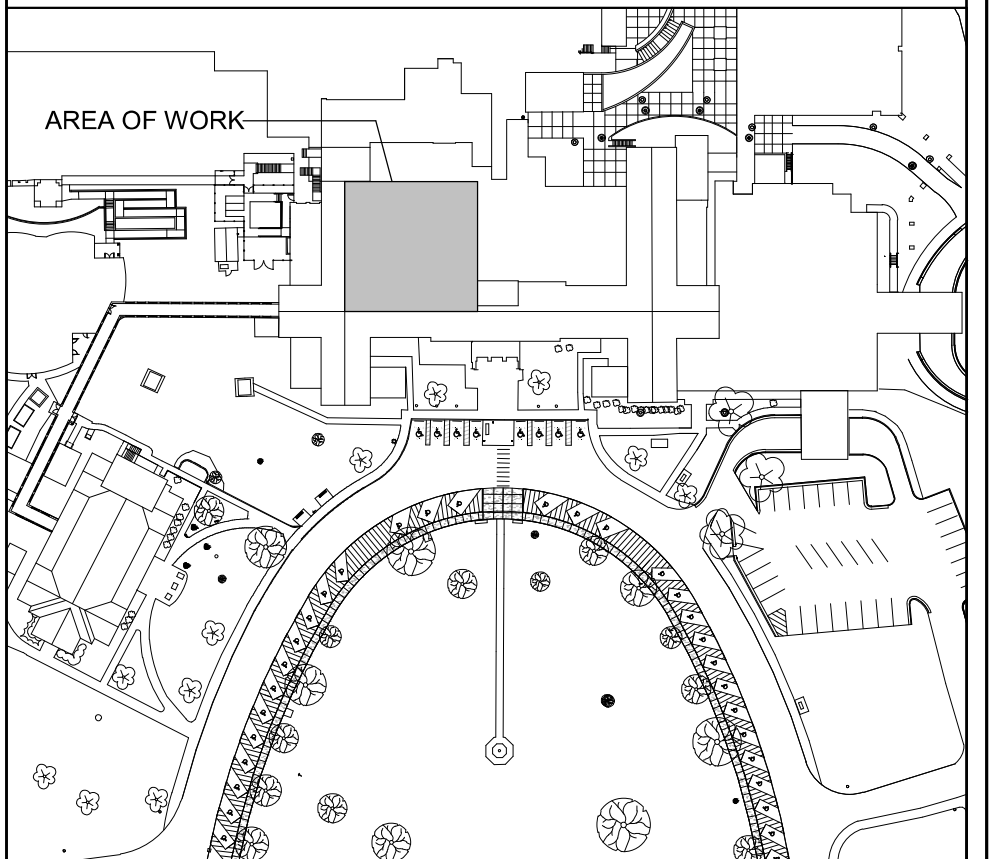


**NORTH LEGEND**

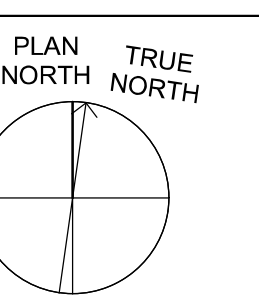


FIRST FLOOR - FFE: 0'-0"

**C2 BASEMENT ELEVATOR LOBBY MECHANICAL PLAN**  
1/8" = 1'-0"

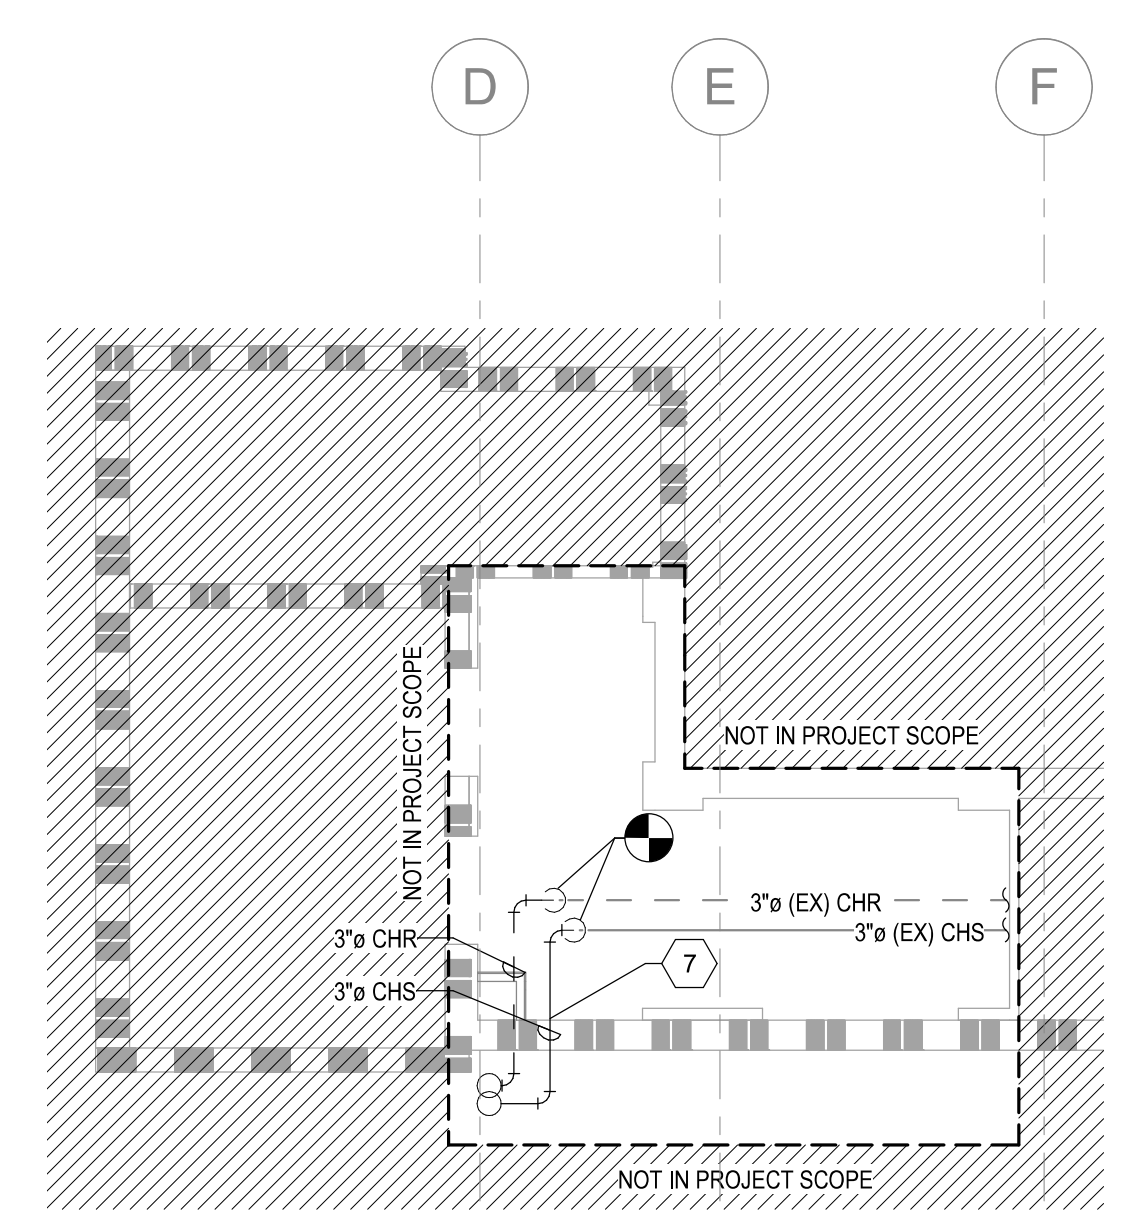

**F4 FIRST FLOOR MECHANICAL PIPING PLAN**  
1/8" = 1'-0"

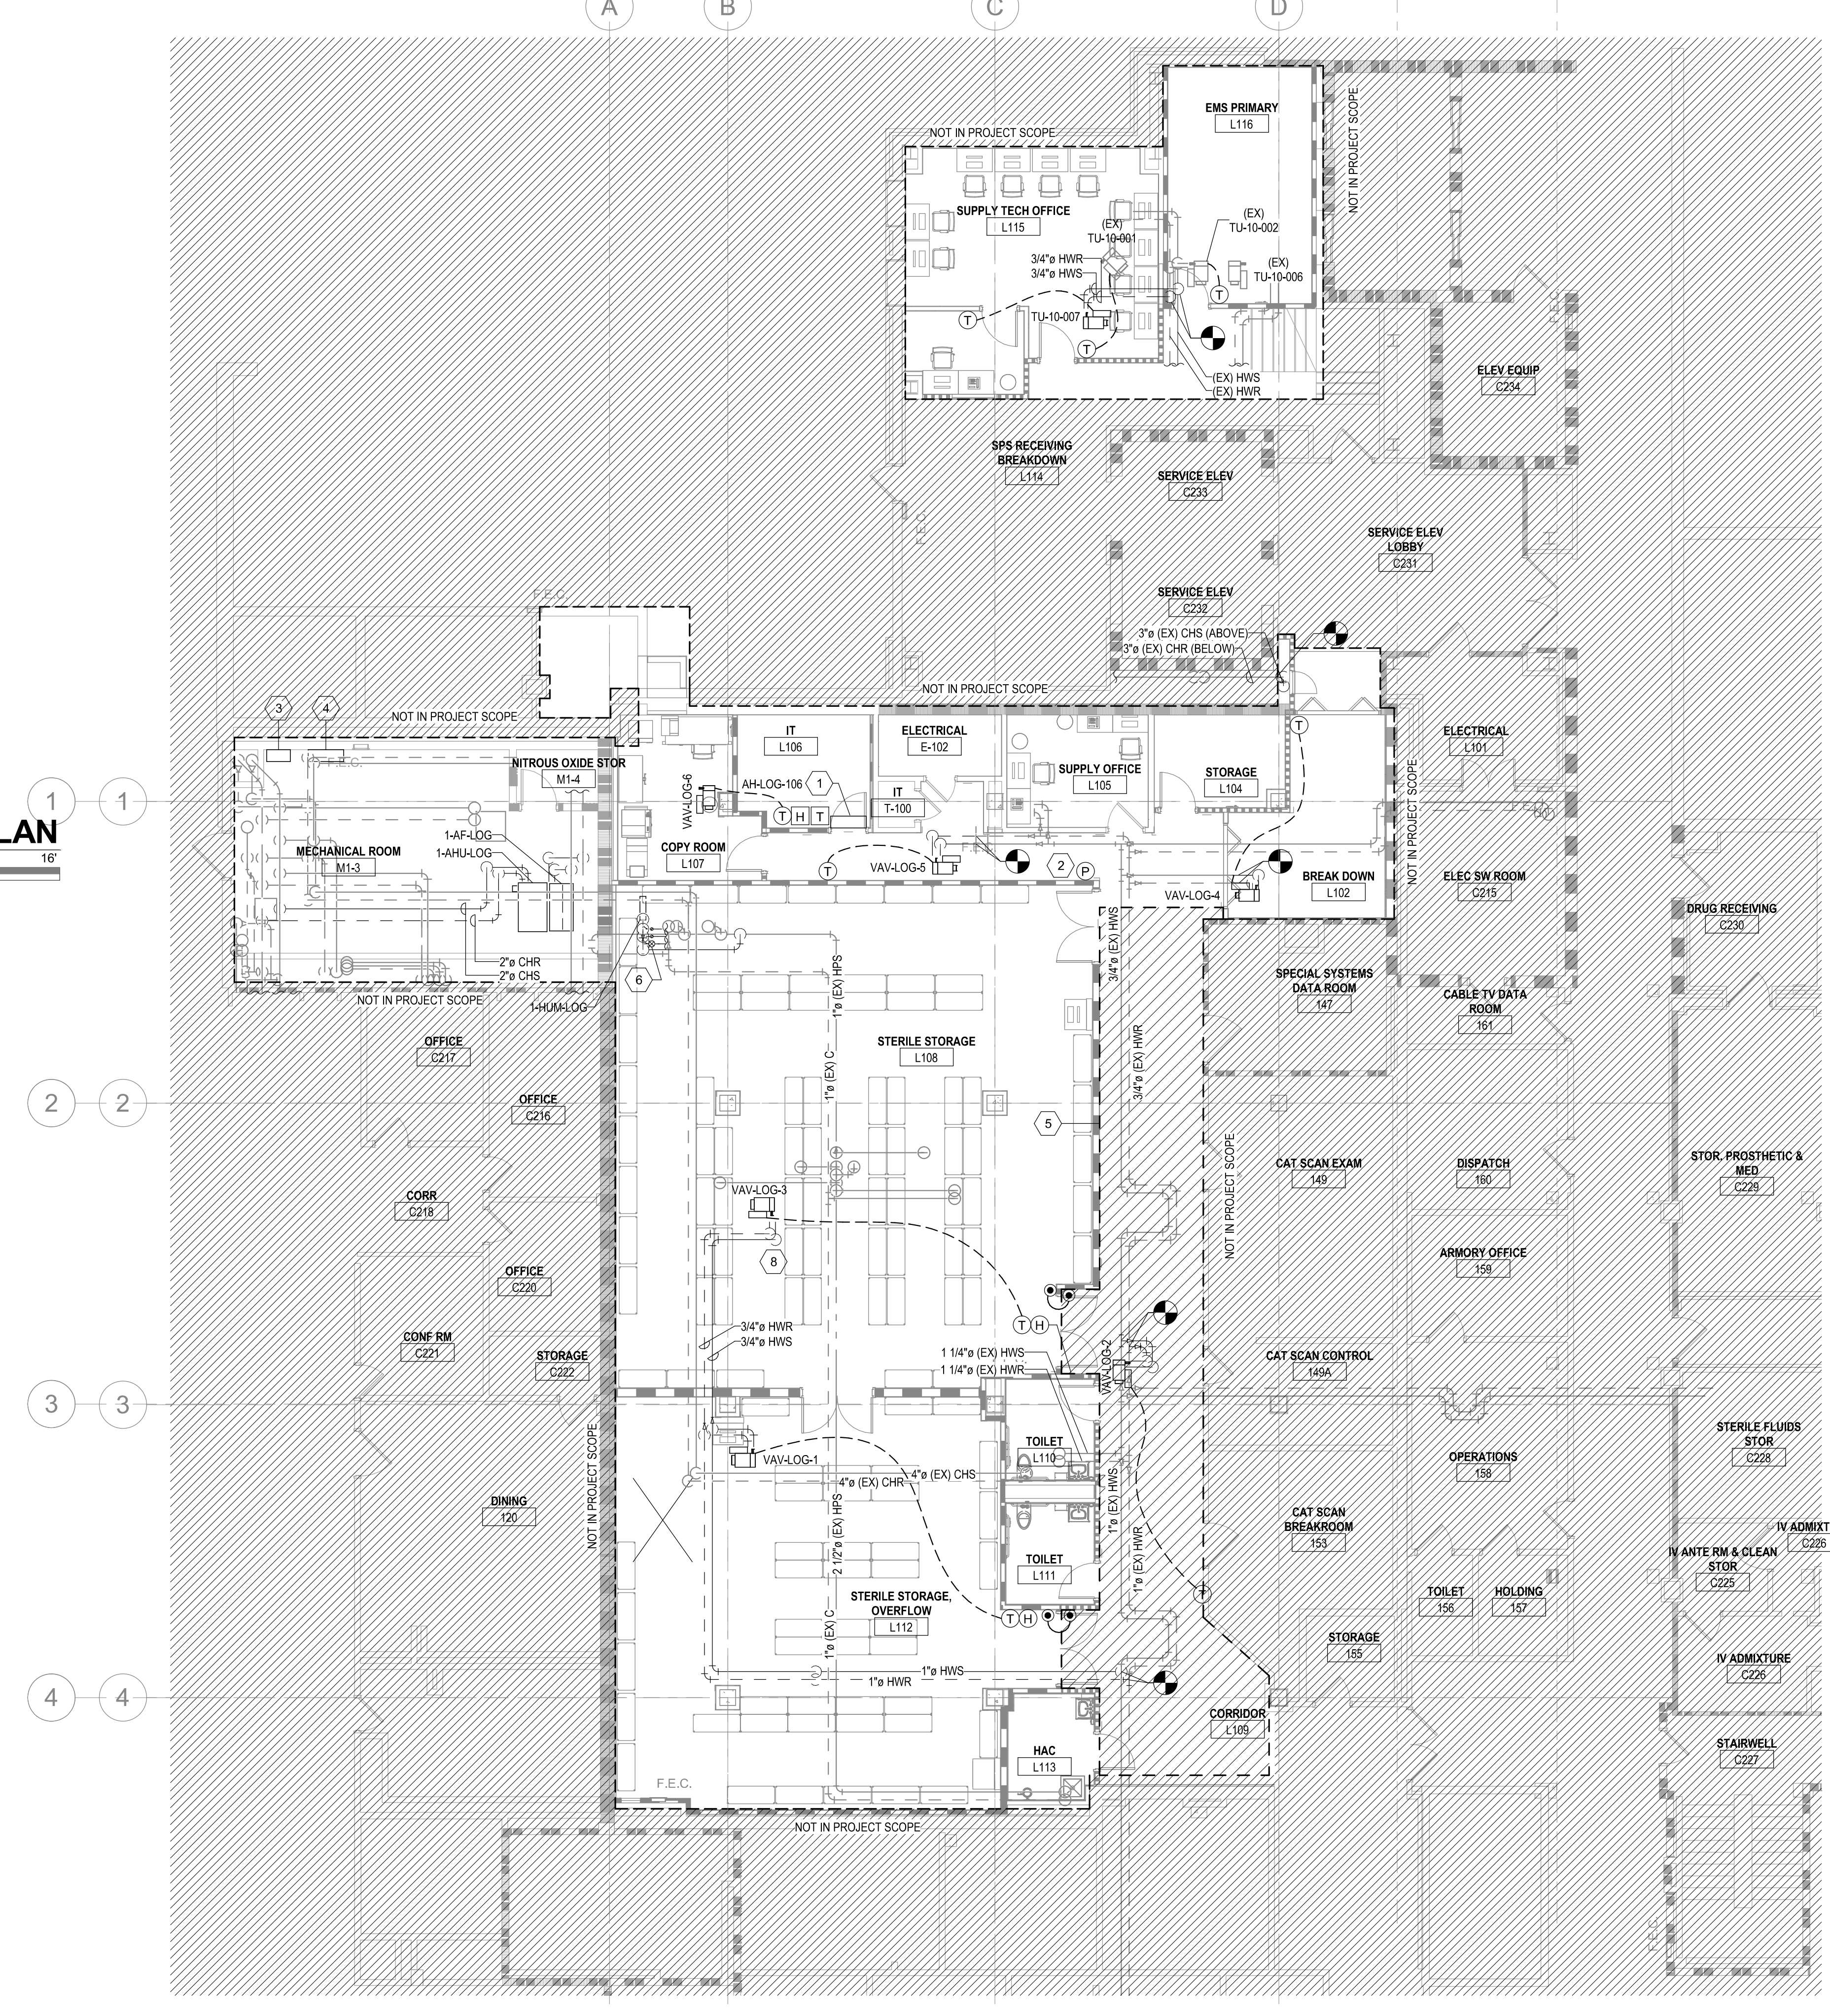

1 2 3 4 5 6 7 8 9 10

A

B

C

D

E

F

Revision Number	Revisions:	Date:

**CONSULTANTS**  
CONSULTING STRUCTURAL ENGINEERS

**ARCHITECT/ENGINEER OF RECORD**

A/E:  
HARRELL DESIGN GROUP PC  
10720 SIKES PLACE, SUITE 100  
CHARLOTTE, NC 28277  
704-814-1346  
POC: LEE HARRELL PE, LEED AP, QCCP  
PRESIDENT  
HDG PROJECT: 19022

**STAMP**

William G. Graney Jr.  
Charlotte, NC  
I am approving this document  
ograney@harrelldg.com  
2024.04.12  
13:44:36-0400

**DRAWING TITLE**  
BASEMENT AND FIRST FLOOR MECHANICAL PIPING PLANS

**APPROVED**

**PHASE**  
CONSTRUCTION DOCUMENTS SUBMISSION

**FULLY SPRINKLERED**

**PROJECT TITLE**  
RENOVATE SPACE FOR LOGISTICS (B-1)

**LOCATION**  
FAYETTEVILLE VA MEDICAL CENTER

**ISSUE DATE**  
11 APRIL 2024

**CHECKED**  
WGG

**DRAWN**  
ANB

**PROJECT NUMBER**  
564-24-104

**BUILDING NUMBER**  
1

**DRAWING NUMBER**  
MP101-A

**Engineering Service**  
VETERANS HEALTH CARE SYSTEM OF THE OZARKS  
U.S. Department of Veterans Affairs