


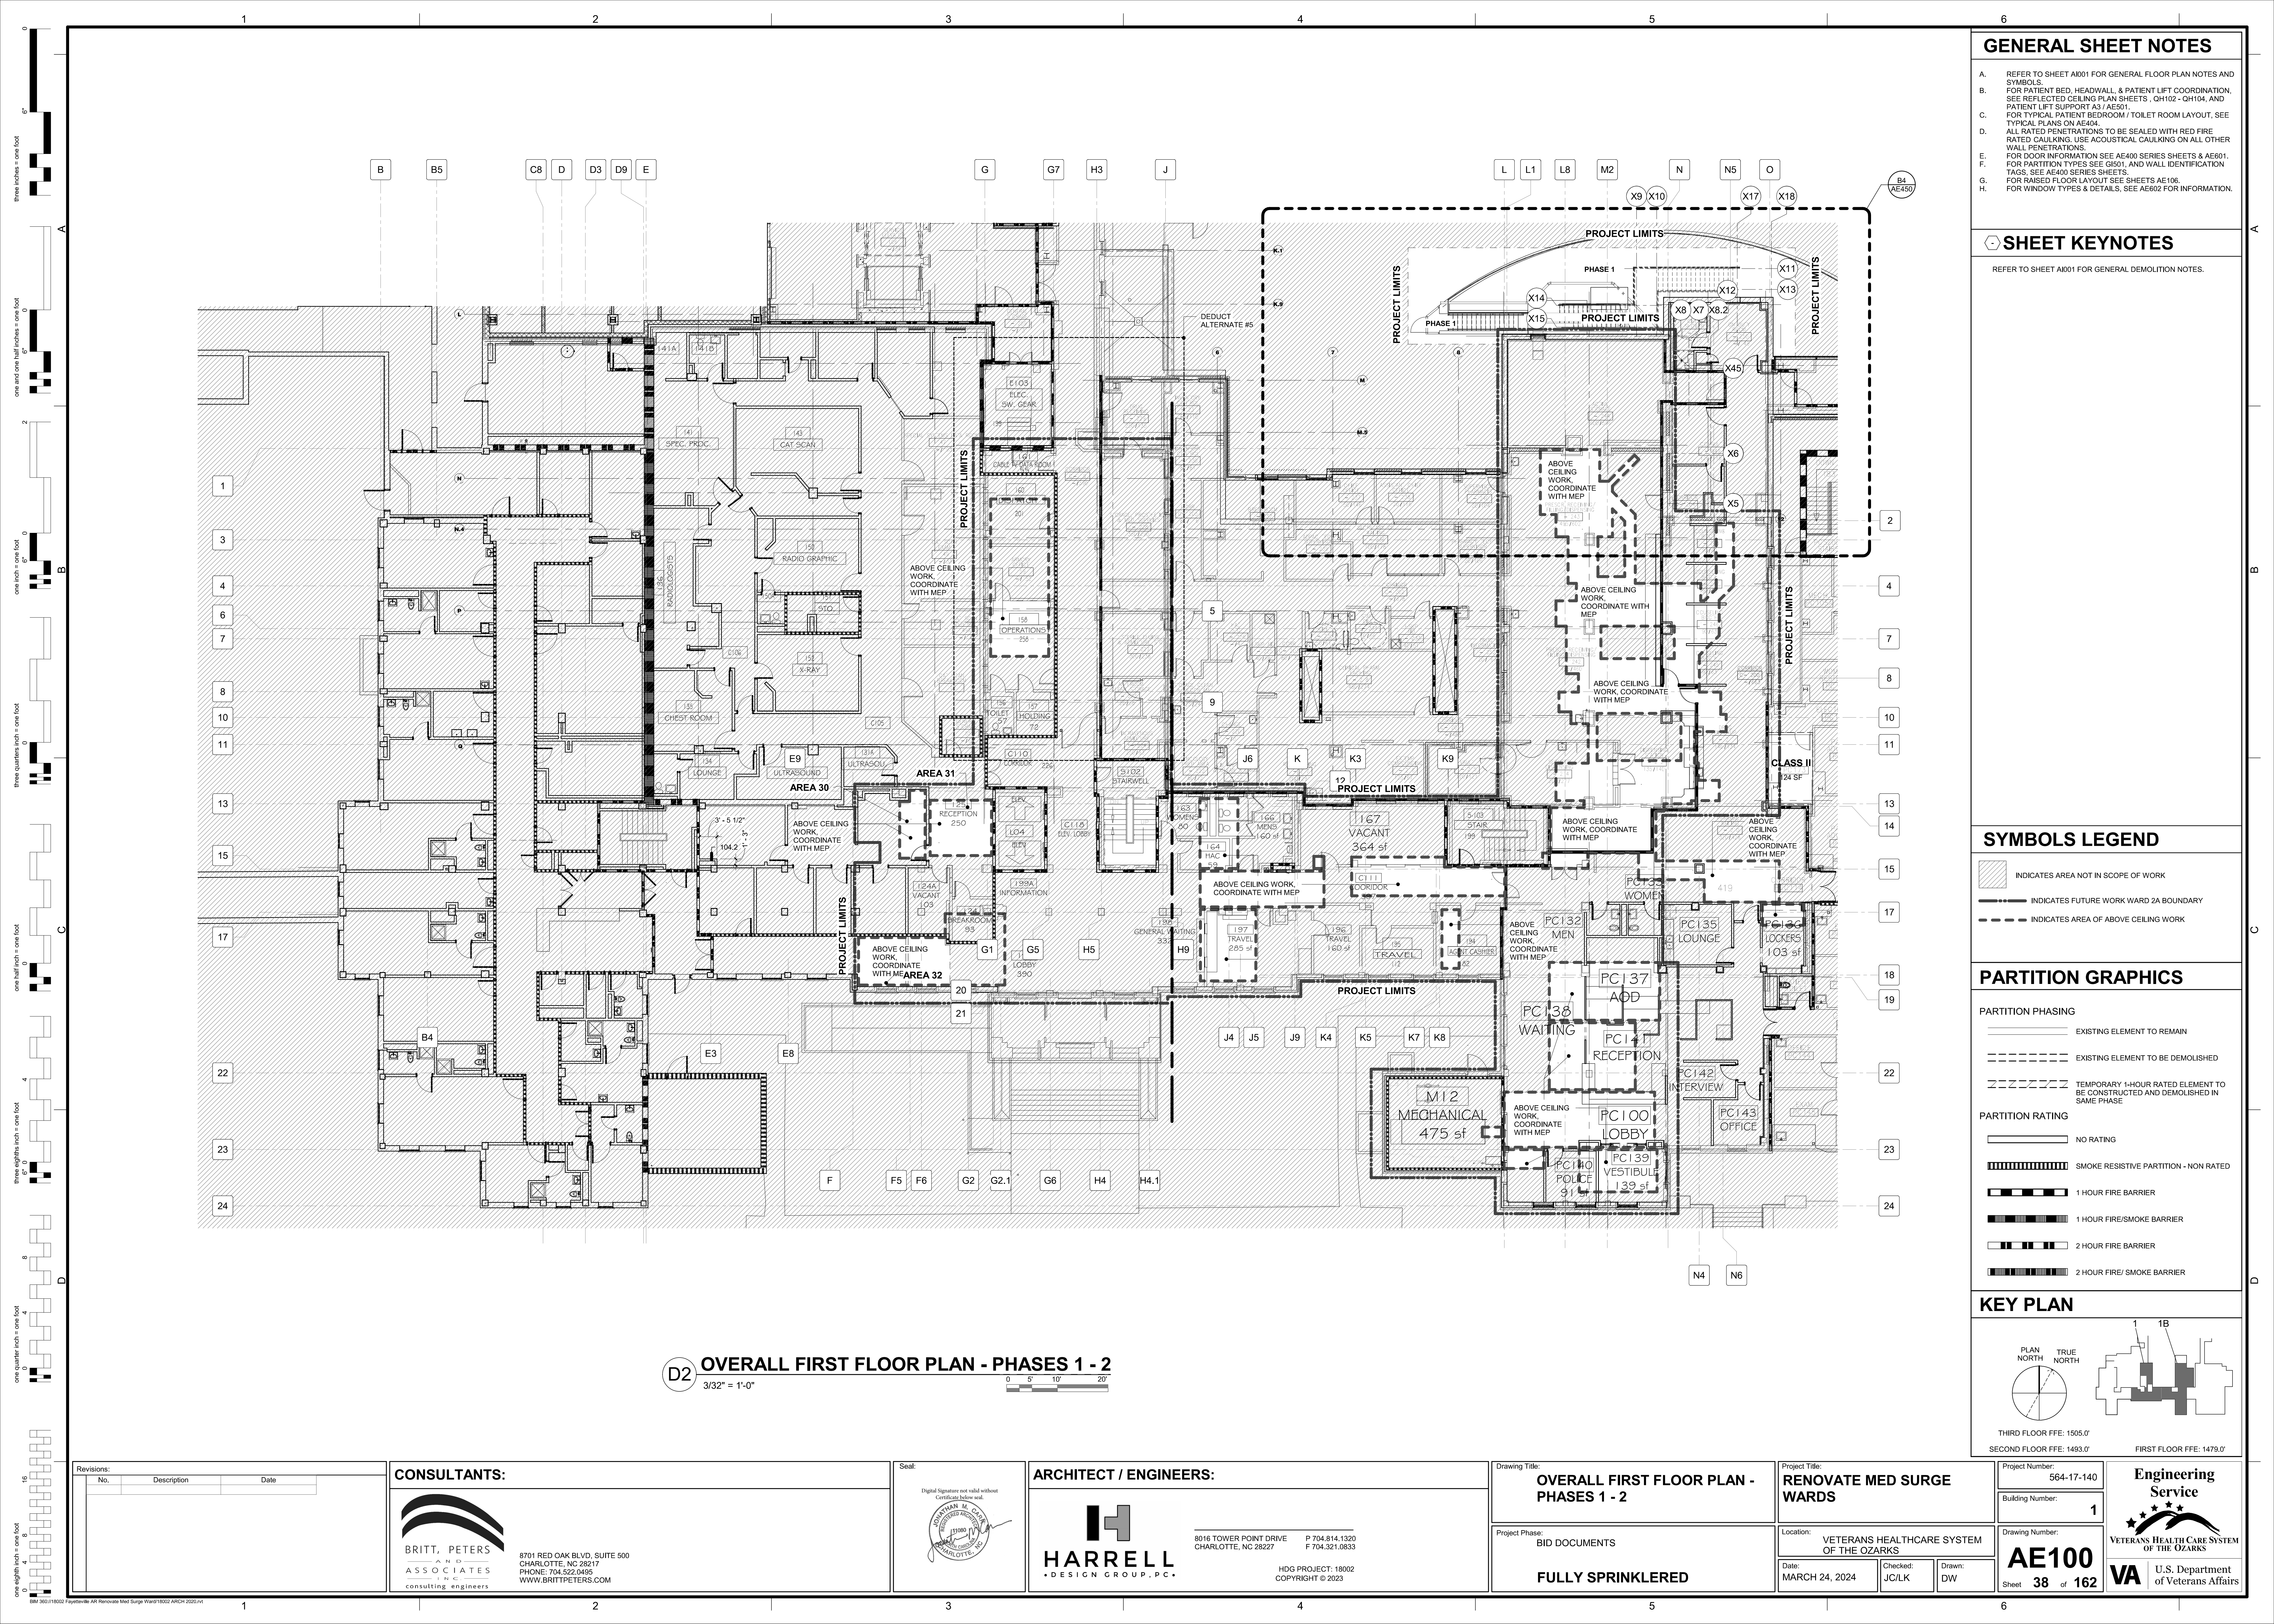

GENERAL SHEET NOTES

- A. REFER TO SHEET A001 FOR GENERAL FLOOR PLAN NOTES AND SYMBOLS.
- B. FOR PATIENT BED, HEADWALL, & PATIENT LIFT COORDINATION, SEE REFLECTED CEILING PLAN SHEETS, QH102 - QH104, AND PATIENT LIFT SUPPORT A3 / AE501.
- C. FOR TYPICAL PATIENT BEDROOM / TOILET ROOM LAYOUT, SEE TYPICAL PLANS ON AE04.
- D. ALL RATED PENETRATIONS TO BE SEALED WITH RED FIRE RATED CAULKING. USE ACOUSTICAL CAULKING ON ALL OTHER WALL PENETRATIONS.
- E. FOR DOOR INFORMATION SEE AE400 SERIES SHEETS & AE601.
- F. FOR PARTITION TYPES SEE G601, AND WALL IDENTIFICATION TAGS, SEE AE400 SERIES SHEETS.
- G. FOR RAISED FLOOR LAYOUT SEE SHEETS AE106.
- H. FOR WINDOW TYPES & DETAILS, SEE AE602 FOR INFORMATION.

SHEET KEYNOTES

REFER TO SHEET A001 FOR GENERAL DEMOLITION NOTES.

SYMBOLS LEGEND

- INDICATES AREA NOT IN SCOPE OF WORK
- INDICATES FUTURE WORK WARD 2A BOUNDARY
- INDICATES AREA OF ABOVE CEILING WORK

PARTITION GRAPHICS


PARTITION PHASING

- EXISTING ELEMENT TO REMAIN
- EXISTING ELEMENT TO BE DEMOLISHED
- TEMPORARY 1-HOUR RATED ELEMENT TO BE CONSTRUCTED AND DEMOLISHED IN SAME PHASE

PARTITION RATING

- NO RATING
- SMOKE RESISTIVE PARTITION - NON RATED
- 1 HOUR FIRE BARRIER
- 1 HOUR FIRE/SMOKE BARRIER
- 2 HOUR FIRE BARRIER
- 2 HOUR FIRE/ SMOKE BARRIER

KEY PLAN

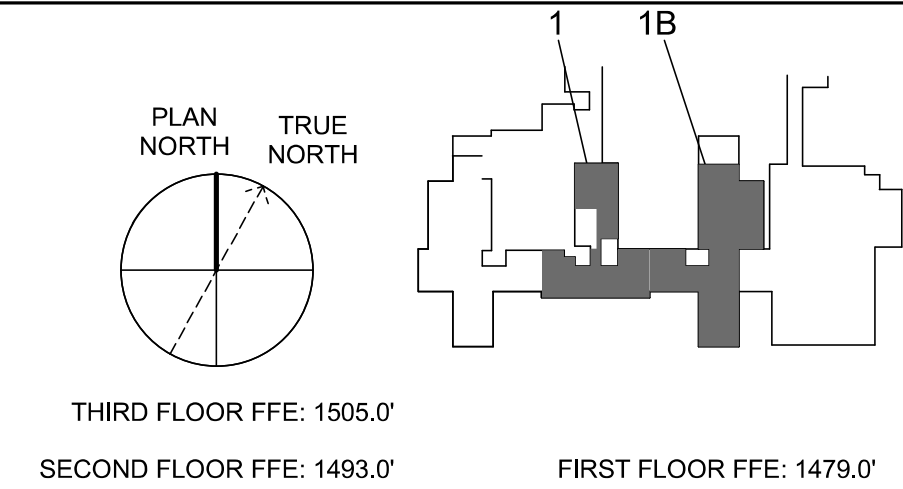


Revisions:		
No.	Description	Date

CONSULTANTS:

BRITT, PETERS AND ASSOCIATES
CONSULTING ENGINEERS
8701 RED OAK BLVD, SUITE 500
CHARLOTTE, NC 28217
PHONE: 704.522.0405
WWW.BRITTPETERS.COM

Seal:

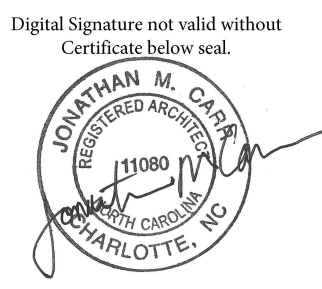

ARCHITECT / ENGINEERS:

HARRELL DESIGN GROUP, P.C.
8016 TOWER POINT DRIVE
CHARLOTTE, NC 28227
P 704.814.1320
F 704.321.0833
HDG PROJECT: 18002
COPYRIGHT © 2023

Drawing Title:

OVERALL FIRST FLOOR PLAN - PHASES 1 - 2

Project Phase:

BID DOCUMENTS

FULLY SPRINKLERED

Project Title:

RENOVATE MED SURGE WARDS

Location:

VETERANS HEALTHCARE SYSTEM OF THE OZARKS

Date:

MARCH 24, 2024

Checked:

JC/LK

Drawn:

DW

Project Number:

564-17-140

Building Number:

1

Drawing Number:

AE100

Sheet 38 of 162

Engineering Service



VA U.S. Department of Veterans Affairs