


Scale bars and graphical representations for various dimensions:


- 0 to 8 feet
- 0 to 2 feet
- 0 to 1 foot
- 0 to 6 inches
- 0 to 4 inches
- 0 to 2 inches
- 0 to 1 inch
- 0 to 1/2 inch
- 0 to 1/4 inch
- 0 to 1/8 inch
- 0 to 1/16 inch

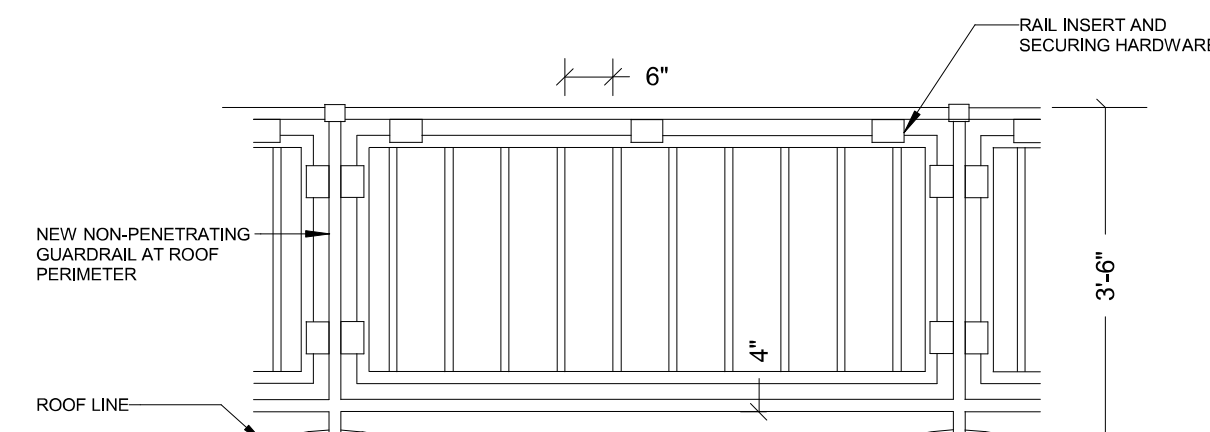

NON-PENETRATING GUARDRAIL ELEVATION, TYPICAL

A5

1/2" = 1'-0"

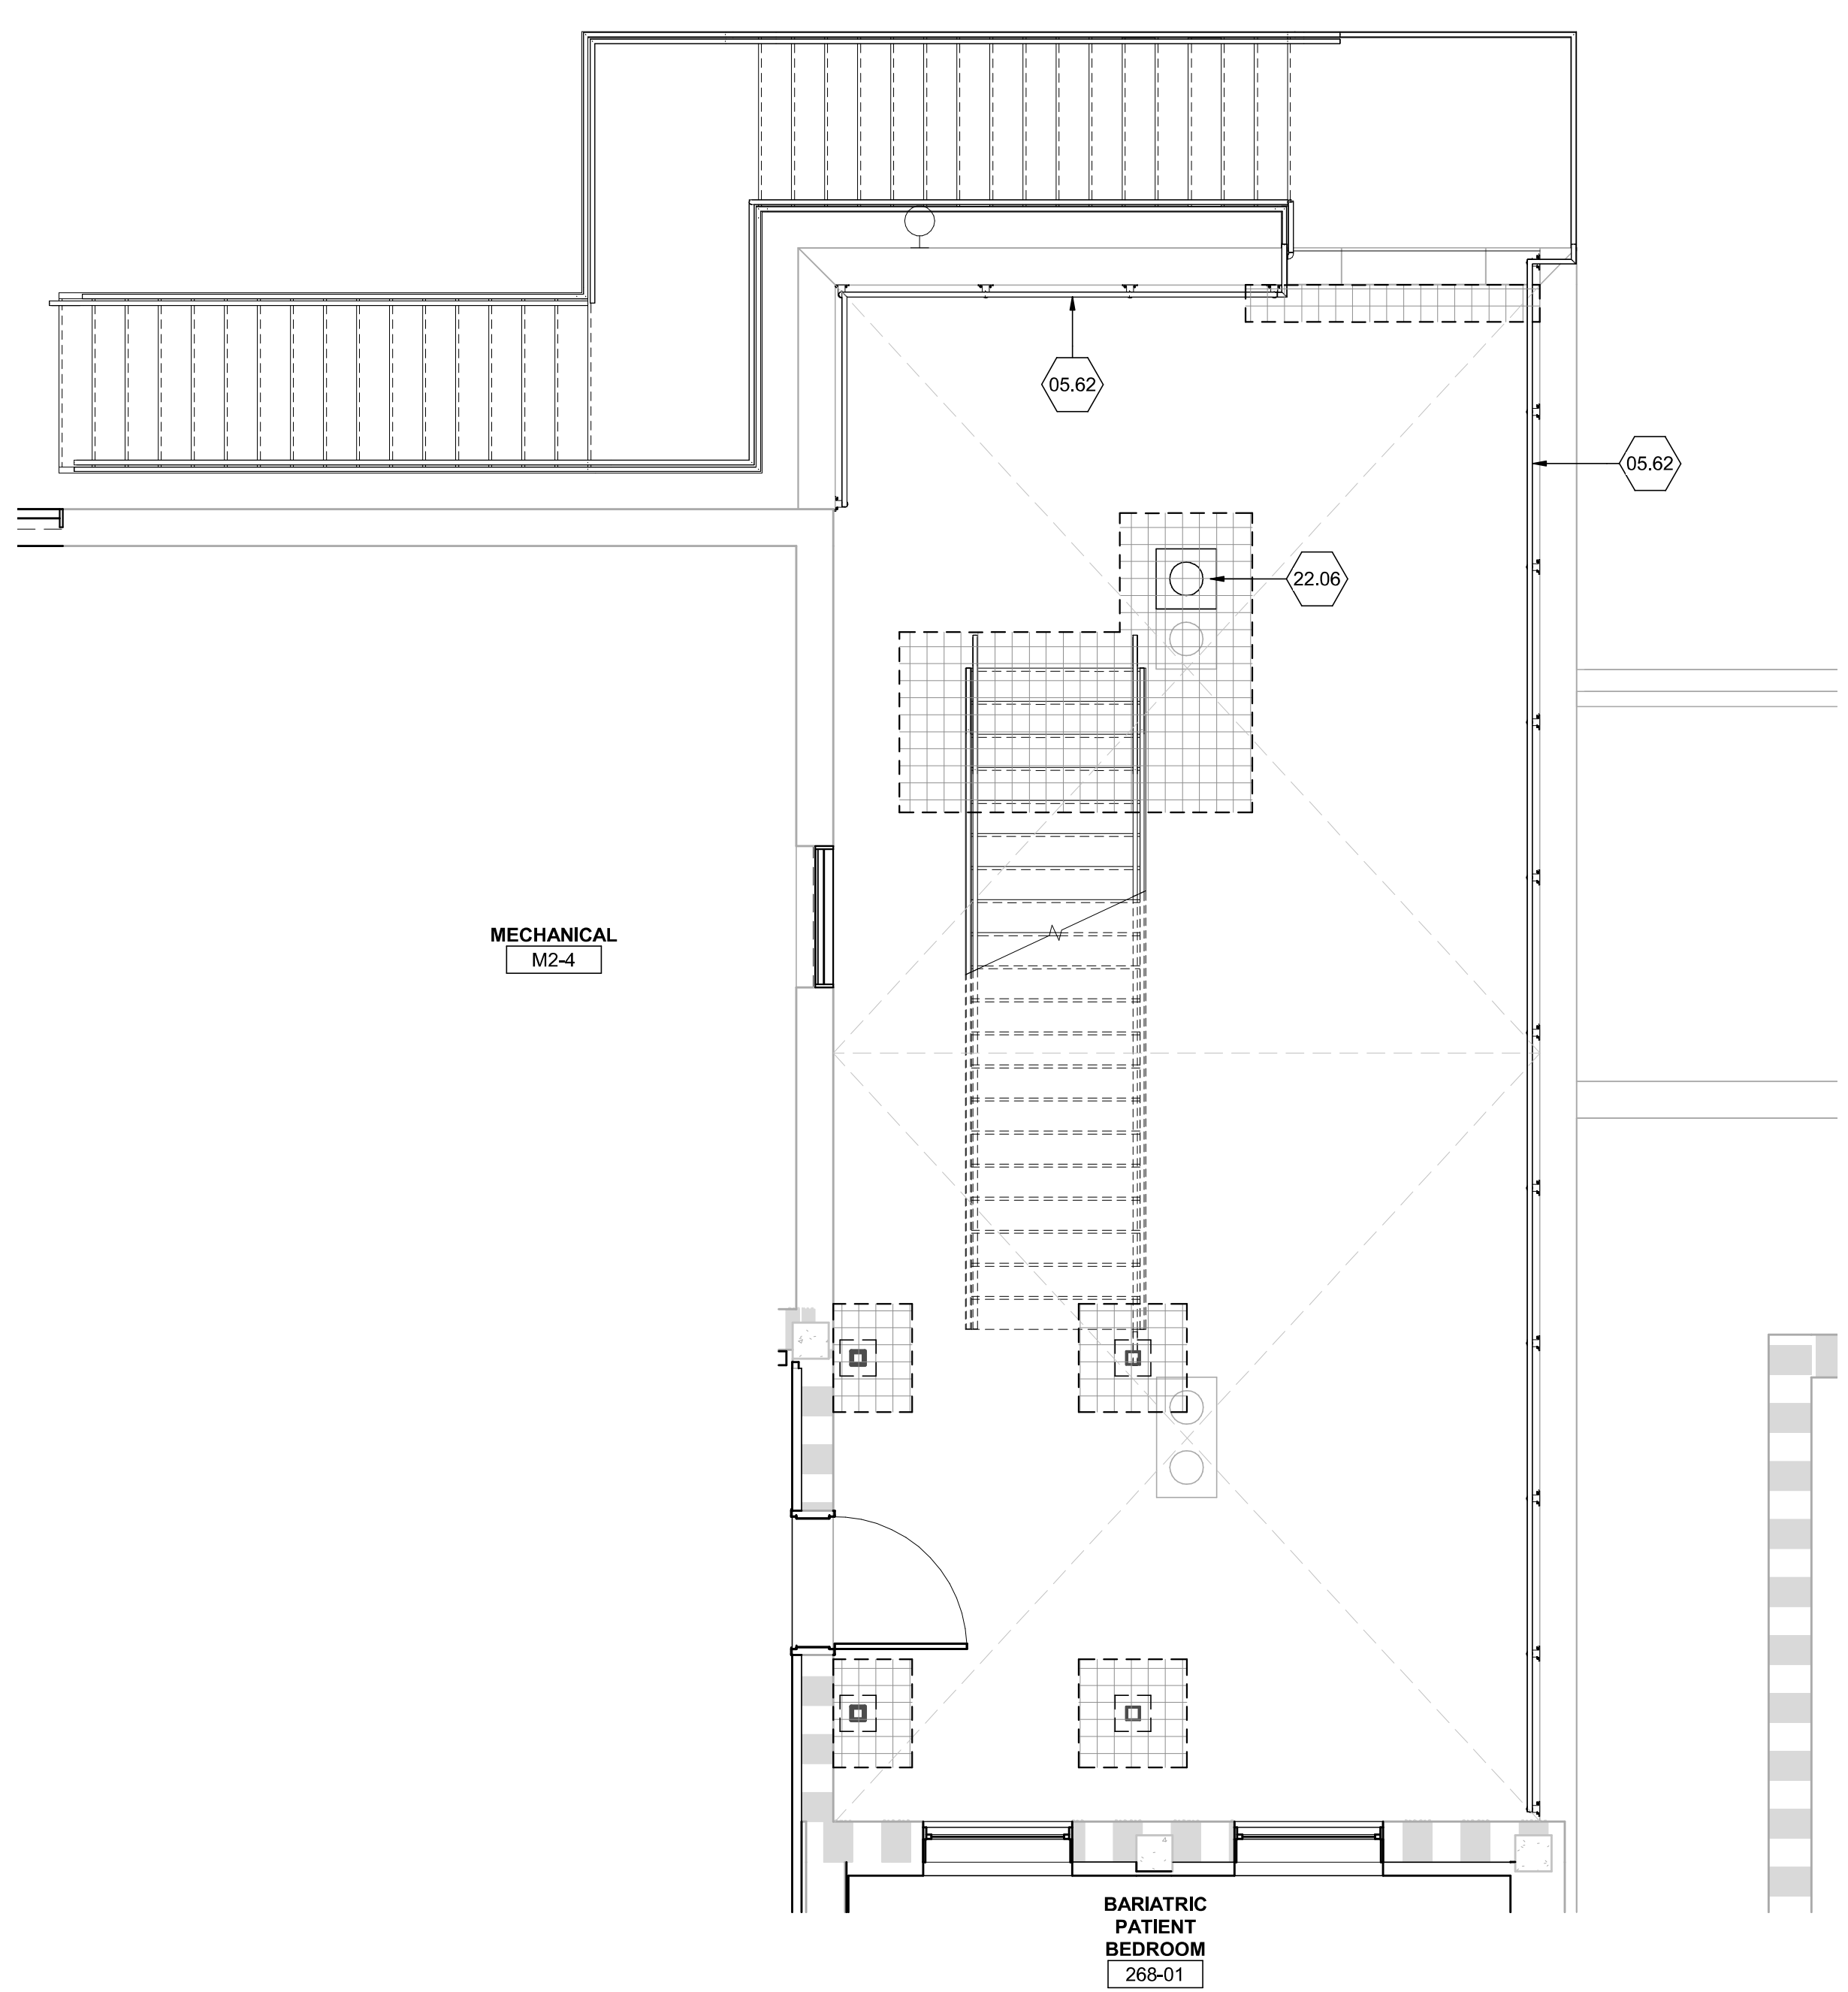

D5 RE-ROOF PLAN - EXTERIOR STAIR EAST SECOND FLOOR

1/4" = 1'-0"

GENERAL SHEET NOTES

A. REFER TO STRUCTURAL DRAWINGS AND SPECIFICATIONS FOR STAIR DETAILS AND CONNECTIONS.

SHEET KEYNOTES

05.62 NEW NON-PENETRATING GUARDRAIL AT ROOF PERIMETER. BASIS OF DESIGN: KEEGUARD PERMANENT RAIL. TIE INTO EXISTING LIGHTNING PROTECTION SYSTEM.
22.06 USE NEW ROOF DRAIN AND ROOF LEADER CONNECTING TO EXISTING PIPING. SEE PLUMBING DRAWINGS FOR INFORMATION. GC SHALL MAINTAIN ROOF SLOPE TO DRAINS.

SYMBOLS LEGEND

- ROOF WALKWAY PATH
- RE-ROOF CUT OPENING EXTENTS, SEE DETAILS FOR INFORMATION. RE-ROOF WITH COMPATIBLE ROOFING IN ACCORDANCE WITH MANUFACTURERS RECOMMENDATIONS.

PARTITION GRAPHICS

PARTITION PHASING

- EXISTING ELEMENT TO REMAIN
- EXISTING ELEMENT TO BE DEMOLISHED
- TEMPORARY 1-HOUR RATED ELEMENT TO BE CONSTRUCTED AND DEMOLISHED IN SAME PHASE

PARTITION RATING

- NO RATING
- SMOKE RESISTIVE PARTITION - NON RATED
- 1 HOUR FIRE BARRIER
- 1 HOUR FIRE/SMOKE BARRIER
- 2 HOUR FIRE BARRIER
- 2 HOUR FIRE/ SMOKE BARRIER

KEY PLAN

PLAN NORTH, TRUE NORTH

THIRD FLOOR FFE: 1505.0'
SECOND FLOOR FFE: 1493.0'
FIRST FLOOR FFE: 1479.0'

Engineering Service

VETERANS HEALTH CARE SYSTEM OF THE OZARKS

VA U.S. Department of Veterans Affairs

Revisions:		
No.	Description	Date

CONSULTANTS:

BRITT, PETERS AND ASSOCIATES
CONSULTING ENGINEERS

8701 RED OAK BLVD, SUITE 500
CHARLOTTE, NC 28217
PHONE: 704.522.0405
WWW.BRITTPETERS.COM

Seal:

ARCHITECT / ENGINEERS:

HARRELL
DESIGN GROUP, P.C.

8016 TOWER POINT DRIVE
CHARLOTTE, NC 28227

P 704.814.1320
F 704.321.0833

HG PROJECT: 18002
COPYRIGHT © 2023

Drawing Title:

PARTIAL ROOF PLANS

Project Phase:

BID DOCUMENTS

FULLY SPRINKLERED

Project Title:

RENOVATE MED SURGE WARDS

Location:

VETERANS HEALTHCARE SYSTEM OF THE OZARKS

Date:

MARCH 24, 2024

Checked:

JC/LK

Drawn:

DW

Project Number:

564-17-140

Building Number:

1

Drawing Number:

AE130

Sheet 48 of 162