




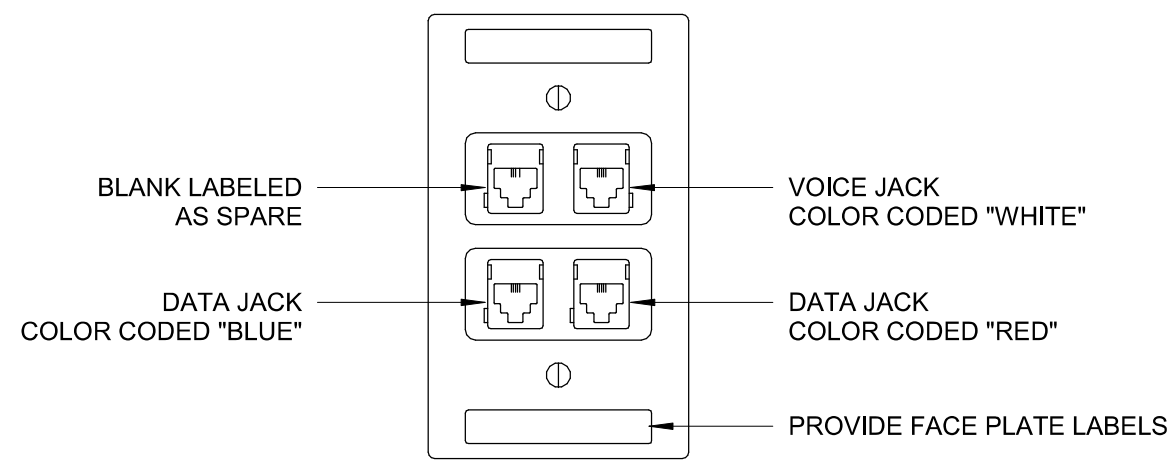

NOTE:
EACH COMBINATION VOICE / DATA OUTLET SHALL HAVE THE FOLLOWING: ONE BLANK LABELED AS SPARE MOUNTED IN TOP LEFT OF FACE PLATE. ONE VOICE 4-PAIR WHITE PLENUM CAT 6 CABLES ON WHITE RJ-45 JACKS MOUNTED IN TOP RIGHT OF FACE PLATE. ONE DATA 4-PAIR RED PLENUM CAT 6 CABLE ON RED RJ-45 JACK MOUNTED IN THE BOTTOM RIGHT OF FACE PLATE. ONE DATA 4-PAIR BLUE PLENUM CAT 6 CABLE ON BLACK RJ-45 JACK MOUNTED IN BOTTOM LEFT OF FACEPLATE. FACE PLATES SHALL BE STAINLESS STEEL WITH COPPER ANTI-MICROBIAL FINISH. CABLES SHALL BE TERMINATED PER T568B. BACKBOXES SHALL BE 4-11/16"x2-1/8". COORDINATE FACEPLATES REQUIREMENTS WITH LOCAL STATION IT SERVICE PRIOR TO SUBMITTING SHOP DRAWINGS AND SUBMITTALS.

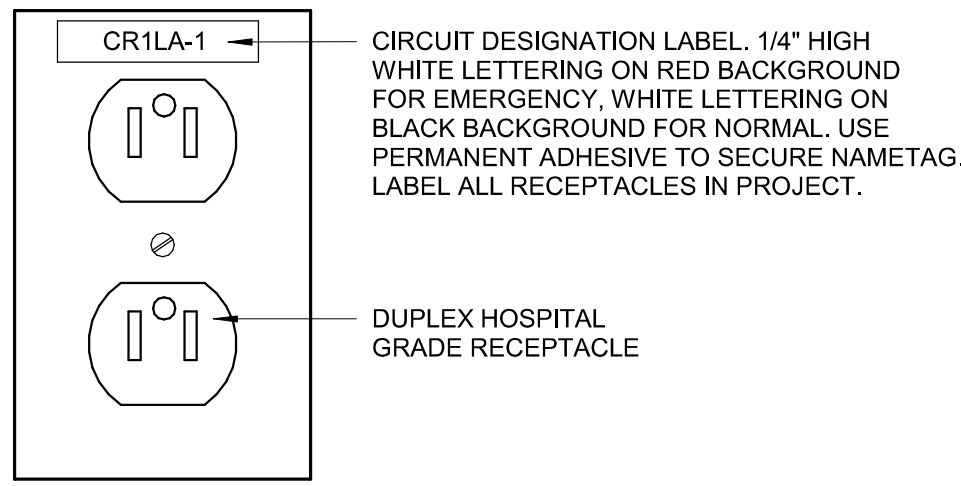


NOTE:
ALL RECEPTACLES WHETHER DUPLEX OR QUADRAPLEX OR ANY OTHER NEMA CONFIGURATION SHALL BE LABELED.

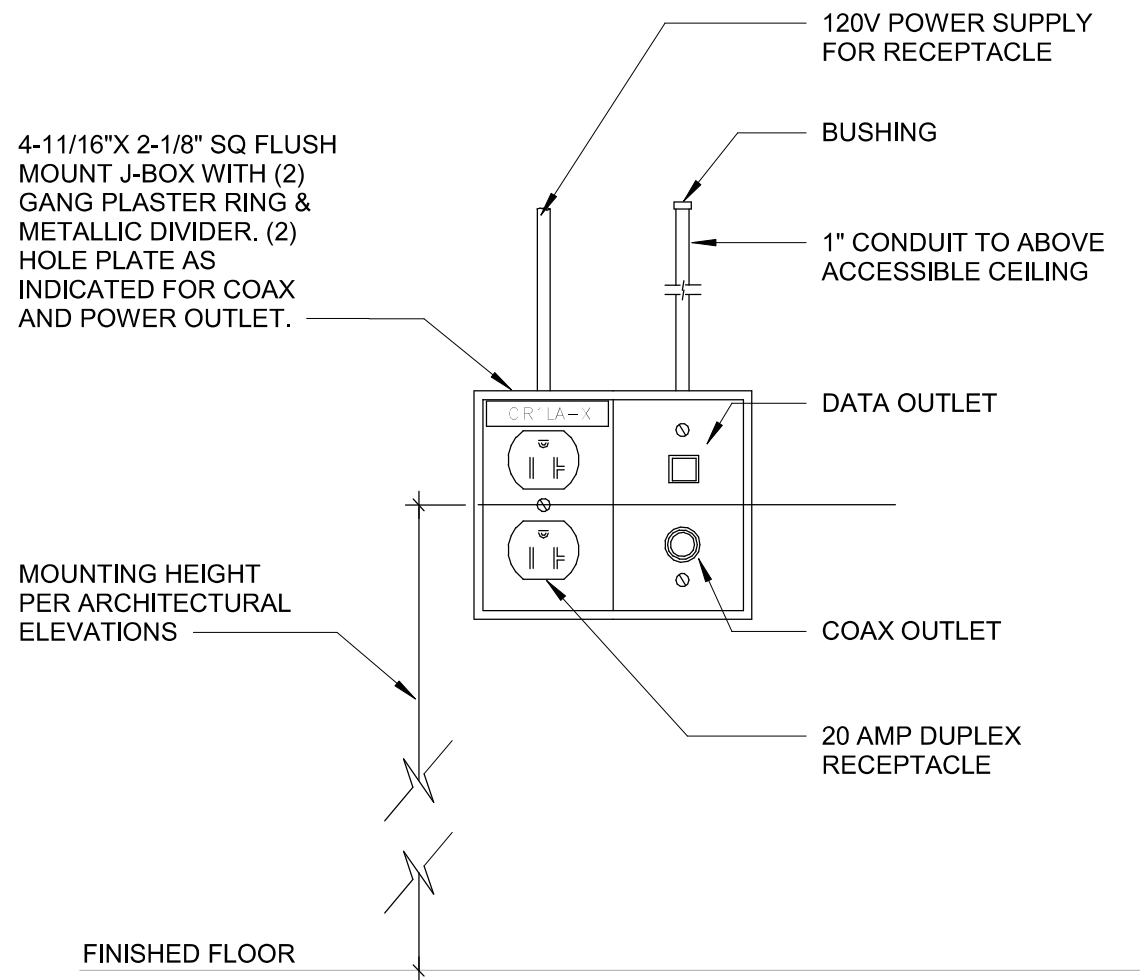


A1 TYPICAL VOICE/DATA OUTLET DIAGRAM
NO SCALE

A3 TYPICAL RECEPTACLE NAMEPLATE
NO SCALE


A5 POWER/TV OUTLET
NO SCALE

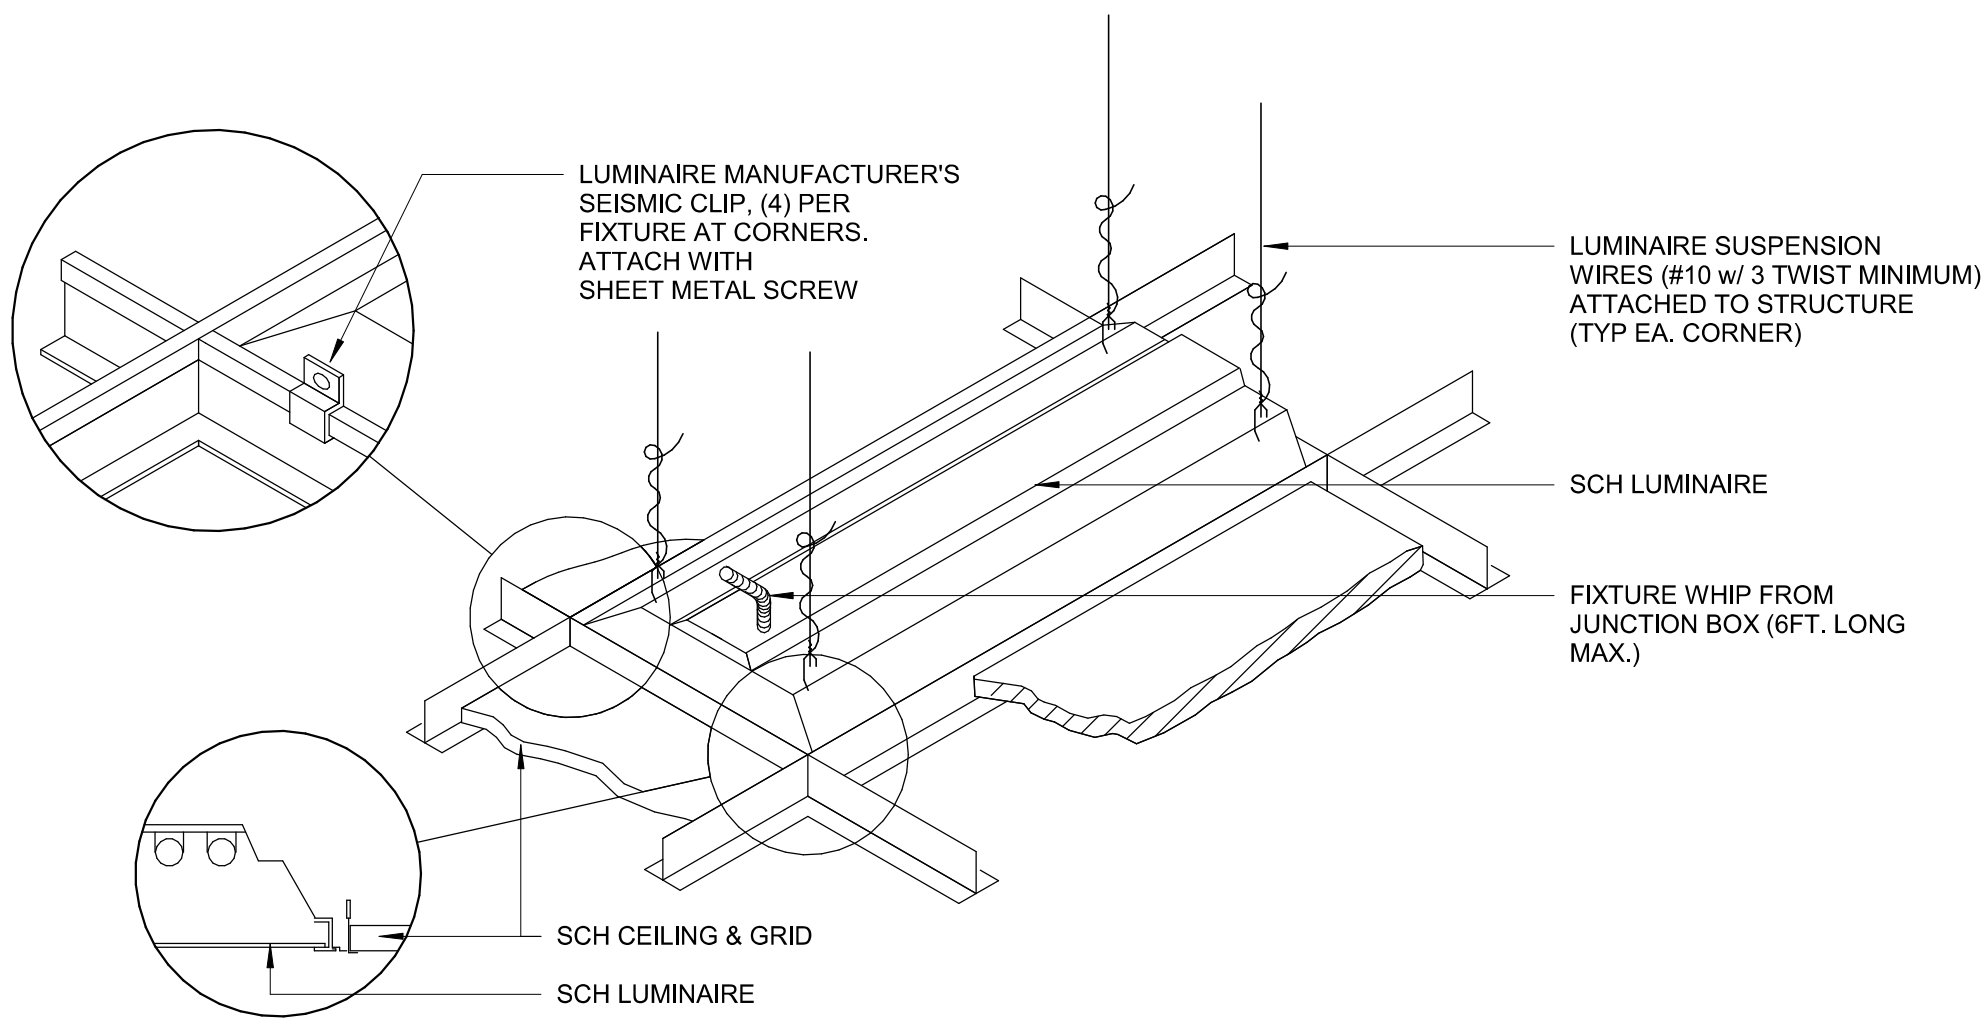

C1 LUMINAIRE MOUNTING - LAY-IN CEILING
NO SCALE

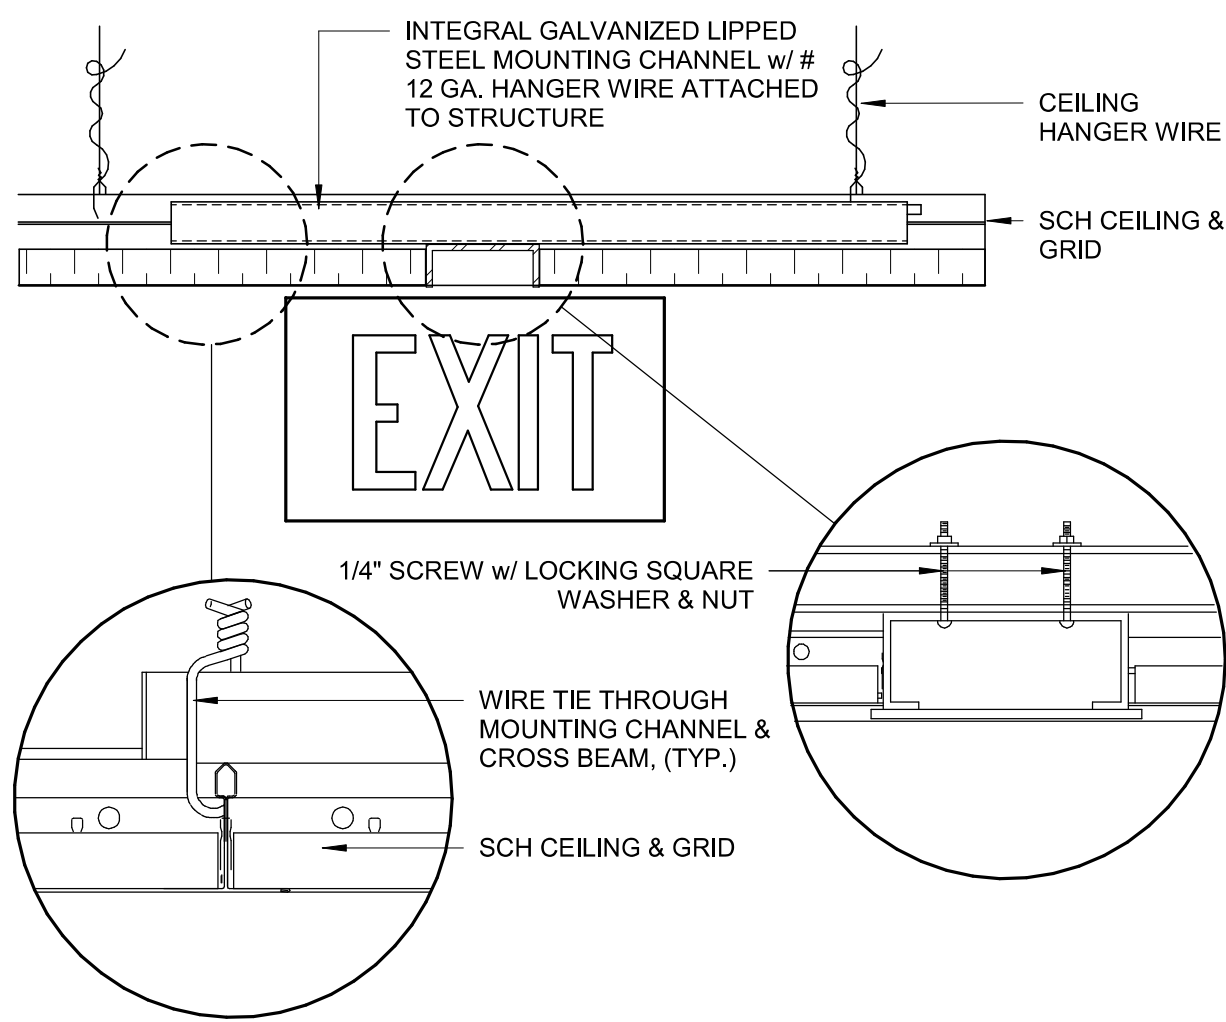

D1 EXIT SIGN MOUNTING - LAY-IN CEILING
NO SCALE

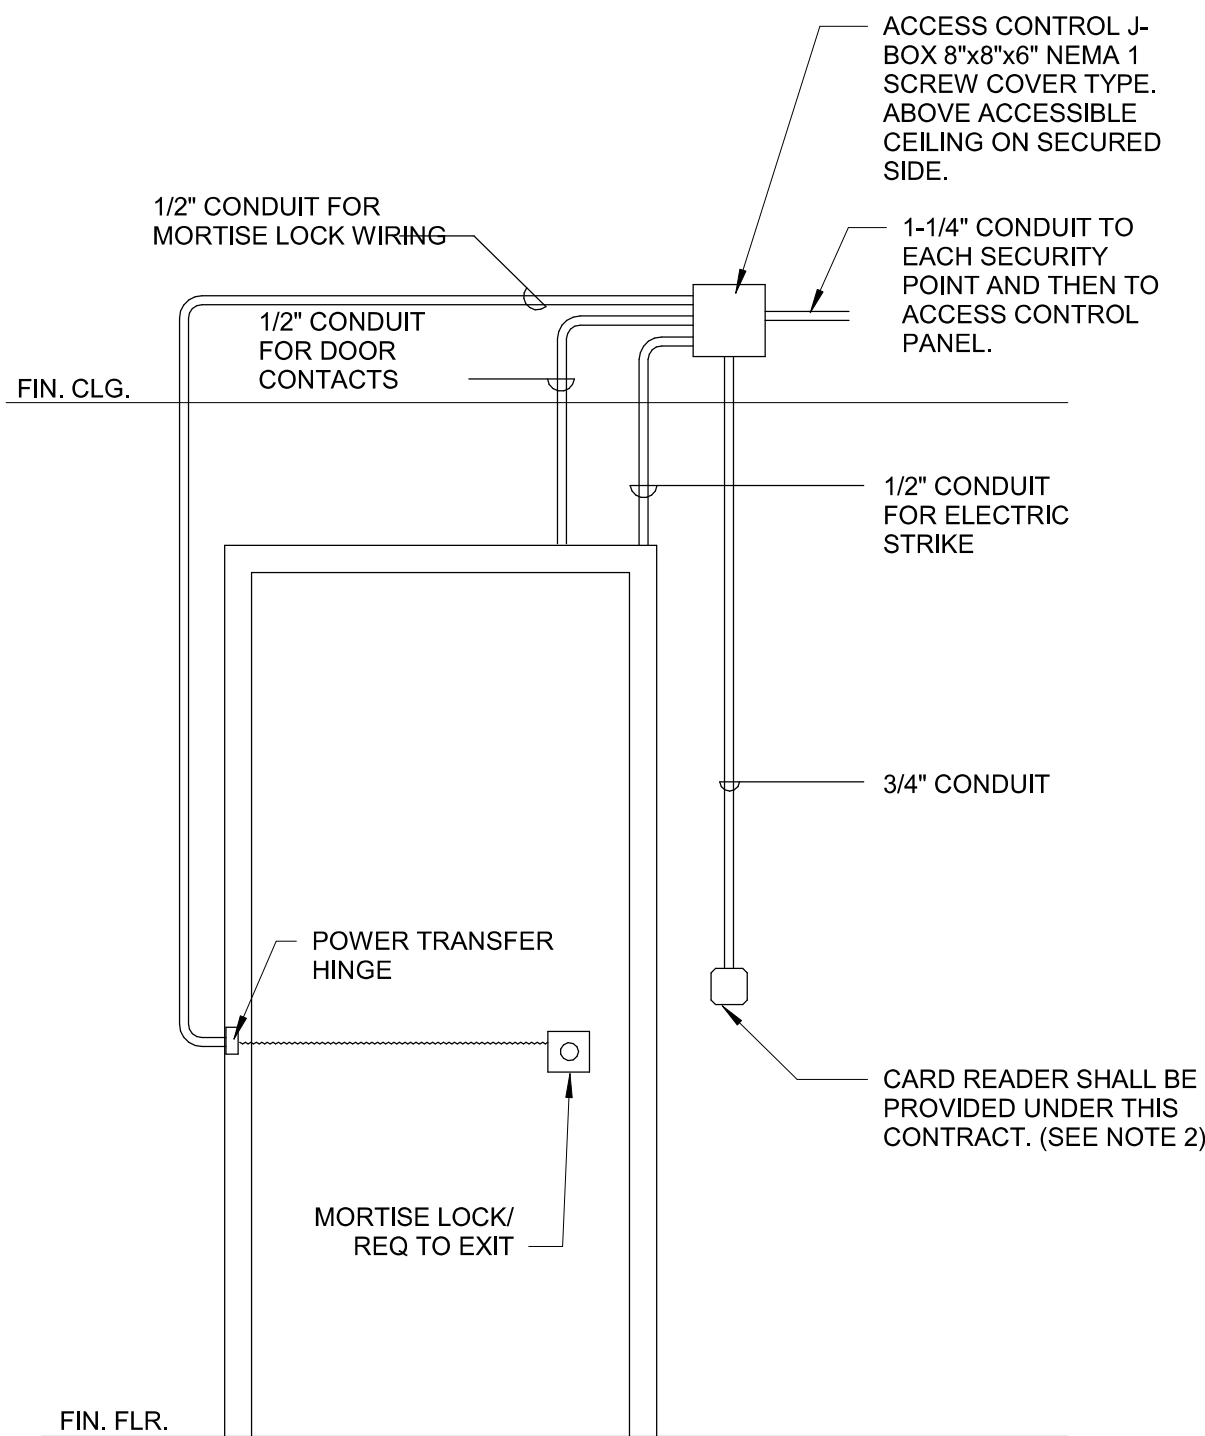

NOTES:
1. FIRE ALARM CONTRACTOR SHALL PROVIDE ONE CONTROL RELAY PER DOOR SECURITY SYSTEM CONTROL PANEL TO INITIATE DELAYED EGRESS IN THE EVENT OF AN ALARM.
2. CARD READERS SHALL BE PROVIDED WITH AND INSTALLED ON BACKBOX BY SAME MANUFACTURER.

D3 PACS TYPICAL DOOR CONDUIT DETAIL
NO SCALE


Revisions:		
No.	Description	Date

CONSULTANTS:



BRITT, PETERS
AND
ASSOCIATES
INC.
consulting engineers
8701 RED OAK BLVD, SUITE 500
CHARLOTTE, NC 28217
PHONE: 704.522.0405
WWW.BRITTPETERS.COM

Digital Signature not valid without Certificate below seal.

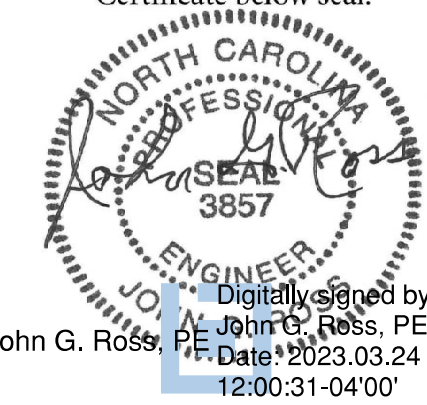

ARCHITECT / ENGINEERS:



8016 TOWER POINT DRIVE
CHARLOTTE, NC 28227
P 704.814.1320
F 704.321.0833
Hdg PROJECT: 18002
COPYRIGHT © 2021

Drawing Title:
ELECTRICAL DETAILS

Project Phase:
BID DOCUMENTS

FULLY SPRINKLERED

Project Title:
**RENOVATE MED SURGE
WARDS**

Location:
VETERANS HEALTHCARE SYSTEM
OF THE OZARKS

Date:
MARCH 24, 2024

Checked:
LEH

Drawn:
CSR

Project Number:
564-17-140

Building Number:
1

Drawing Number:

EE501
Sheet **156** of **162**

**Engineering
Service**



VA U.S. Department
of Veterans Affairs