

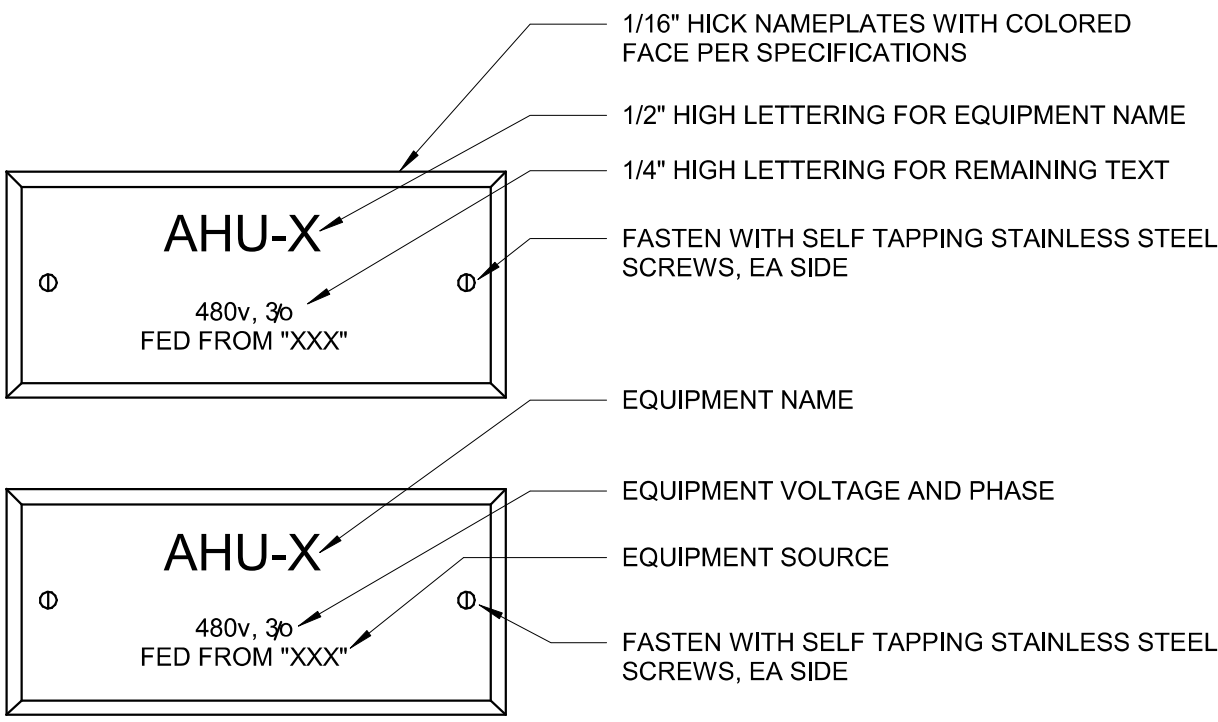
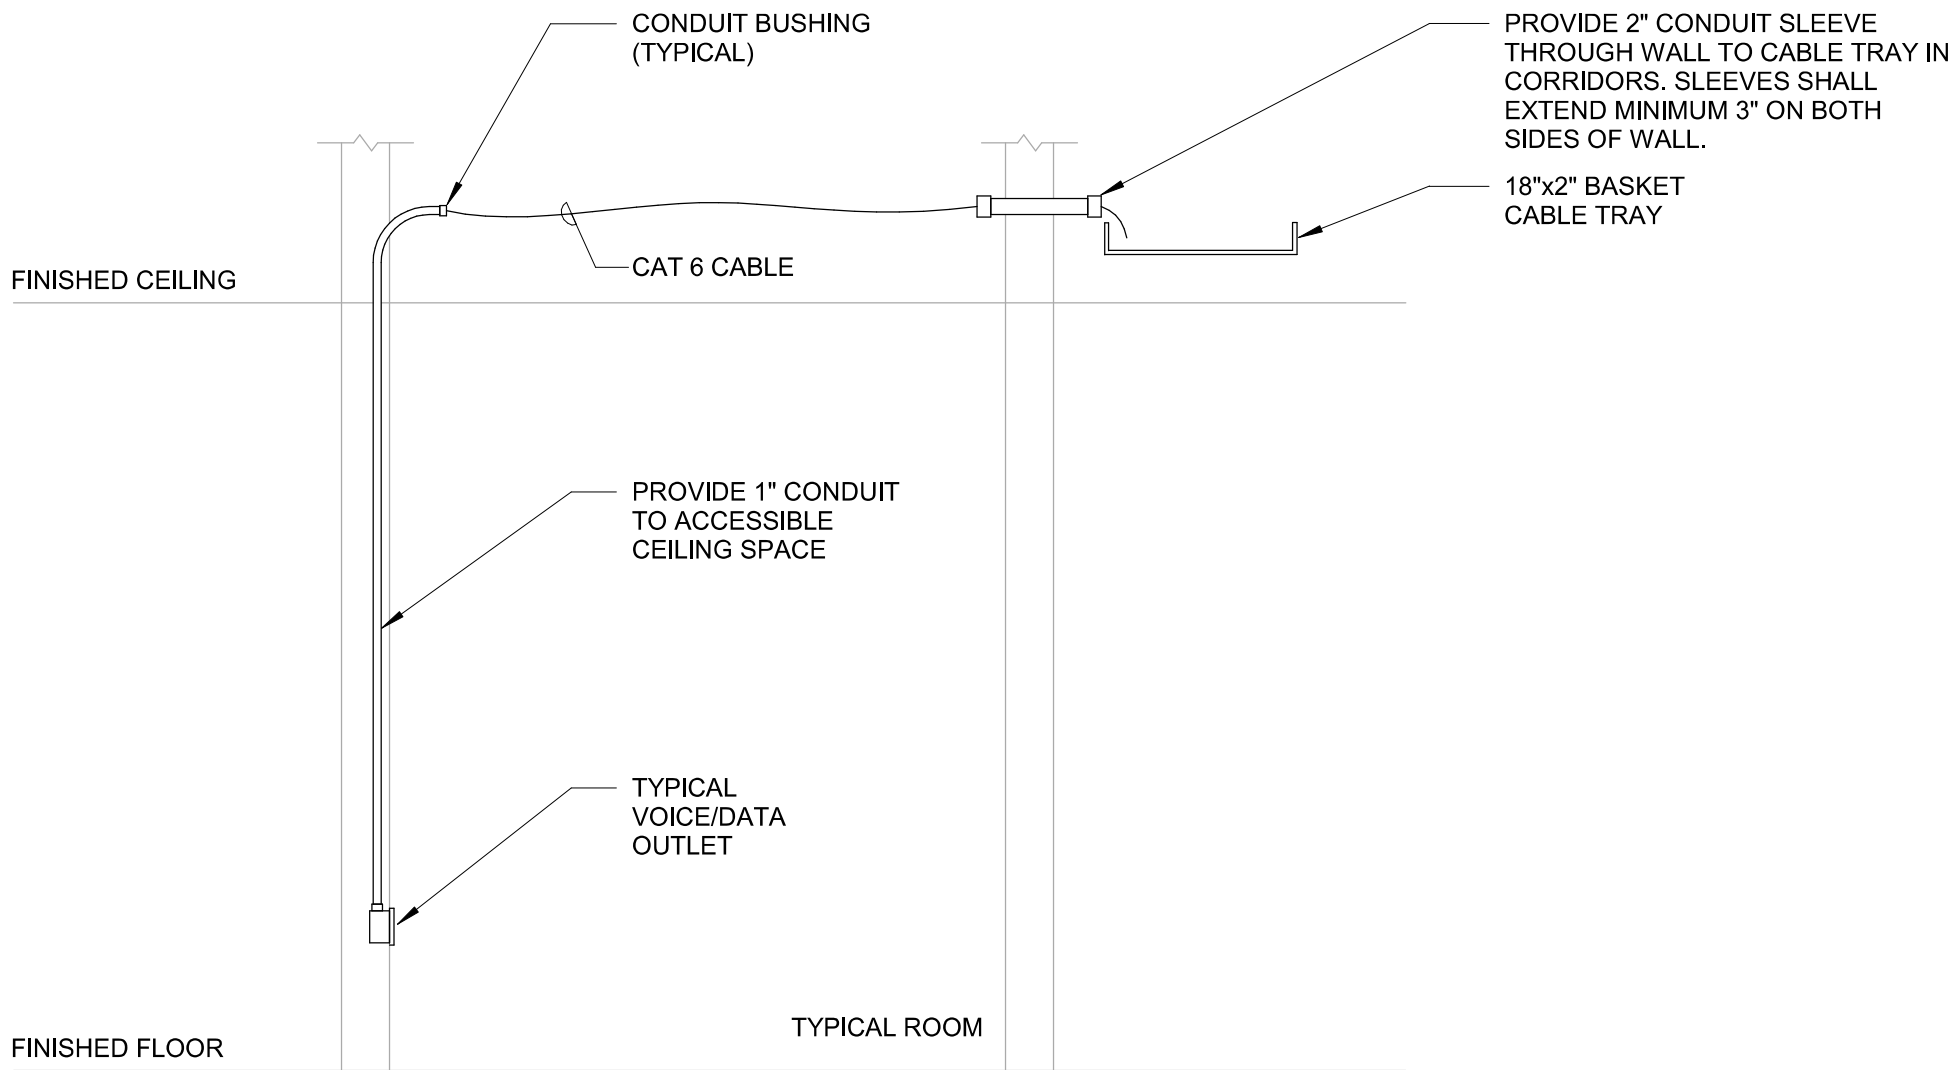




- NOTES:
- THE MAXIMUM NUMBER OF DATA CABLES IN A CONDUIT SLEEVE SHALL NOT EXCEED 40% FILL.
 - 12 STRAND SINGLE MODE FIBER OPTIC CABLE TO MAIN SYSTEMS ROOM 147A ON FIRST FLOOR.

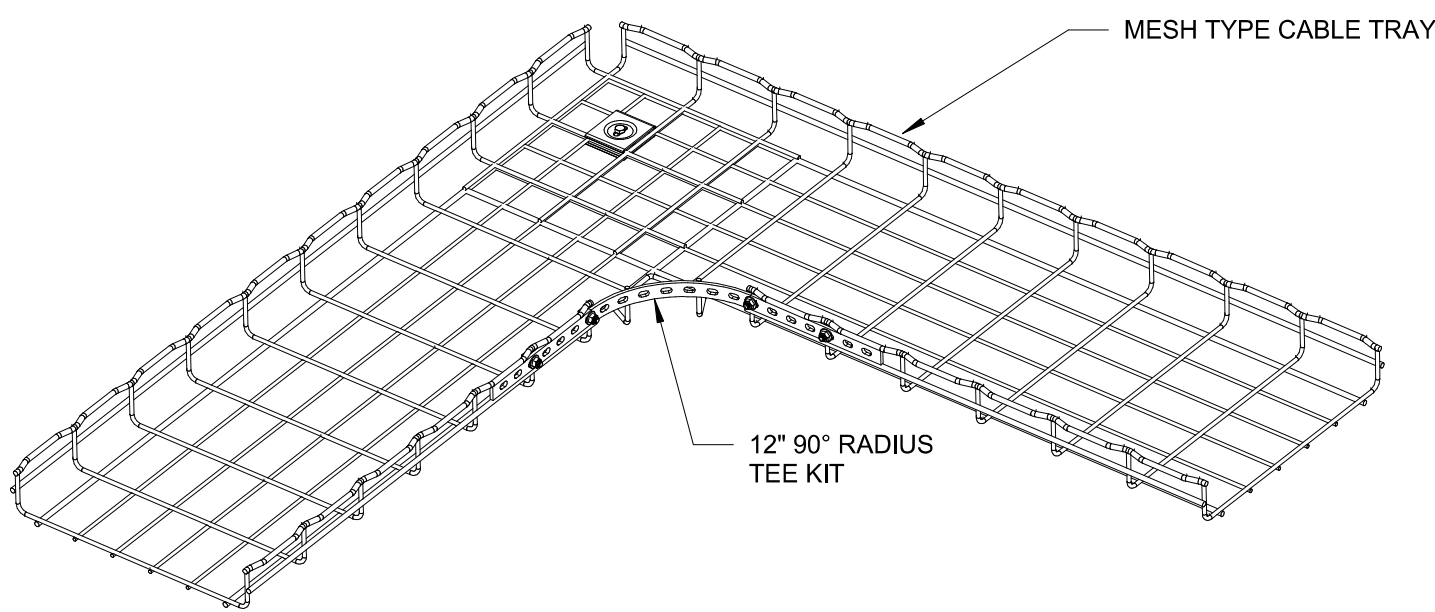

- NOTES:
- EMERGENCY LABELS SHALL BE RED WITH WHITE COR.
 - NORMAL SHALL BE BLACK WITH WHITE CORE.
 - PROVIDE LABELS FOR ALL MECHANICAL AND PLUMBING EQUIPMENT, AND ALL RELATED DISCONNECTING MEANS AND CONTROLLERS REQUIRING POWER.

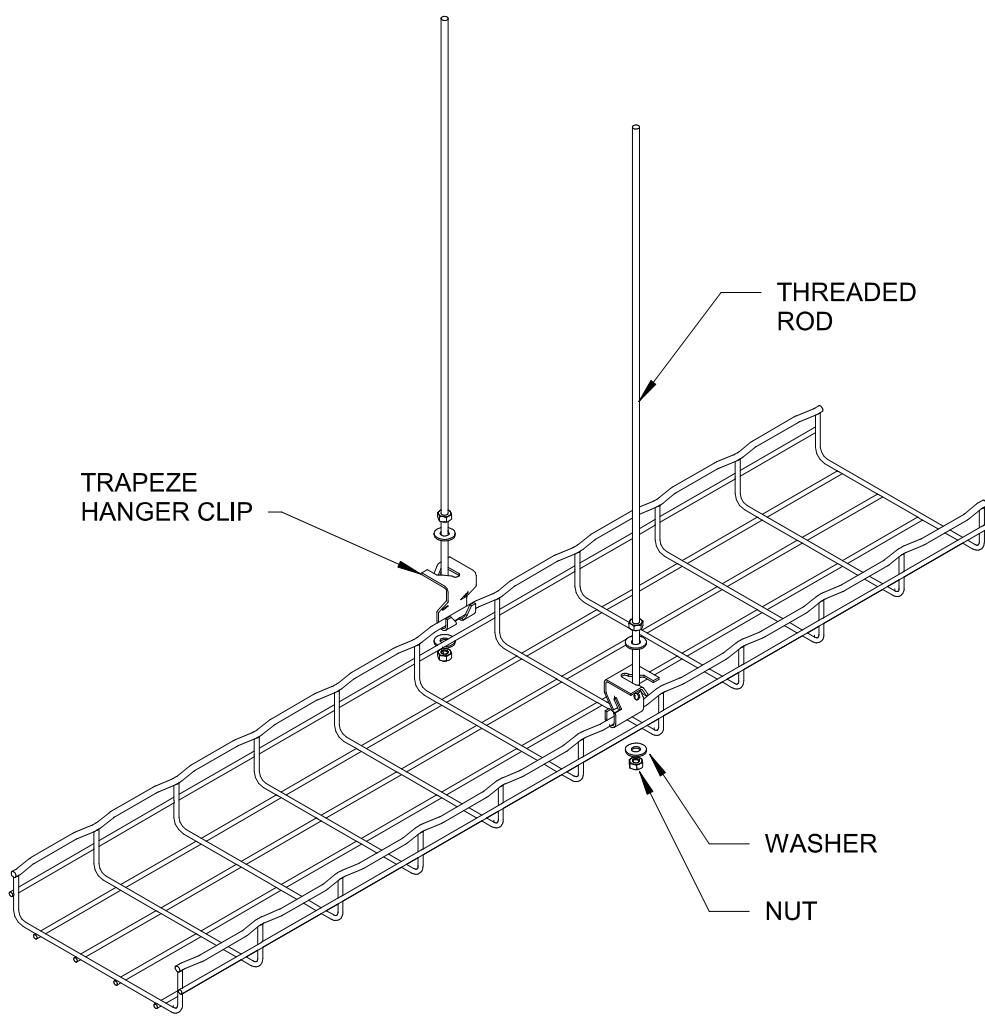

- NOTES:
- DISCONTINUOUS JOINTS (WHERE CABLE TRAYS ARE NOT CONTINUOUS) REQUIRE BONDING.
 - BONDING JUMPERS FOR GROUNDING NOT SHOWN.

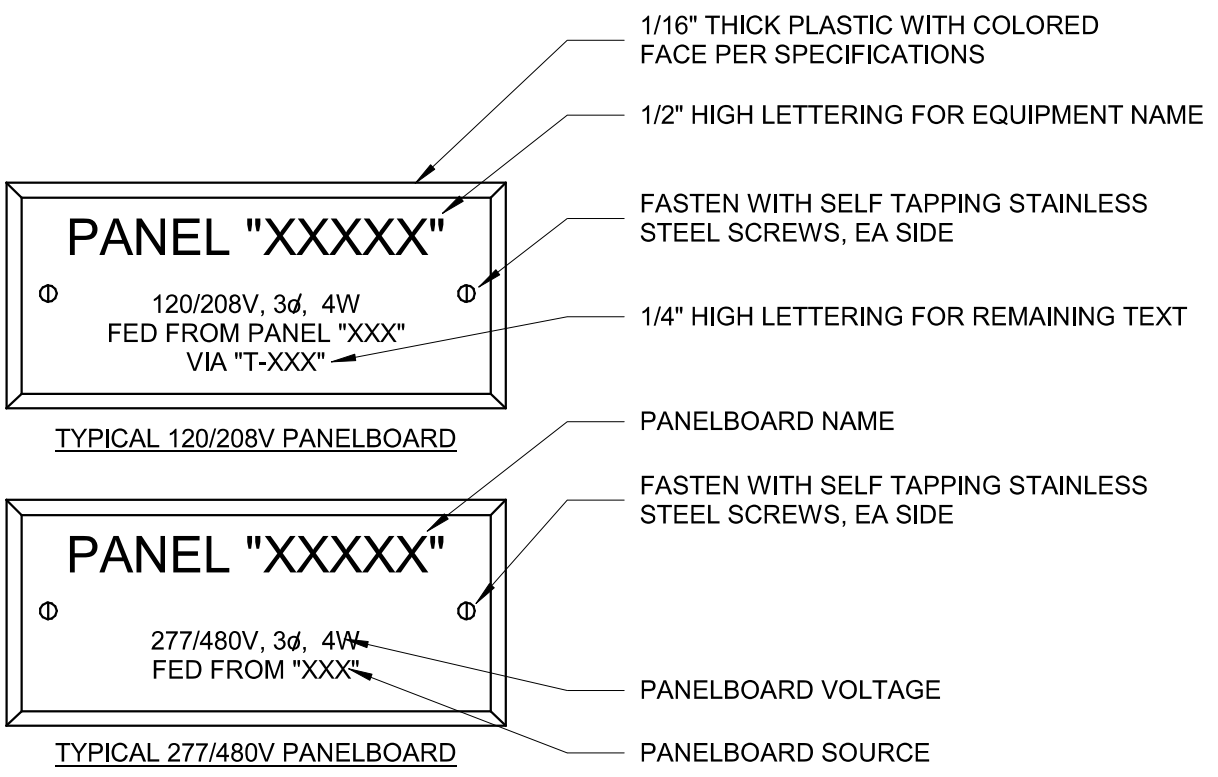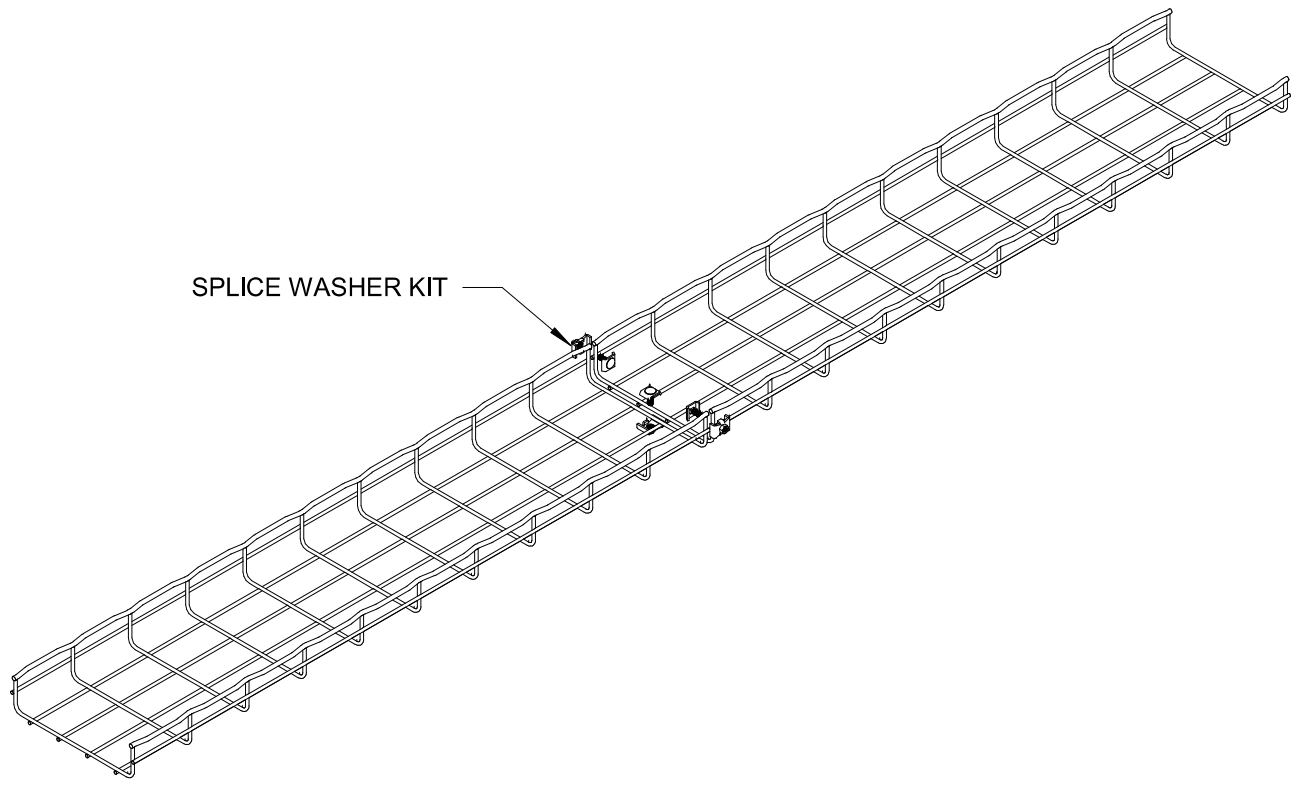

NOTE: EMERGENCY POWER LABELS SHALL RED WITH WHITE CORE. NORMAL POWER LABELS SHALL BE BLACK WITH WHITE CORE.


Revisions:		
No.	Description	Date

CONSULTANTS:



8701 RED OAK BLVD, SUITE 500
CHARLOTTE, NC 28217
PHONE: 704.522.0405
WWW.BRITTPETERS.COM

Digital Signature not valid without
Certificate below seal.

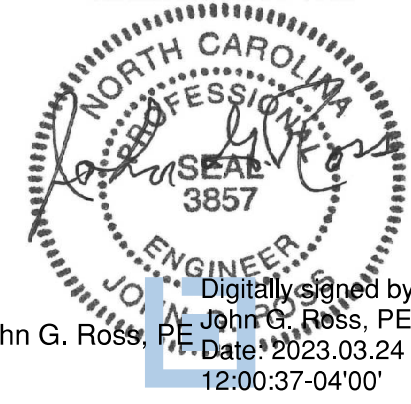

ARCHITECT / ENGINEERS:



8016 TOWER POINT DRIVE
CHARLOTTE, NC 28227
P 704.814.1320
F 704.321.0833

HG PROJECT: 18002
COPYRIGHT © 2021

Drawing Title:

ELECTRICAL DETAILS

Project Phase:

BID DOCUMENTS

FULLY SPRINKLERED

Project Title:

RENOVATE MED SURGE
WARDS

Location:

VETERANS HEALTHCARE SYSTEM
OF THE OZARKS

Date:

MARCH 24, 2024

Checked:

LEH

Drawn:

CSR

Project Number:

564-17-140

Building Number:

1

Drawing Number:

EE503

Sheet 158 of 162

Engineering
Service



VA

U.S. Department
of Veterans Affairs