


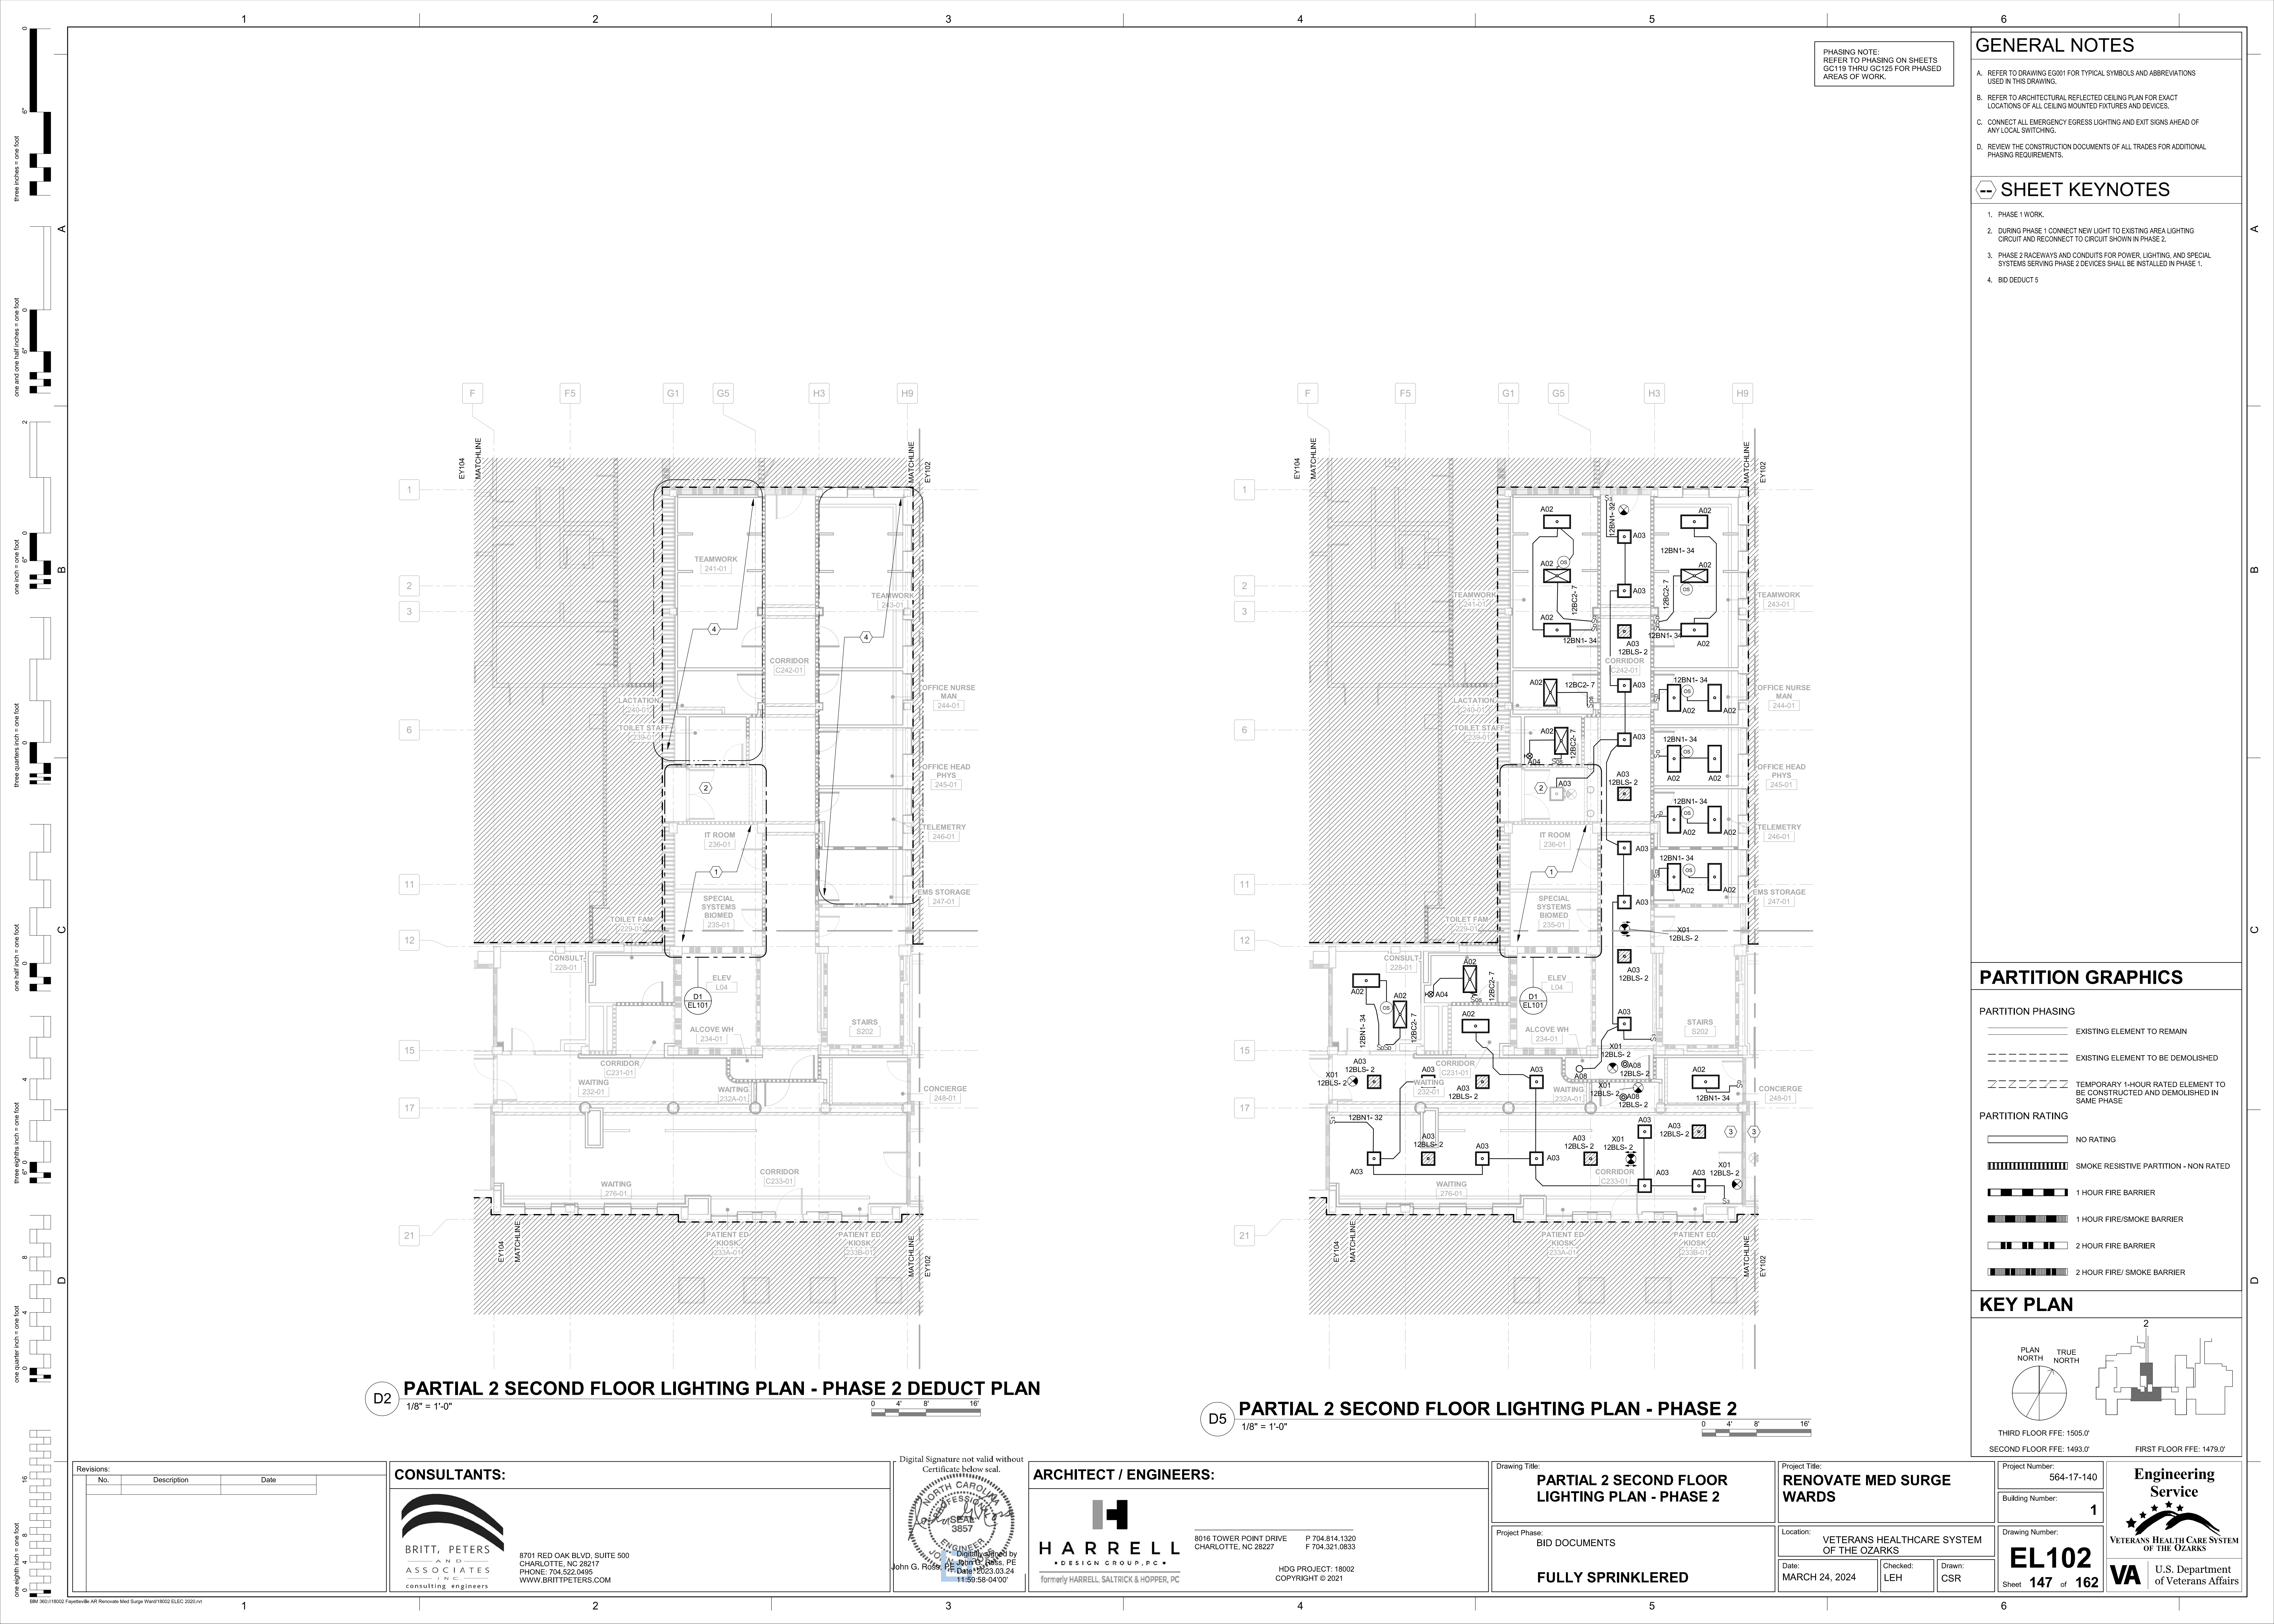

PHASING NOTE:
REFER TO PHASING ON SHEETS
GC119 THRU GC125 FOR PHASED
AREAS OF WORK.

GENERAL NOTES

- A. REFER TO DRAWING EG001 FOR TYPICAL SYMBOLS AND ABBREVIATIONS USED IN THIS DRAWING.
- B. REFER TO ARCHITECTURAL REFLECTED CEILING PLAN FOR EXACT LOCATIONS OF ALL CEILING MOUNTED FIXTURES AND DEVICES.
- C. CONNECT ALL EMERGENCY EGRESS LIGHTING AND EXIT SIGNS AHEAD OF ANY LOCAL SWITCHING.
- D. REVIEW THE CONSTRUCTION DOCUMENTS OF ALL TRADES FOR ADDITIONAL PHASING REQUIREMENTS.


SHEET KEYNOTES

1. PHASE 1 WORK.
2. DURING PHASE 1 CONNECT NEW LIGHT TO EXISTING AREA LIGHTING CIRCUIT AND RECONNECT TO CIRCUIT SHOWN IN PHASE 2.
3. PHASE 2 RACEWAYS AND CONDUITS FOR POWER, LIGHTING, AND SPECIAL SYSTEMS SERVING PHASE 2 DEVICES SHALL BE INSTALLED IN PHASE 1.
4. BID DEDUCT 5

PARTITION GRAPHICS

- PARTITION PHASING
- EXISTING ELEMENT TO REMAIN
- EXISTING ELEMENT TO BE DEMOLISHED
- TEMPORARY 1-HOUR RATED ELEMENT TO BE CONSTRUCTED AND DEMOLISHED IN SAME PHASE
- PARTITION RATING
- NO RATING
- SMOKE RESISTIVE PARTITION - NON RATED
- 1 HOUR FIRE BARRIER
- 1 HOUR FIRE/SMOKE BARRIER
- 2 HOUR FIRE BARRIER
- 2 HOUR FIRE/ SMOKE BARRIER

KEY PLAN

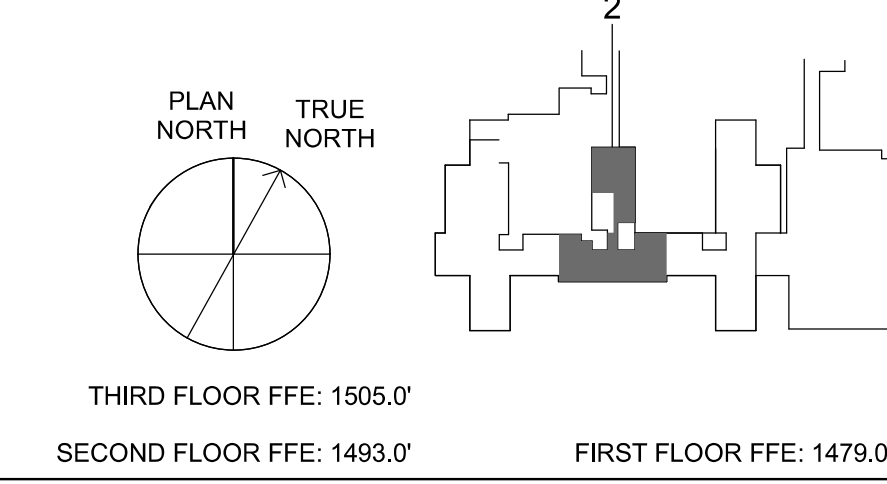

D2 PARTIAL 2 SECOND FLOOR LIGHTING PLAN - PHASE 2 DEDUCT PLAN
1/8" = 1'-0"

D5 PARTIAL 2 SECOND FLOOR LIGHTING PLAN - PHASE 2
1/8" = 1'-0"

Revisions:		
No.	Description	Date


CONSULTANTS:



BRITT, PETERS
AND
ASSOCIATES
INC.
consulting engineers

8701 RED OAK BLVD, SUITE 500
CHARLOTTE, NC 28217
PHONE: 704.522.0405
WWW.BRITTPETERS.COM

Digital Signature not valid without
Certificate below seal.

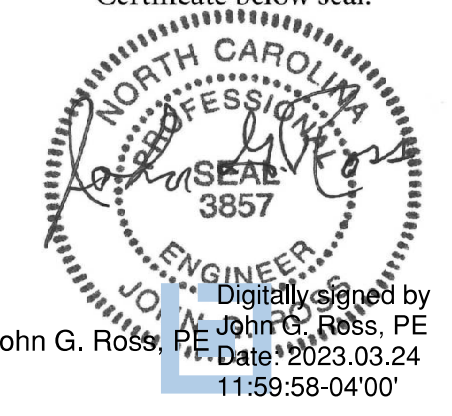

John G. Ross, PE
No. 3857
11-59-58-0400

ARCHITECT / ENGINEERS:



HARRELL
DESIGN GROUP, P.C.
formerly HARRELL, SALTRICK & HOPPER, PC

8016 TOWER POINT DRIVE
CHARLOTTE, NC 28227
P 704.814.1320
F 704.321.0833
HDP PROJECT: 18002
COPYRIGHT © 2021

Drawing Title:
PARTIAL 2 SECOND FLOOR
LIGHTING PLAN - PHASE 2

Project Phase:
BID DOCUMENTS

FULLY SPRINKLERED

Project Title:
RENOVATE MED SURGE
WARDS

Location:
VETERANS HEALTHCARE SYSTEM
OF THE OZARKS

Date:
MARCH 24, 2024

Checked:
LEH

Drawn:
CSR

Project Number:
564-17-140

Building Number:
1

Drawing Number:
EL102

Sheet 147 of 162

Engineering
Service



VETERANS HEALTH CARE SYSTEM
OF THE OZARKS
VA U.S. Department
of Veterans Affairs