



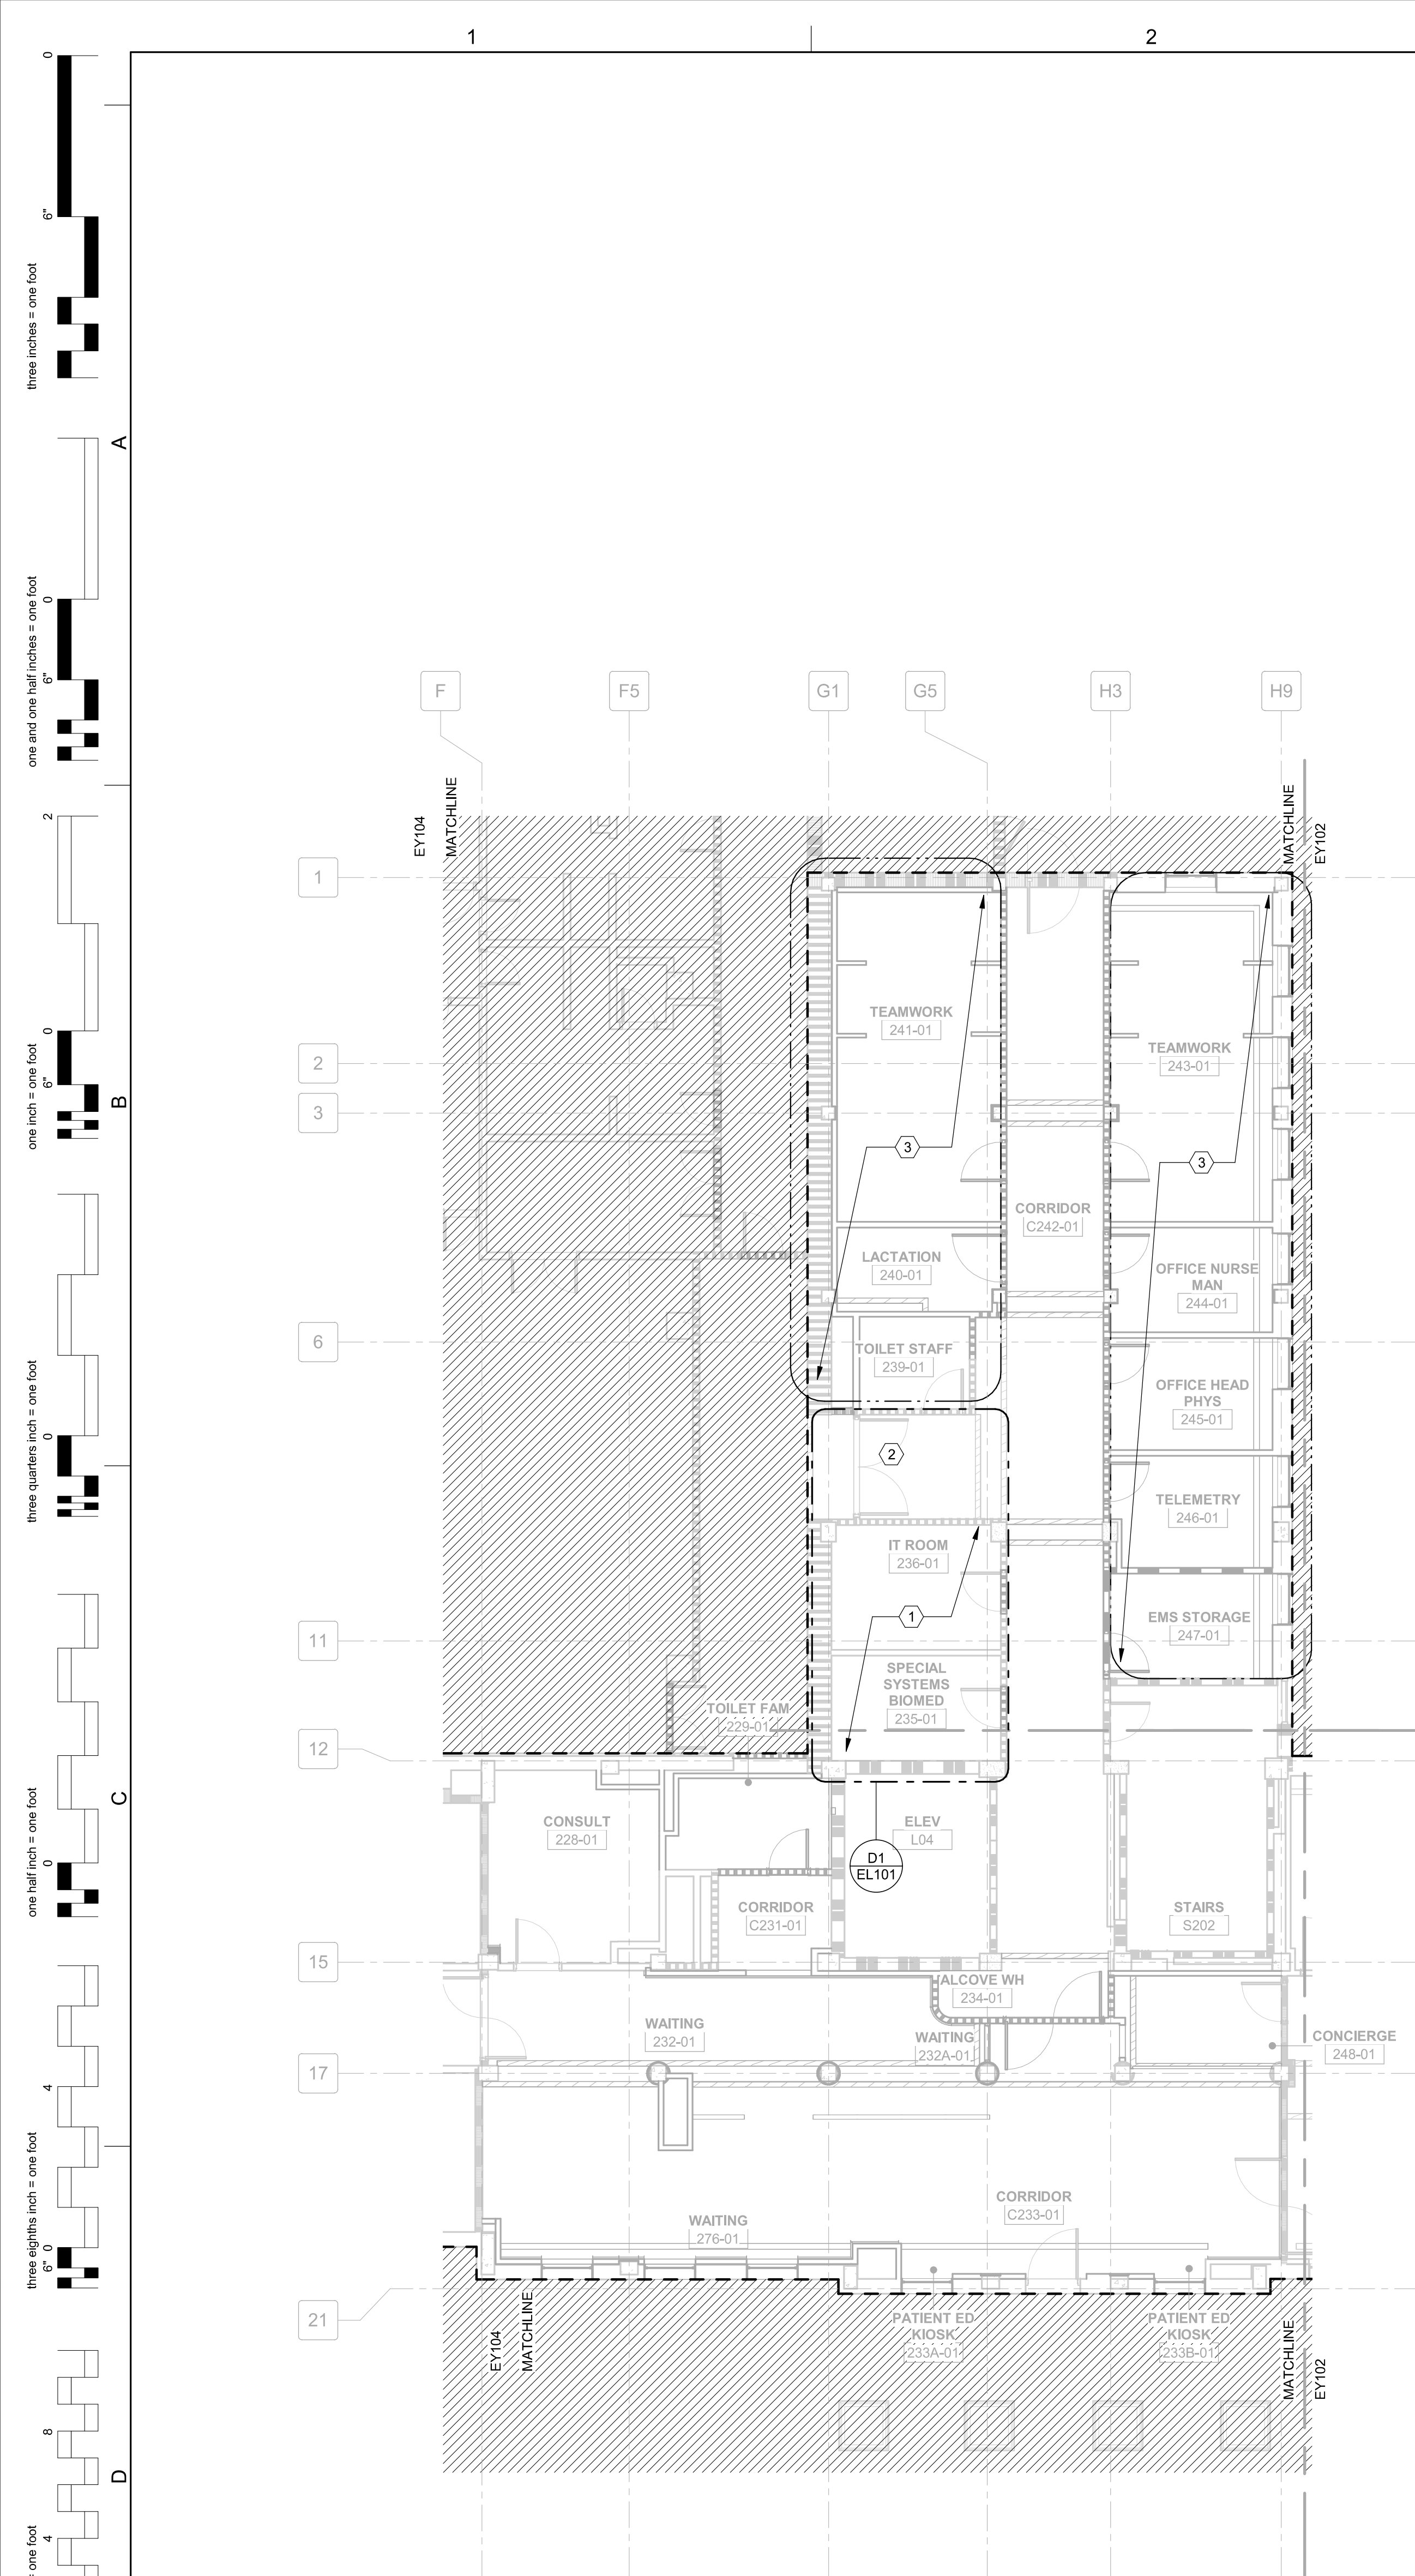

D2 PARTIAL 2 SECOND FLOOR POWER PLAN - PHASE 2 DEDUCT PLAN
1/8" = 1'-0"

D4 PARTIAL 2 SECOND FLOOR POWER PLAN - PHASE 2
1/8" = 1'-0"

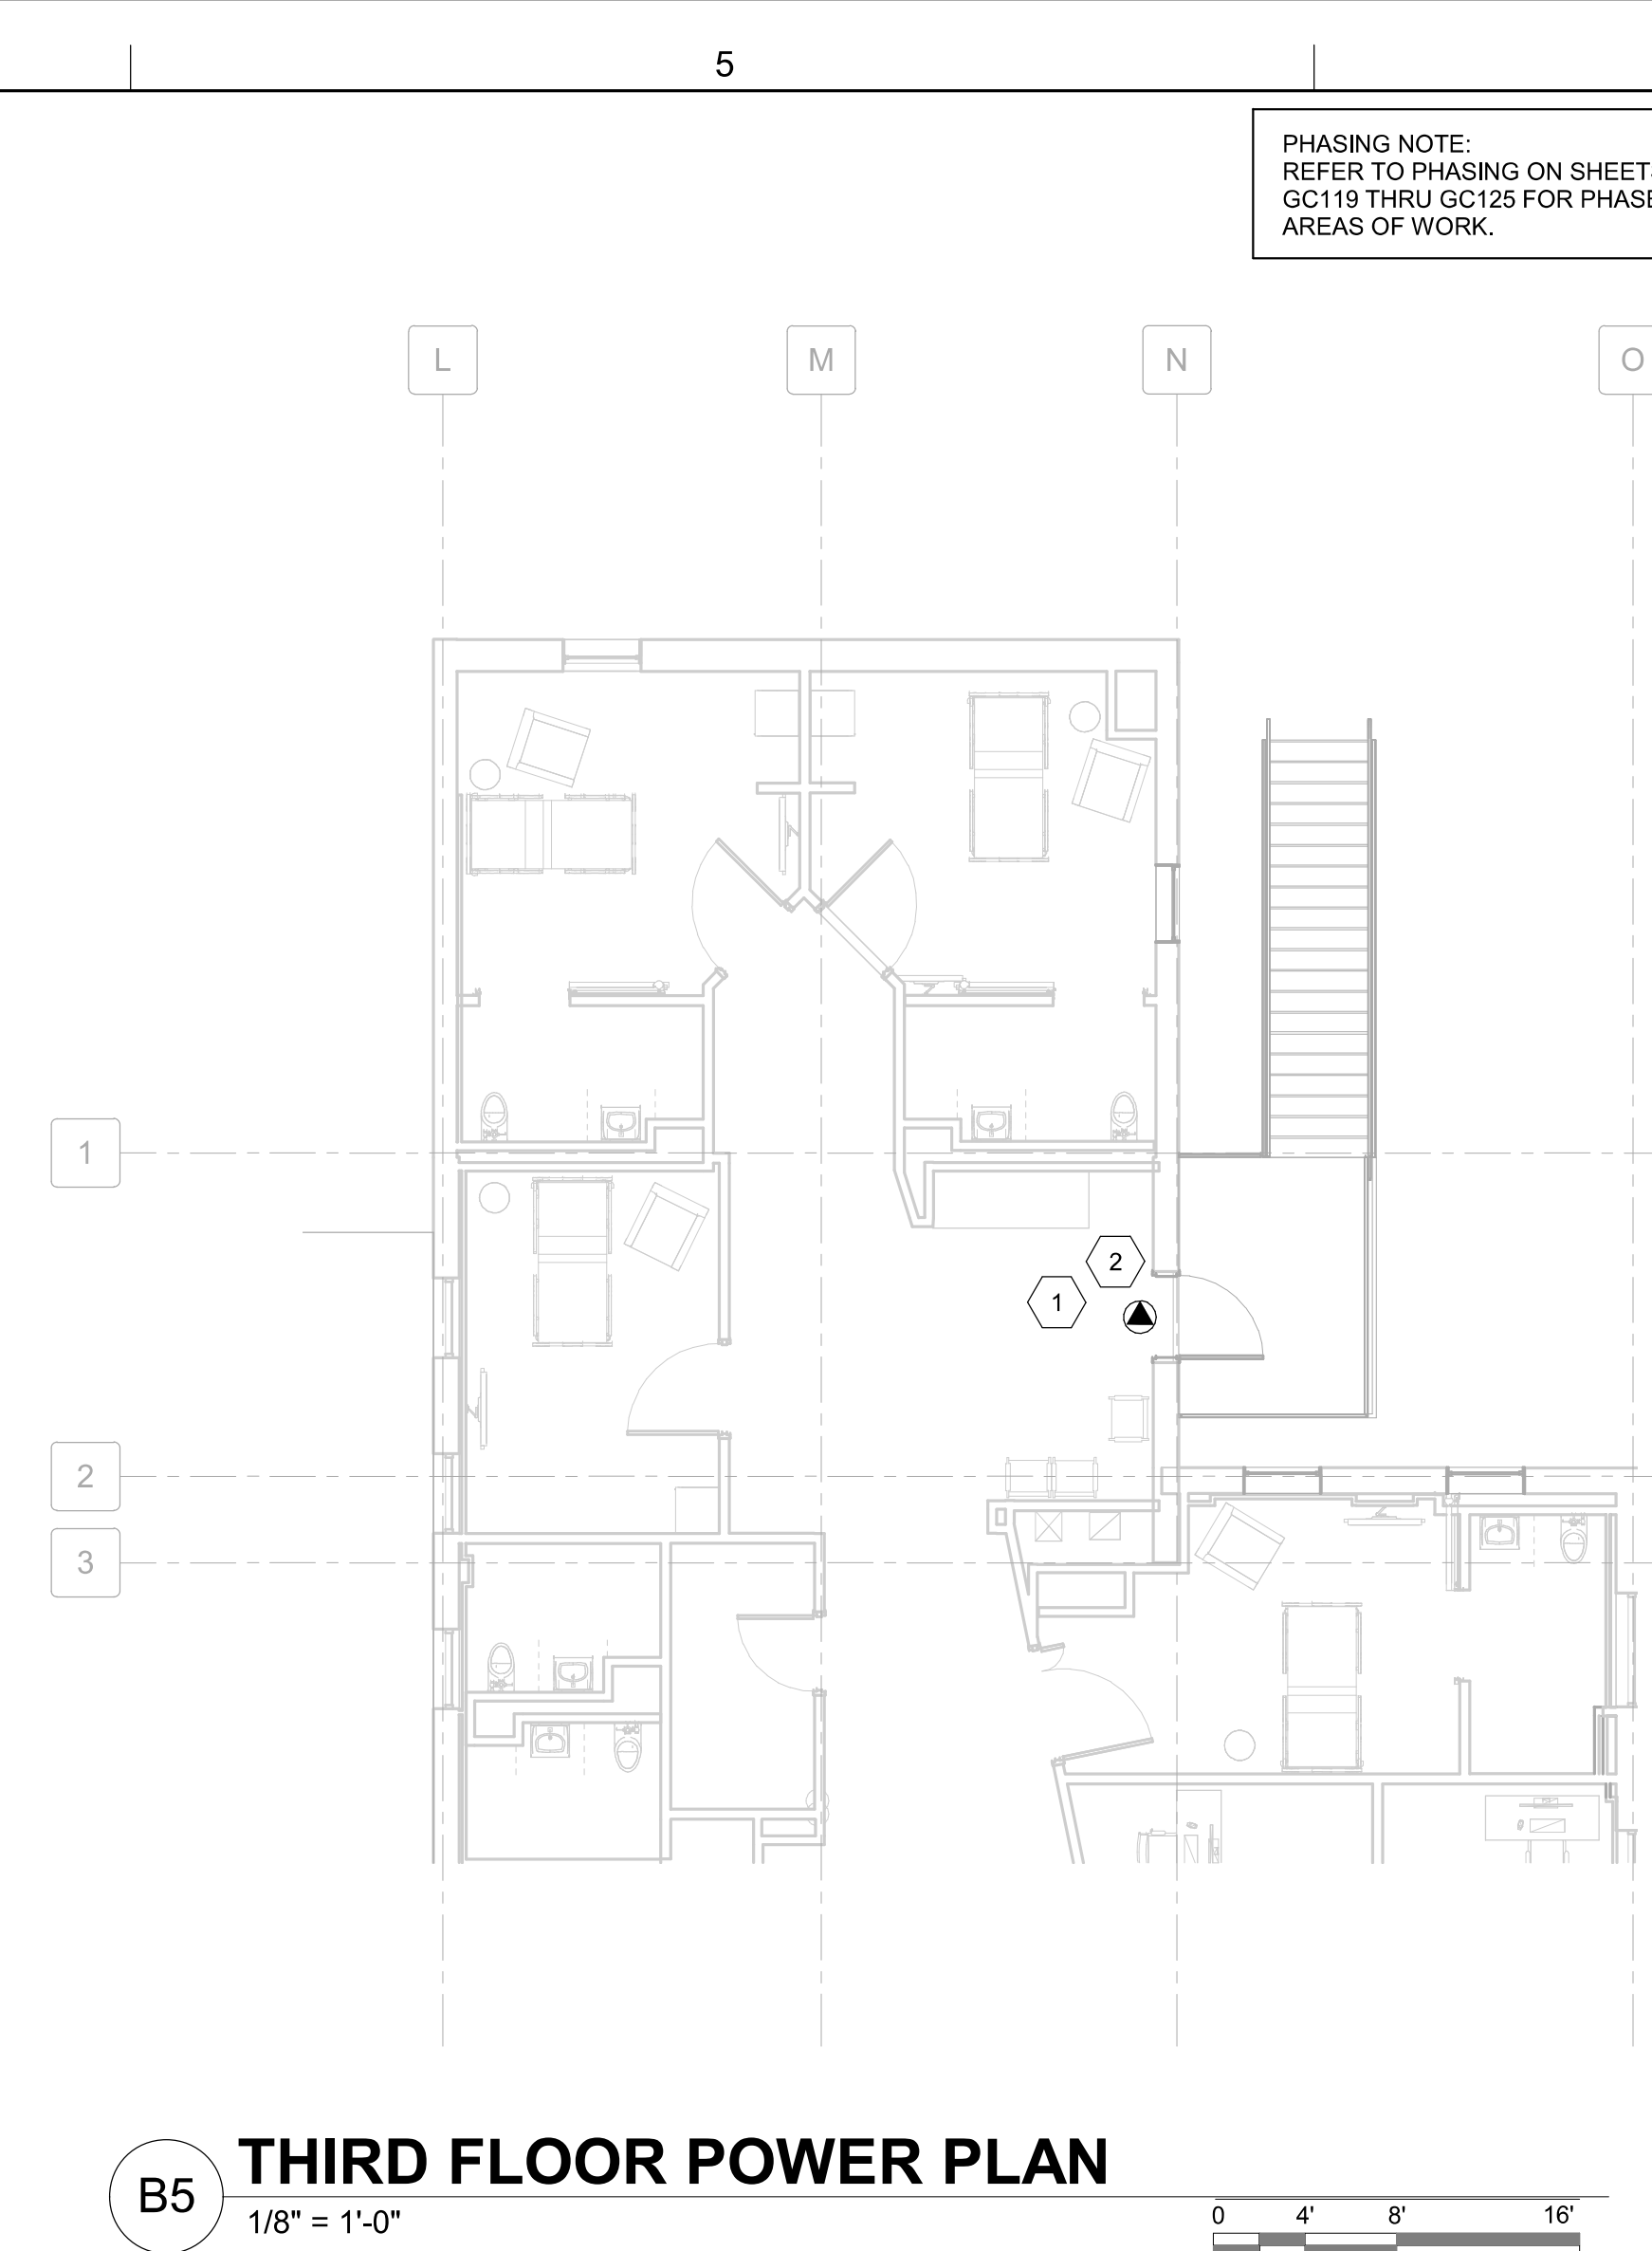

B5 THIRD FLOOR POWER PLAN
1/8" = 1'-0"

GENERAL NOTES

- REFER TO DRAWING EG001 FOR TYPICAL SYMBOLS AND ABBREVIATIONS USED IN THIS DRAWING.
- CONFIRM RECEPTACLE LOCATIONS AND MOUNTING HEIGHTS WITH ARCHITECTURAL INTERIOR ELEVATIONS PRIOR TO ROUGH-IN.
- ALL RECEPTACLES WITHIN 6'-0" OF SINK SHALL BE OF THE GFCI TYPE.
- ALL RECEPTACLES IN PATIENT CARE AREAS SHALL BE HOSPITAL GRADE.
- REVIEW THE CONSTRUCTION DOCUMENTS OF ALL TRADES FOR PHASING REQUIREMENTS.
- REFER TO POWER RISER DIAGRAMS ON SHEETS EP001 AND EP002 FOR EXISTING AND NEW RISERS AND DETAILS OF EXISTING AND NEW FEEDER CONNECTIONS TO PLAN NEW FEEDER AND REROUTING FEEDER WORK.
- REFER TO PHASING ON SHEETS GC122 THRU GC125 FOR PHASED AREAS OF WORK.

SHEET KEYNOTES

- PHASE 1 WORK.
- PROVIDE POWER FOR NEW DOOR LOCK. CONNECT TO CLOSEST CRITICAL BRANCH CIRCUIT.
- CONTRACTOR SHALL REFER TO TRACING AND IDENTIFYING EXISTING FEEDERS AND BRANCH CIRCUIT VERIFIED DURING DEMOLITION WORK. PHASE 1, DEDUCT 5 ALTERNATE WORK SHALL INCLUDE EXISTING AREAS SHOWN ARE THE FLOOR PLAN FOR EXISTING POWER TO REMAIN AND BE RECIRCUITED TO THE EXISTING PANELS VERIFIED BY THE LOAD ANALYSIS REPORT AND NEW PANEL LOCATIONS SHOWN ON THE NEW POWER PLAN.

PARTITION GRAPHICS


PARTITION PHASING

- EXISTING ELEMENT TO REMAIN
- EXISTING ELEMENT TO BE DEMOLISHED
- TEMPORARY 1-HOUR RATED ELEMENT TO BE CONSTRUCTED AND DEMOLISHED IN SAME PHASE

PARTITION RATING

- NO RATING
- SMOKE RESISTIVE PARTITION - NON RATED
- 1 HOUR FIRE BARRIER
- 1 HOUR FIRE/SMOKE BARRIER
- 2 HOUR FIRE BARRIER
- 2 HOUR FIRE/ SMOKE BARRIER

KEY PLAN

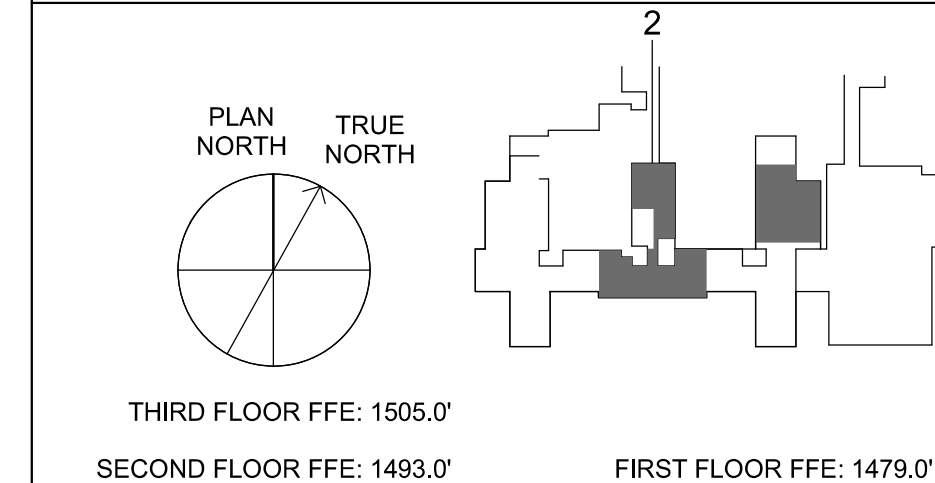


Revisions:		
No.	Description	Date

CONSULTANTS:



8701 RED OAK BLVD, SUITE 500
CHARLOTTE, NC 28217
PHONE: 704.522.0405
WWW.BRITTPETERS.COM

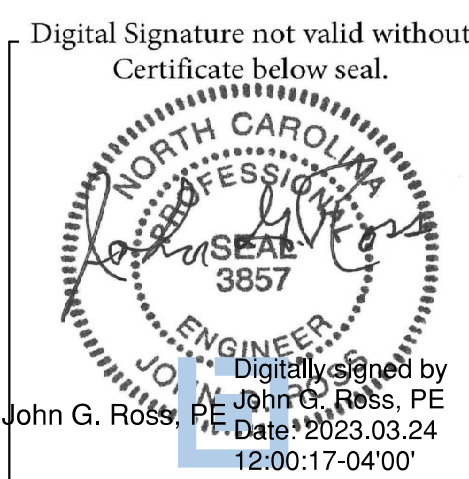

ARCHITECT / ENGINEERS:



8016 TOWER POINT DRIVE
CHARLOTTE, NC 28227
P 704.814.1320
F 704.321.0833
HDG PROJECT: 18002
COPYRIGHT © 2021

Drawing Title:

PARTIAL 2 SECOND FLOOR
POWER PLAN - PHASE 2

Project Phase:

BID DOCUMENTS

FULLY SPRINKLERED

Project Title:

RENOVATE MED SURGE
WARDS

Location:

VETERANS HEALTHCARE SYSTEM
OF THE OZARKS

Date:

MARCH 24, 2024

Checked:

LEH

Drawn:

CSR

Project Number:

564-17-140

Building Number:

1

Drawing Number:

EP104

Sheet 152 of 162

