


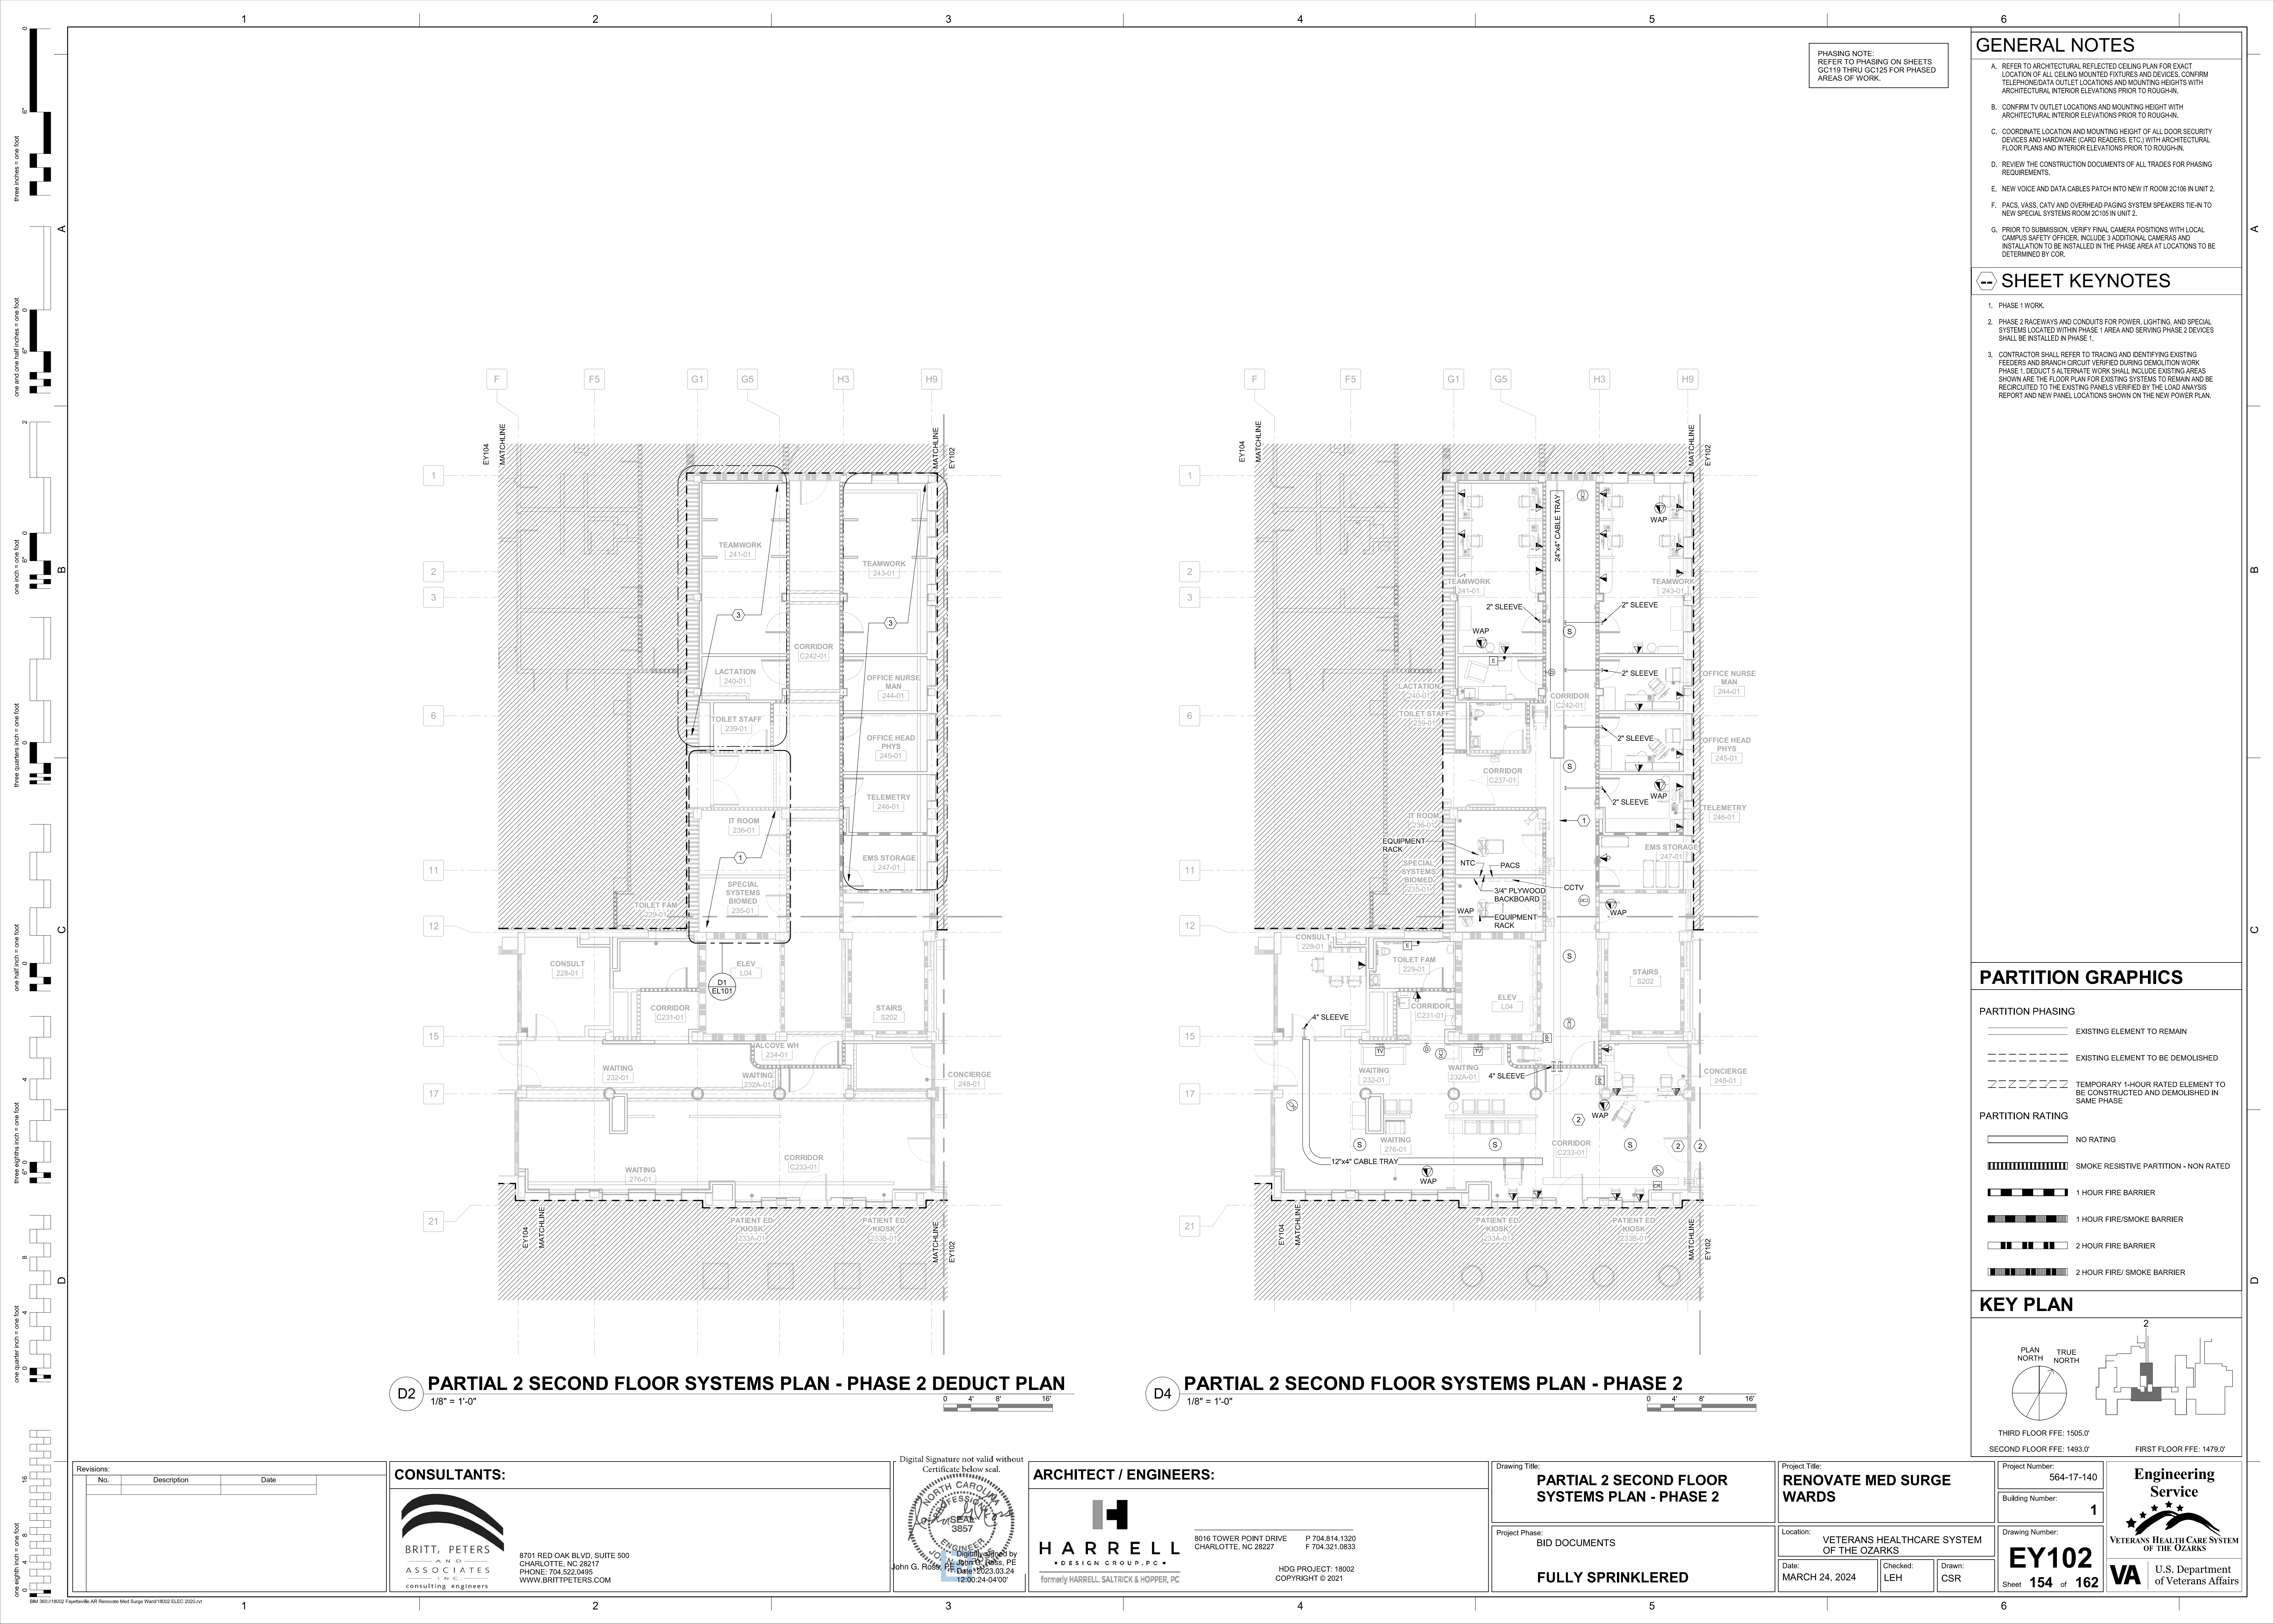

PHASING NOTE:  
REFER TO PHASING ON SHEETS  
GC119 THRU GC125 FOR PHASED  
AREAS OF WORK.

## GENERAL NOTES

- REFER TO ARCHITECTURAL REFLECTED CEILING PLAN FOR EXACT LOCATION OF ALL CEILING MOUNTED FIXTURES AND DEVICES. CONFIRM TELEPHONE DATA OUTLET LOCATIONS AND MOUNTING HEIGHTS WITH ARCHITECTURAL INTERIOR ELEVATIONS PRIOR TO ROUGH-IN.
- CONFIRM TV OUTLET LOCATIONS AND MOUNTING HEIGHT WITH ARCHITECTURAL INTERIOR ELEVATIONS PRIOR TO ROUGH-IN.
- COORDINATE LOCATION AND MOUNTING HEIGHT OF ALL DOOR SECURITY DEVICES AND HARDWARE (CARD READERS, ETC.) WITH ARCHITECTURAL FLOOR PLANS AND INTERIOR ELEVATIONS PRIOR TO ROUGH-IN.
- REVIEW THE CONSTRUCTION DOCUMENTS OF ALL TRADES FOR PHASING REQUIREMENTS.
- NEW VOICE AND DATA CABLES PATCH INTO NEW IT ROOM 2C106 IN UNIT 2.
- PACS, VASS, CATV AND OVERHEAD PAGING SYSTEM SPEAKERS TIE-IN TO NEW SPECIAL SYSTEMS ROOM 2C105 IN UNIT 2.
- PRIOR TO SUBMISSION, VERIFY FINAL CAMERA POSITIONS WITH LOCAL CAMPUS SAFETY OFFICER. INCLUDE 3 ADDITIONAL CAMERAS AND INSTALLATION TO BE INSTALLED IN THE PHASE AREA AT LOCATIONS TO BE DETERMINED BY COR.

## SHEET KEYNOTES

- PHASE 1 WORK.
- PHASE 2 RACEWAYS AND CONDUITS FOR POWER, LIGHTING, AND SPECIAL SYSTEMS LOCATED WITHIN PHASE 1 AREA AND SERVING PHASE 2 DEVICES SHALL BE INSTALLED IN PHASE 1.
- CONTRACTOR SHALL REFER TO TRACING AND IDENTIFYING EXISTING FEEDERS AND BRANCH CIRCUIT VERIFIED DURING DEMOLITION WORK PHASE 1. DEDUCT 5 ALTERNATE WORK SHALL INCLUDE EXISTING AREAS SHOWN ARE THE FLOOR PLAN FOR EXISTING SYSTEMS TO REMAIN AND BE REROUTED TO THE EXISTING PANELS VERIFIED BY THE LOAD ANALYSIS REPORT AND NEW PANEL LOCATIONS SHOWN ON THE NEW POWER PLAN.

## PARTITION GRAPHICS


### PARTITION PHASING

- EXISTING ELEMENT TO REMAIN
- EXISTING ELEMENT TO BE DEMOLISHED
- TEMPORARY 1-HOUR RATED ELEMENT TO BE CONSTRUCTED AND DEMOLISHED IN SAME PHASE

### PARTITION RATING

- NO RATING
- SMOKE RESISTIVE PARTITION - NON RATED
- 1 HOUR FIRE BARRIER
- 1 HOUR FIRE/SMOKE BARRIER
- 2 HOUR FIRE BARRIER
- 2 HOUR FIRE/ SMOKE BARRIER

## KEY PLAN

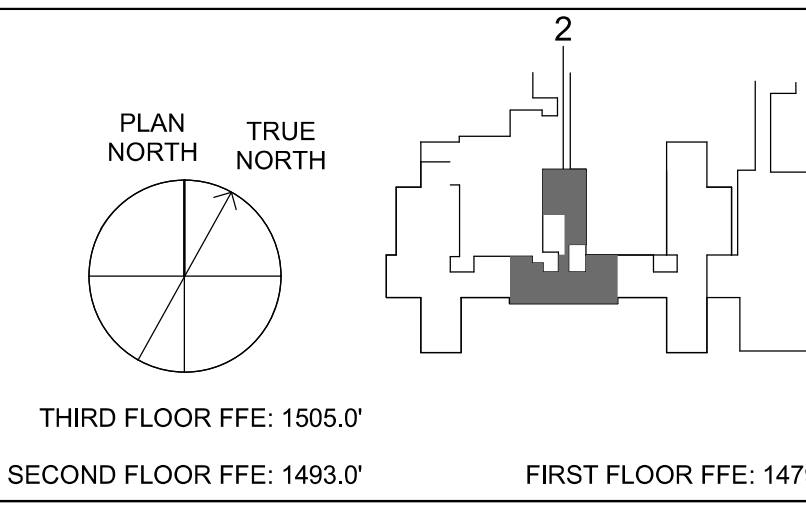


**D2 PARTIAL 2 SECOND FLOOR SYSTEMS PLAN - PHASE 2 DEDUCT PLAN**  
1/8" = 1'-0"

**D4 PARTIAL 2 SECOND FLOOR SYSTEMS PLAN - PHASE 2**  
1/8" = 1'-0"


| Revisions: |             |      |
|------------|-------------|------|
| No.        | Description | Date |
|            |             |      |

### CONSULTANTS:

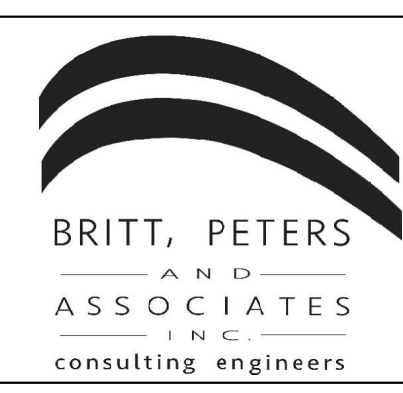

8701 RED OAK BLVD, SUITE 500  
CHARLOTTE, NC 28217  
PHONE: 704.522.0405  
WWW.BRITTPETERS.COM

Digital Signature not valid without  
Certificate below seal.

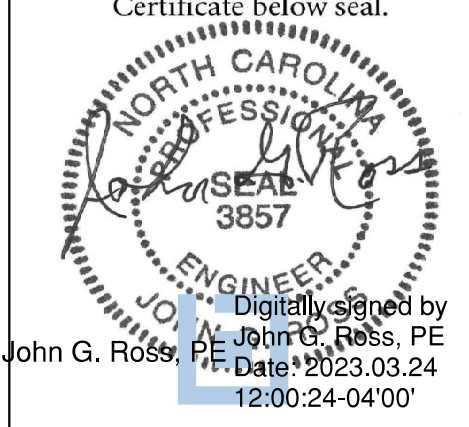

### ARCHITECT / ENGINEERS:



8016 TOWER POINT DRIVE  
CHARLOTTE, NC 28227  
P 704.814.1320  
F 704.321.0833  
HDX PROJECT: 18002  
COPYRIGHT © 2021

Drawing Title:

**PARTIAL 2 SECOND FLOOR  
SYSTEMS PLAN - PHASE 2**

Project Phase:

BID DOCUMENTS

**FULLY SPRINKLERED**

Project Title:

**RENOVATE MED SURGE  
WARDS**

Location:

VETERANS HEALTHCARE SYSTEM  
OF THE OZARKS

Date:

MARCH 24, 2024

Checked:

LEH

Drawn:

CSR

Project Number:

564-17-140

Building Number:

1

Drawing Number:

**EY102**

Sheet 154 of 162

**Engineering  
Service**



**VA** U.S. Department  
of Veterans Affairs